





**LEGEND**

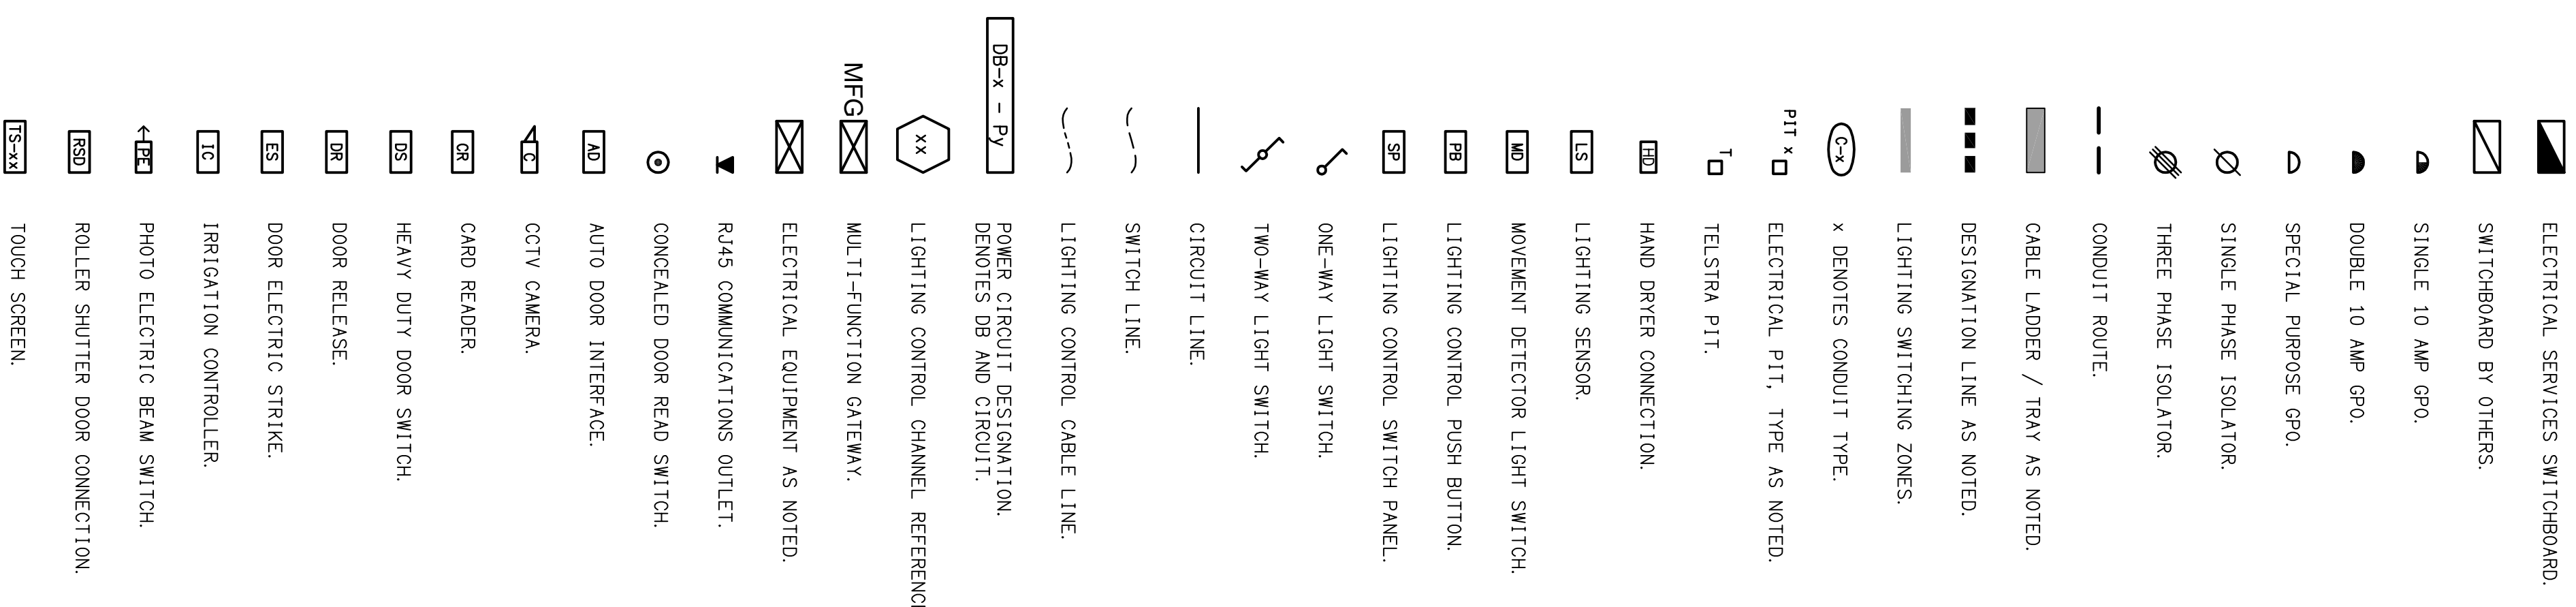

**LEGEND**

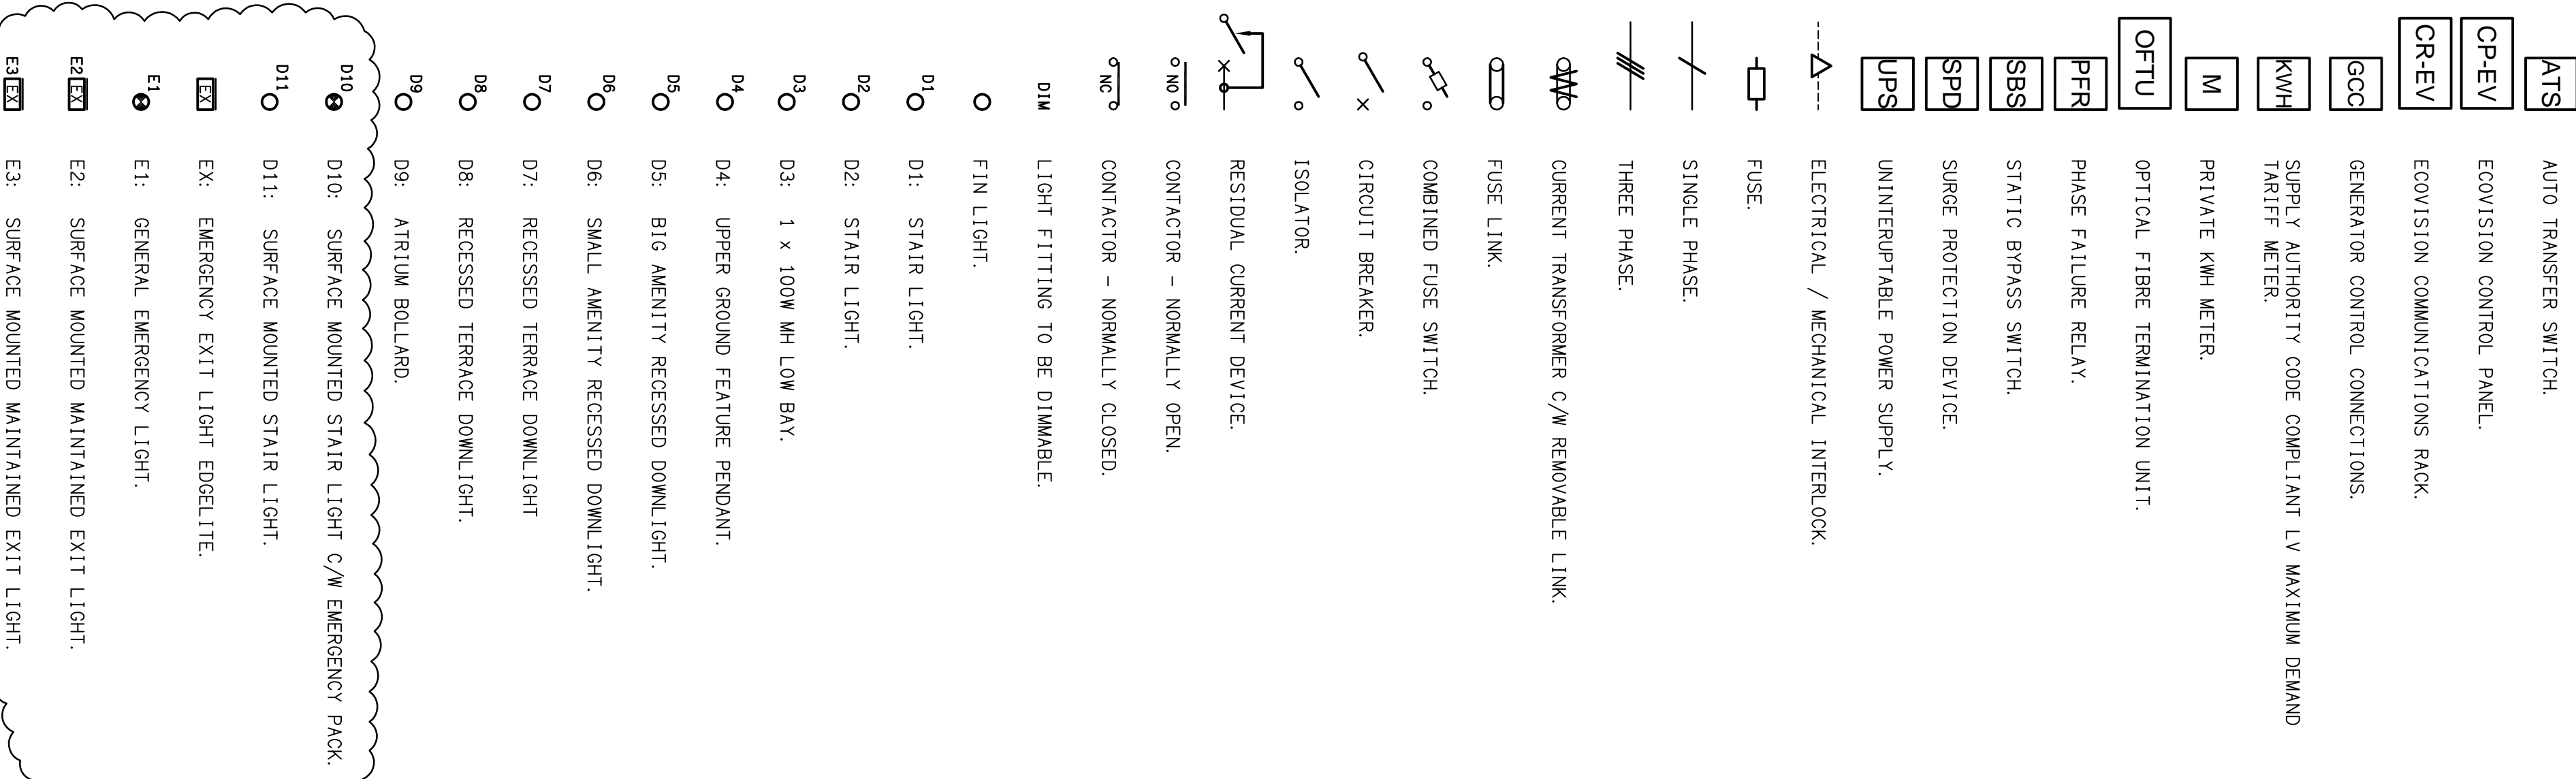


**LEGEND**

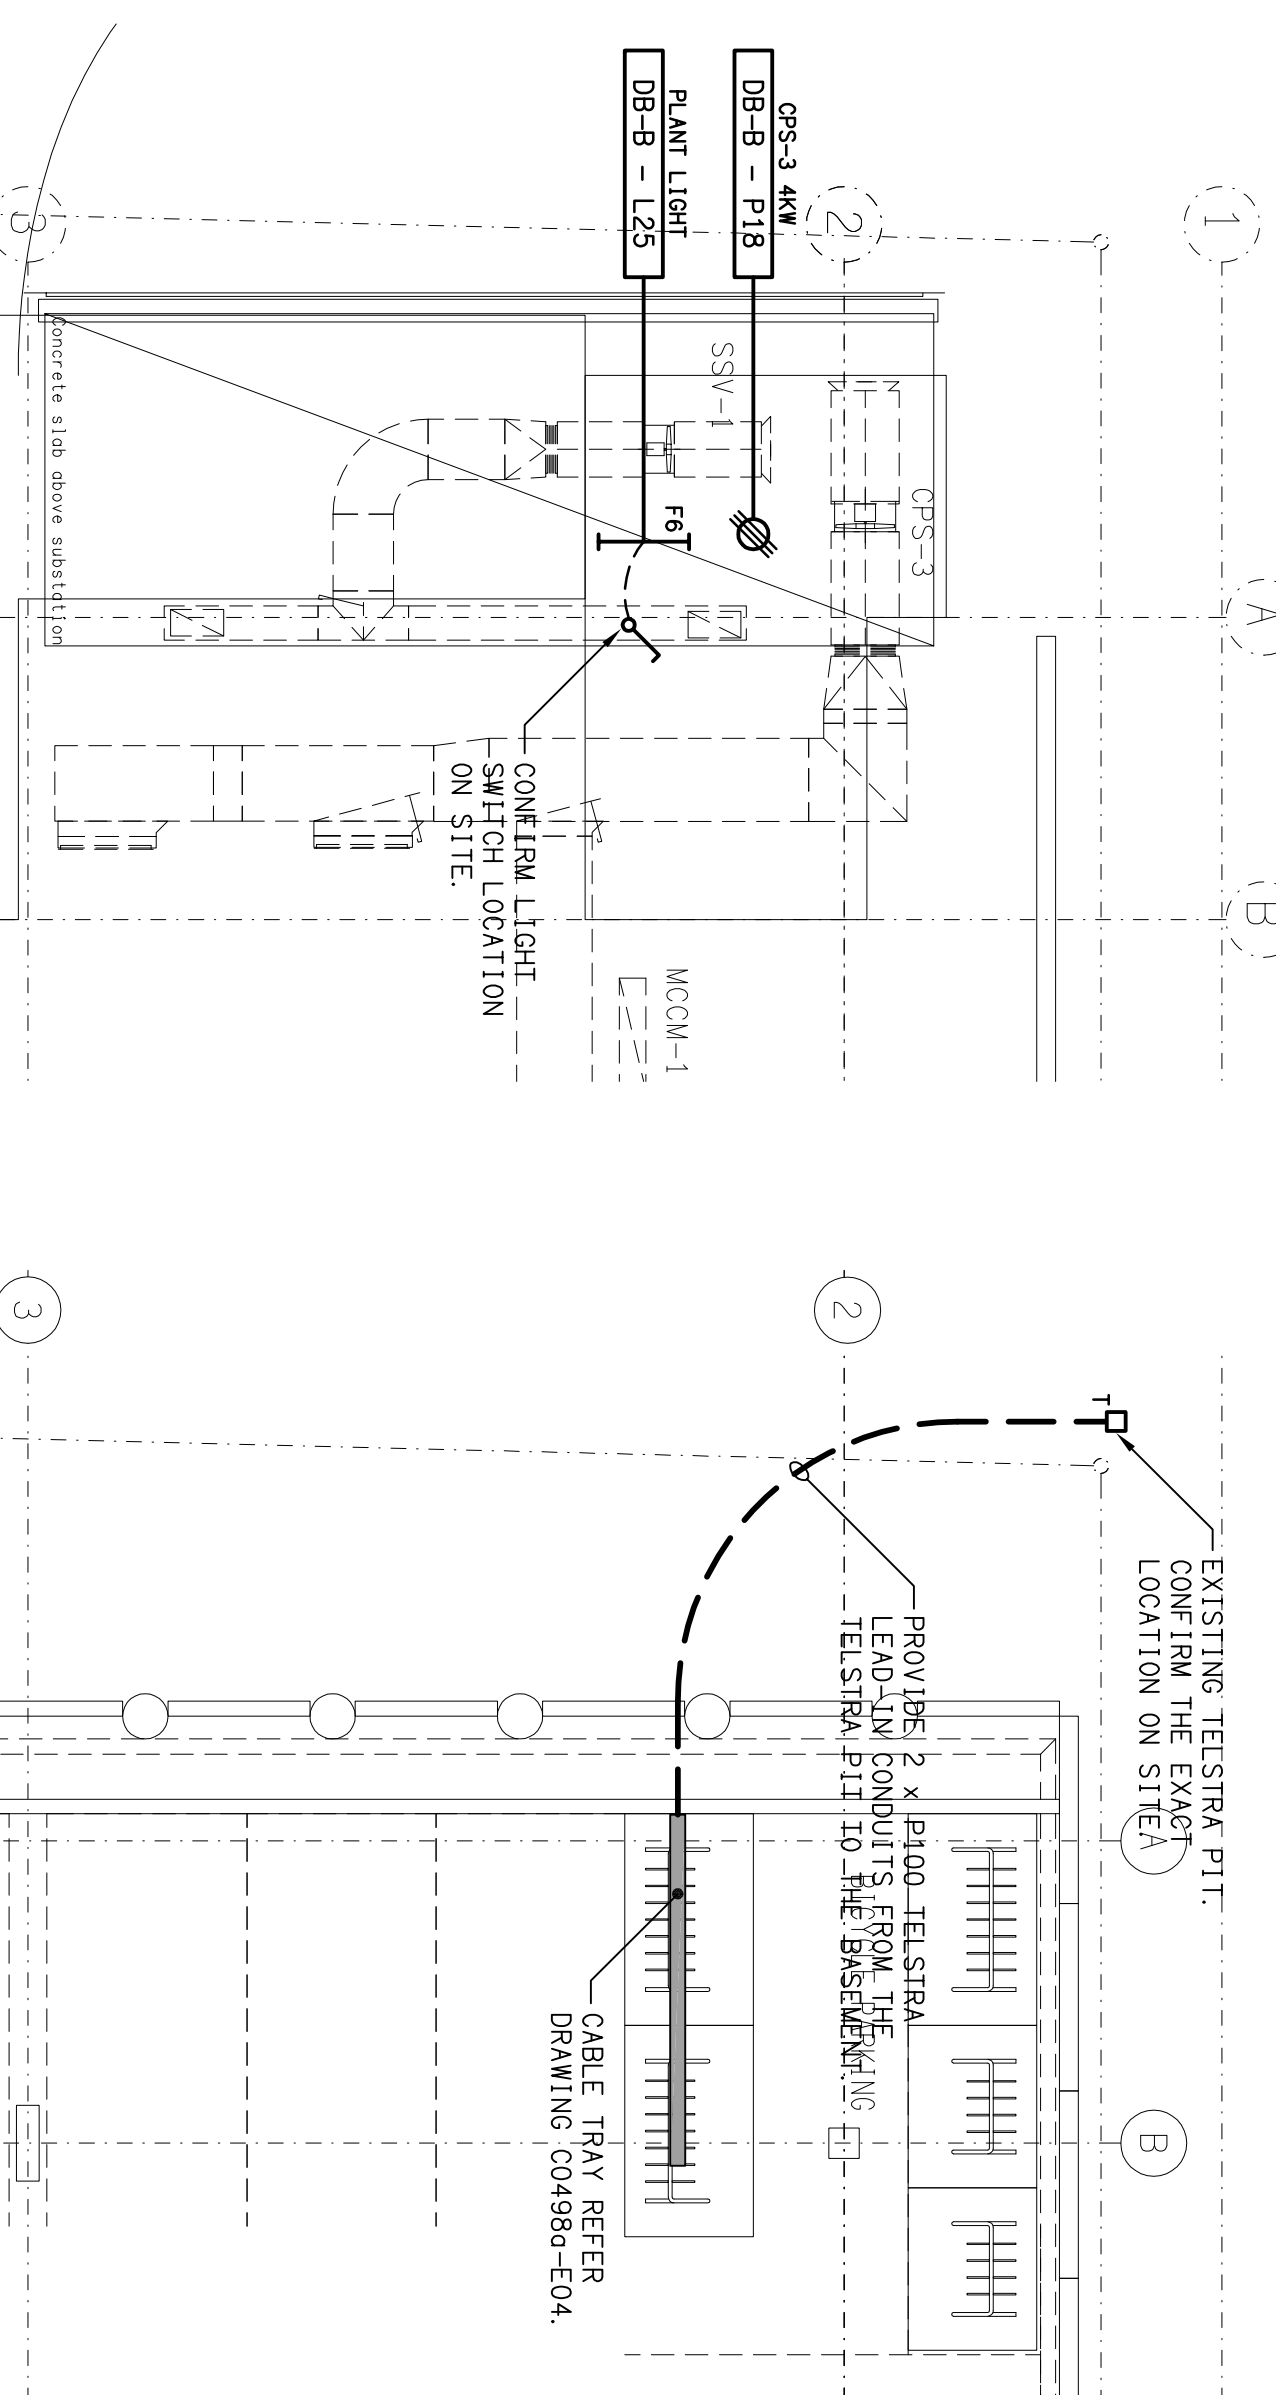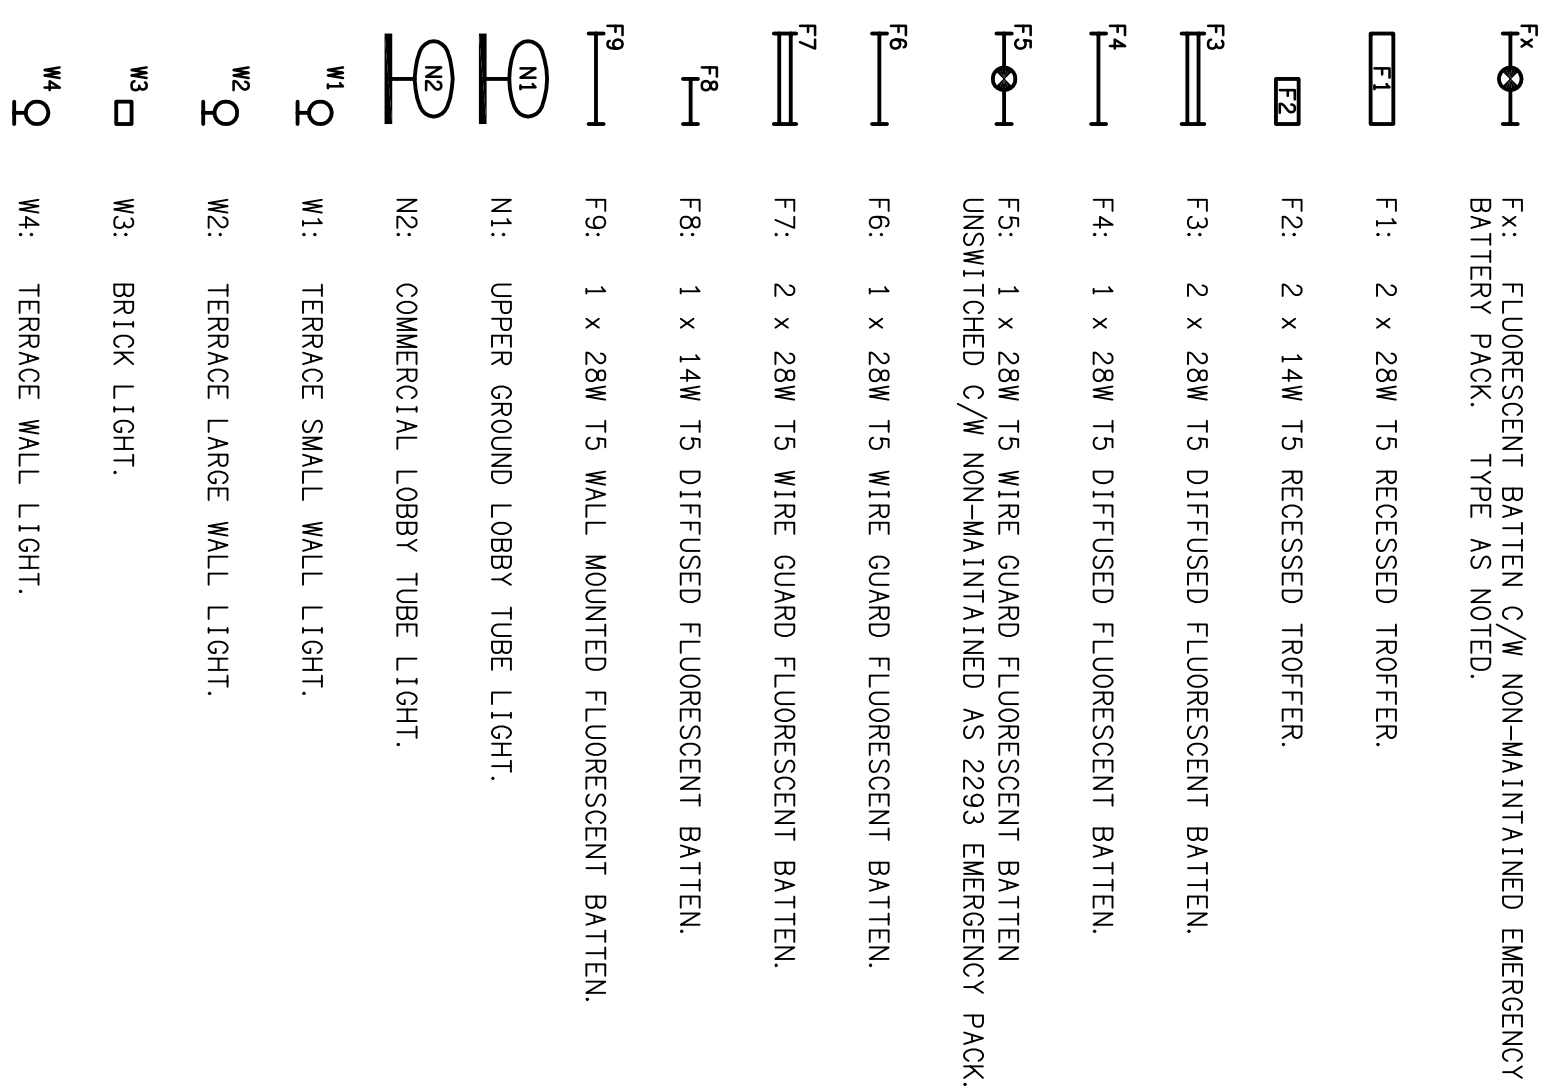

**MEZZANINE**  
FLOOR PLAN ABOVE SUBSTATION  
SCALE 1:100


**DETAIL**  
TELSTRA LEAD-IN CONDUIT  
SCALE 1:100

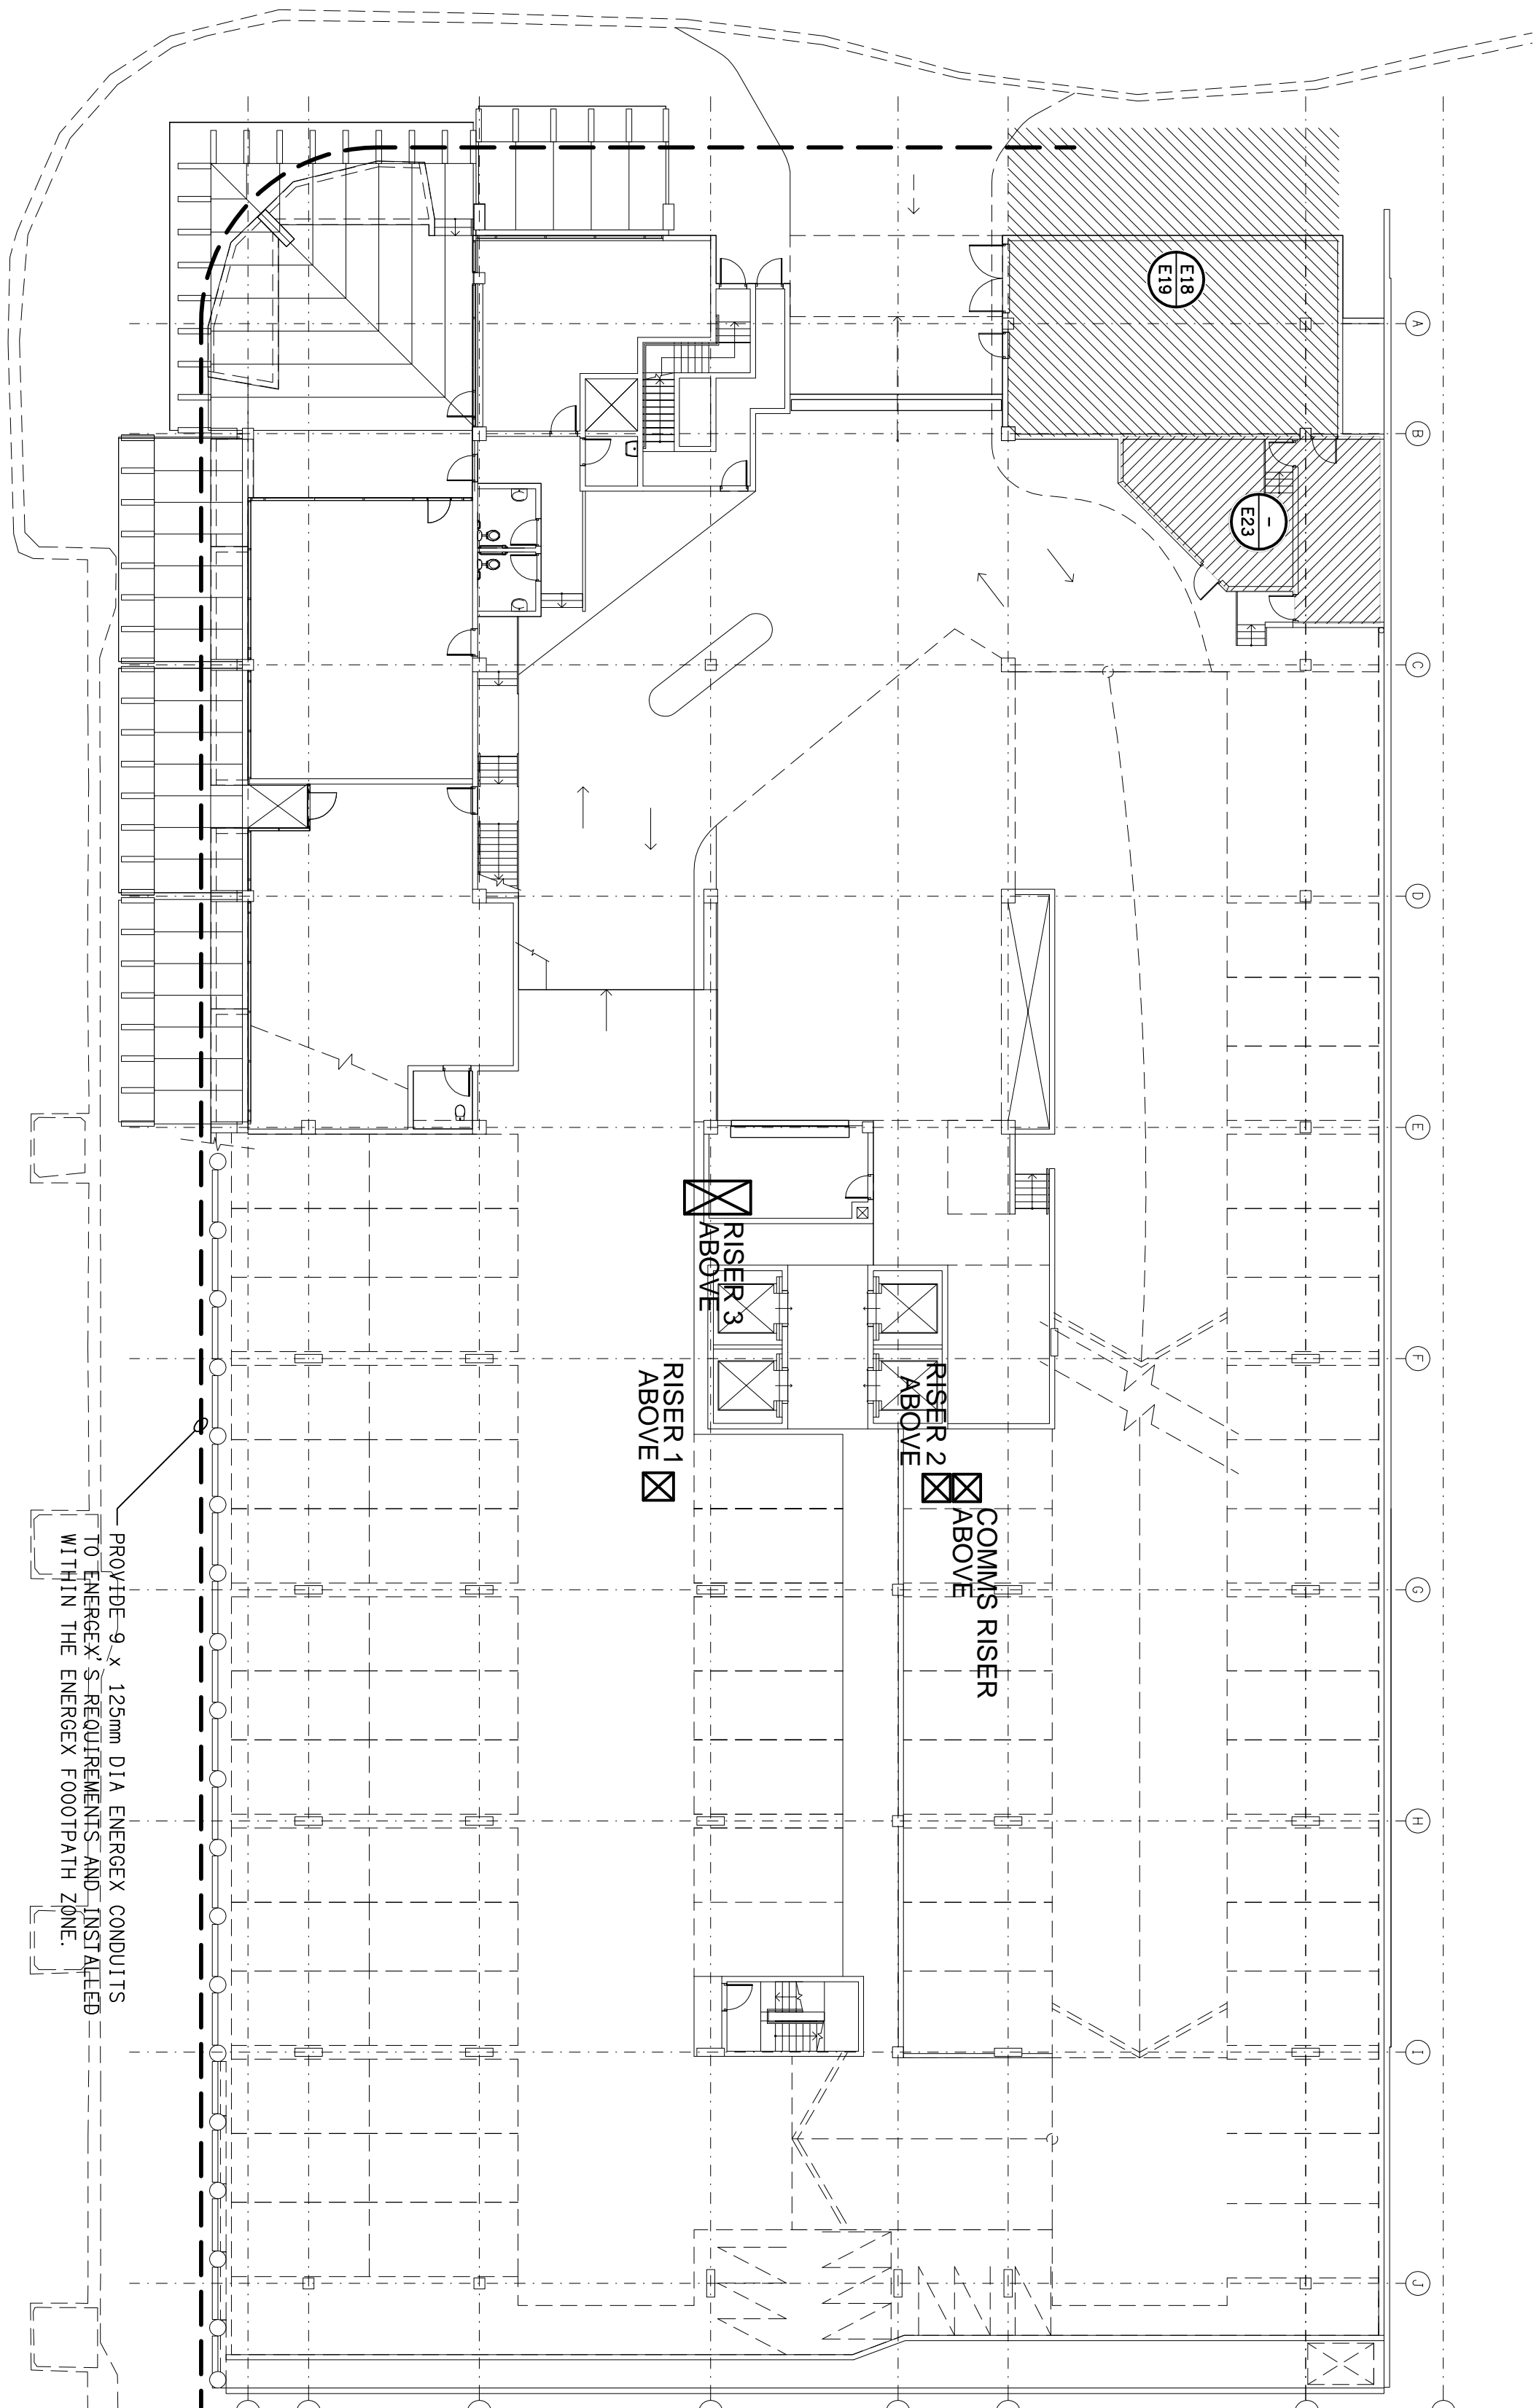

OFFICE USE ONLY:  
MARKUP: DRAFT: CHECK:

ELECTRICAL DESIGN GROUP BRISBANE  
PTV LID  
NOV 2012 7:10:39  
READING AS  
ELECTRICAL DESIGN GROUP

THE COPYRIGHT OF THIS DRAWING  
REMAINS THE PROPERTY OF THE  
ELECTRICAL DESIGN GROUP.  
USE FIGURED DIMENSIONS  
IN PREFERENCE TO SCALE.  
ALL DIMENSIONS TO BE  
VERIFIED ON SITE.

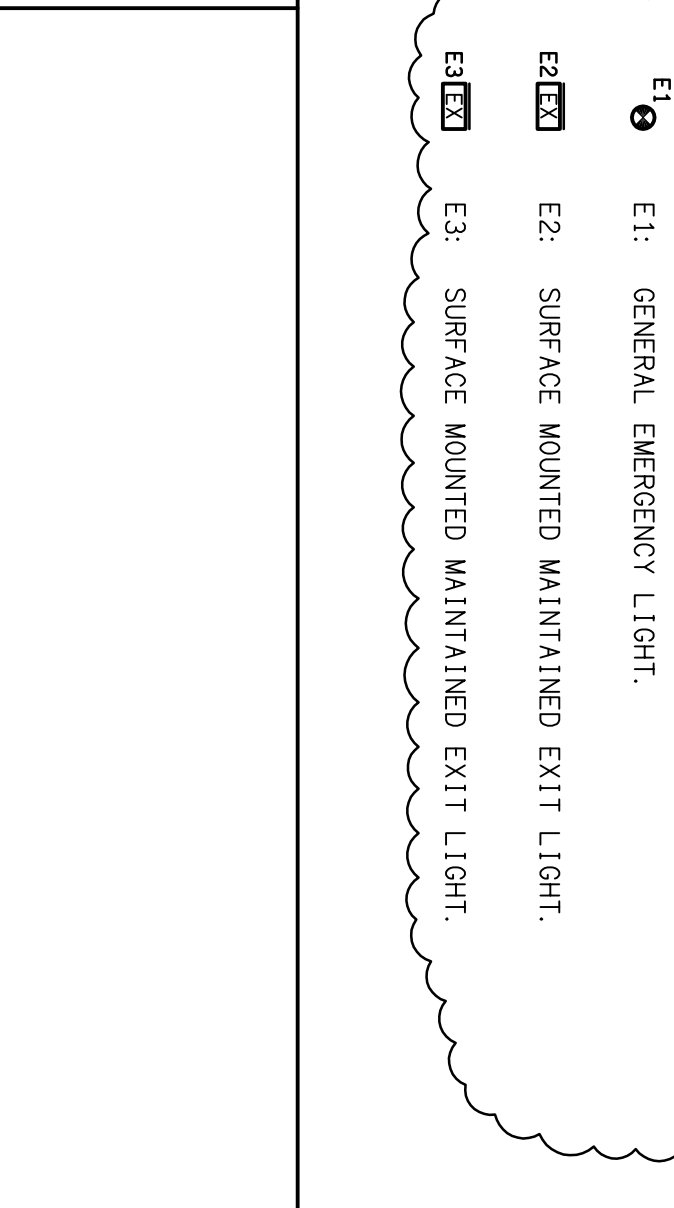

**ELECTRICAL DESIGN GROUP**  
ELECTRICAL COMMUNICATIONS FIRE SYSTEMS DESIGNERS  
BRISBANE  
P.O. Box 15, Sherwood Q.4075  
Phone: (07) 378 4375  
Fax: (07) 378 0222

Product:  
**SYNERGY**  
LOTS 30 & 31 MUSK AVENUE, KELVIN GROVE URBAN VILLAGE

Project:  
**SYNERGY**  
GOLD COAST  
P.O. Box 4248, Ashmore Q.4214  
Phone: (07) 5597 7551  
Fax: (07) 5597 7552

REVISIONS:  
ELECTRICAL SERVICES  
LEGEND, SITE PLAN & MEZZANINE LEVEL  
FLOOR PLAN  
SCALE AS SHOWN AT A1

PROJECT NO: **C0498a** DRAWING NO: **E01** REVISION: **E**

REV.	DESCRIPTION	DATE
E	CONSTRUCTION	12/06/2008