

OFFICE USE ONLY:
 MARKUP: DRAFT: CHECK:

ELECTRICAL DESIGN GROUP BRISBANE
 PTV LTD
 ADVISOR 710 793
 TRADING AS
 ELECTRICAL DESIGN GROUP

THE COPYRIGHT OF THIS DRAWING
 REMAINS THE PROPERTY OF THE
 ELECTRICAL DESIGN GROUP.
 USE FIGURED DIMENSIONS
 IN PREFERENCE TO SCALE.
 ALL DIMENSIONS TO BE
 VERIFIED ON SITE.


ELECTRICAL DESIGN GROUP
 ELECTRICAL COMMUNICATIONS FIRE SYSTEMS DESIGNERS
 BRISBANE
 P.O. Box 15, Sharnwood Q.4075
 Phone: (07) 3278 4375
 Fax: (07) 3716 0222

ELECTRICAL DESIGN GROUP
 GOLD COAST
 P.O. Box 4248, Ashmore Q.4214
 Phone: (07) 5597 7551
 Fax: (07) 5597 7552

PROJECT:
SYNERGY
 LOTS 30 & 31 MUSK AVENUE, KELVIN GROVE URBAN VILLAGE

DRAWING:
ELECTRICAL SERVICES
BASEMENT 2
FLOOR / REFLECTED CEILING PLAN
 SCALE:
 1:100
 AT A1
 PROJECT NO:
C04982a
 DRAWING NO:
E03
 REVISION:
D

REV: DESCRIPTION: DATE: 26/10/2007

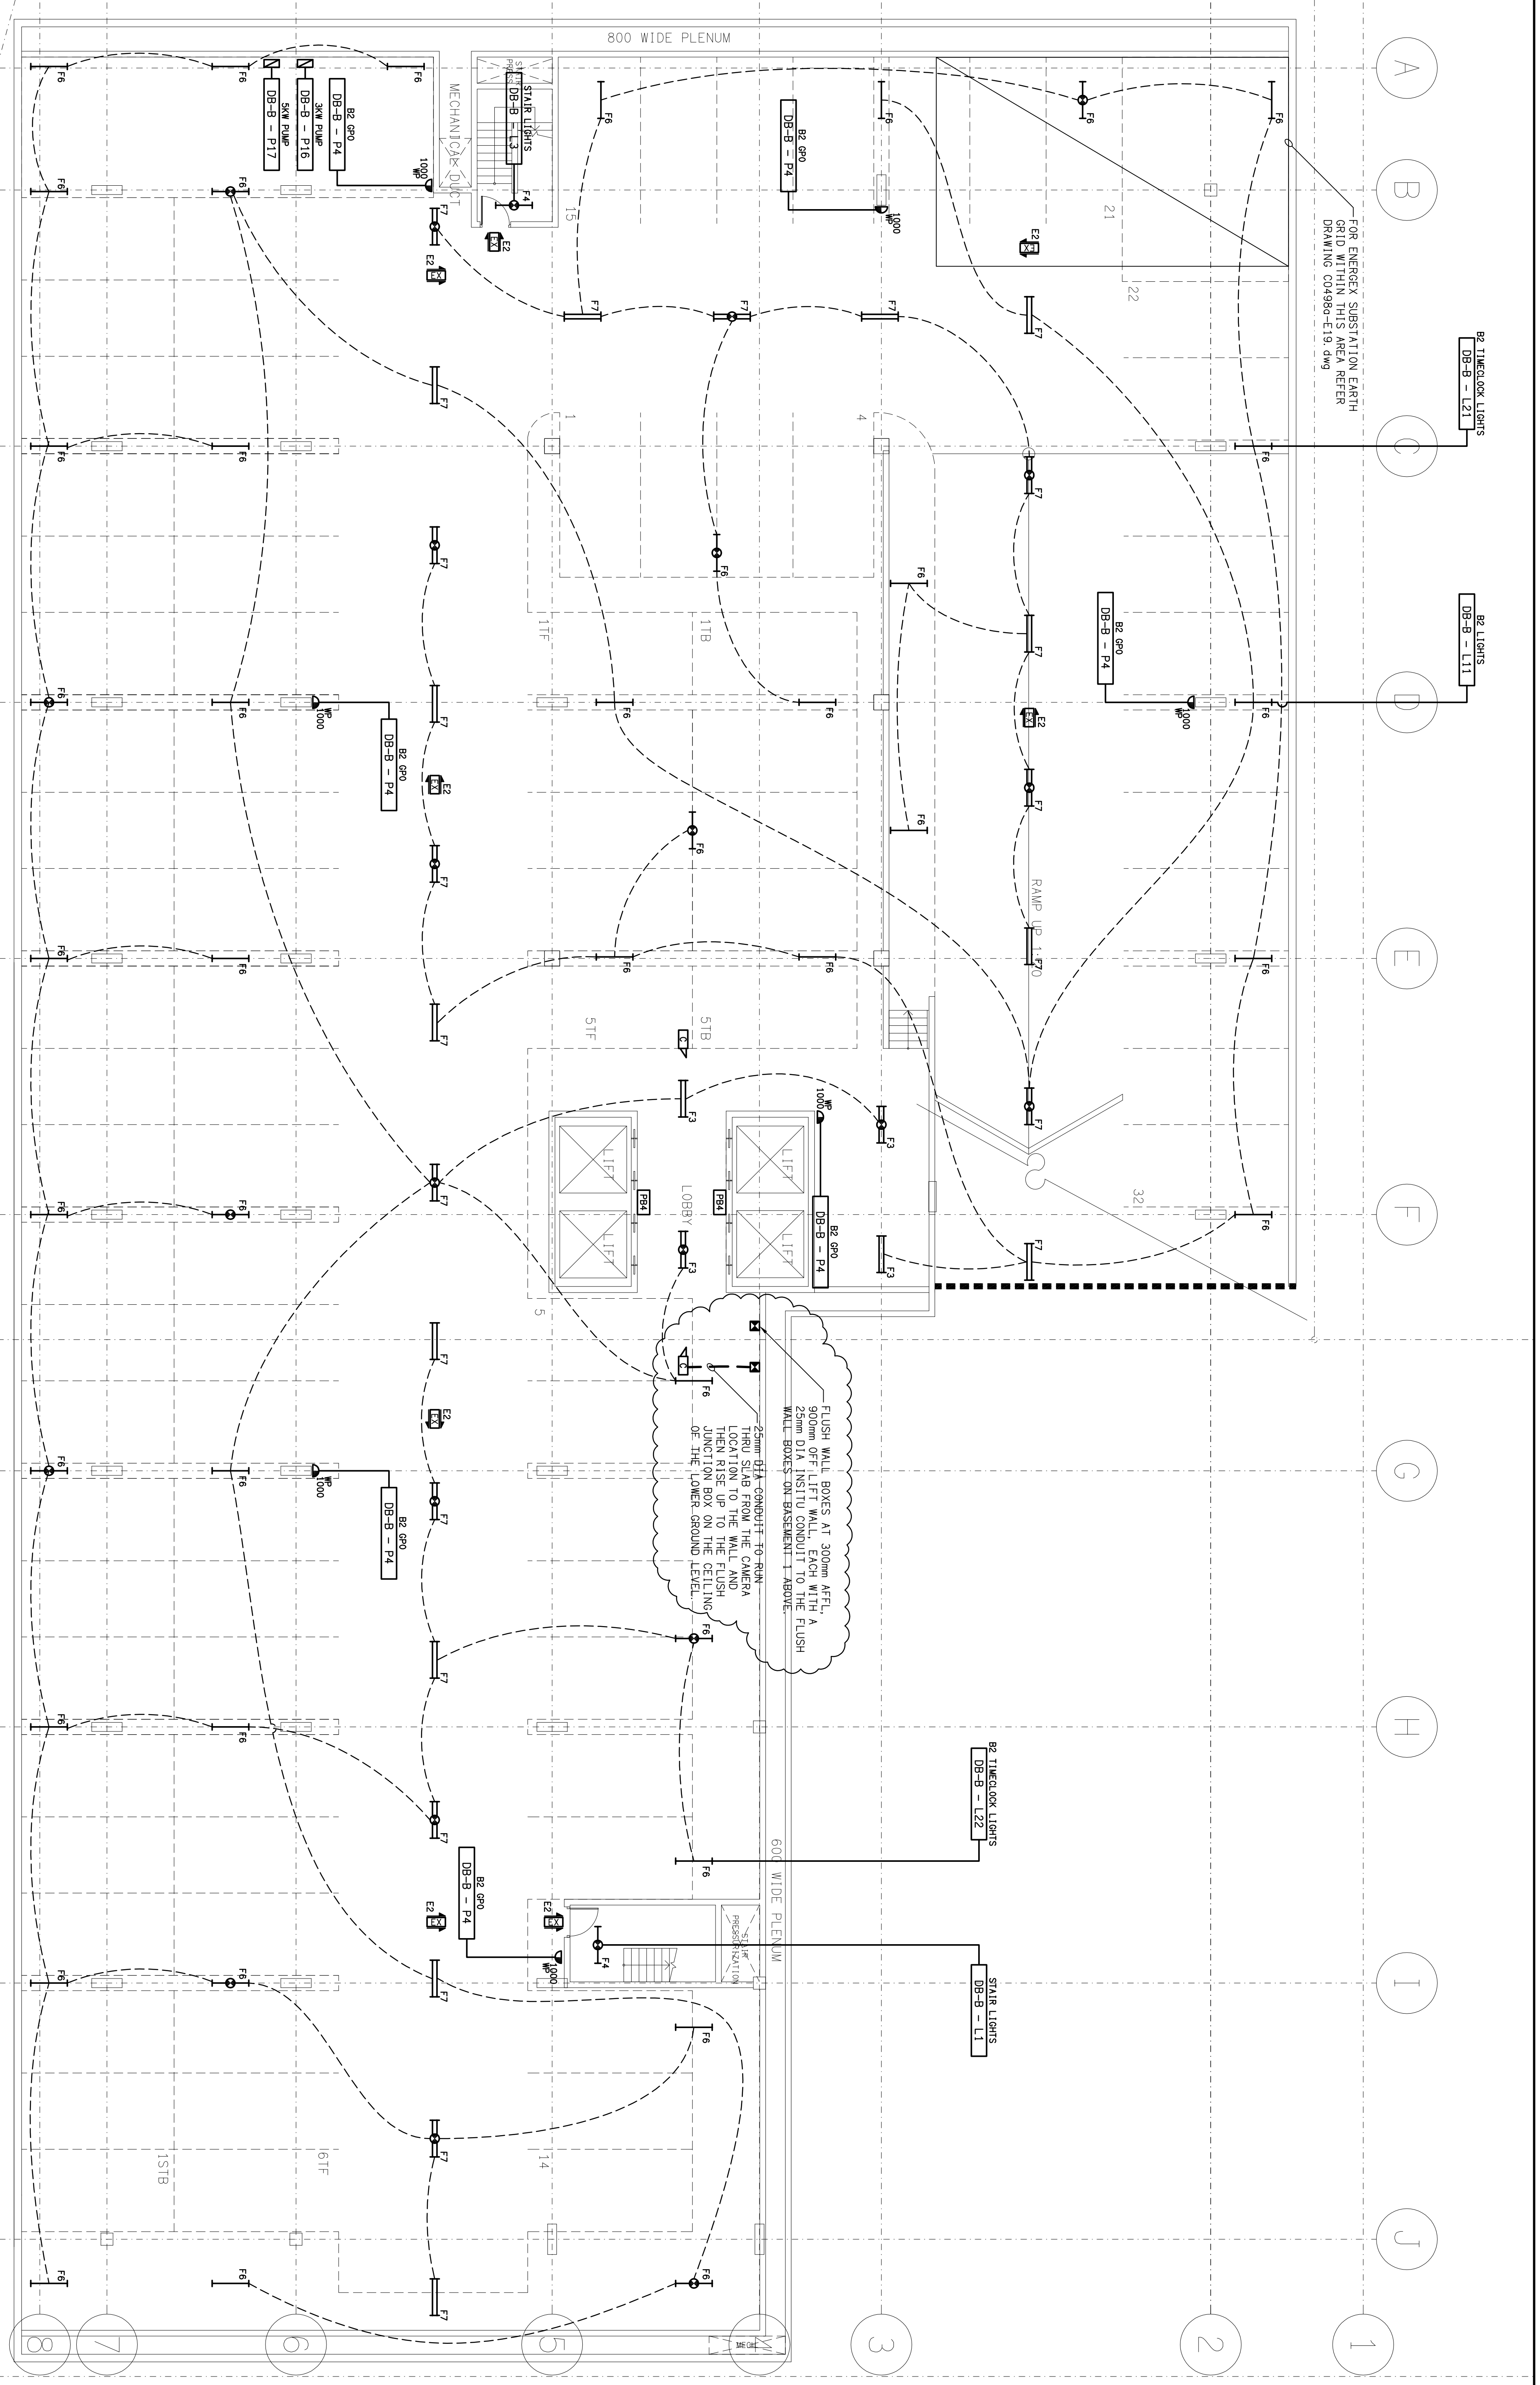

FOR ENERGEK SUBSTATION EARTH GRID WITHIN THIS AREA REFER DRAWING C04982a-E19.dwg