


LIGHTING ZONES ARE PROGRAMMED IN THE DALI LIGHTING CONTROL SYSTEM

PLANTER

TERRACE

TERRACE

COMMERCIAL
R1.49.750

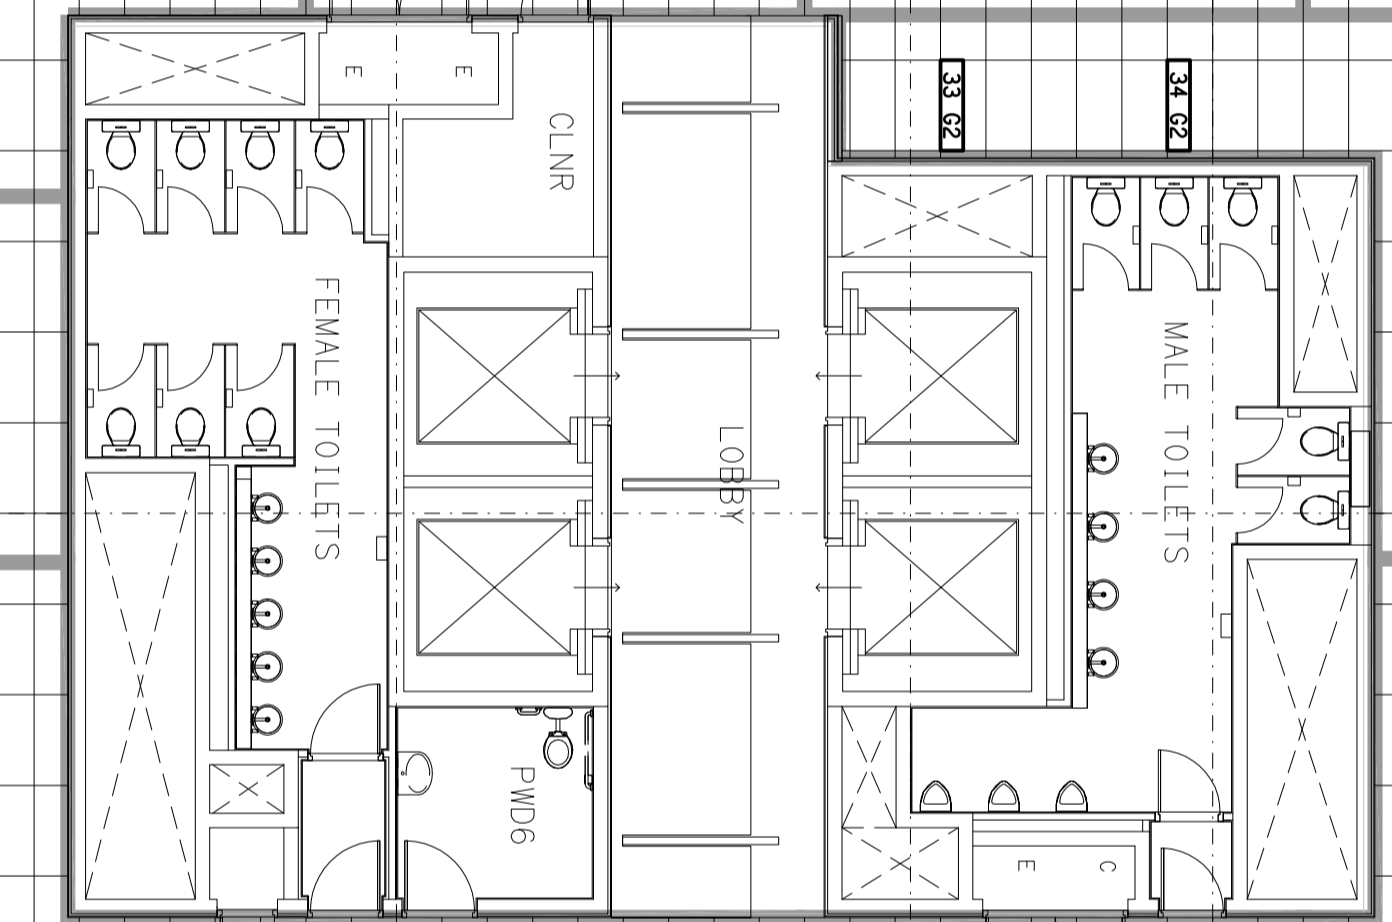

- NOTE 1: [Symbol] TYPICAL LUMINAIRE TYPE FL 5 = GATEWAY DEVICE No. 5
- NOTE 2: INTERNAL LIGHTING ZONES ARE CONTROLLED BY SWITCHES AT THE SP SWITCH PANELS.
- NOTE 3: PERIMETER LIGHTING ZONES CONTROLLED BY LIGHT SENSORS.

ELECTRICAL CONTRACTOR:



ELECTRICAL PTY LTD
 163 Jackson Road
 Sturtgard Hills
 Queensland 4109
 Phone: (07) 3945 6566
 Fax: (07) 3945 6577

PROJECT:

SYNERGY

LOTS 30 & 31 MUSK AVENUE, KELVIN GROVE URBAN VILLAGE

DRAWING:

ELECTRICAL SERVICES

LEVEL 1

FLOOR / REFLECTED CEILING PLAN

SCALE: 1:100

PROJECT NO: **C0498a**

DRAWING NO: **E07**

REVISION: **Q**

DATE: 27/03/2009

REV.	DESCRIPTION	DATE
Q	UPDATED AS INSTALLED	27/03/2009