

OFFICE USE ONLY:		
MARKUP:	DRAFT:	CHECK:

ELECTRICAL DESIGN GROUP BRISBANE
 PTY LTD
 1/10 7/10 7/93
 TRADING AS
 ELECTRICAL DESIGN GROUP


THE COPYRIGHT OF THIS DRAWING
 REMAINS THE PROPERTY OF THE
 ELECTRICAL DESIGN GROUP.
 USE FIGURED DIMENSIONS
 IN PREFERENCE TO SCALE.
 ALL DIMENSIONS TO BE
 VERIFIED ONSITE.

ELECTRICAL DESIGN GROUP
 ELECTRICAL COMMUNICATIONS FIRE SYSTEMS DESIGNERS
 BRISBANE
 P.O. Box 15, Sharnood Q.4075
 Phone: (07) 3278 4375
 Fax: (07) 3716 0222

ELECTRICAL DESIGN GROUP
 GOLD COAST
 P.O. Box 4249, Airmore Q.4214
 Phone: (07) 5597 7551
 Fax: (07) 5597 7552

Product:
SYNERGY
 LOTS 30 & 31 MUSK AVENUE, KELVIN GROVE URBAN VILLAGE

REV:	E	CONSTRUCTION	DATE:	21/04/2008
DESCRIPTION:	ELECTRICAL SERVICES			
SCALE:	1:100			
PROJECT NO.:	C04982a			
DRAWING NO.:	E13			
REVISION:	E			

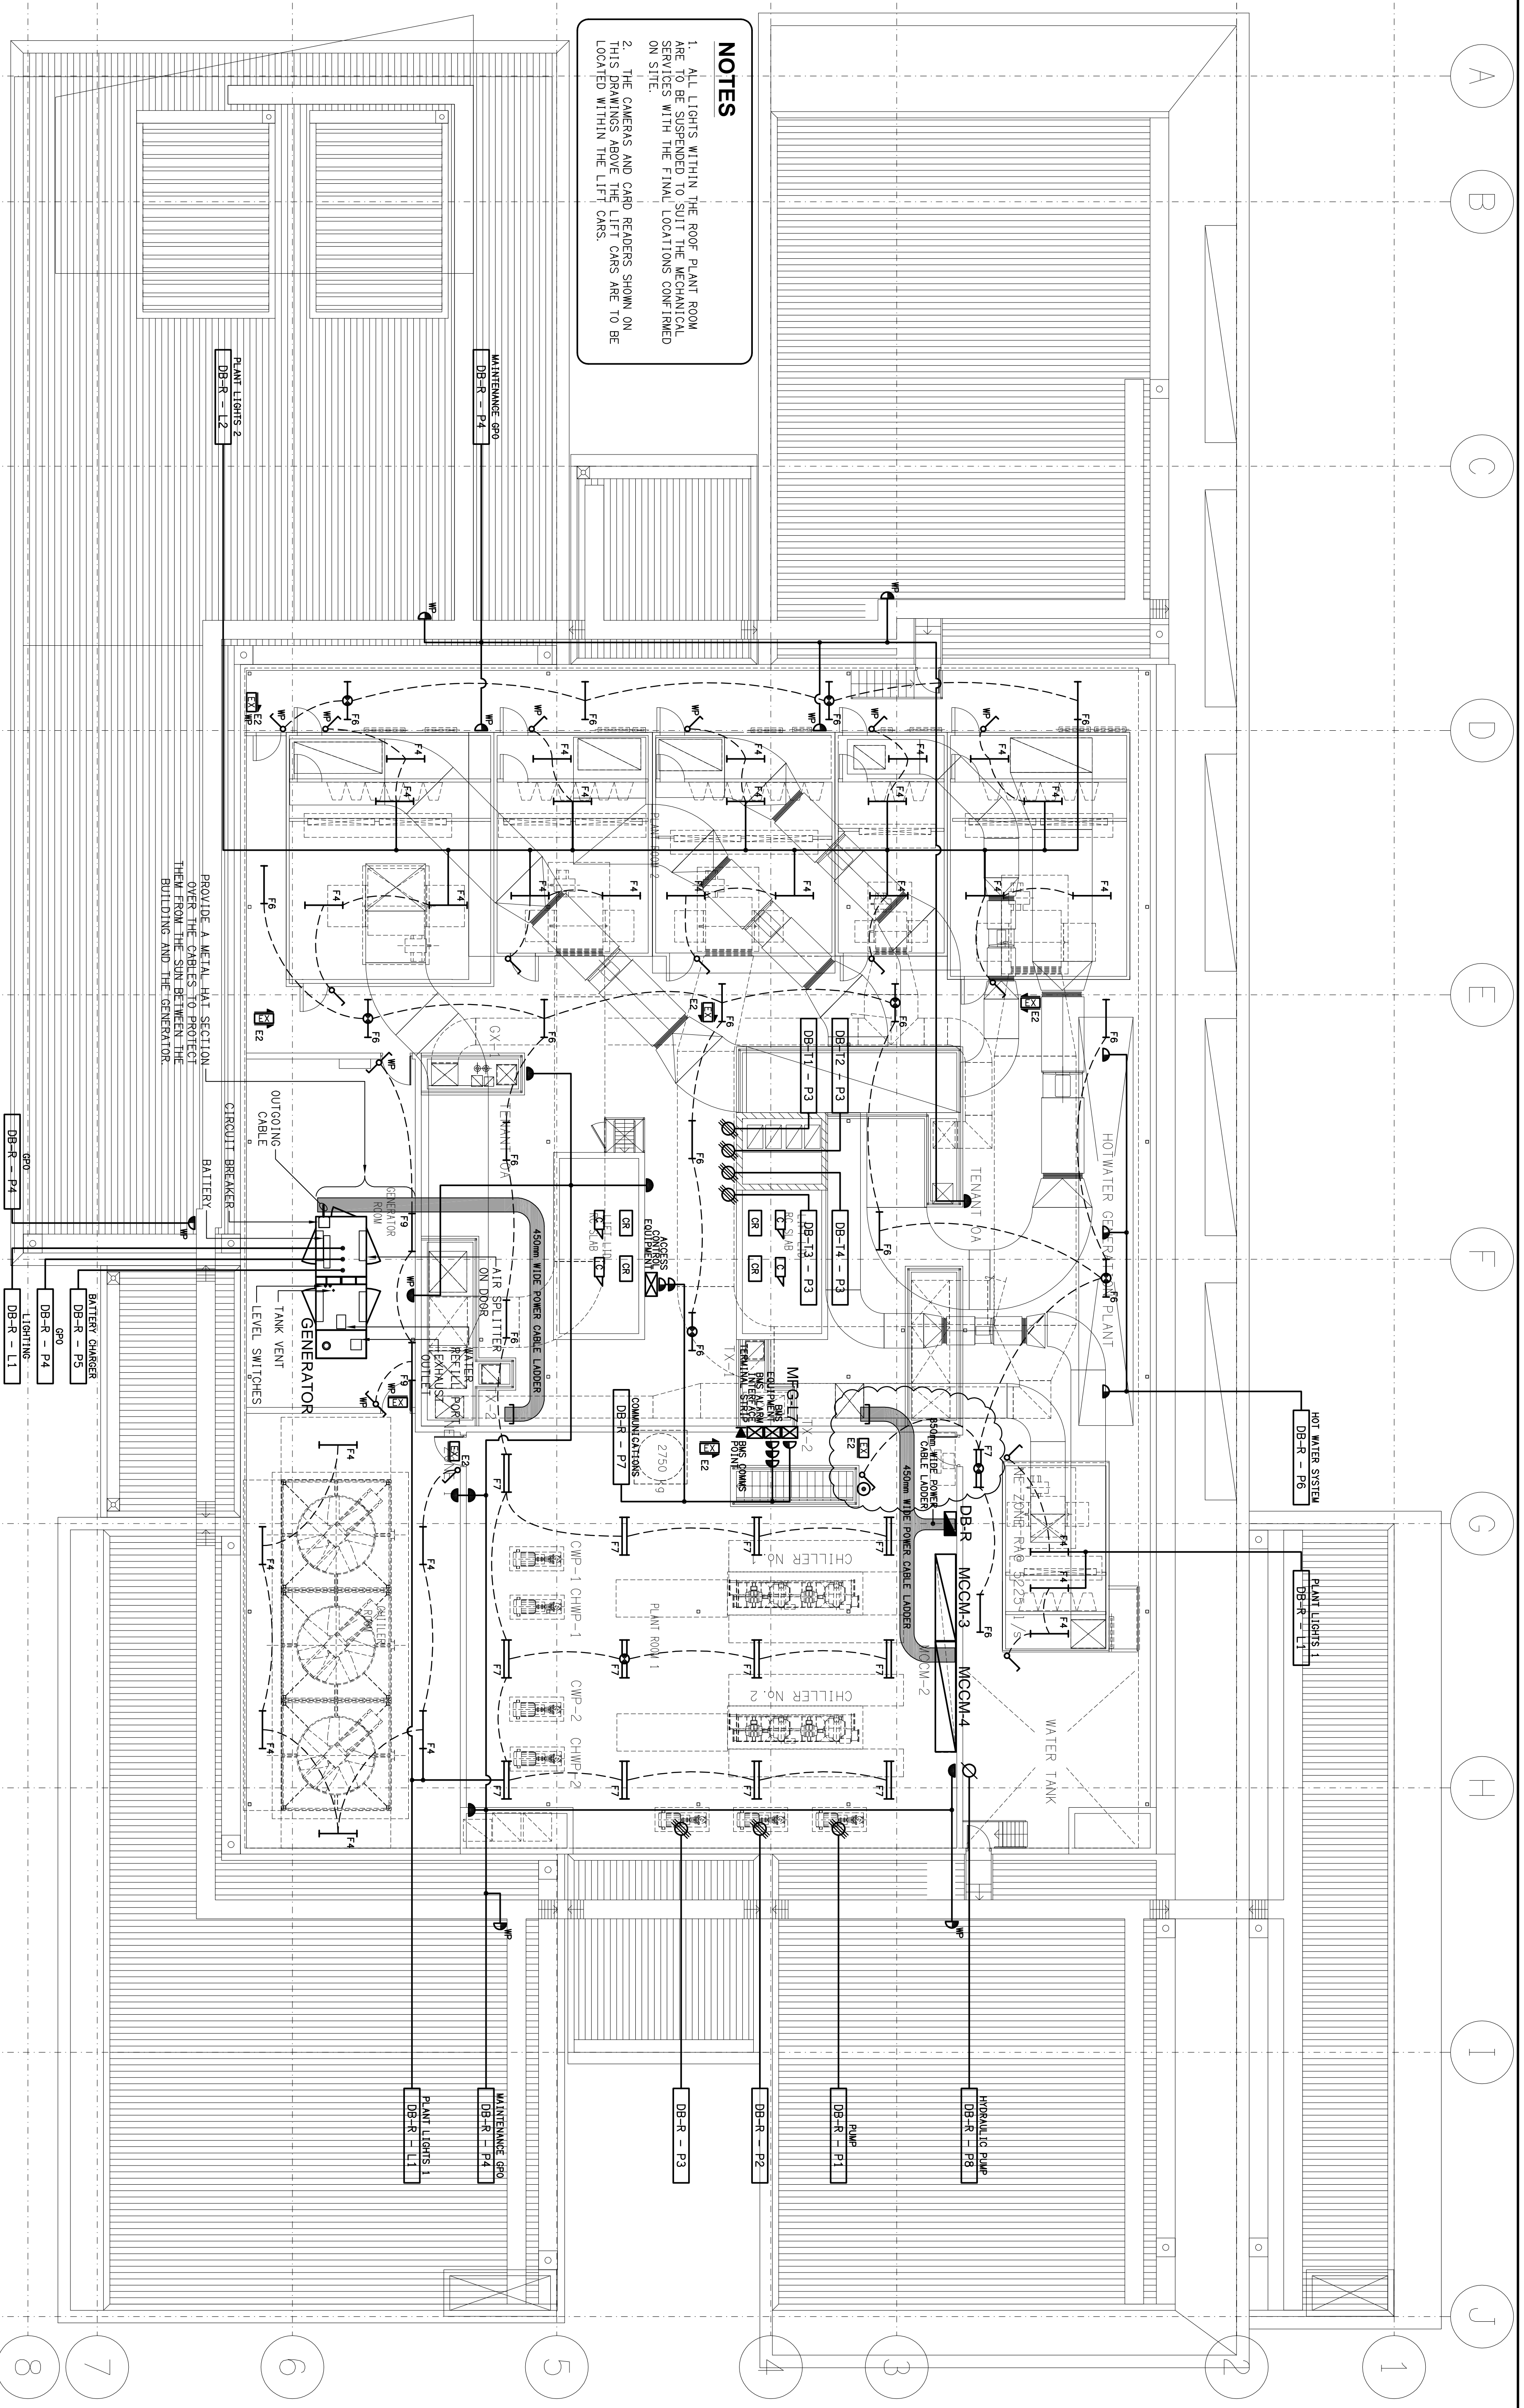

NOTES

1. ALL LIGHTS WITHIN THE ROOF PLANT ROOM ARE TO BE SUSPENDED TO SUIT THE MECHANICAL SERVICES WITH THE FINAL LOCATIONS CONFIRMED ON SITE.
2. THE CAMERAS AND CARD READERS SHOWN ON THIS DRAWINGS ABOVE THE LIFT CARS ARE TO BE LOCATED WITHIN THE LIFT CARS.

PROVIDE A METAL MAT SECTION OVER THE GENTS TO PROTECT THE FLOORING SURFACES FROM THE BUILDING AND THE GENERATOR.