

ELECTRICAL DESIGN GROUP BRISBANE
 PTY LTD
 15/1607/10/793
 TRADING AS
 ELECTRICAL DESIGN GROUP

THE COPYRIGHT OF THIS DRAWING
 REMAINS THE PROPERTY OF THE
 ELECTRICAL DESIGN GROUP.
 USE FIGURED DIMENSIONS
 IN PREFERENCE TO SCALE.
 ALL DIMENSIONS TO BE
 VERIFIED ONSITE.

ELECTRICAL DESIGN GROUP
 BRISBANE
 P.O. Box 15, Shewood Q.4075
 Phone: (07) 3278 4375
 Fax: (07) 3718 0222

ELECTRICAL COMMUNICATIONS FIRE SYSTEMS DESIGNERS
 GOLD COAST
 P.O. Box 4248, Ashmore Q.4214
 Phone: (07) 5597 7551
 Fax: (07) 5597 7552






ELECTRICAL DESIGN GROUP
 PROJECT:
ANGLICAN CHURCH GRAMMAR SCHOOL
AQUATIC CENTRE
 OAKLAND PARADE, COORPAROO

ELECTRICAL SERVICES
LEGEND & SITE PLAN

SCALE: 1:200
 AT A1

PROJECT NO: **C0616a**
 DRAWING NO: **E01**
 REVISION: **E**

REV.	DESCRIPTION	DATE
E	CONSTRUCTION	01/06/2010

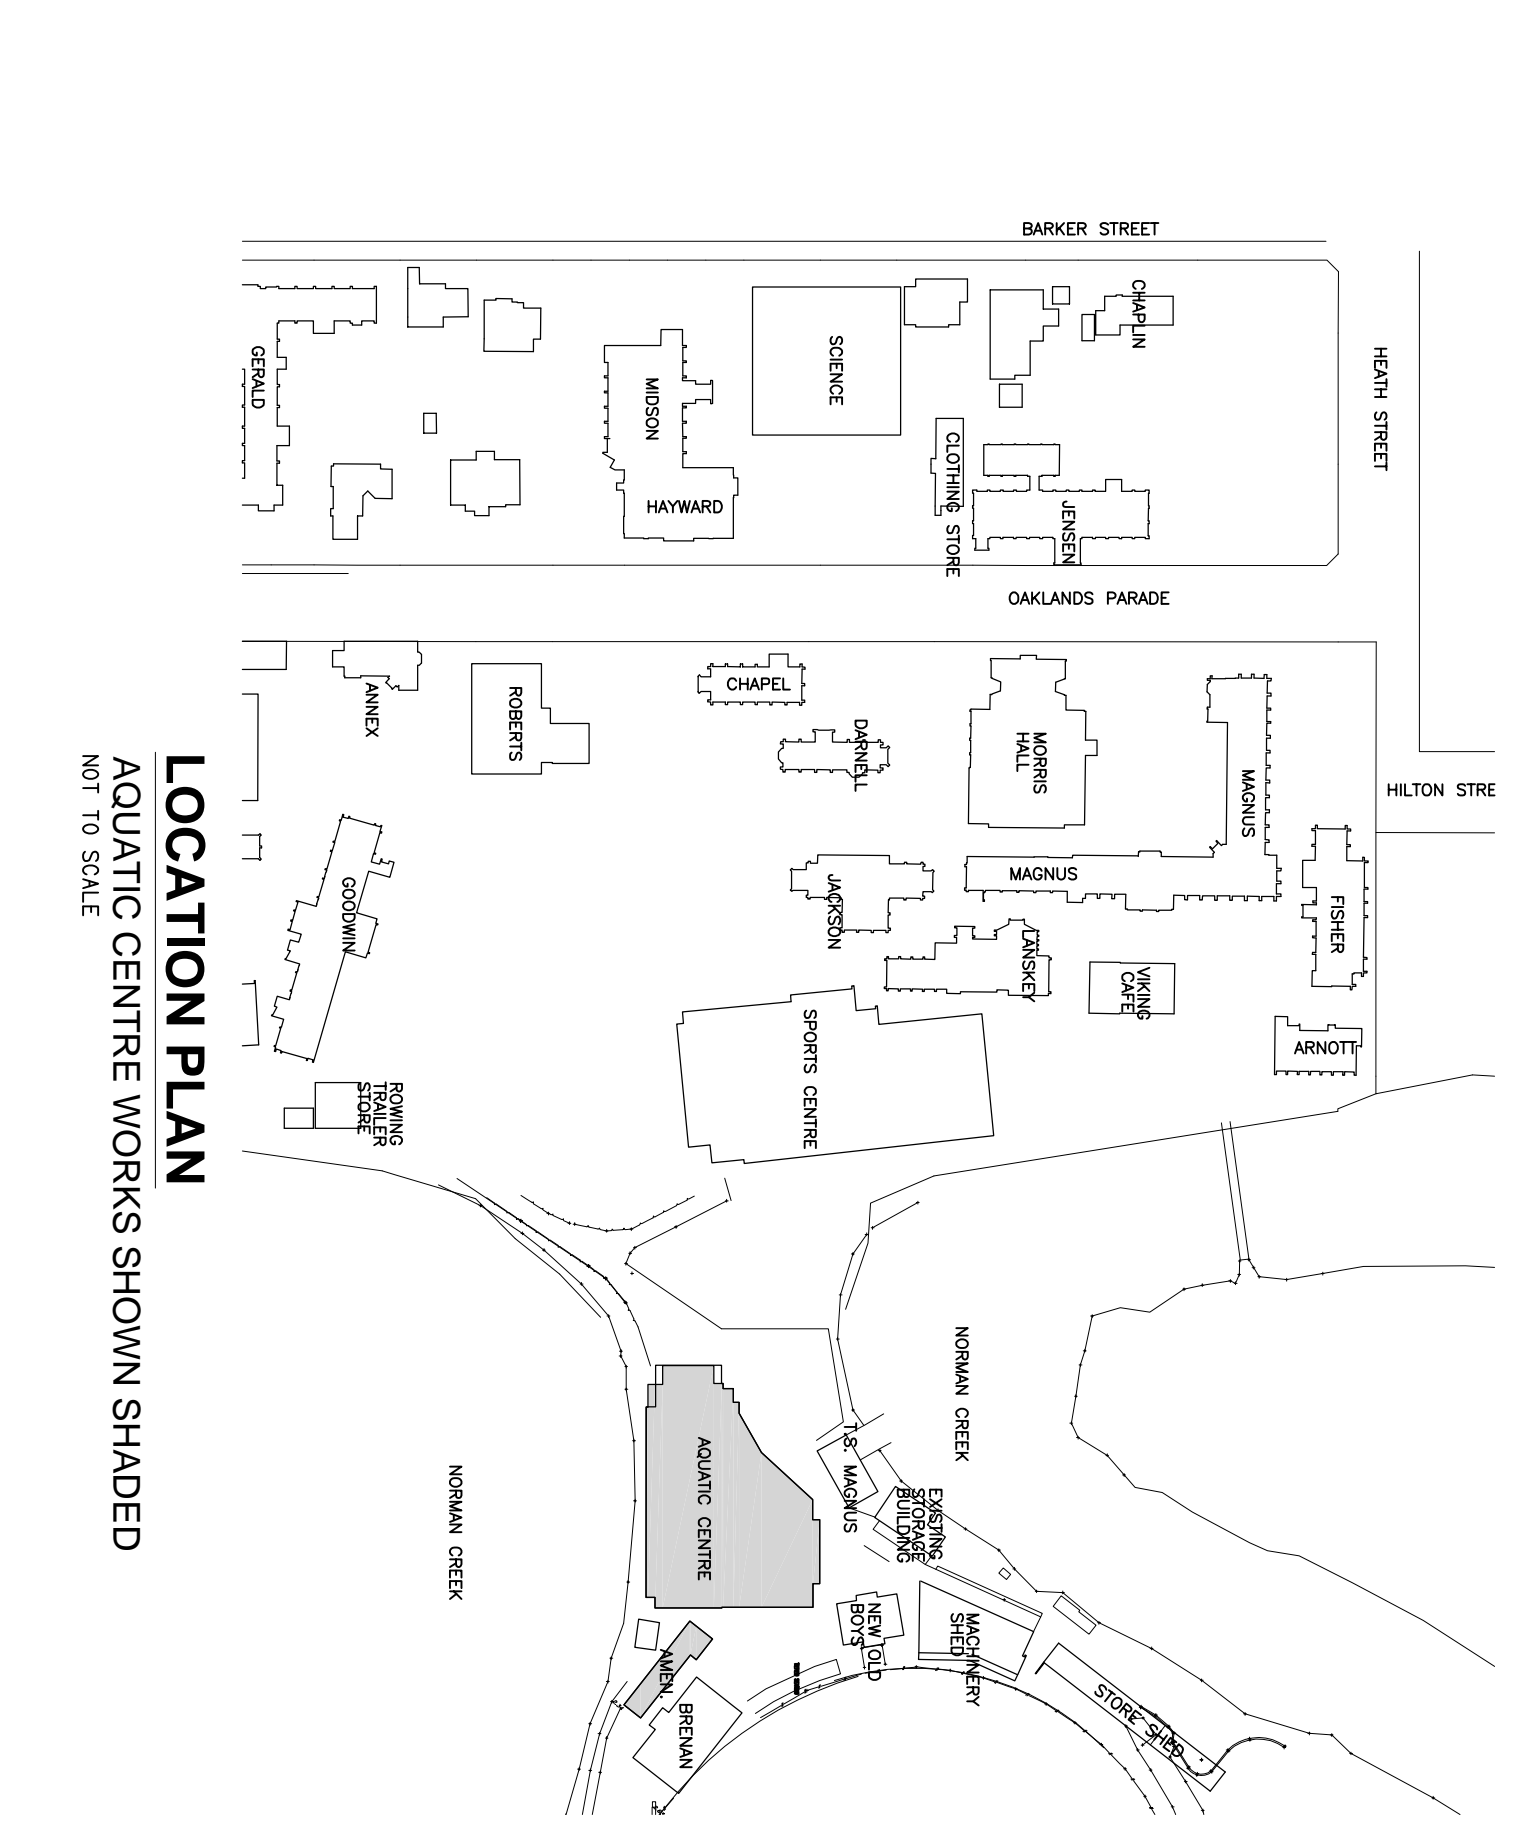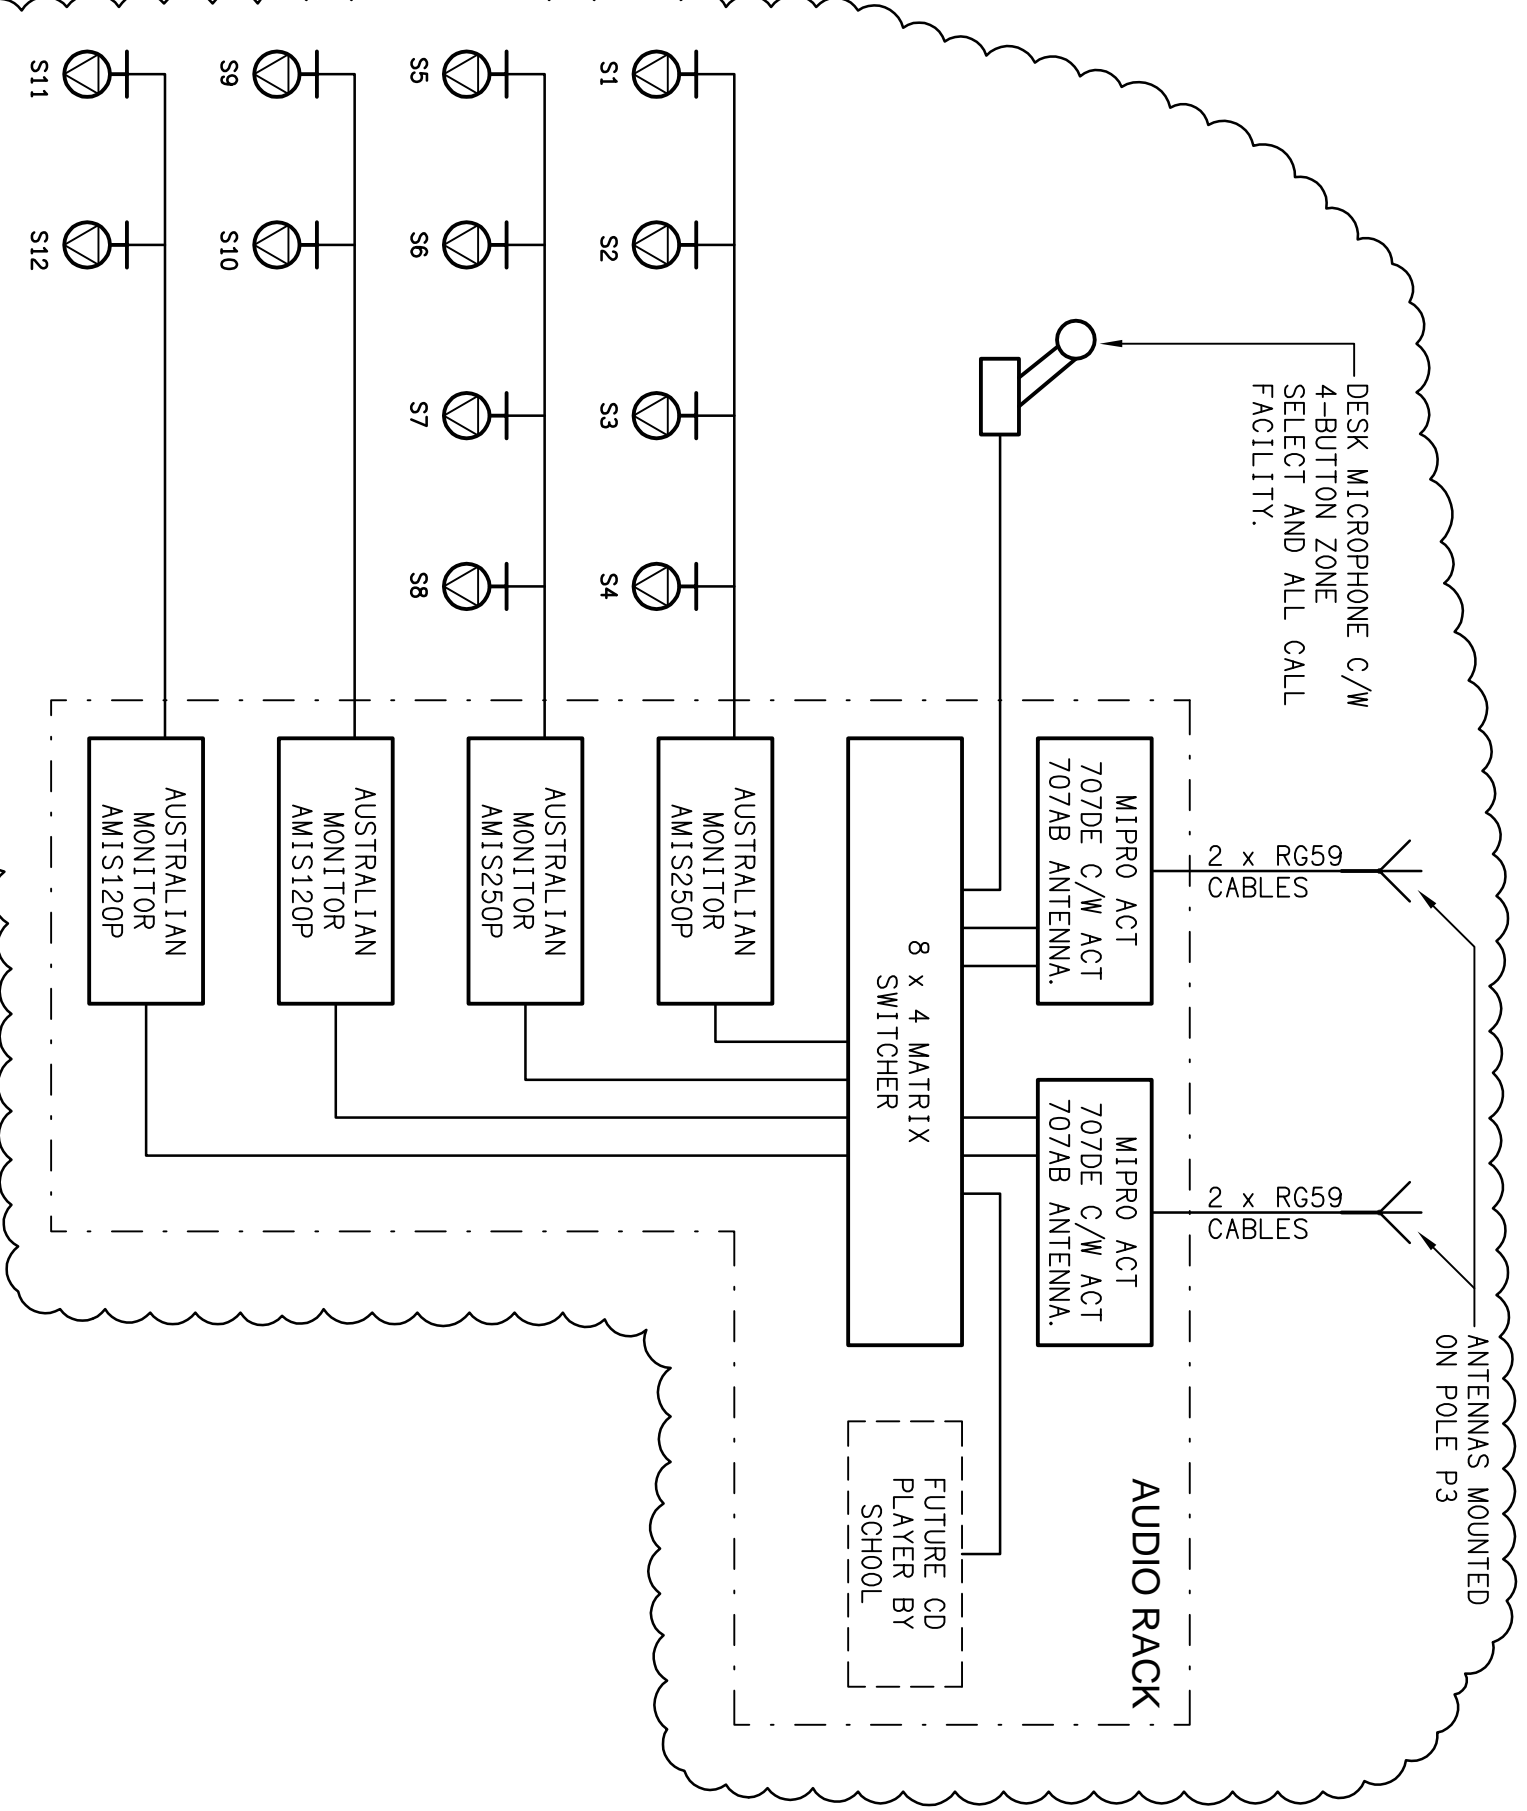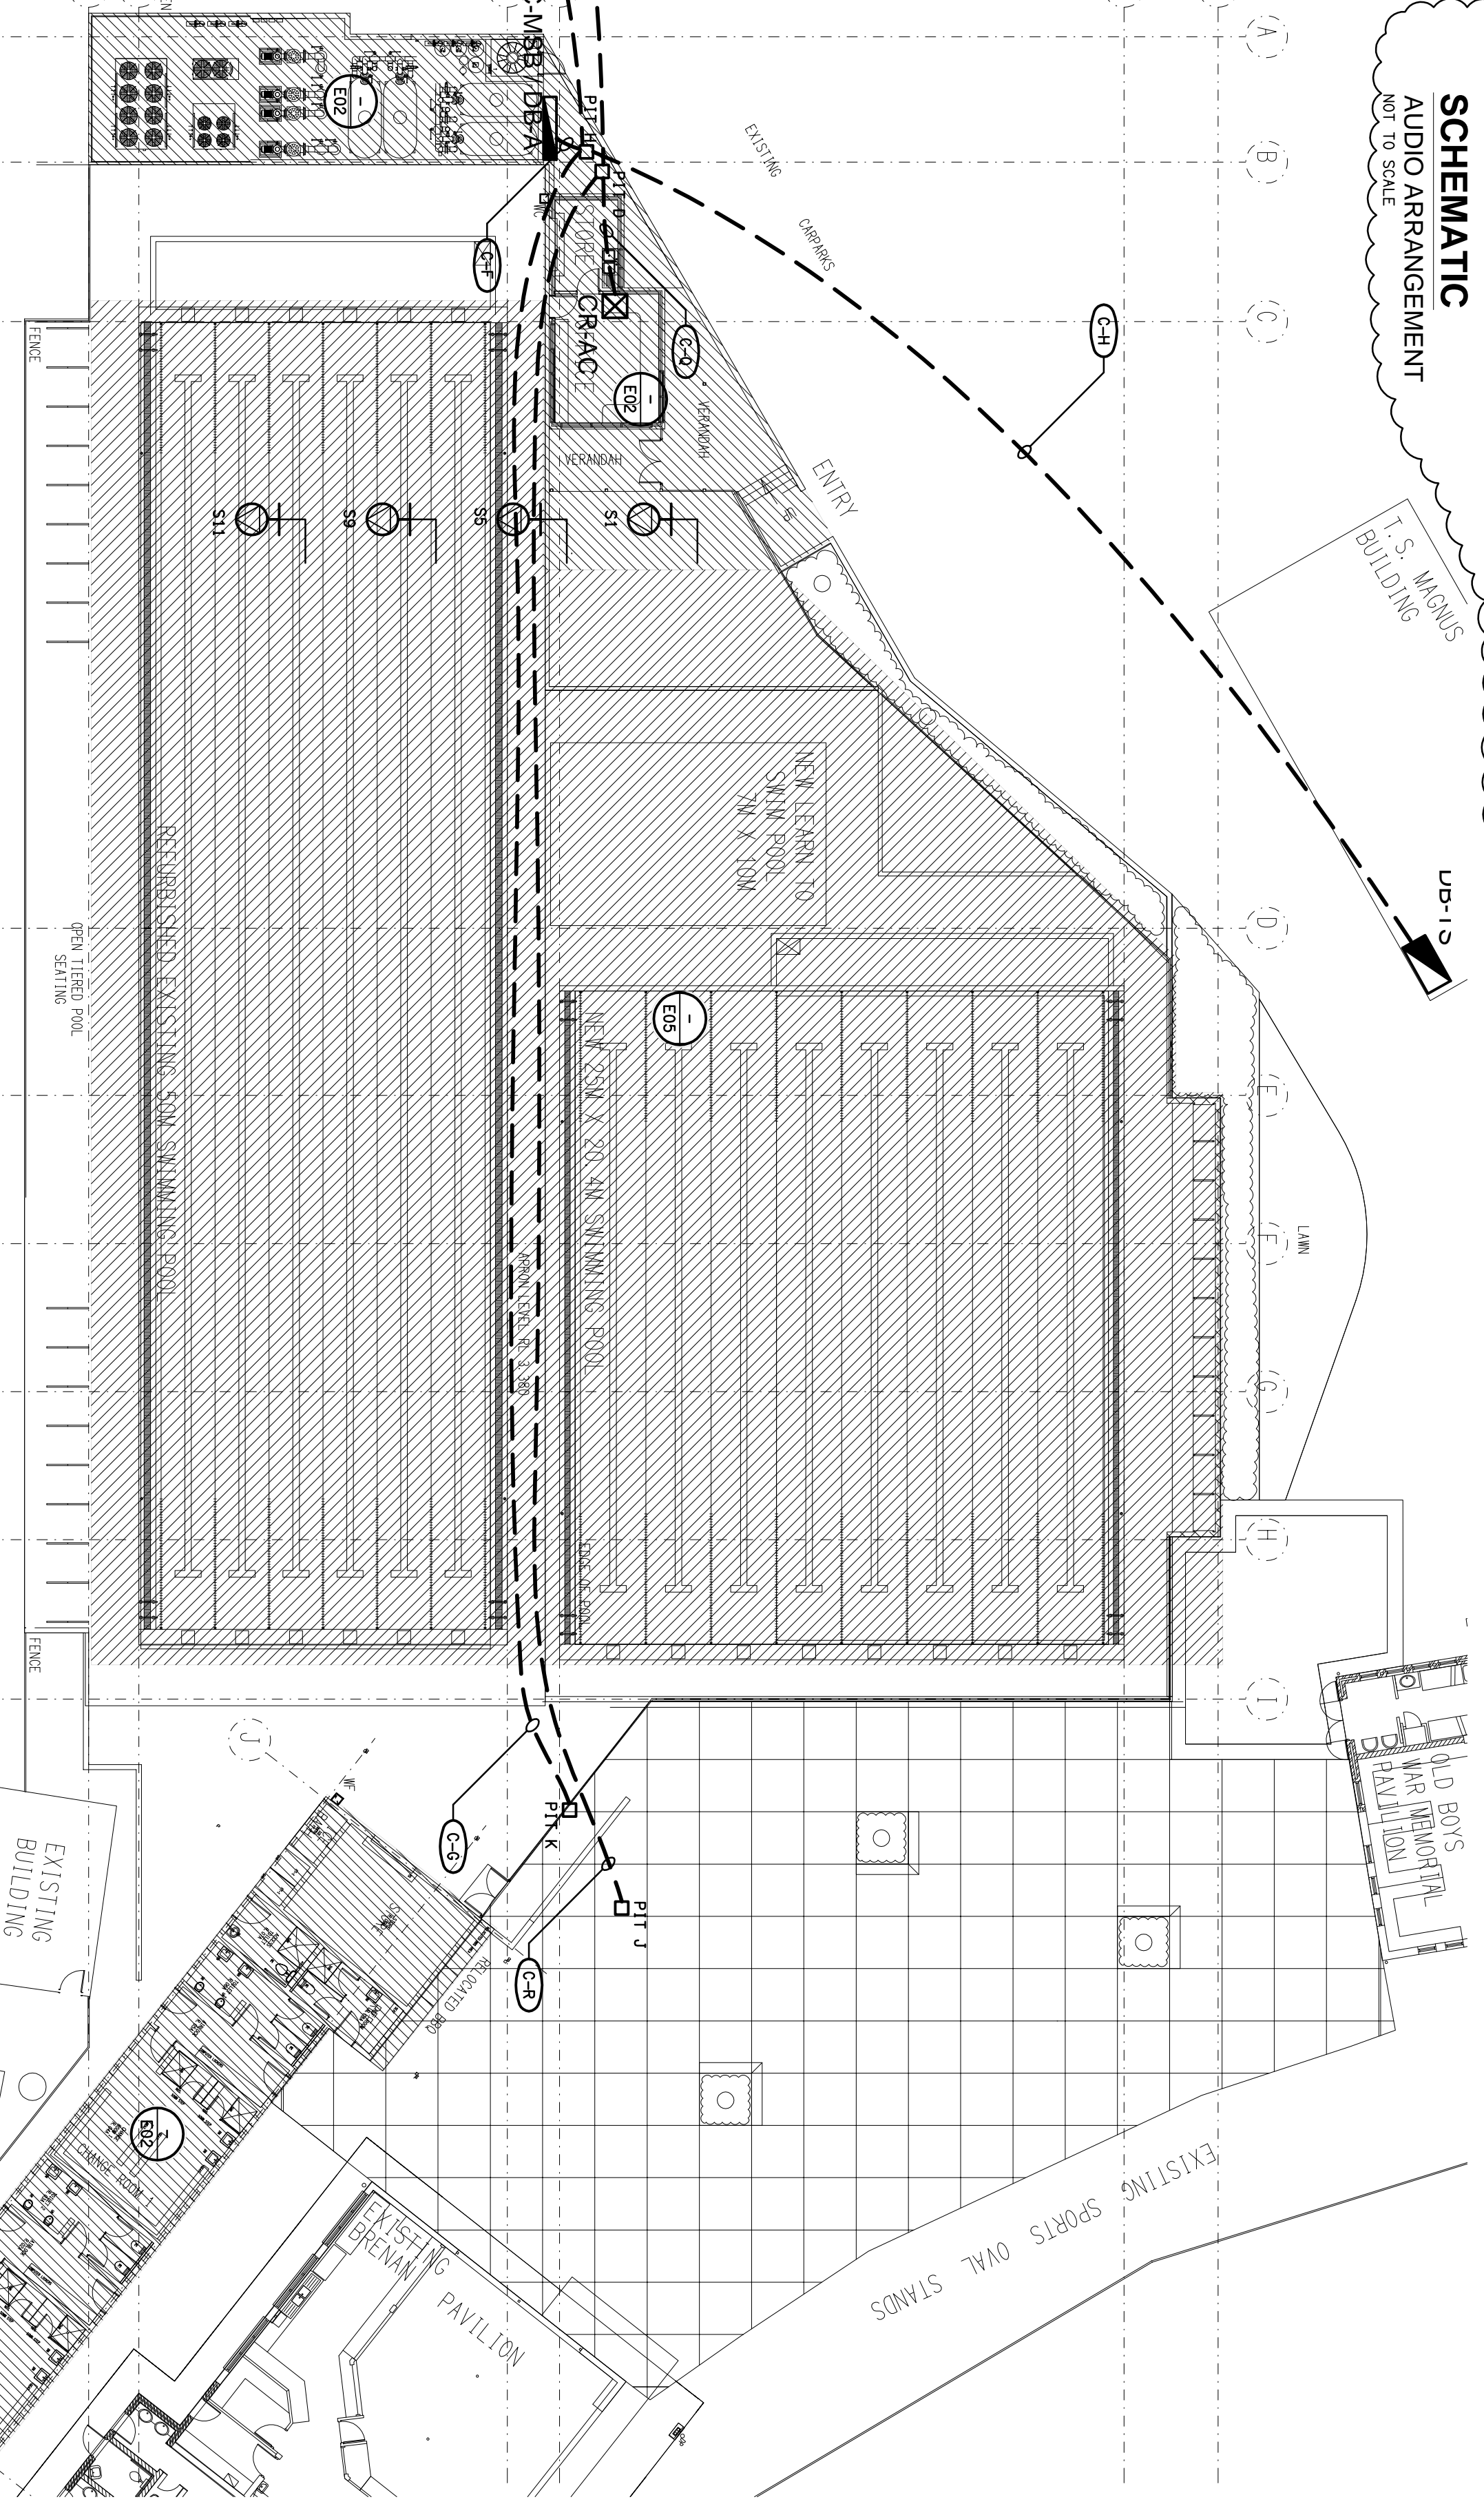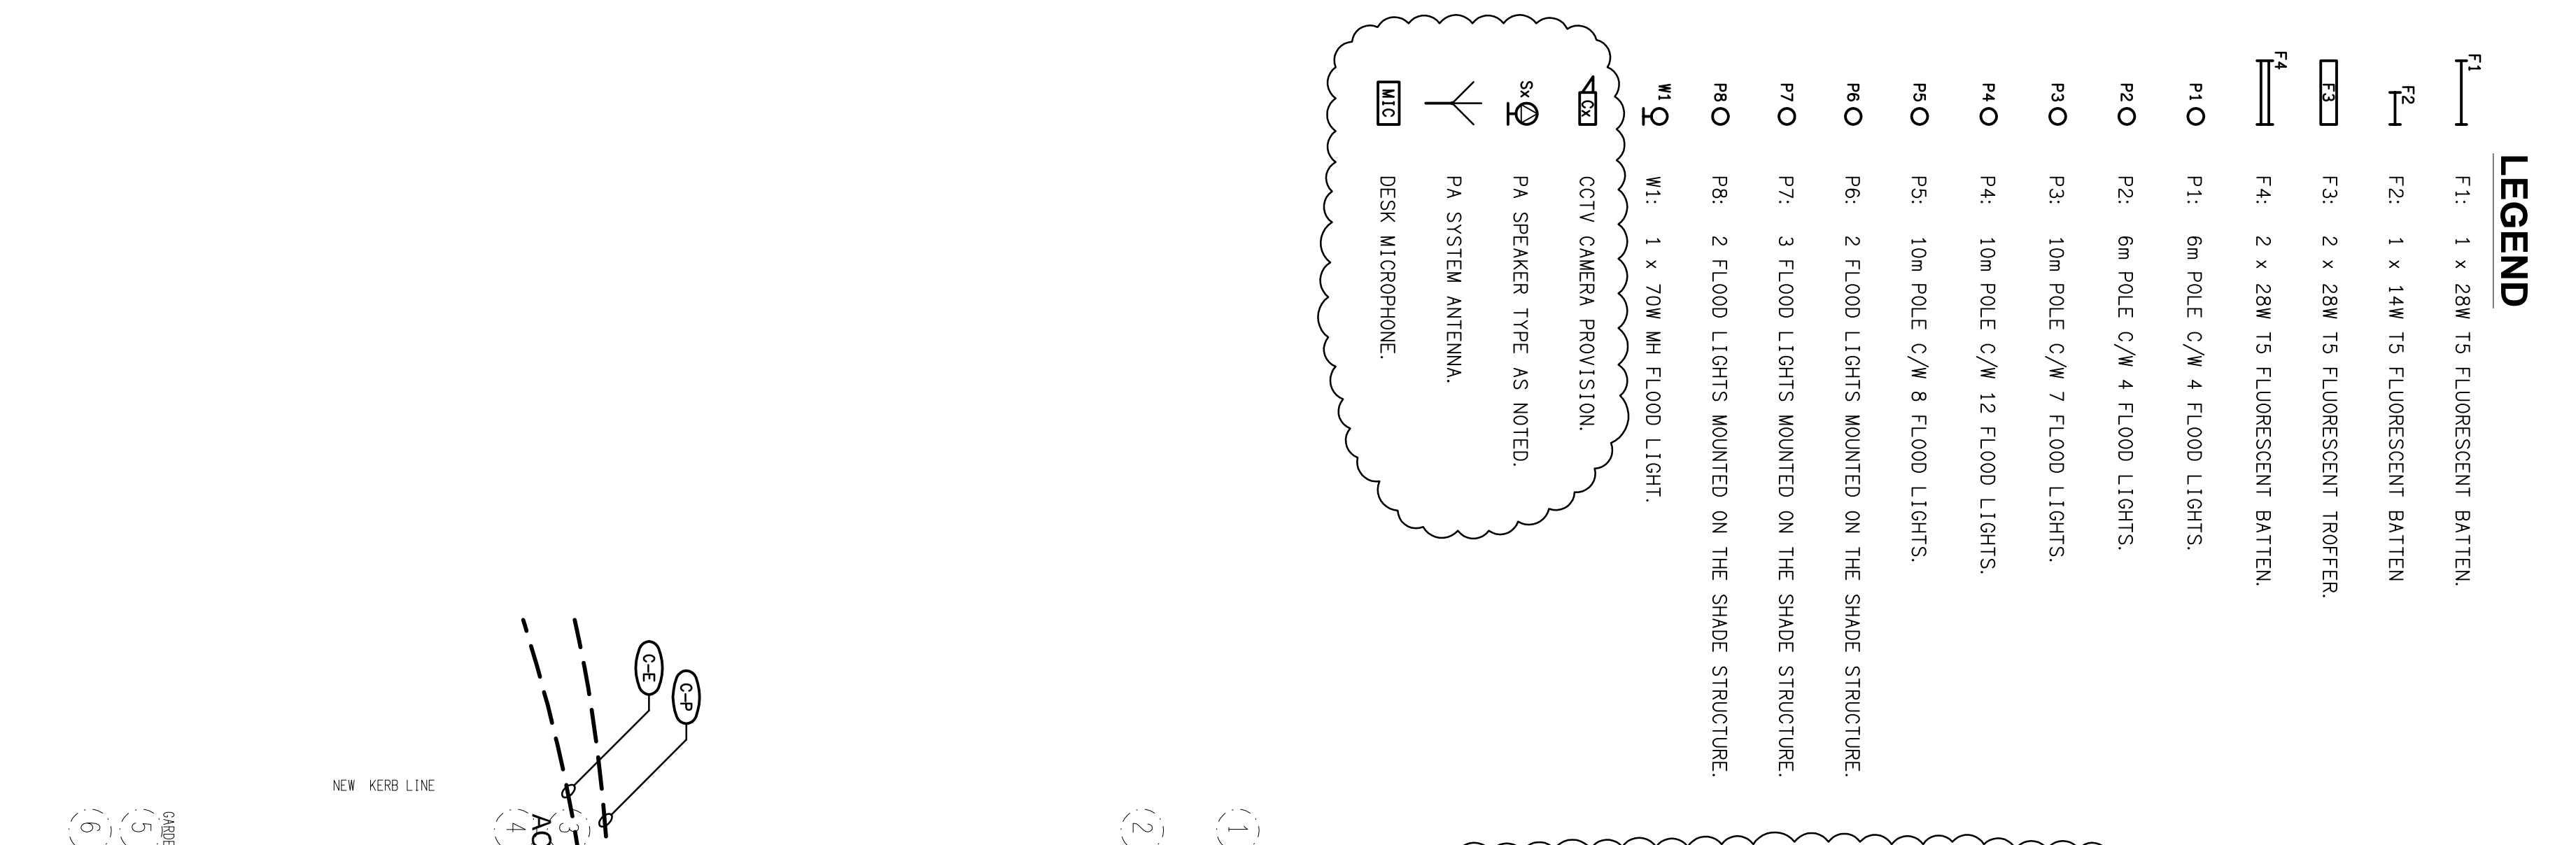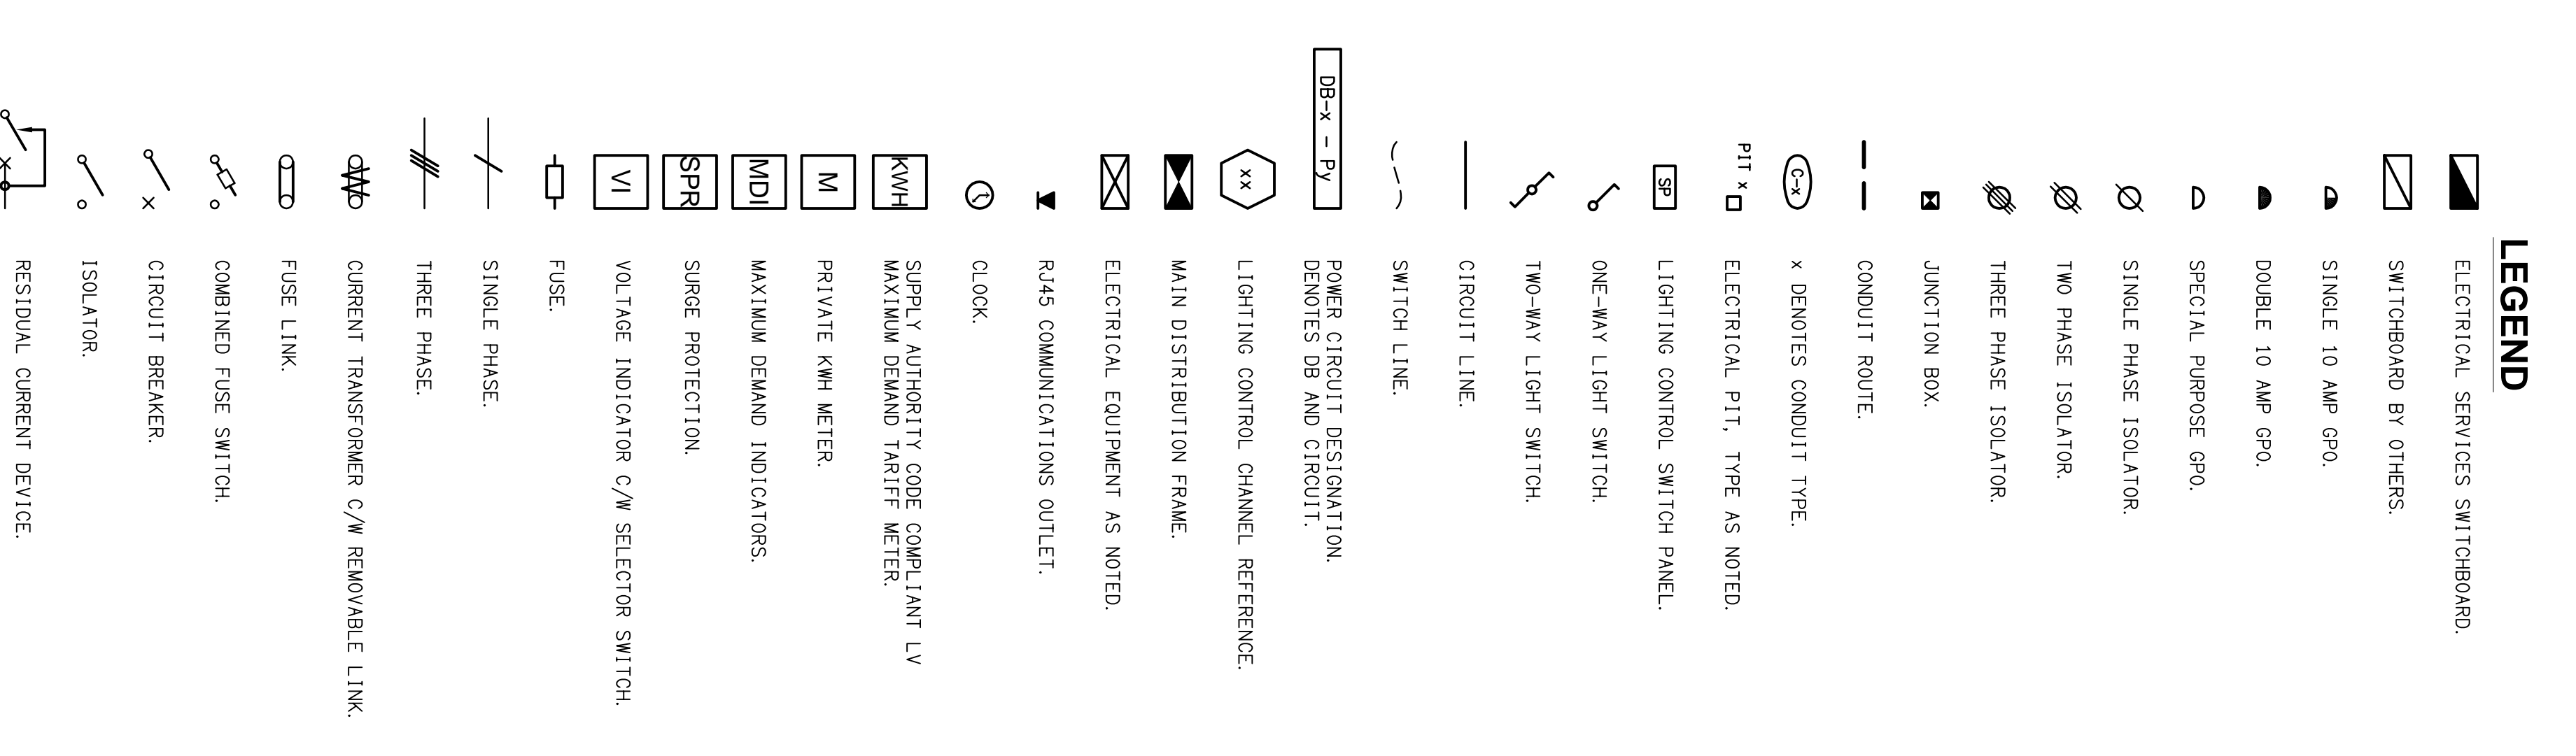

NOTE
 FOR A FULL CONDUIT SITE PLAN
 REFER TO DRAWING C0616a-E04.dwg

SITE PLAN
 AQUATIC CENTRE
 SCALE: 1:200