

|         |        |        |
|---------|--------|--------|
| MARKUP: | DRAFT: | CHECK: |
|---------|--------|--------|

OFFICE USE ONLY:  
 ELECTRICAL DESIGN GROUP BRISBANE  
 P/T/D  
 NON 06/710 793  
 TRADING AS  
 ELECTRICAL DESIGN GROUP

THE COPYRIGHT OF THIS DRAWING  
 REMAINS THE PROPERTY OF THE  
 ELECTRICAL DESIGN GROUP.  
 USE FIGURED DIMENSIONS  
 IN PREFERENCE TO SCALE.  
 ALL DIMENSIONS TO BE  
 VERIFIED ONSITE.



**ELECTRICAL BUILDING SERVICES CONSULTANTS**  
 BRISBANE  
 P.O. Box 15, Sherwood Q.4075  
 Phone: (07) 3278 4975  
 Fax: (07) 316 0222

**GOLD COAST CONSULTANTS**  
 P.O. Box 4286, Ashmore Q.4214  
 Phone: (07) 5587 7351  
 Fax: (07) 5587 7352

PROJECT:  
**RSPCA - WACOL**  
 WACOL STATION ROAD, WACOL

|      |              |            |
|------|--------------|------------|
| REV: | DESCRIPTION: | DATE:      |
| G    | CONSTRUCTION | 14/04/2011 |

DRAWING:  
**ELECTRICAL SERVICES BUILDING B LEVEL 1 REFLECTED CEILING PLAN**  
 SCALE: 1:100  
 PROJECT NO: **C0677a**  
 DRAWING NO: **E09**  
 REVISION: **G**

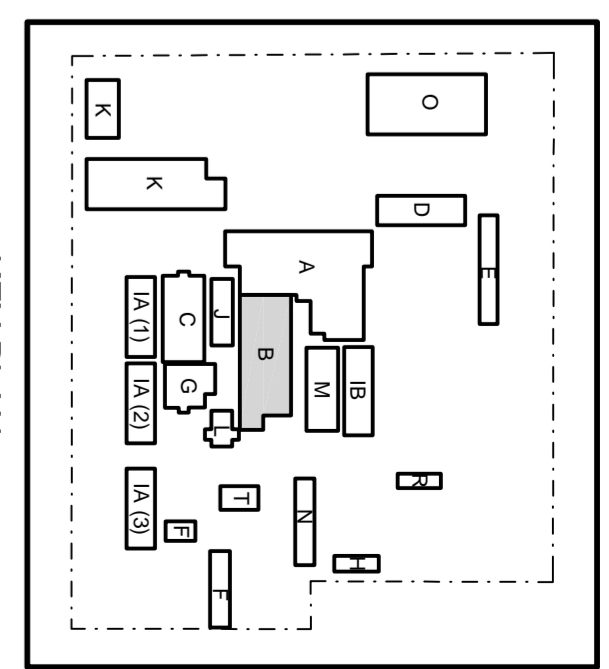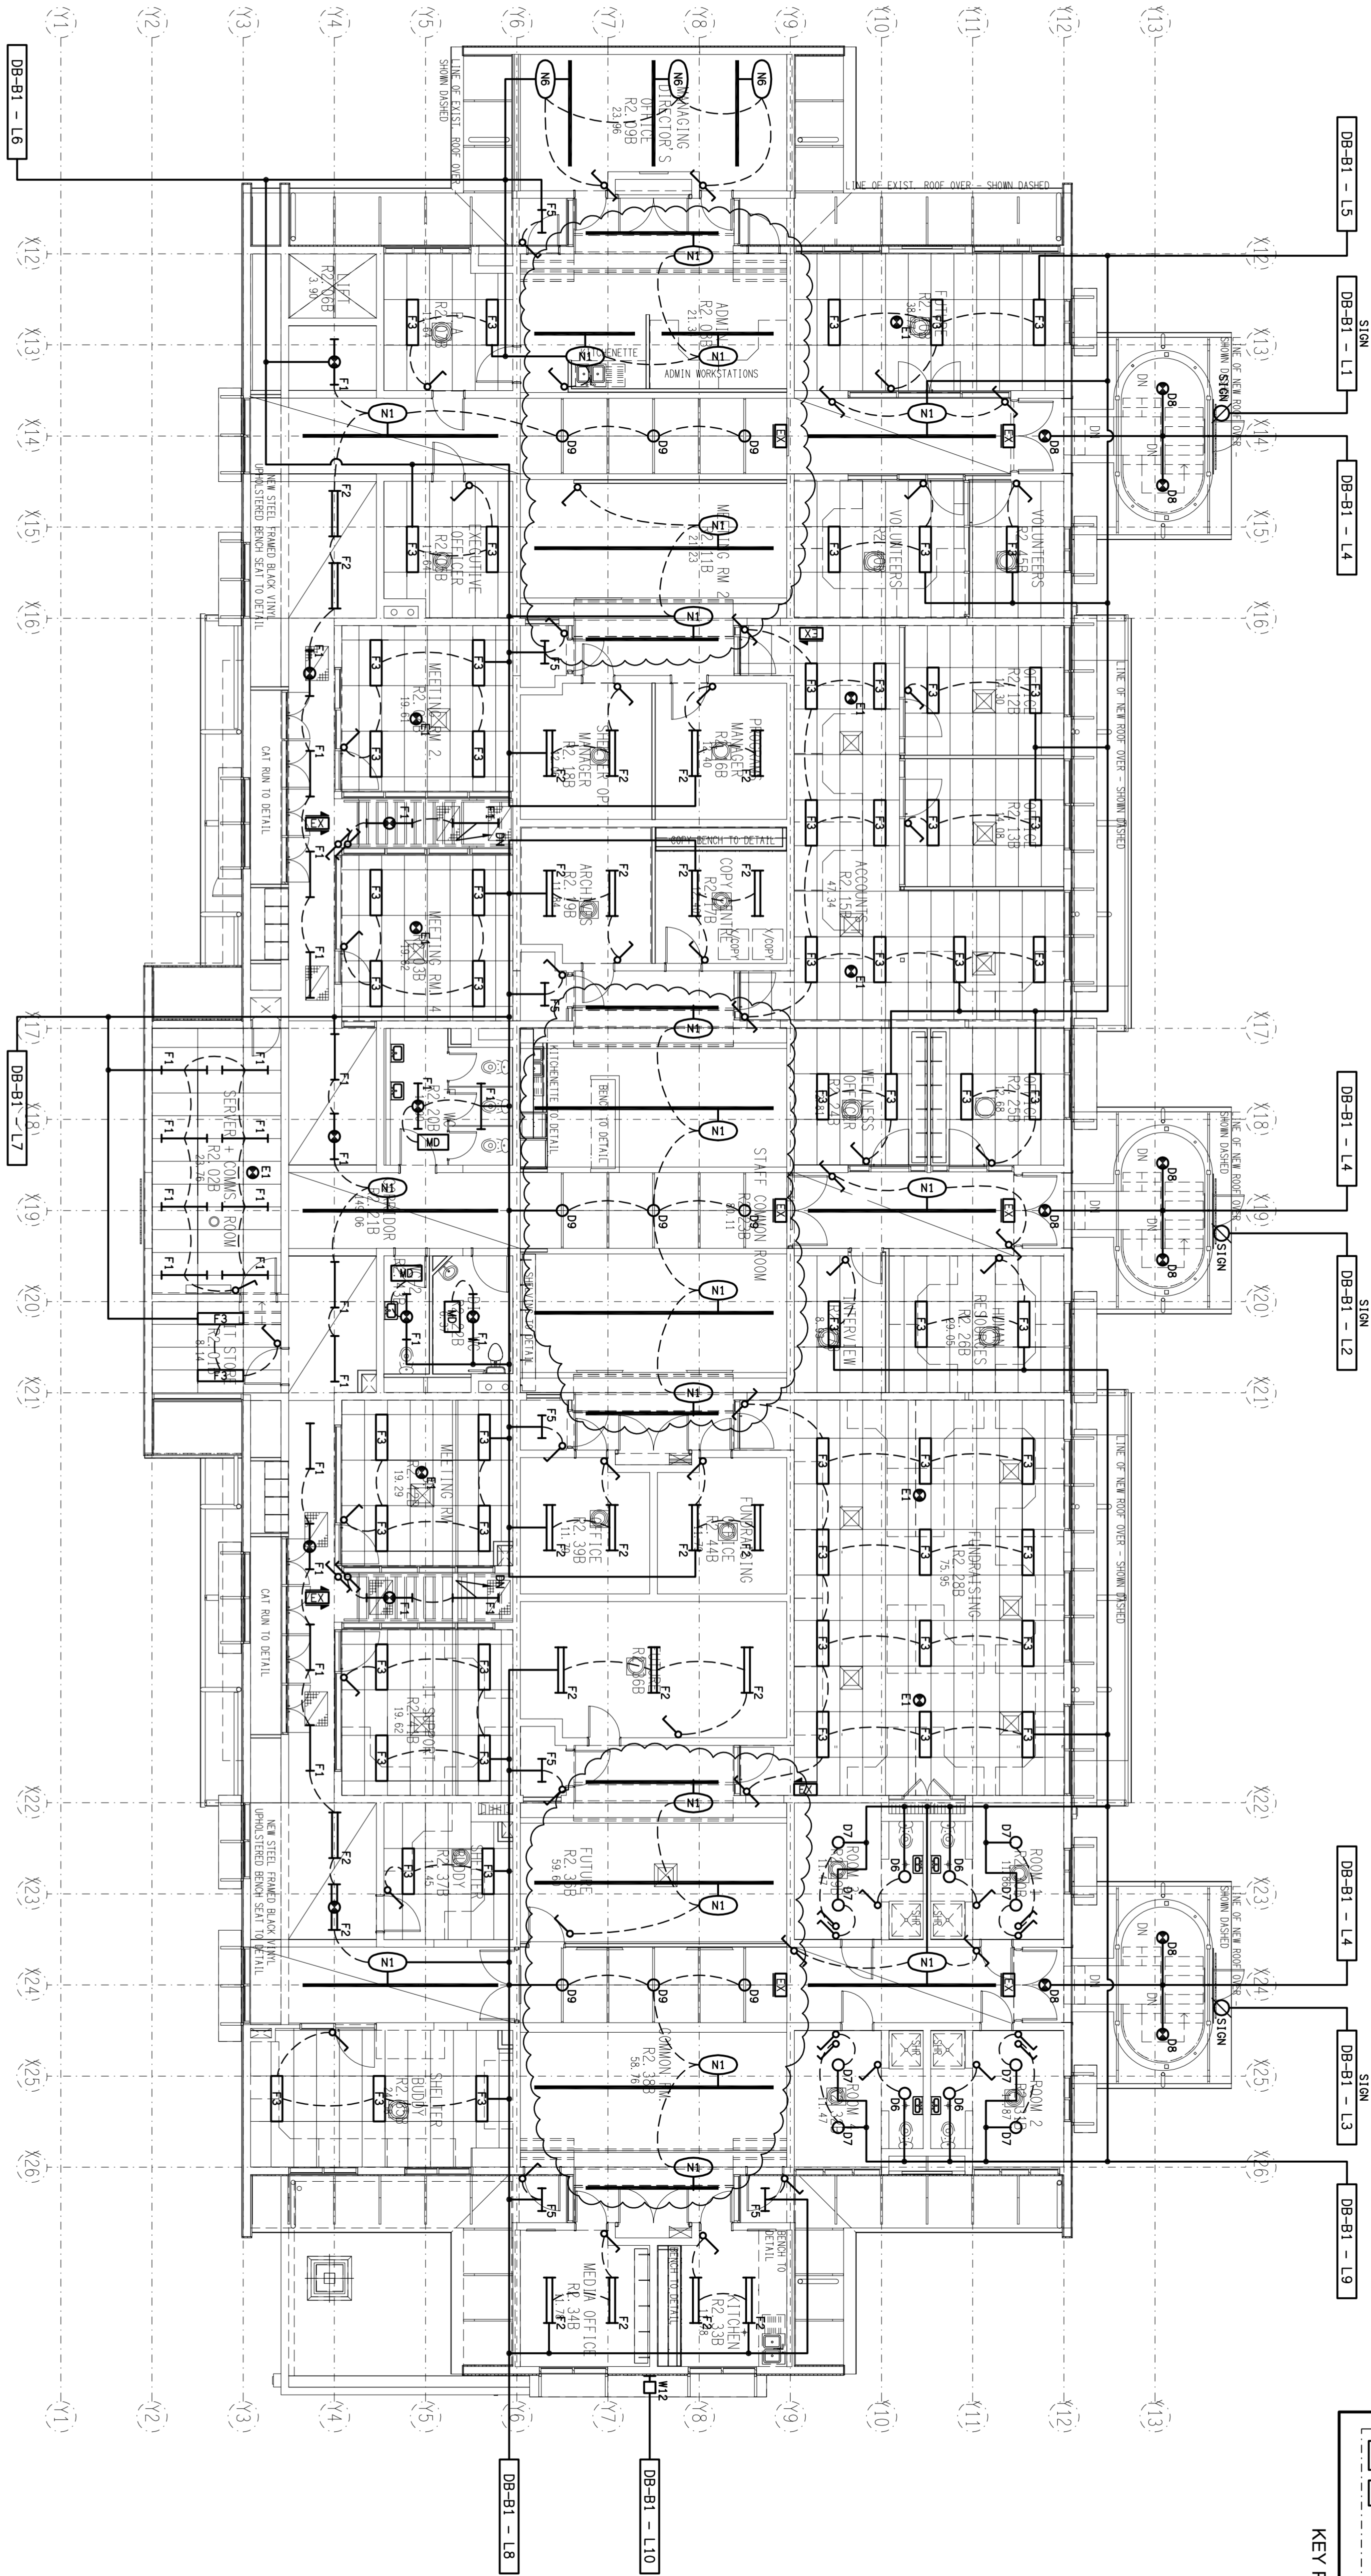

KEY PLAN