

ELECTRICAL DESIGN GROUP BRISBANE
 PROJECT NO. C0677a
 DRAWING NO. E10
 TRADING AS
 ELECTRICAL DESIGN GROUP

THE COPYRIGHT OF THIS DRAWING
 REMAINS THE PROPERTY OF THE
 ELECTRICAL DESIGN GROUP.
 USE FIGURED DIMENSIONS
 IN PREFERENCE TO SCALE.
 ALL DIMENSIONS TO BE
 VERIFIED ONSITE.





ELECTRICAL DESIGN GROUP
 BUILDING SERVICES CONSULTANTS
 BRISBANE
 P.O. Box 15, Sherwood Q.4075
 Phone: (07) 5597 7551
 Fax: (07) 316 0222

ELECTRICAL DESIGN GROUP
 BUILDING SERVICES CONSULTANTS
 GOLD COAST
 P.O. Box 4249, Ashmore Q.4214
 Phone: (07) 5597 7551
 Fax: (07) 5597 7552

PROJECT:
RSPCA - WACOL
 WACOL STATION ROAD, WACOL

DRAWING:
ELECTRICAL SERVICES
FLOOR PLAN & REFLECTED CEILING PLAN
 SCALE: 1:100 UNO
 AT A1
C0677a E10
 PROJECT NO. DRAWING NO.
 REVISION: J

DATE: 10/08/2011

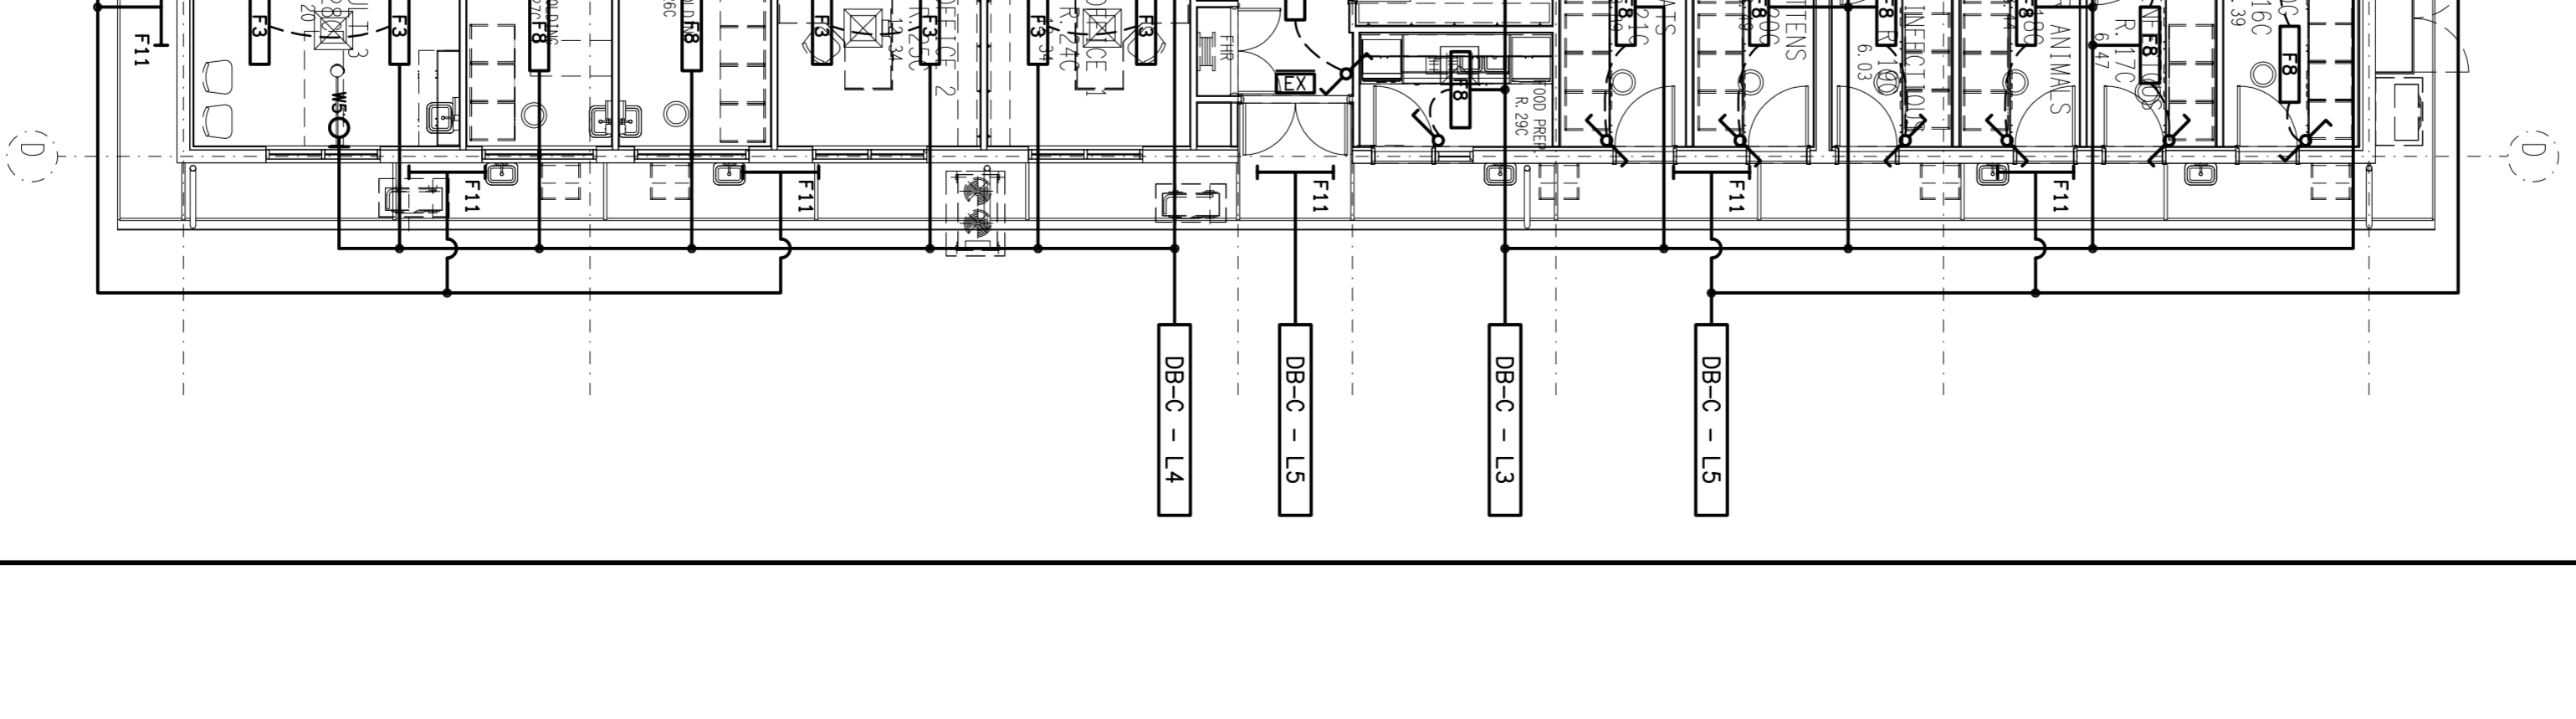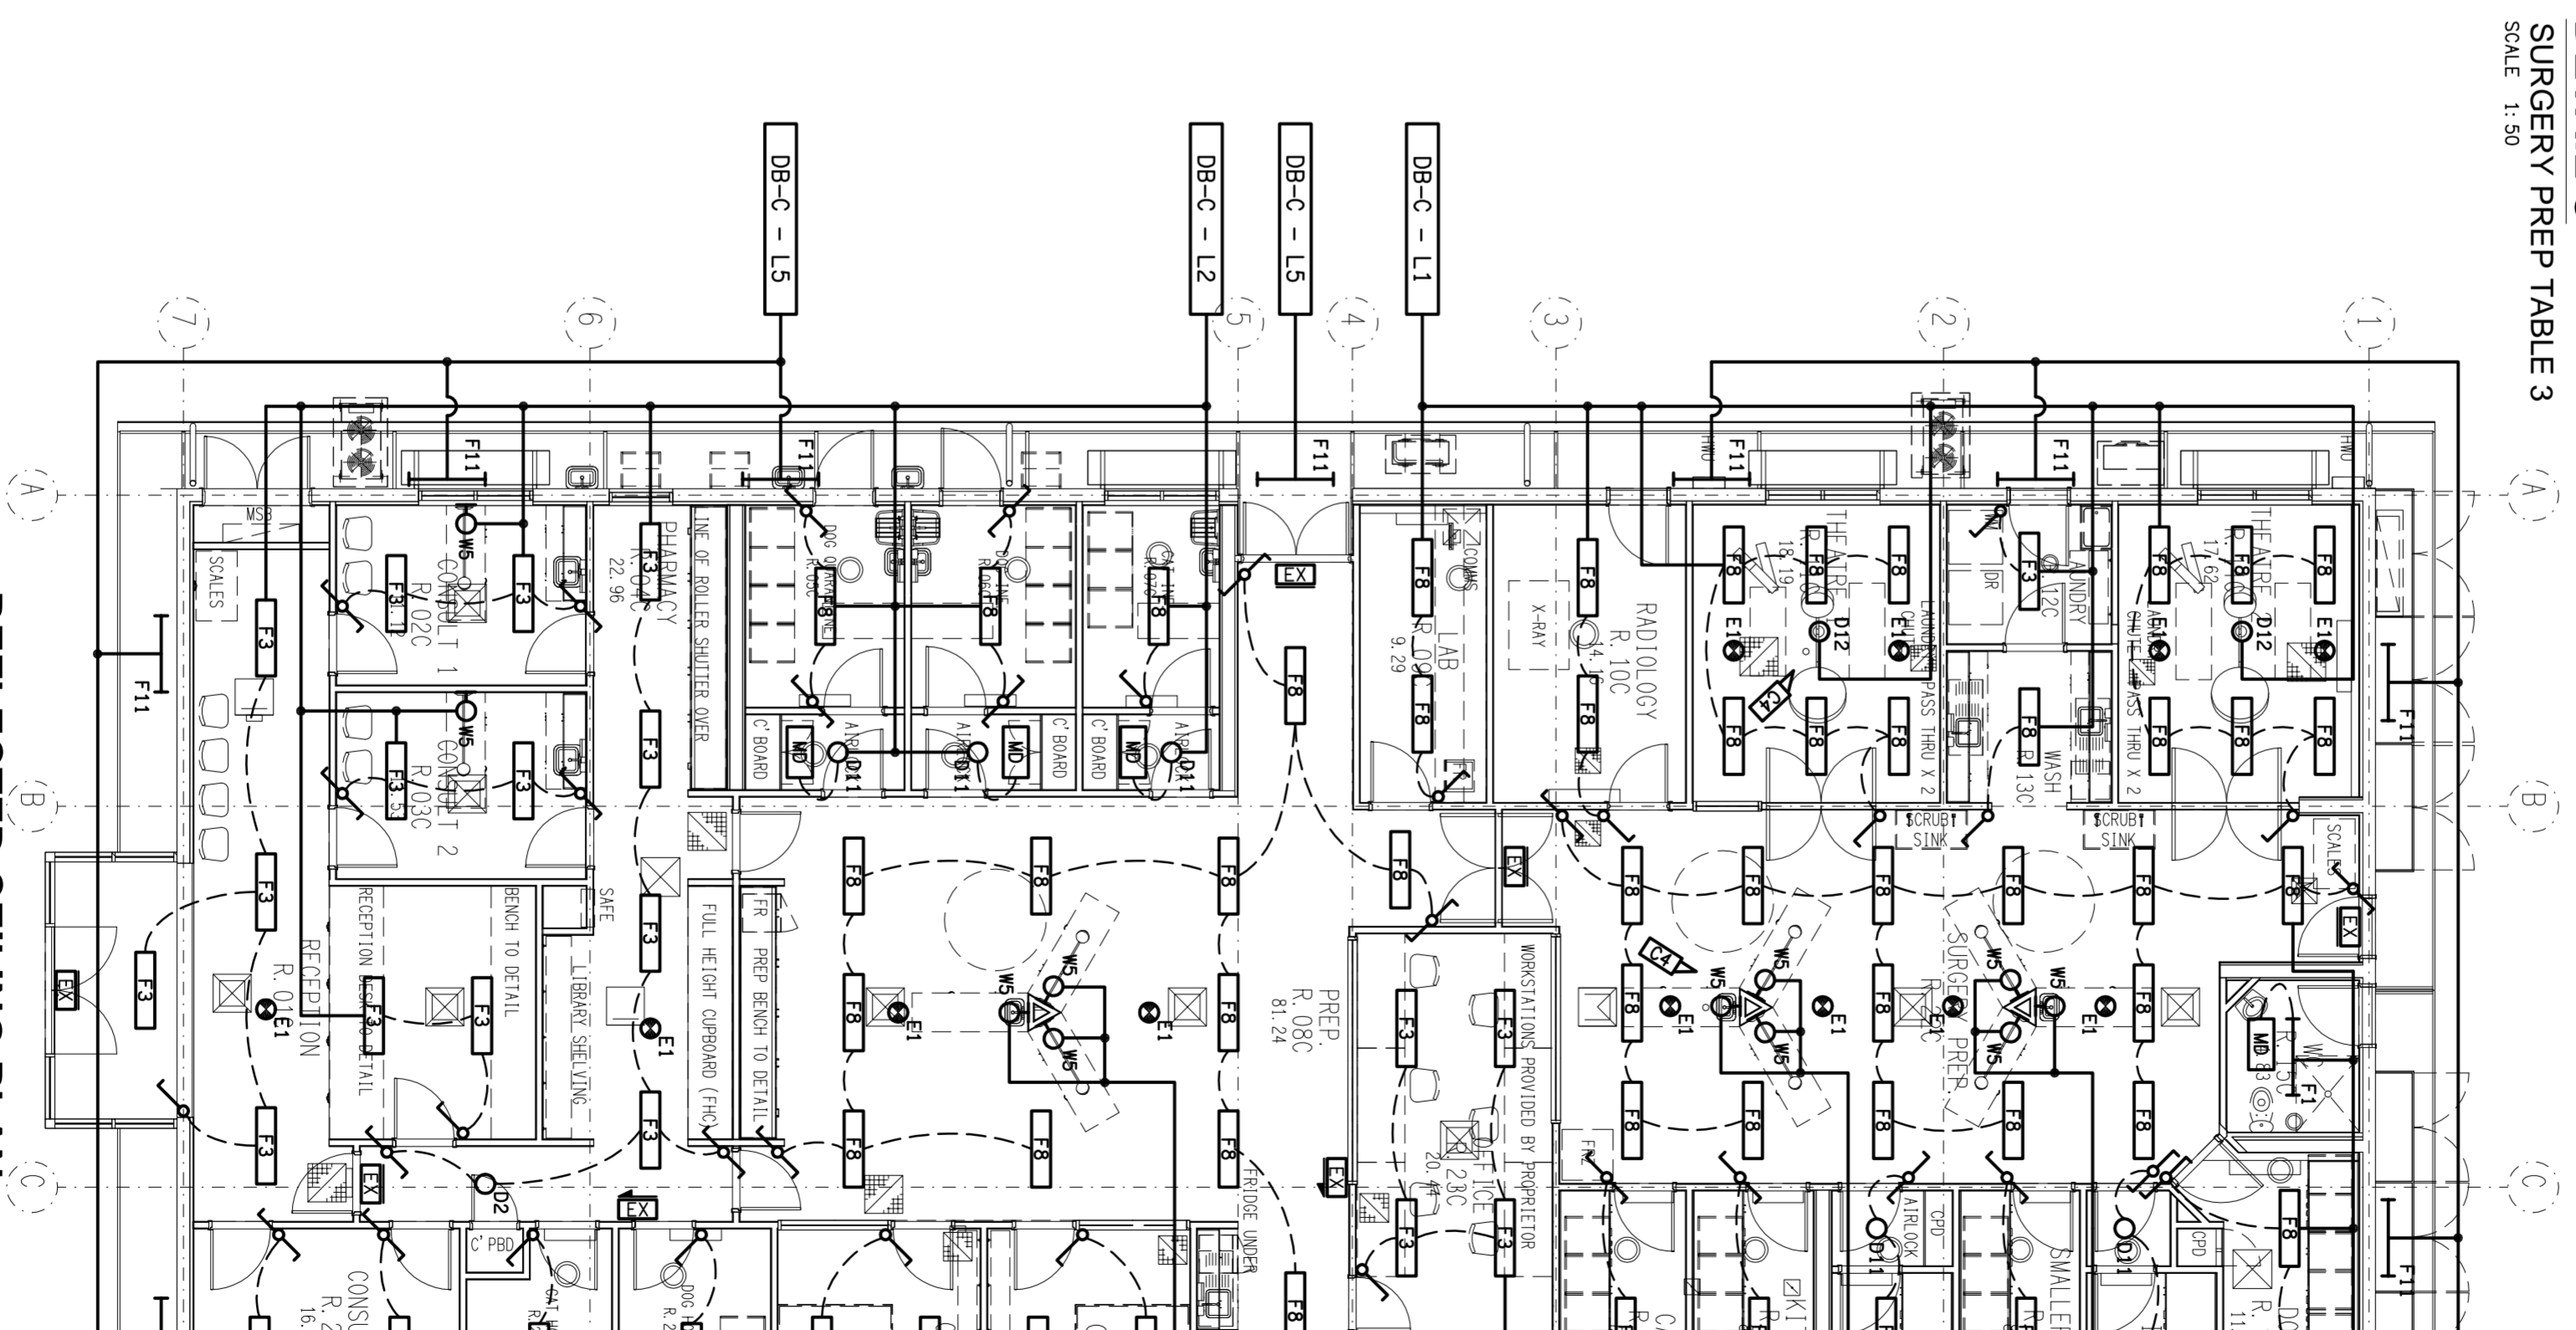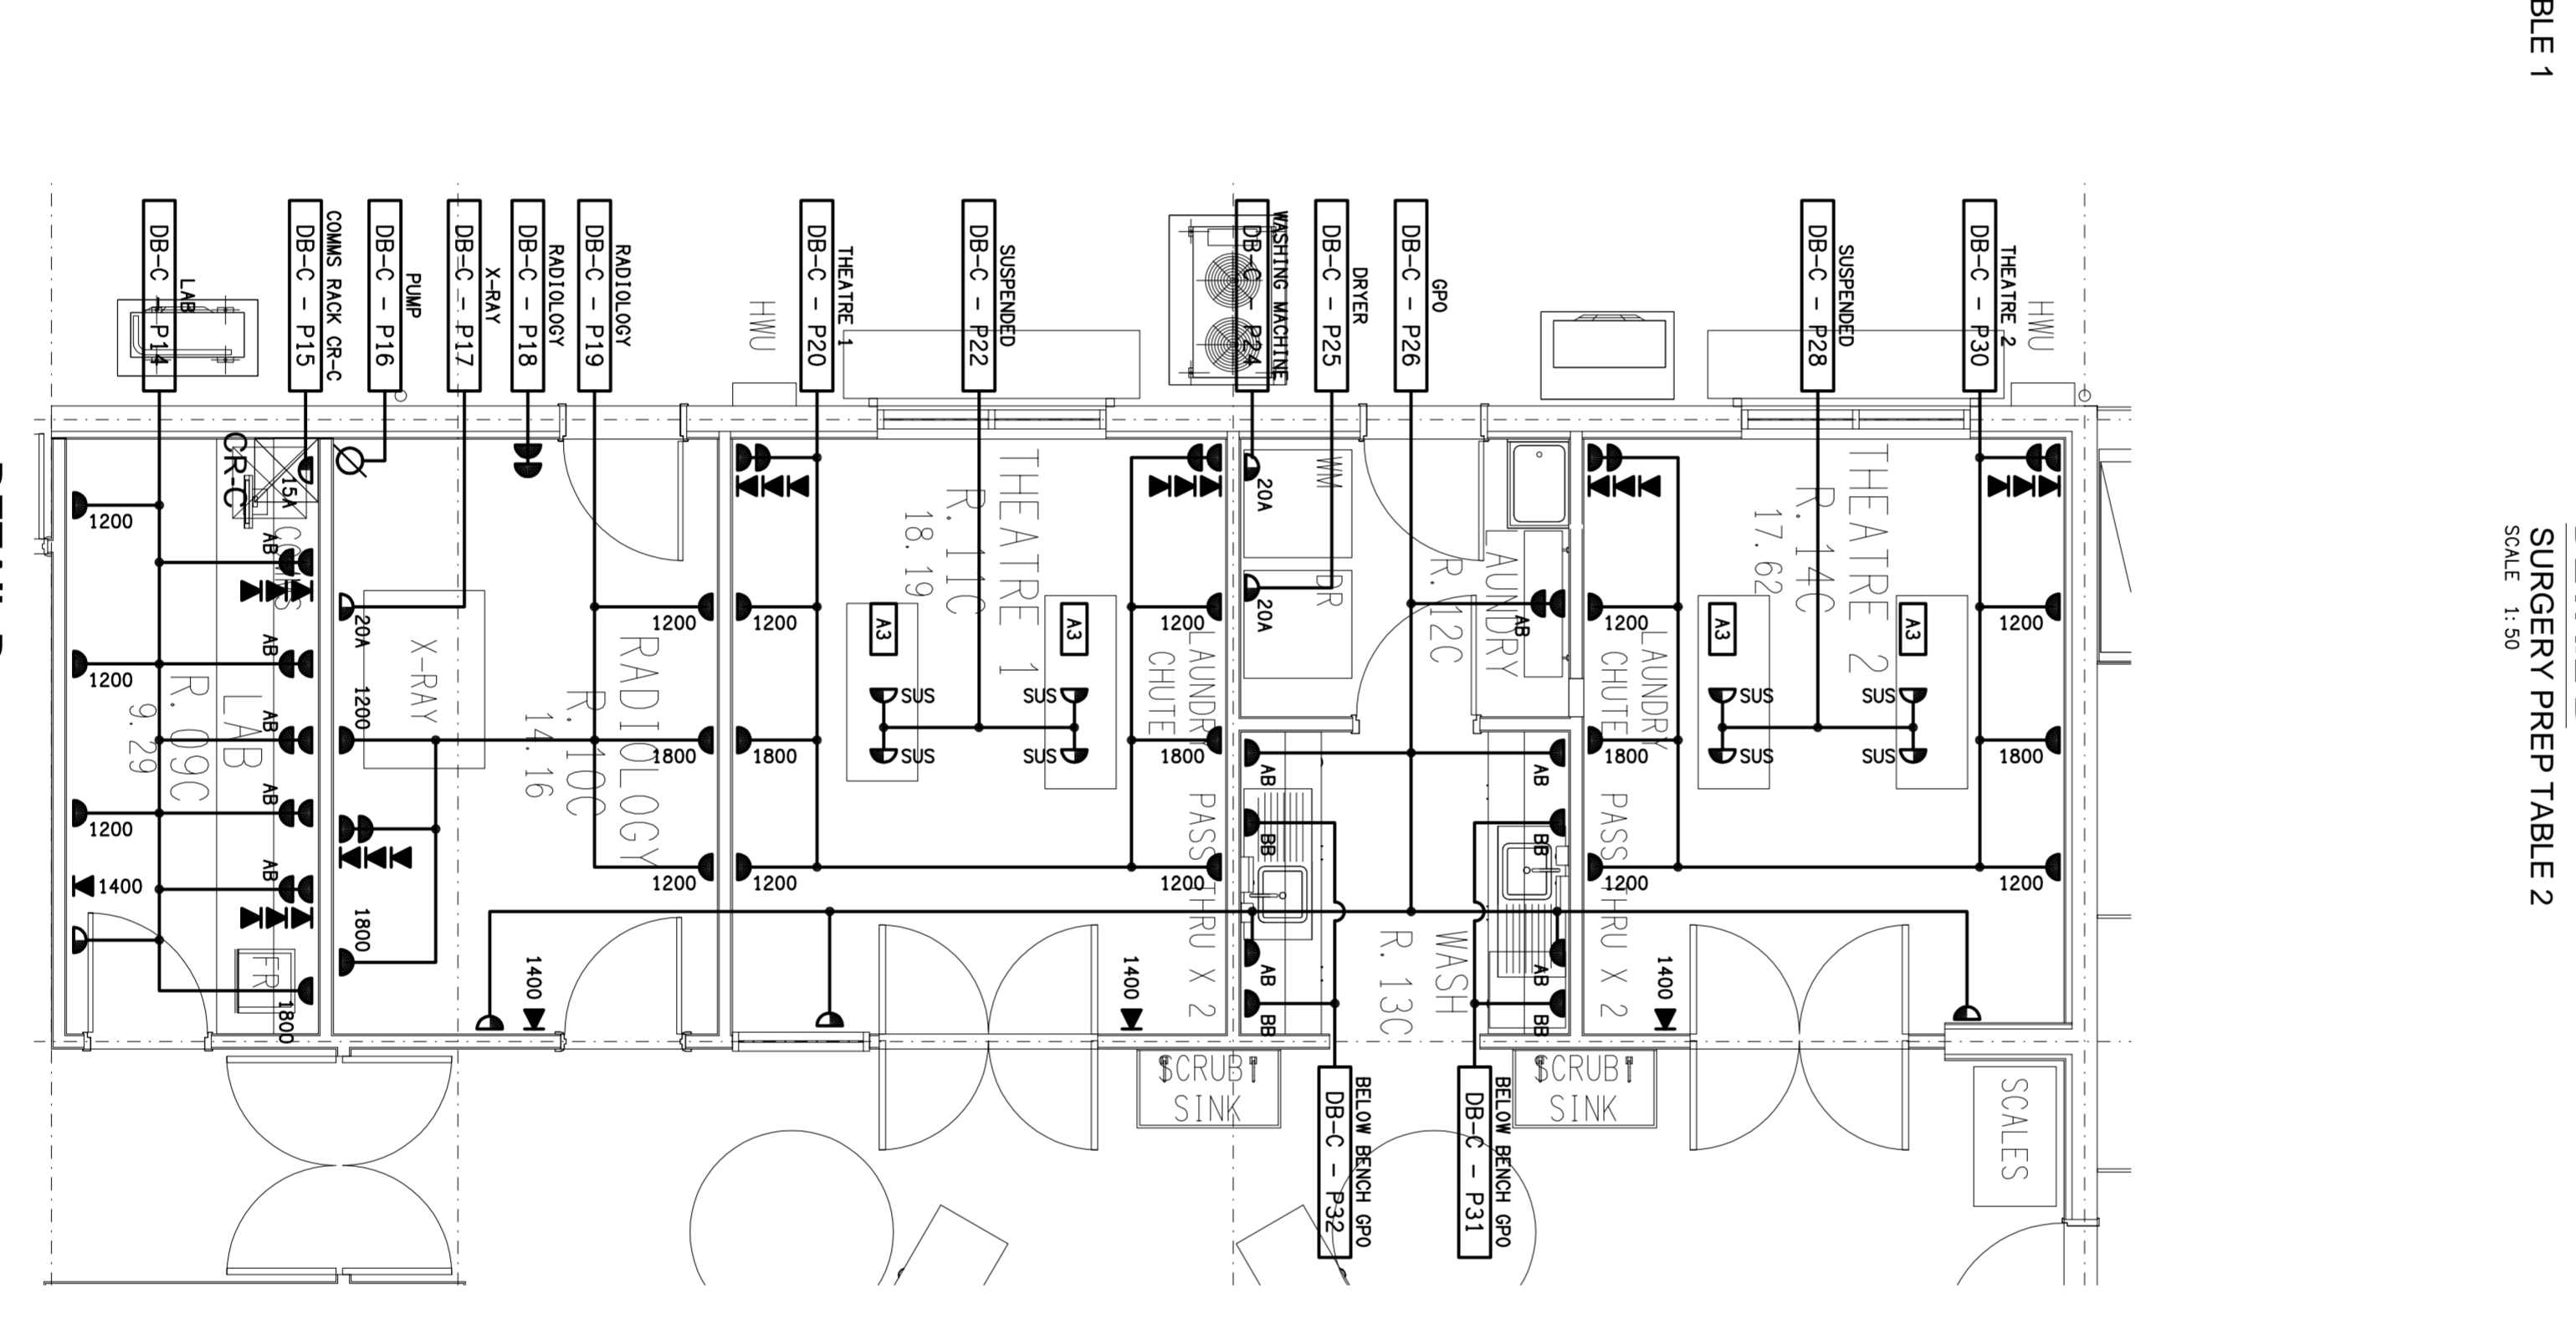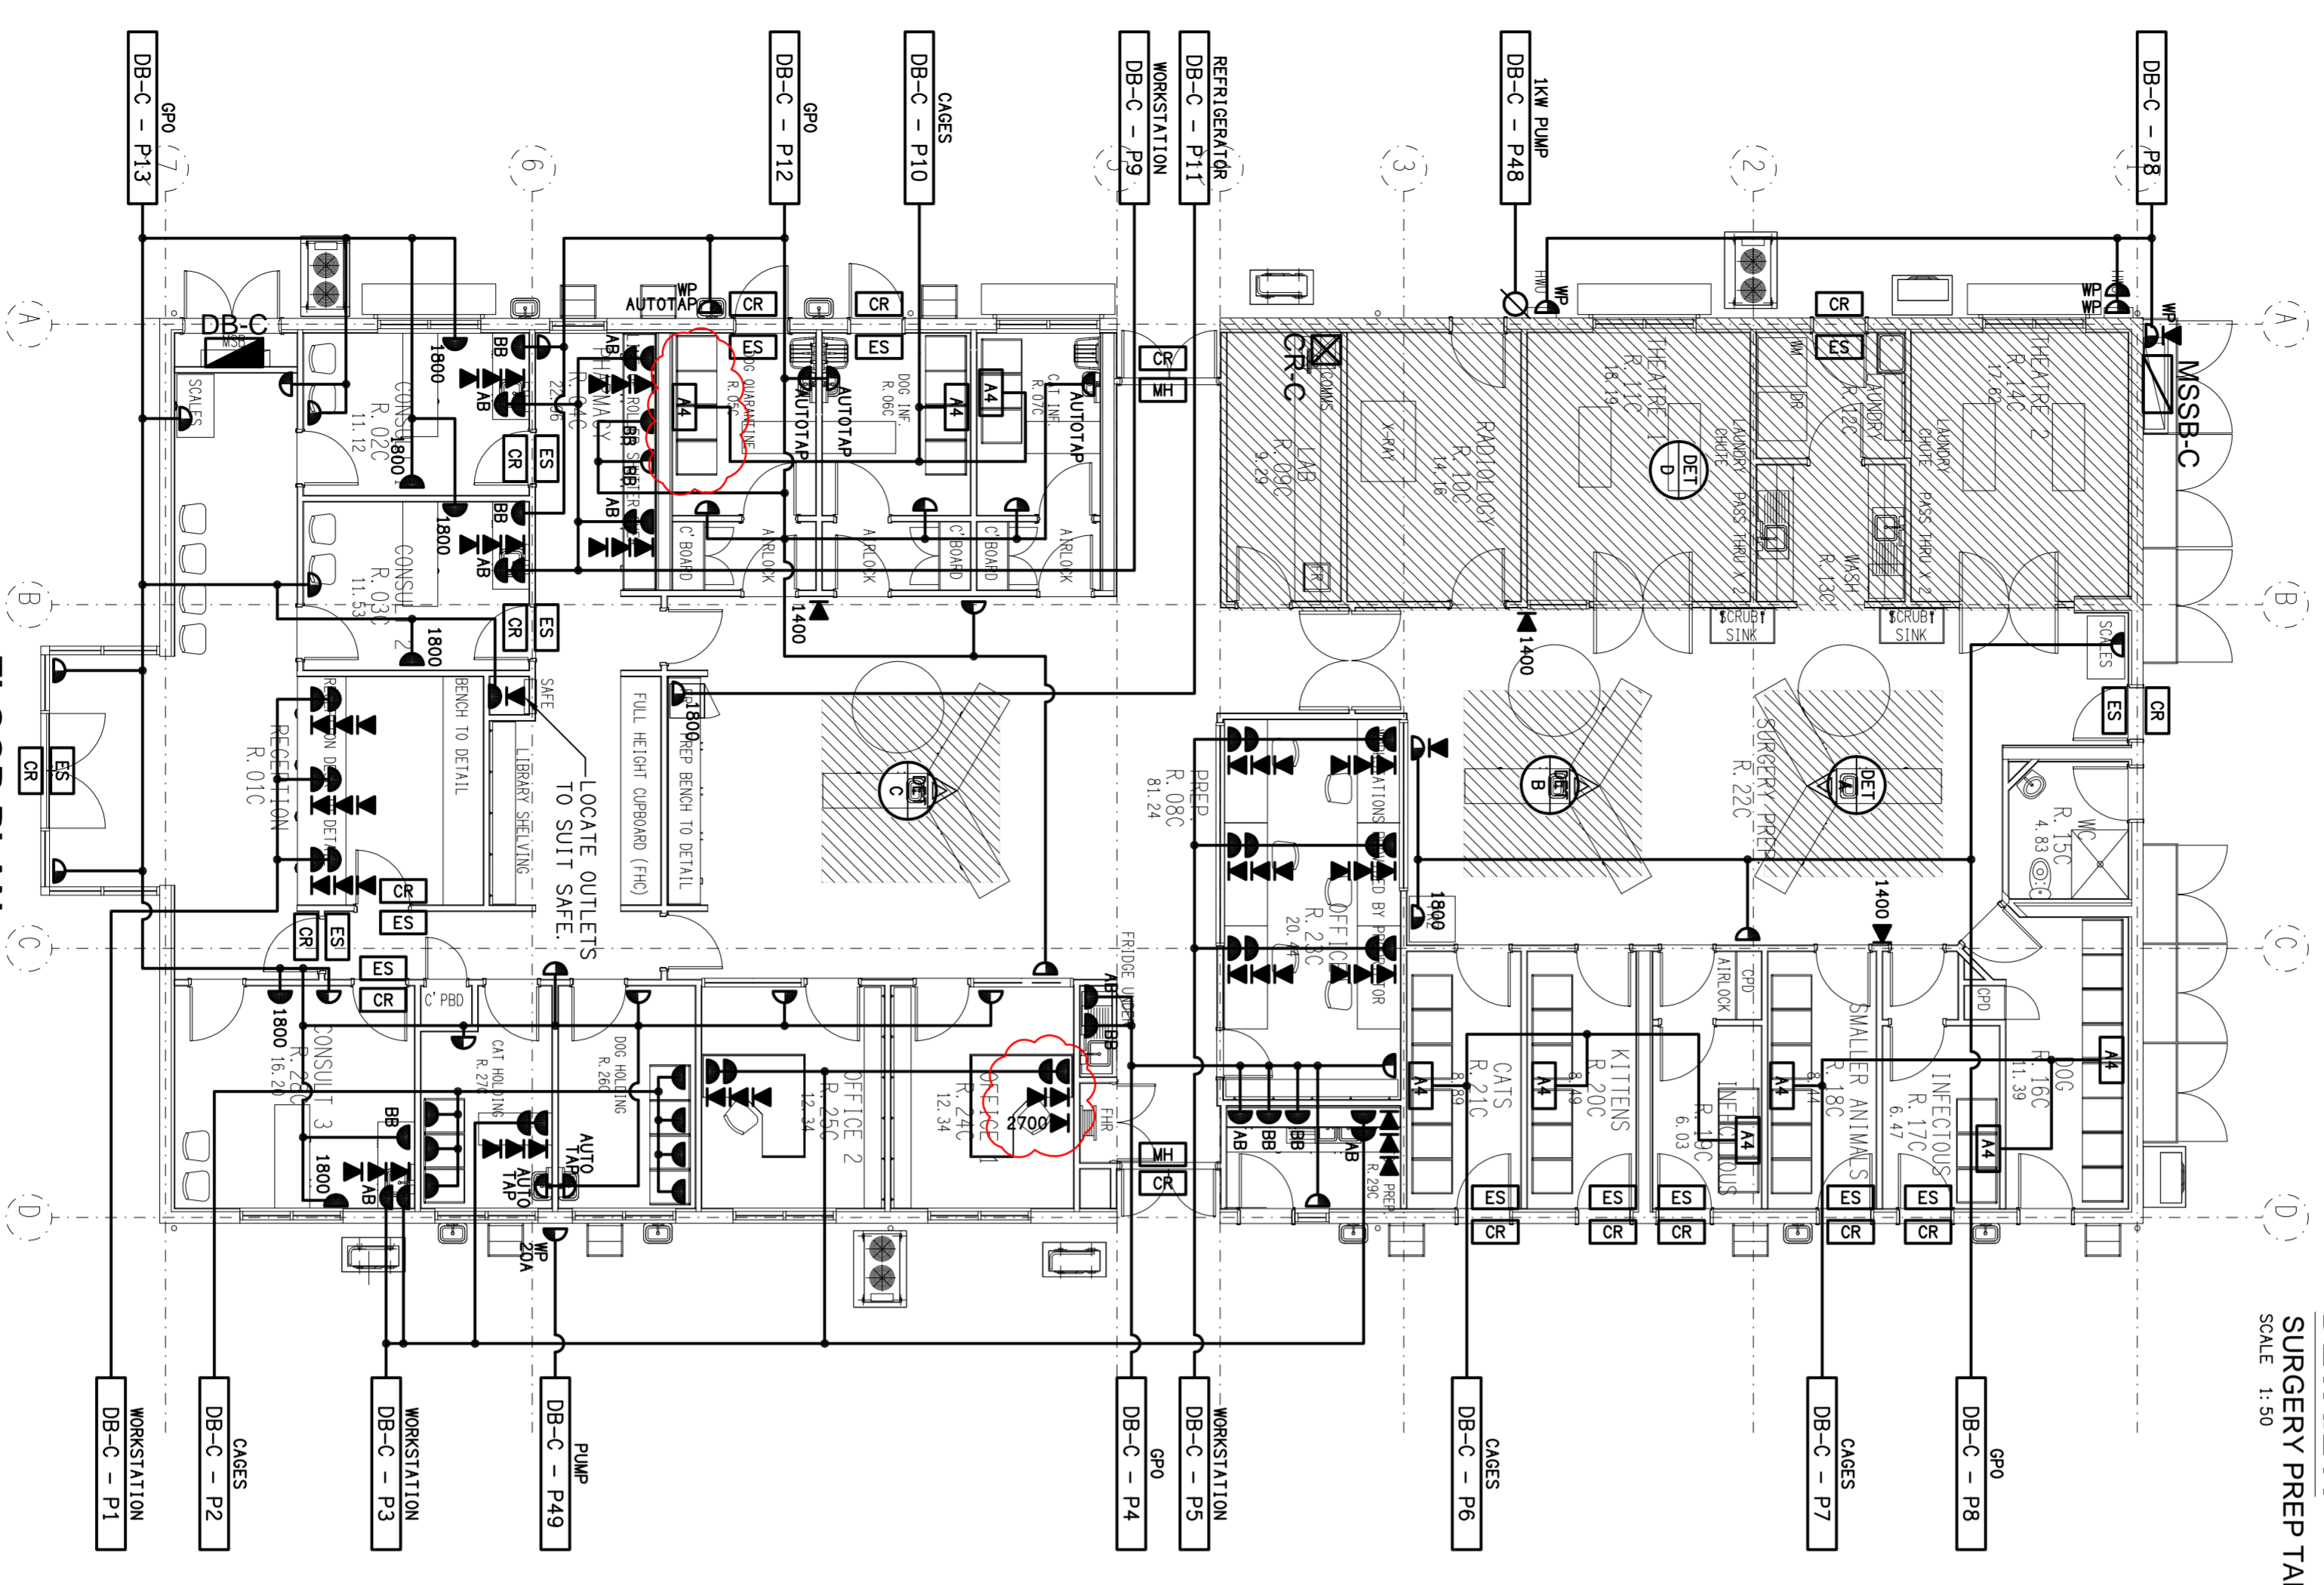

REV.	DESCRIPTION	DATE
J	CONSTRUCTION	10/08/2011

REVISIONS

DATE: 10/08/2011