




BUILDING IA BLOCK 1
PART FLOOR PLAN
SCALE: 1:100

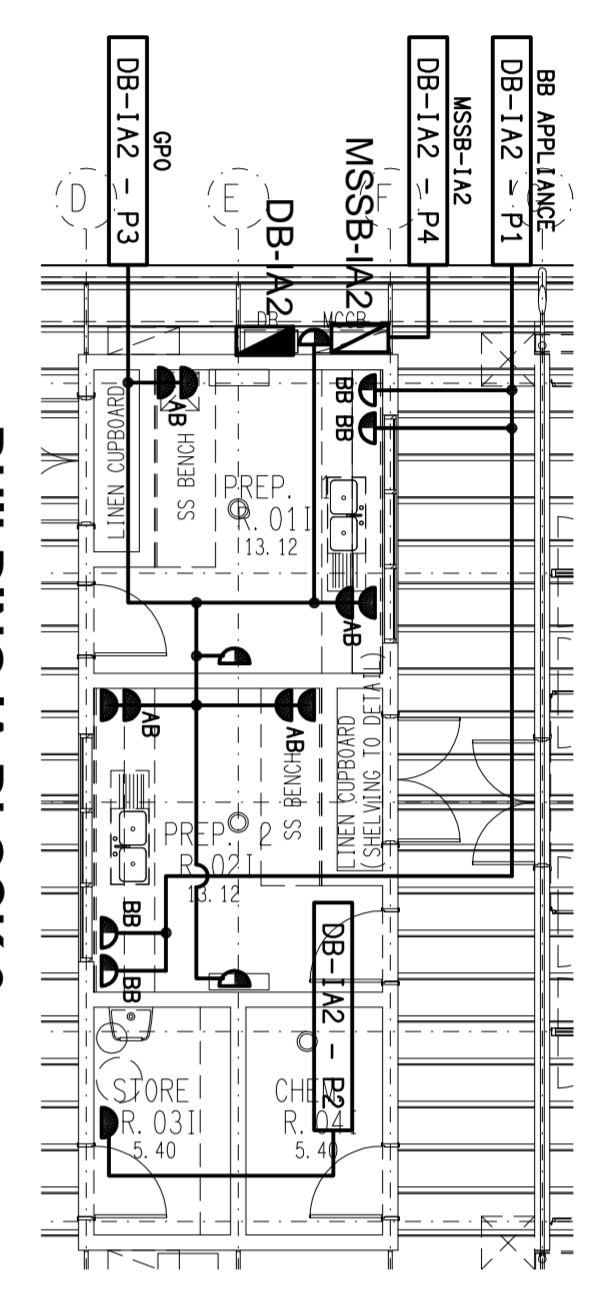


BUILDING IA BLOCK 2
PART FLOOR PLAN
SCALE: 1:100

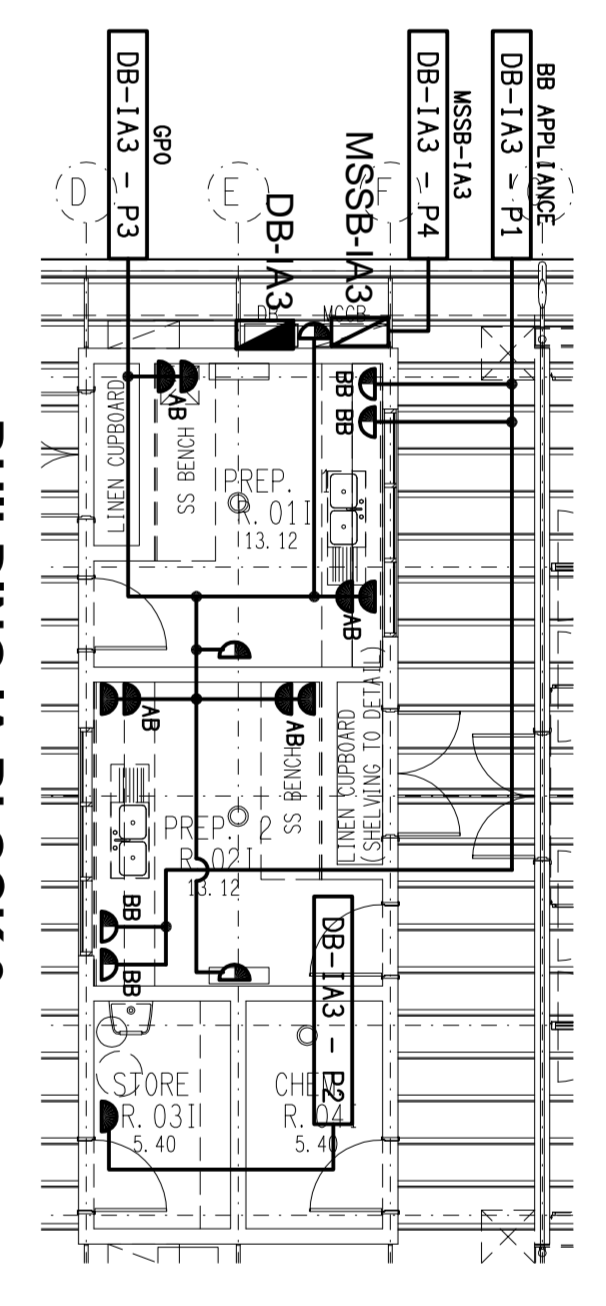


BUILDING IA BLOCK 3
PART FLOOR PLAN
SCALE: 1:100

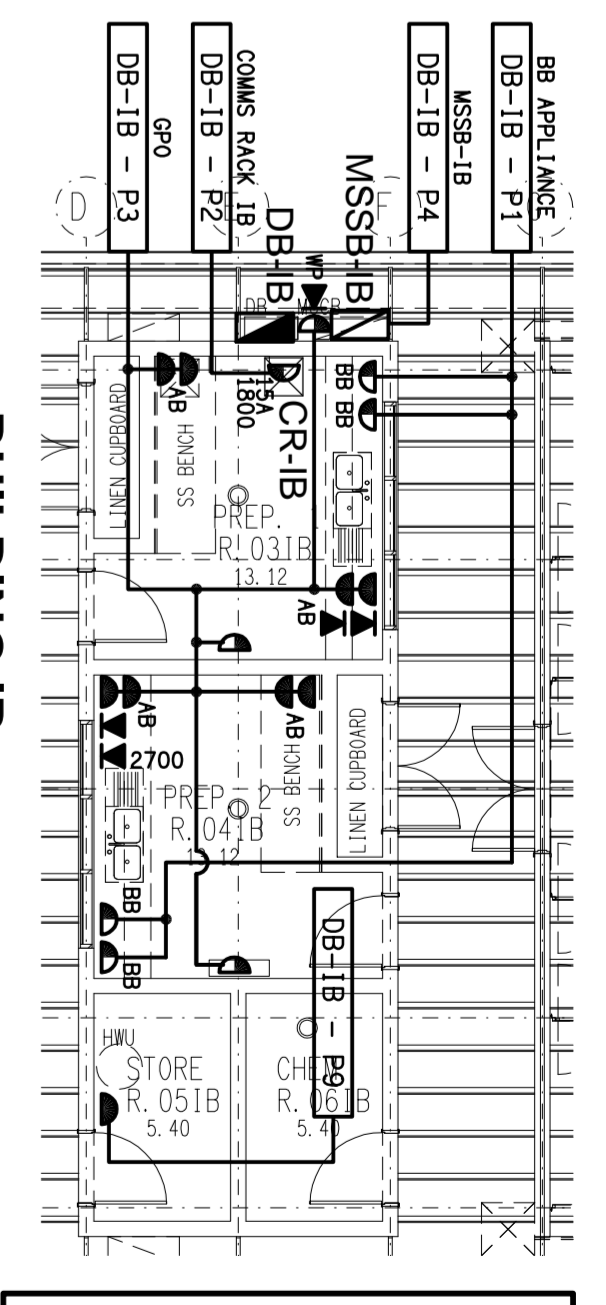


BUILDING IB
PART FLOOR PLAN
SCALE: 1:100

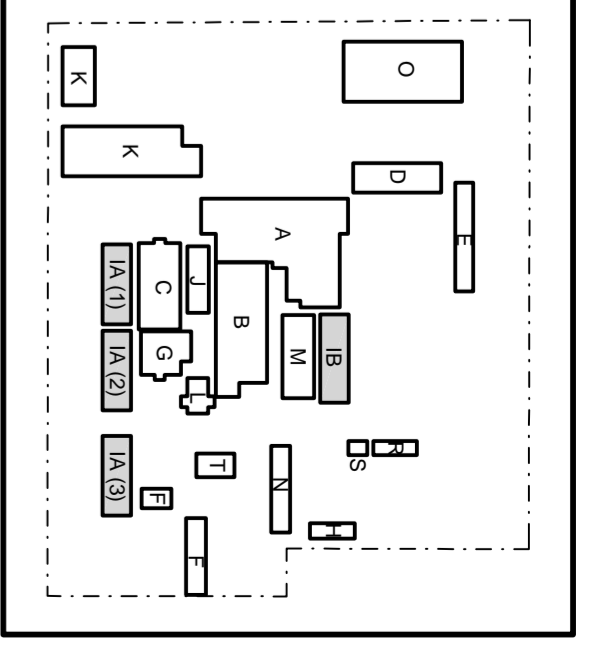


KEY PLAN

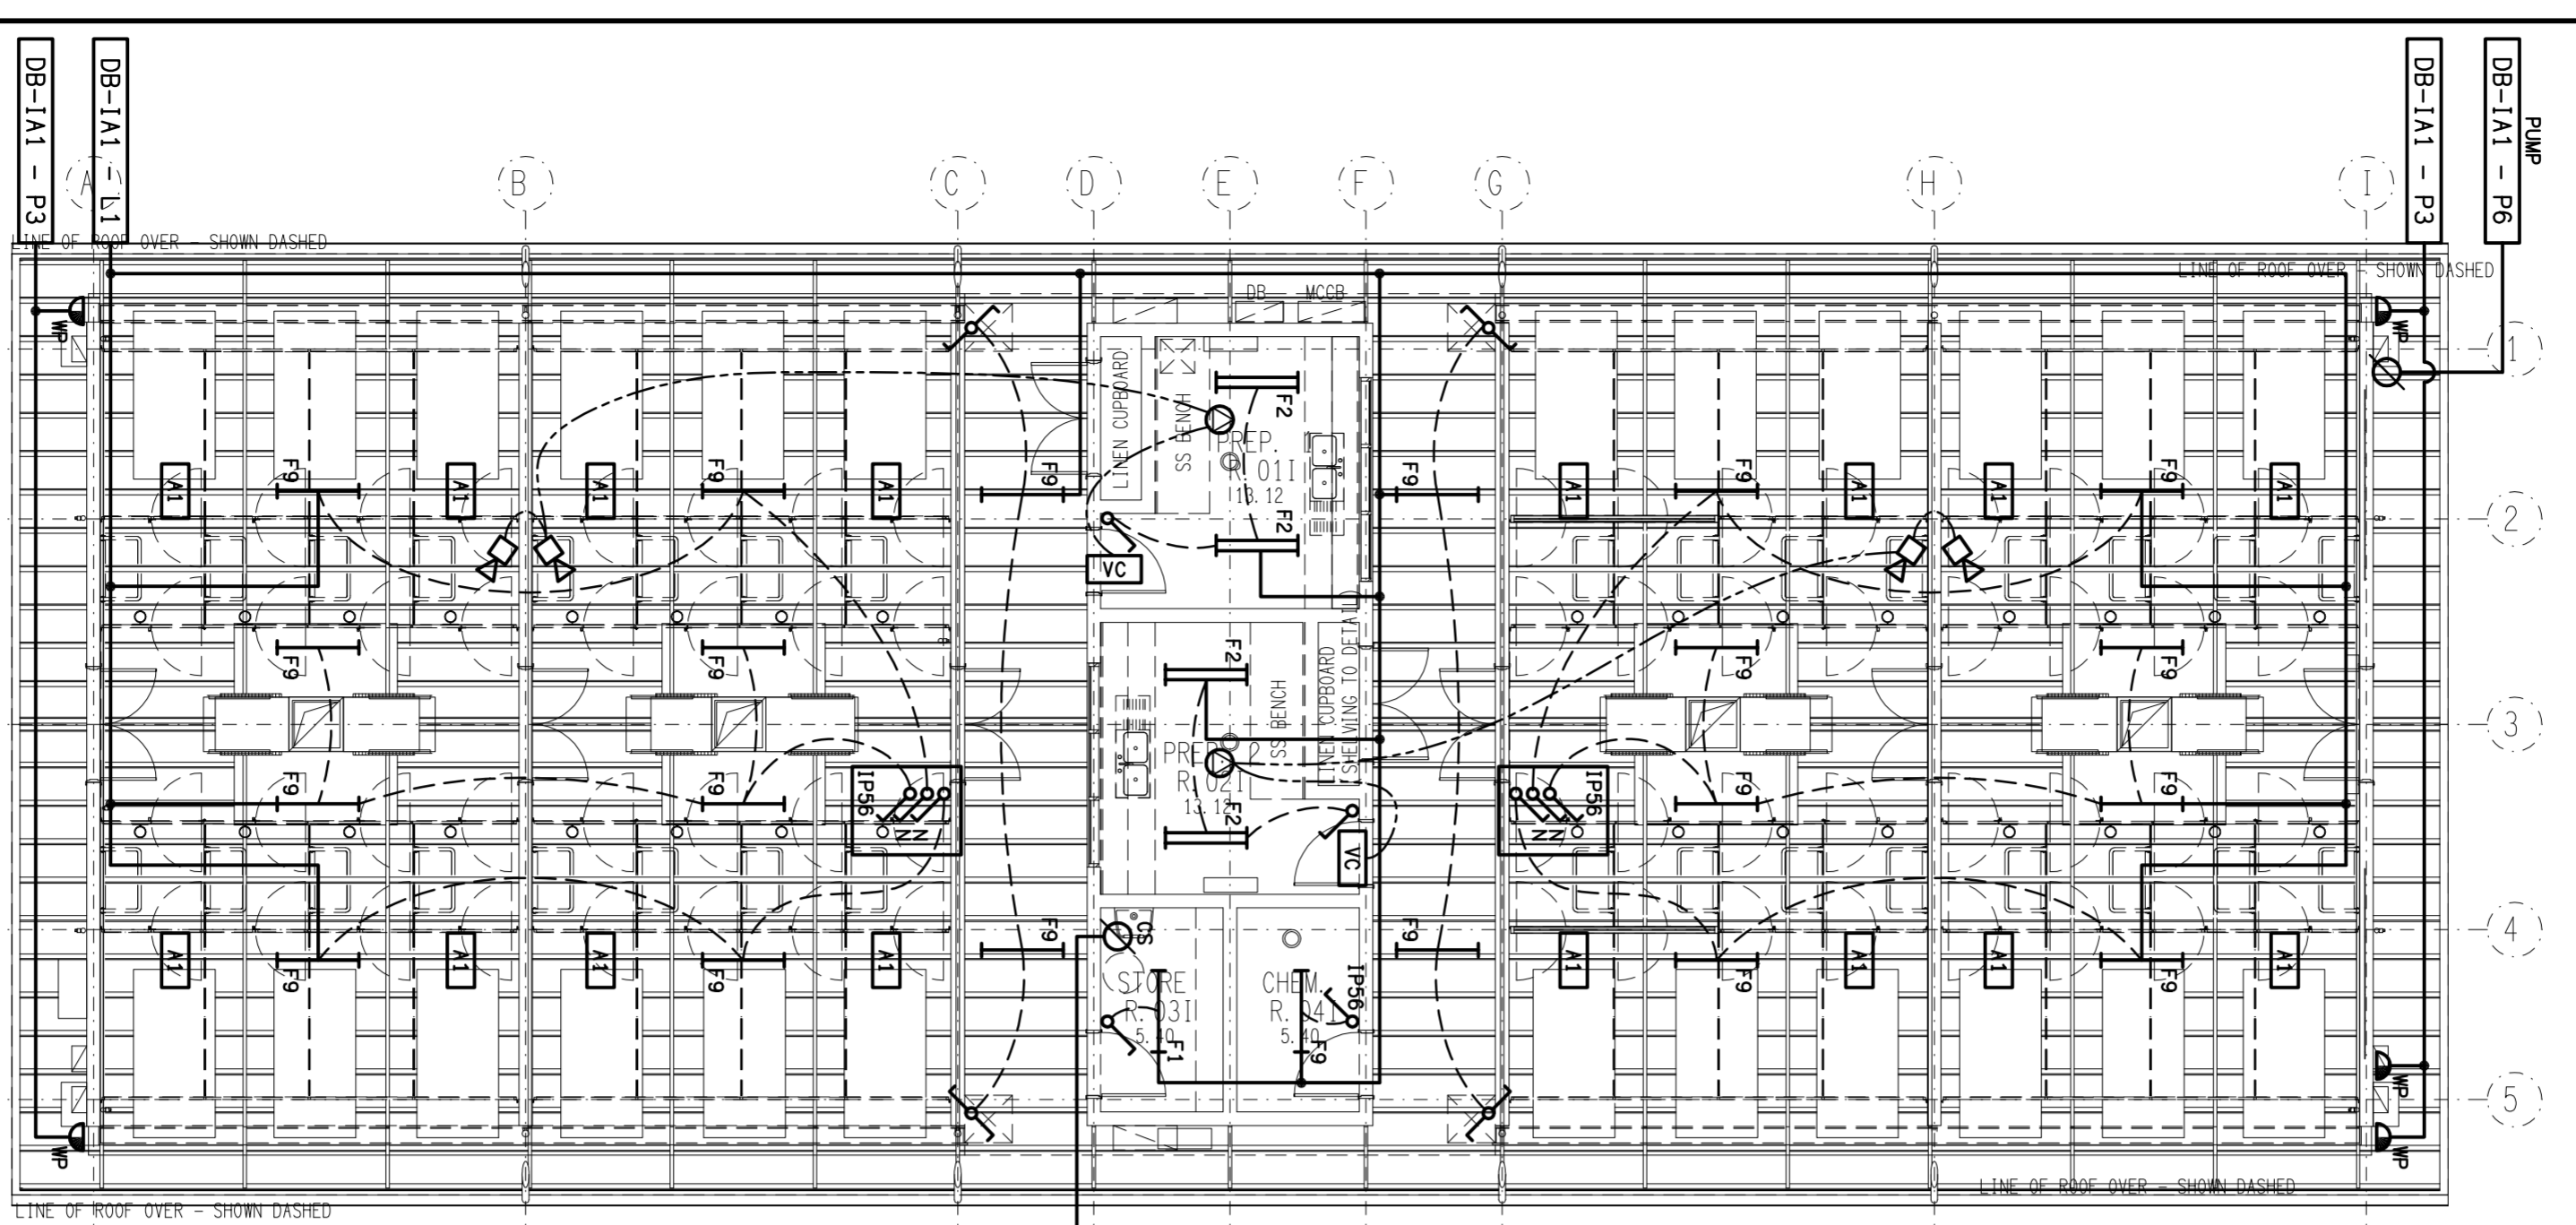


BUILDING IA BLOCK 1
REFLECTED CEILING PLAN
SCALE: 1:100

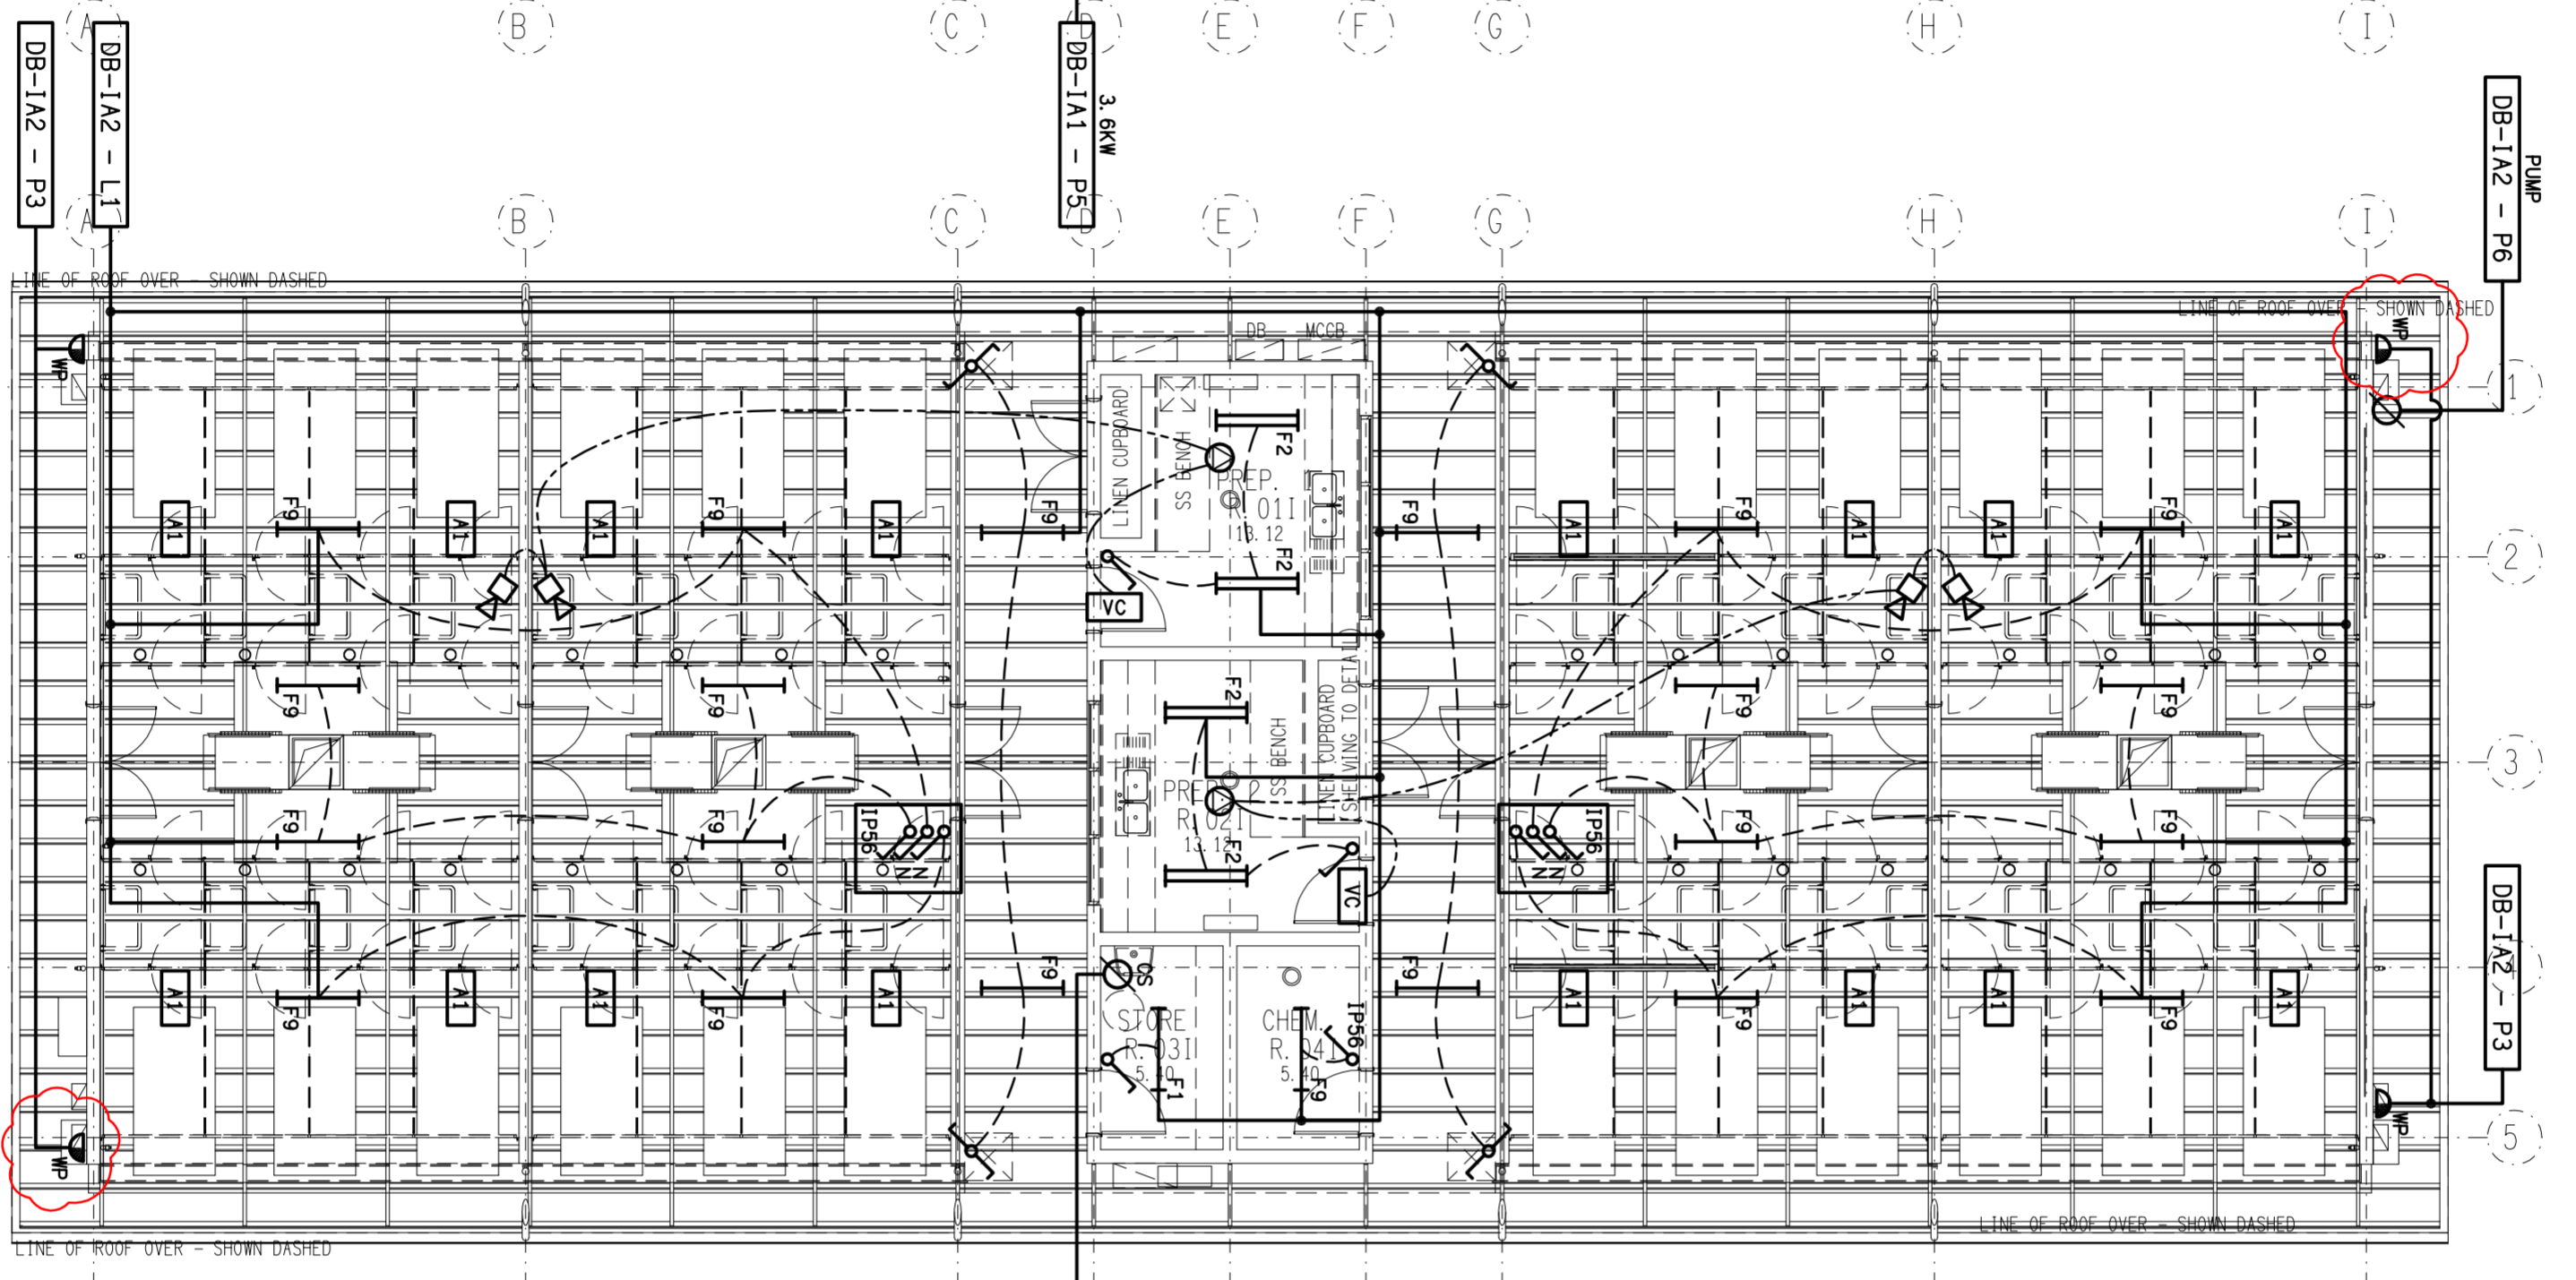

BUILDING IA BLOCK 2
REFLECTED CEILING PLAN
SCALE: 1:100

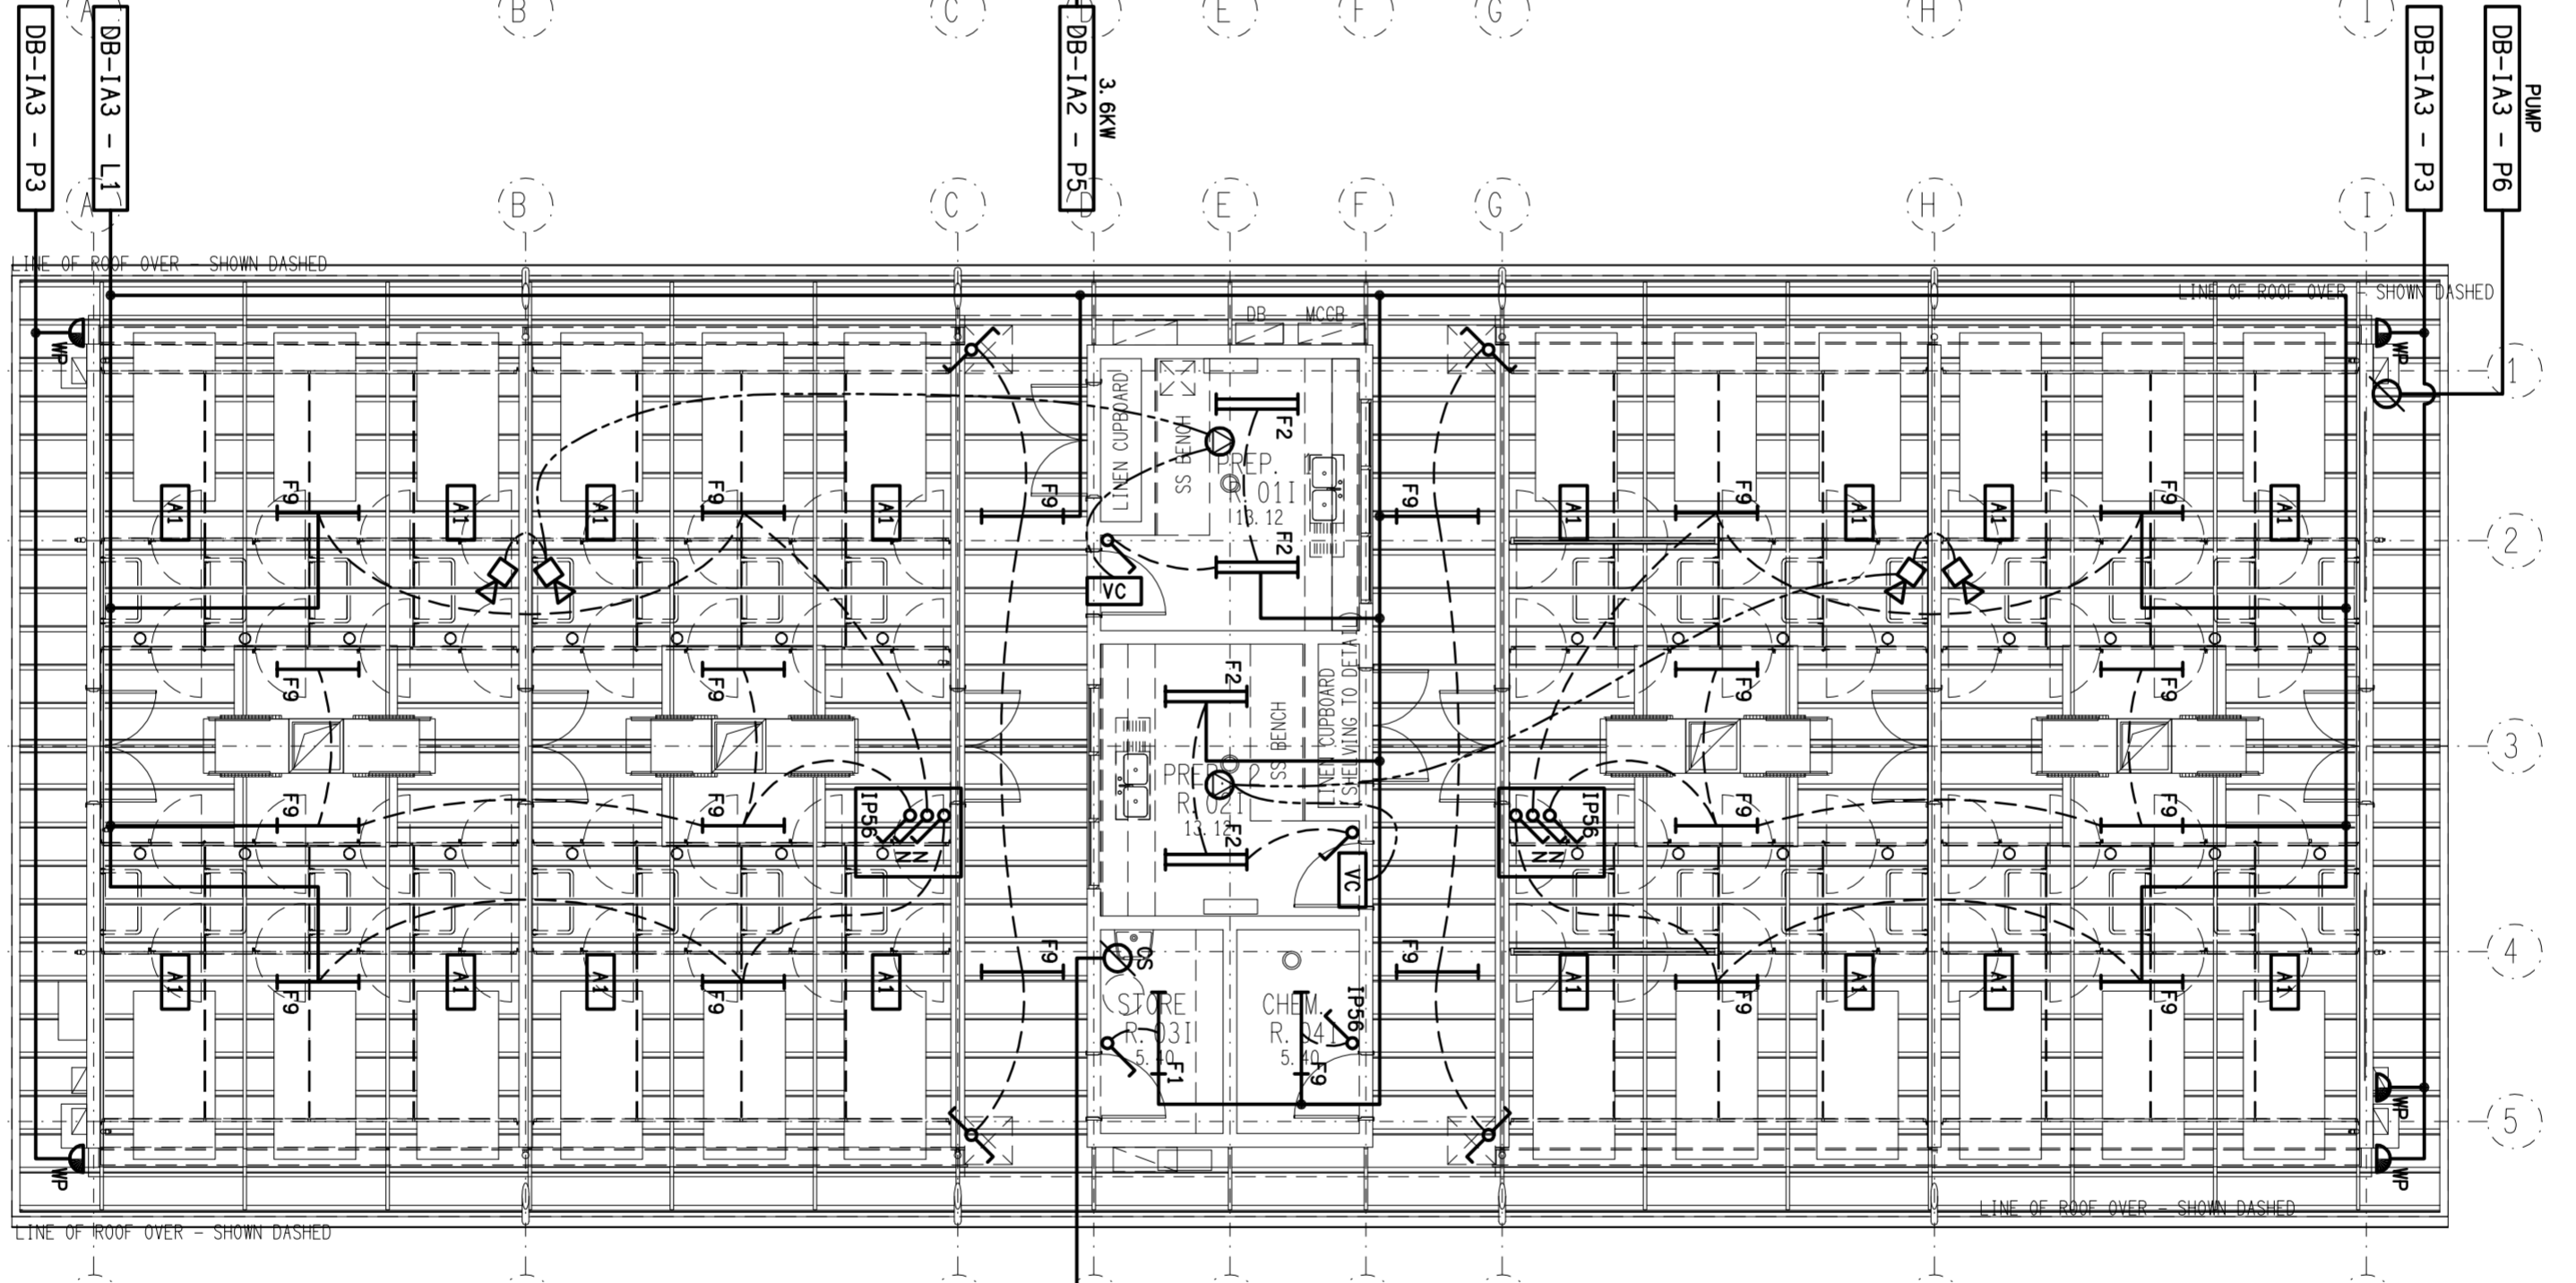

BUILDING IA BLOCK 3
REFLECTED CEILING PLAN
SCALE: 1:100

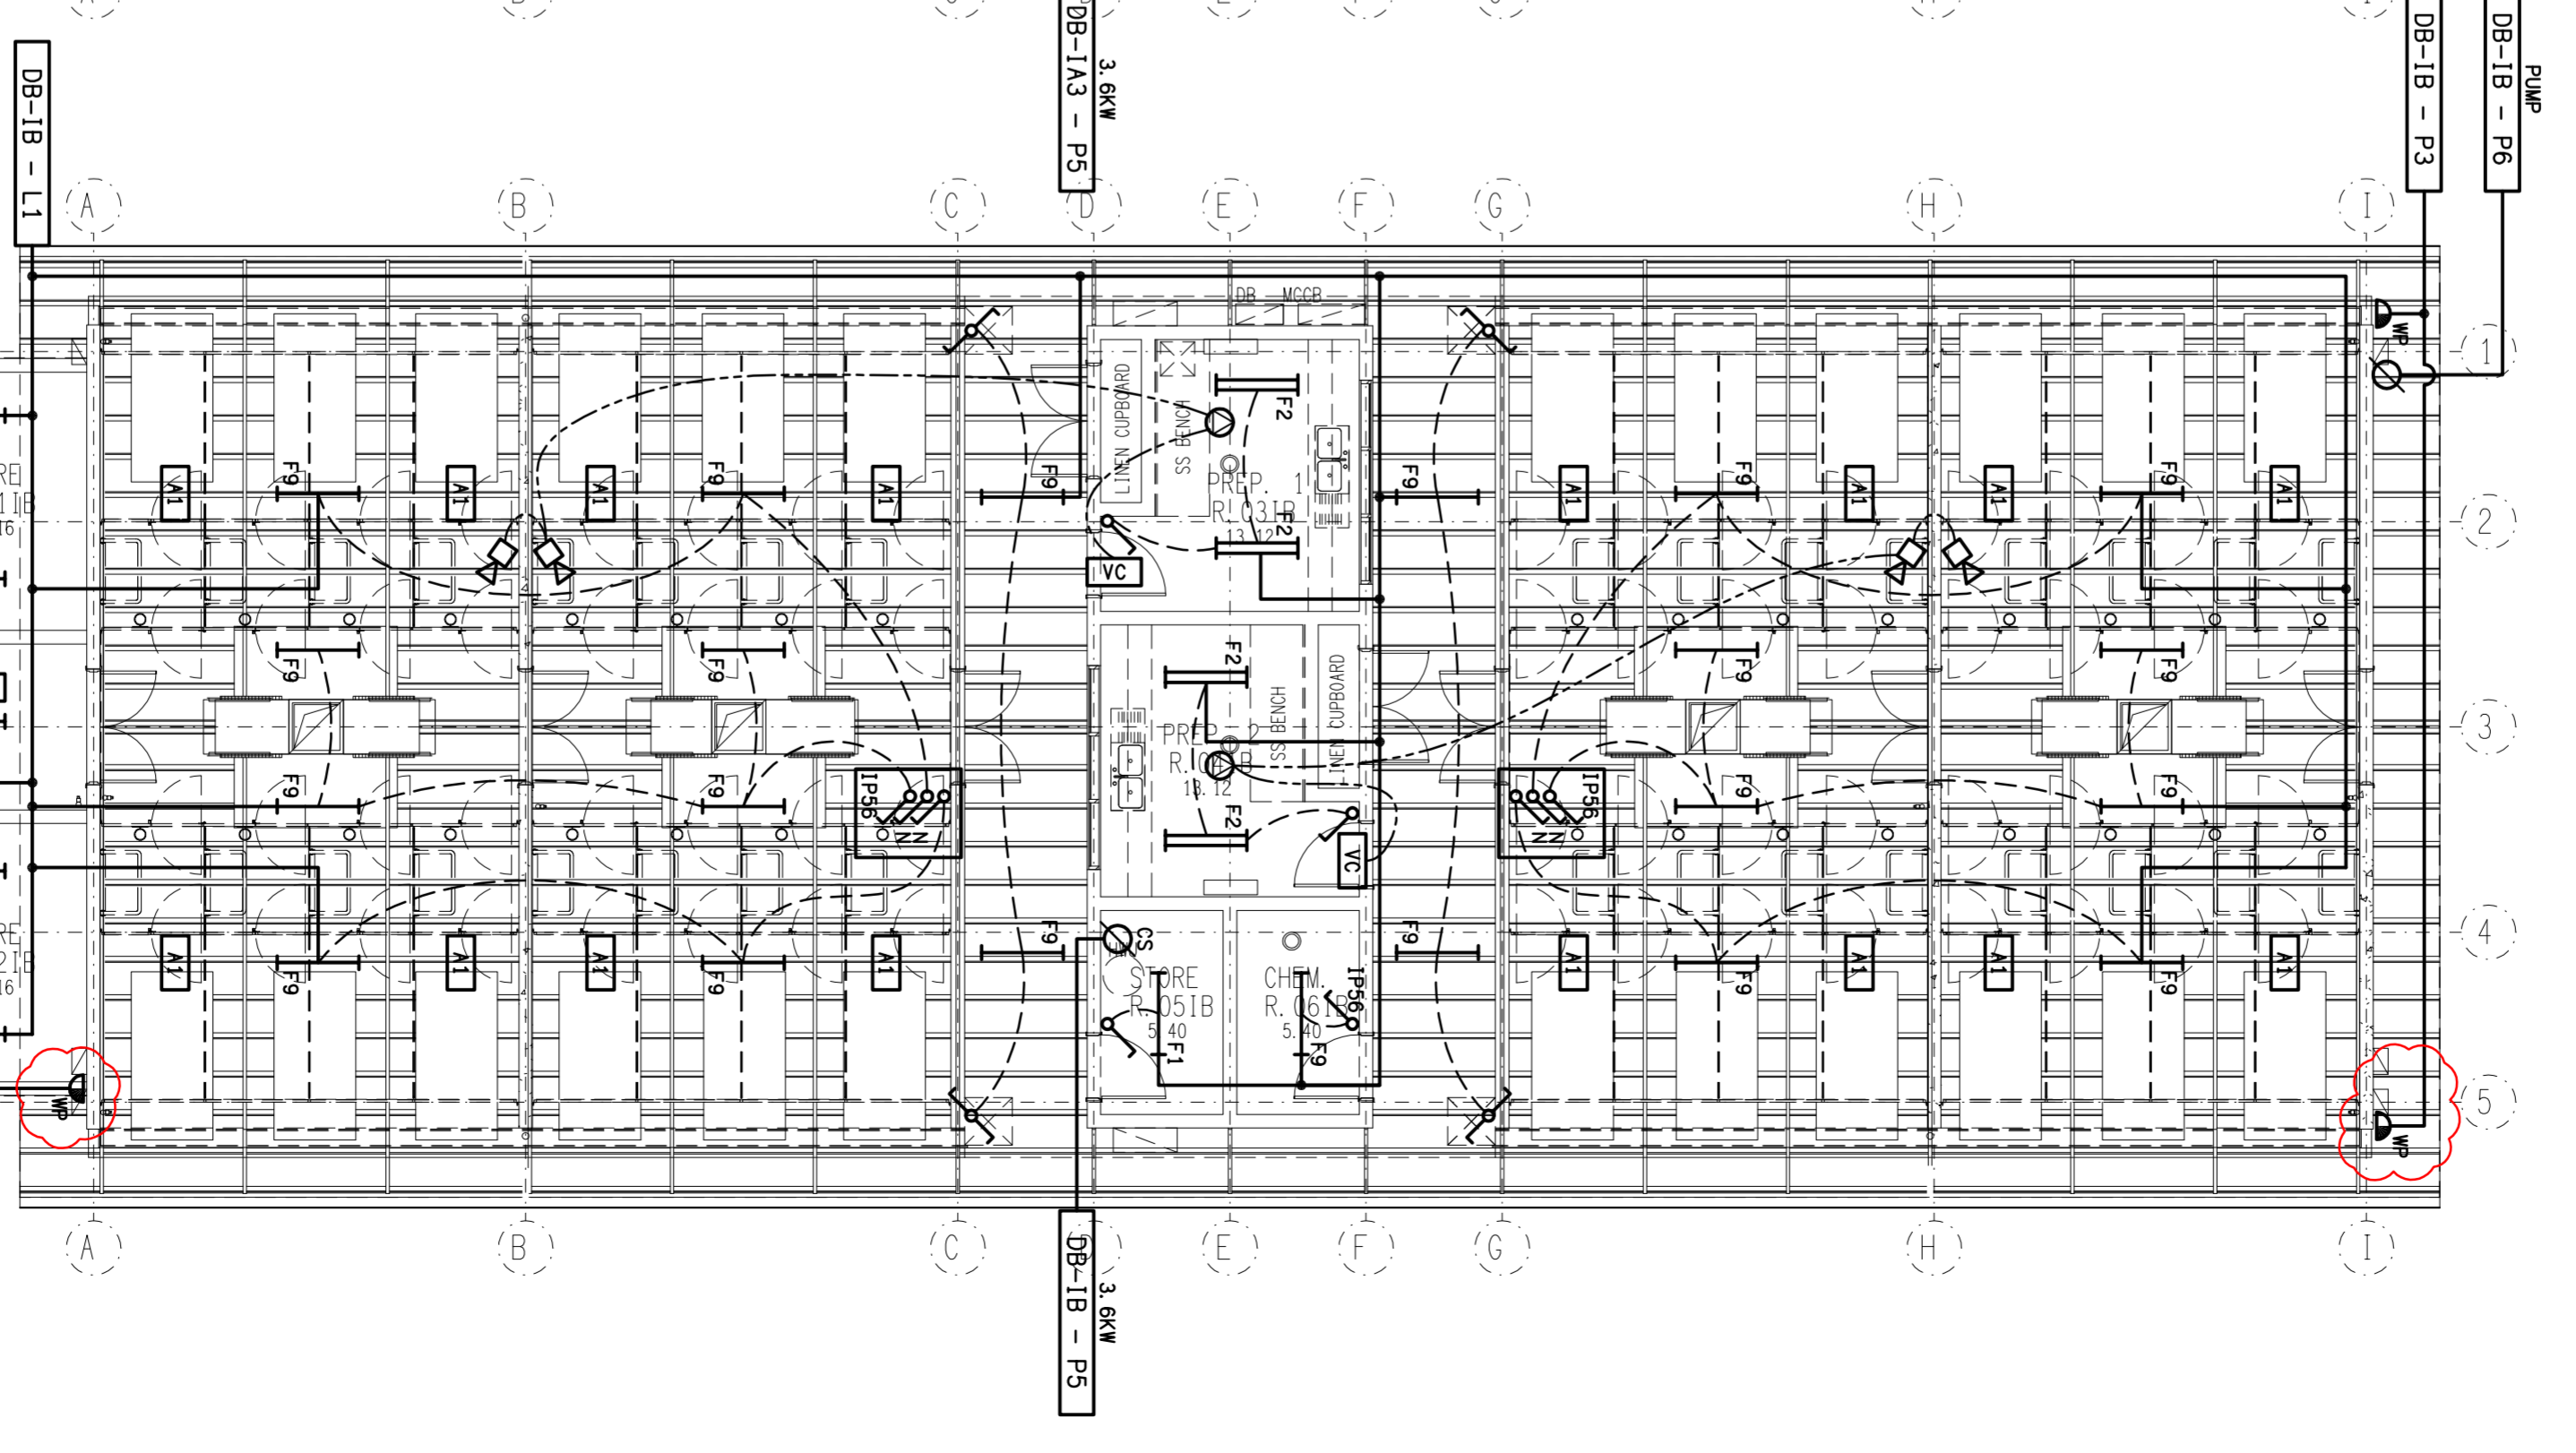

BUILDING IB
REFLECTED CEILING PLAN
SCALE: 1:100

OFFICE USE ONLY:
MARKUP: DRAFT: CHECK:

ELECTRICAL DESIGN GROUP BRISBANE
PROJECT NO. 0710793
DRAWING NO. E112
ELECTRICAL DESIGN GROUP

THE COPYRIGHT OF THIS DRAWING
REMAINS THE PROPERTY OF THE
ELECTRICAL DESIGN GROUP.
USE FIGURED DIMENSIONS
IN PREFERENCE TO SCALE.
ALL DIMENSIONS TO BE
VERIFIED ONSITE.

ELECTRICAL DESIGN GROUP
SERVICES
CONSULTANTS

BRISBANE
P.O. Box 15, Sherwood Q.4075
Phone: (07) 3278 4375
Fax: (07) 3116 0222

PROJECT:
RSPCA - WACOL
WACOL STATION ROAD, WACOL

DRAWING:
ELECTRICAL SERVICES
BUILDING IA BLOCKS 1, 2, 3 & BUILDING IB
FLOOR PLAN & REFLECTED CEILING PLAN
SCALE: 1:100
AT A1
PROJECT NO. **C0677a**
DRAWING NO. **E112**
REVISION:
J

CONSTRUCTION: 12/10/2011