




BUILDING A
CEILING SPACE PART PLAN
SCALE 1:100

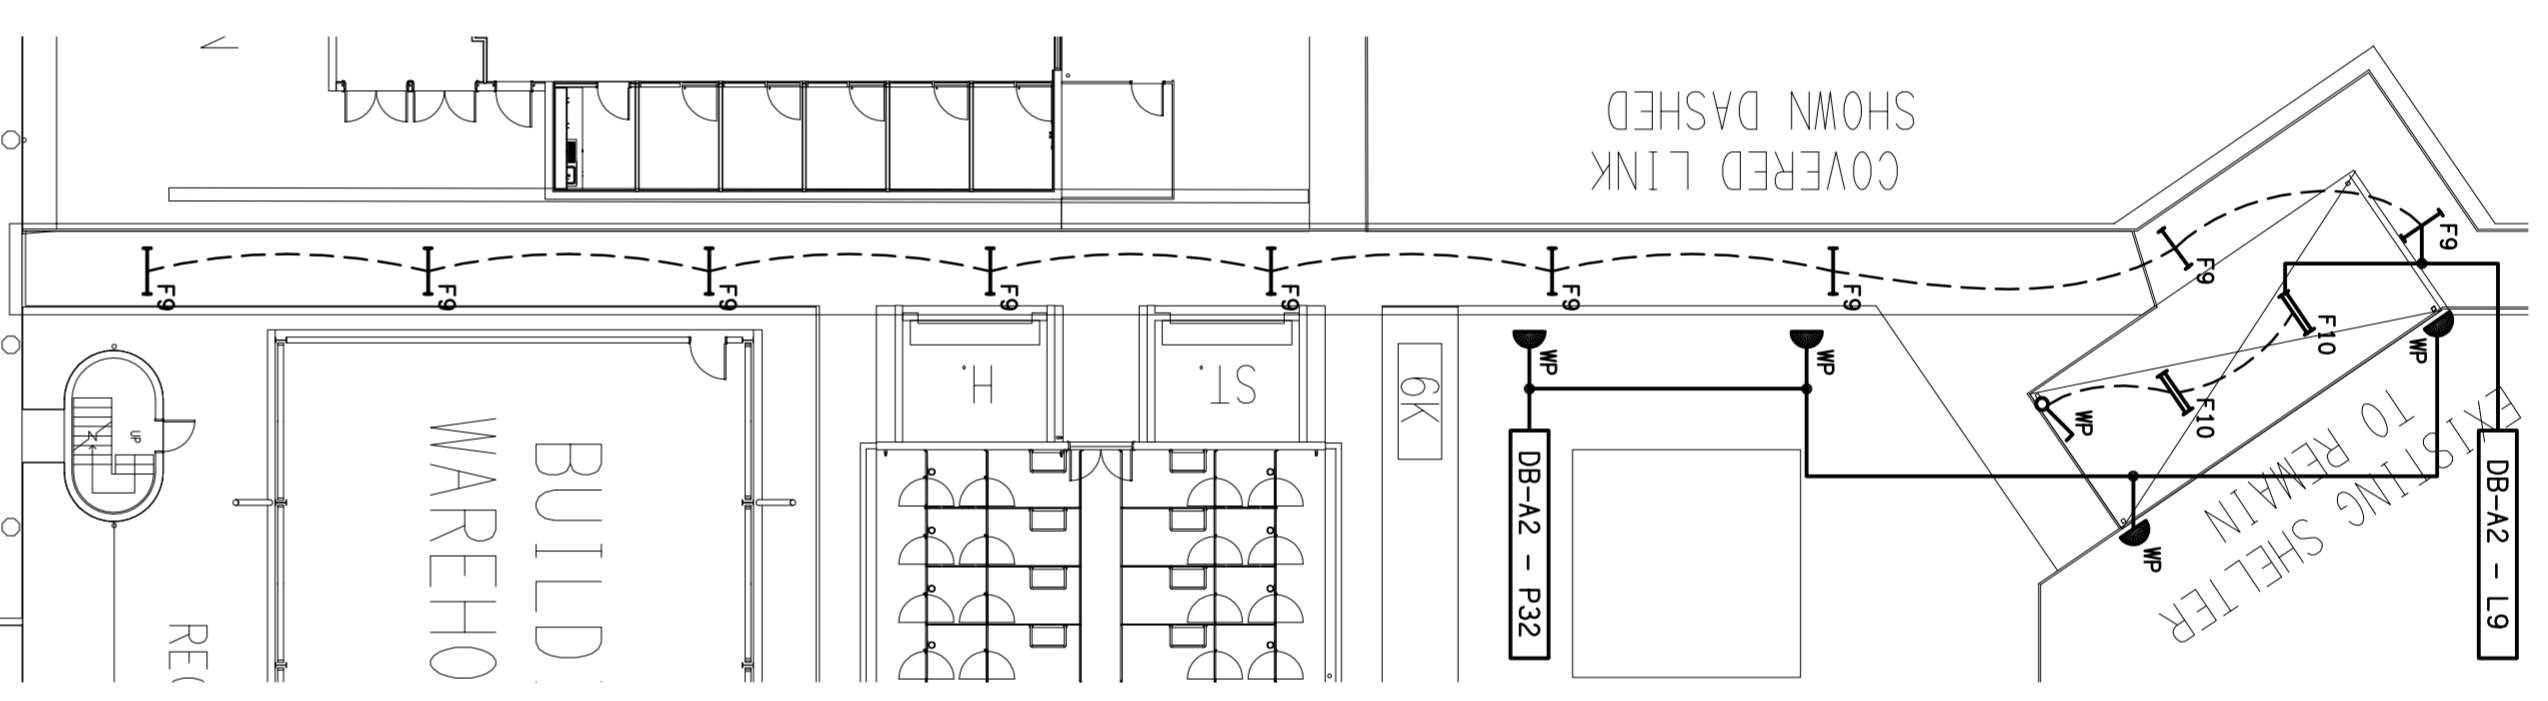


COVERED WALKWAY
FLOOR / REFLECTED CEILING PLAN
SCALE 1:200

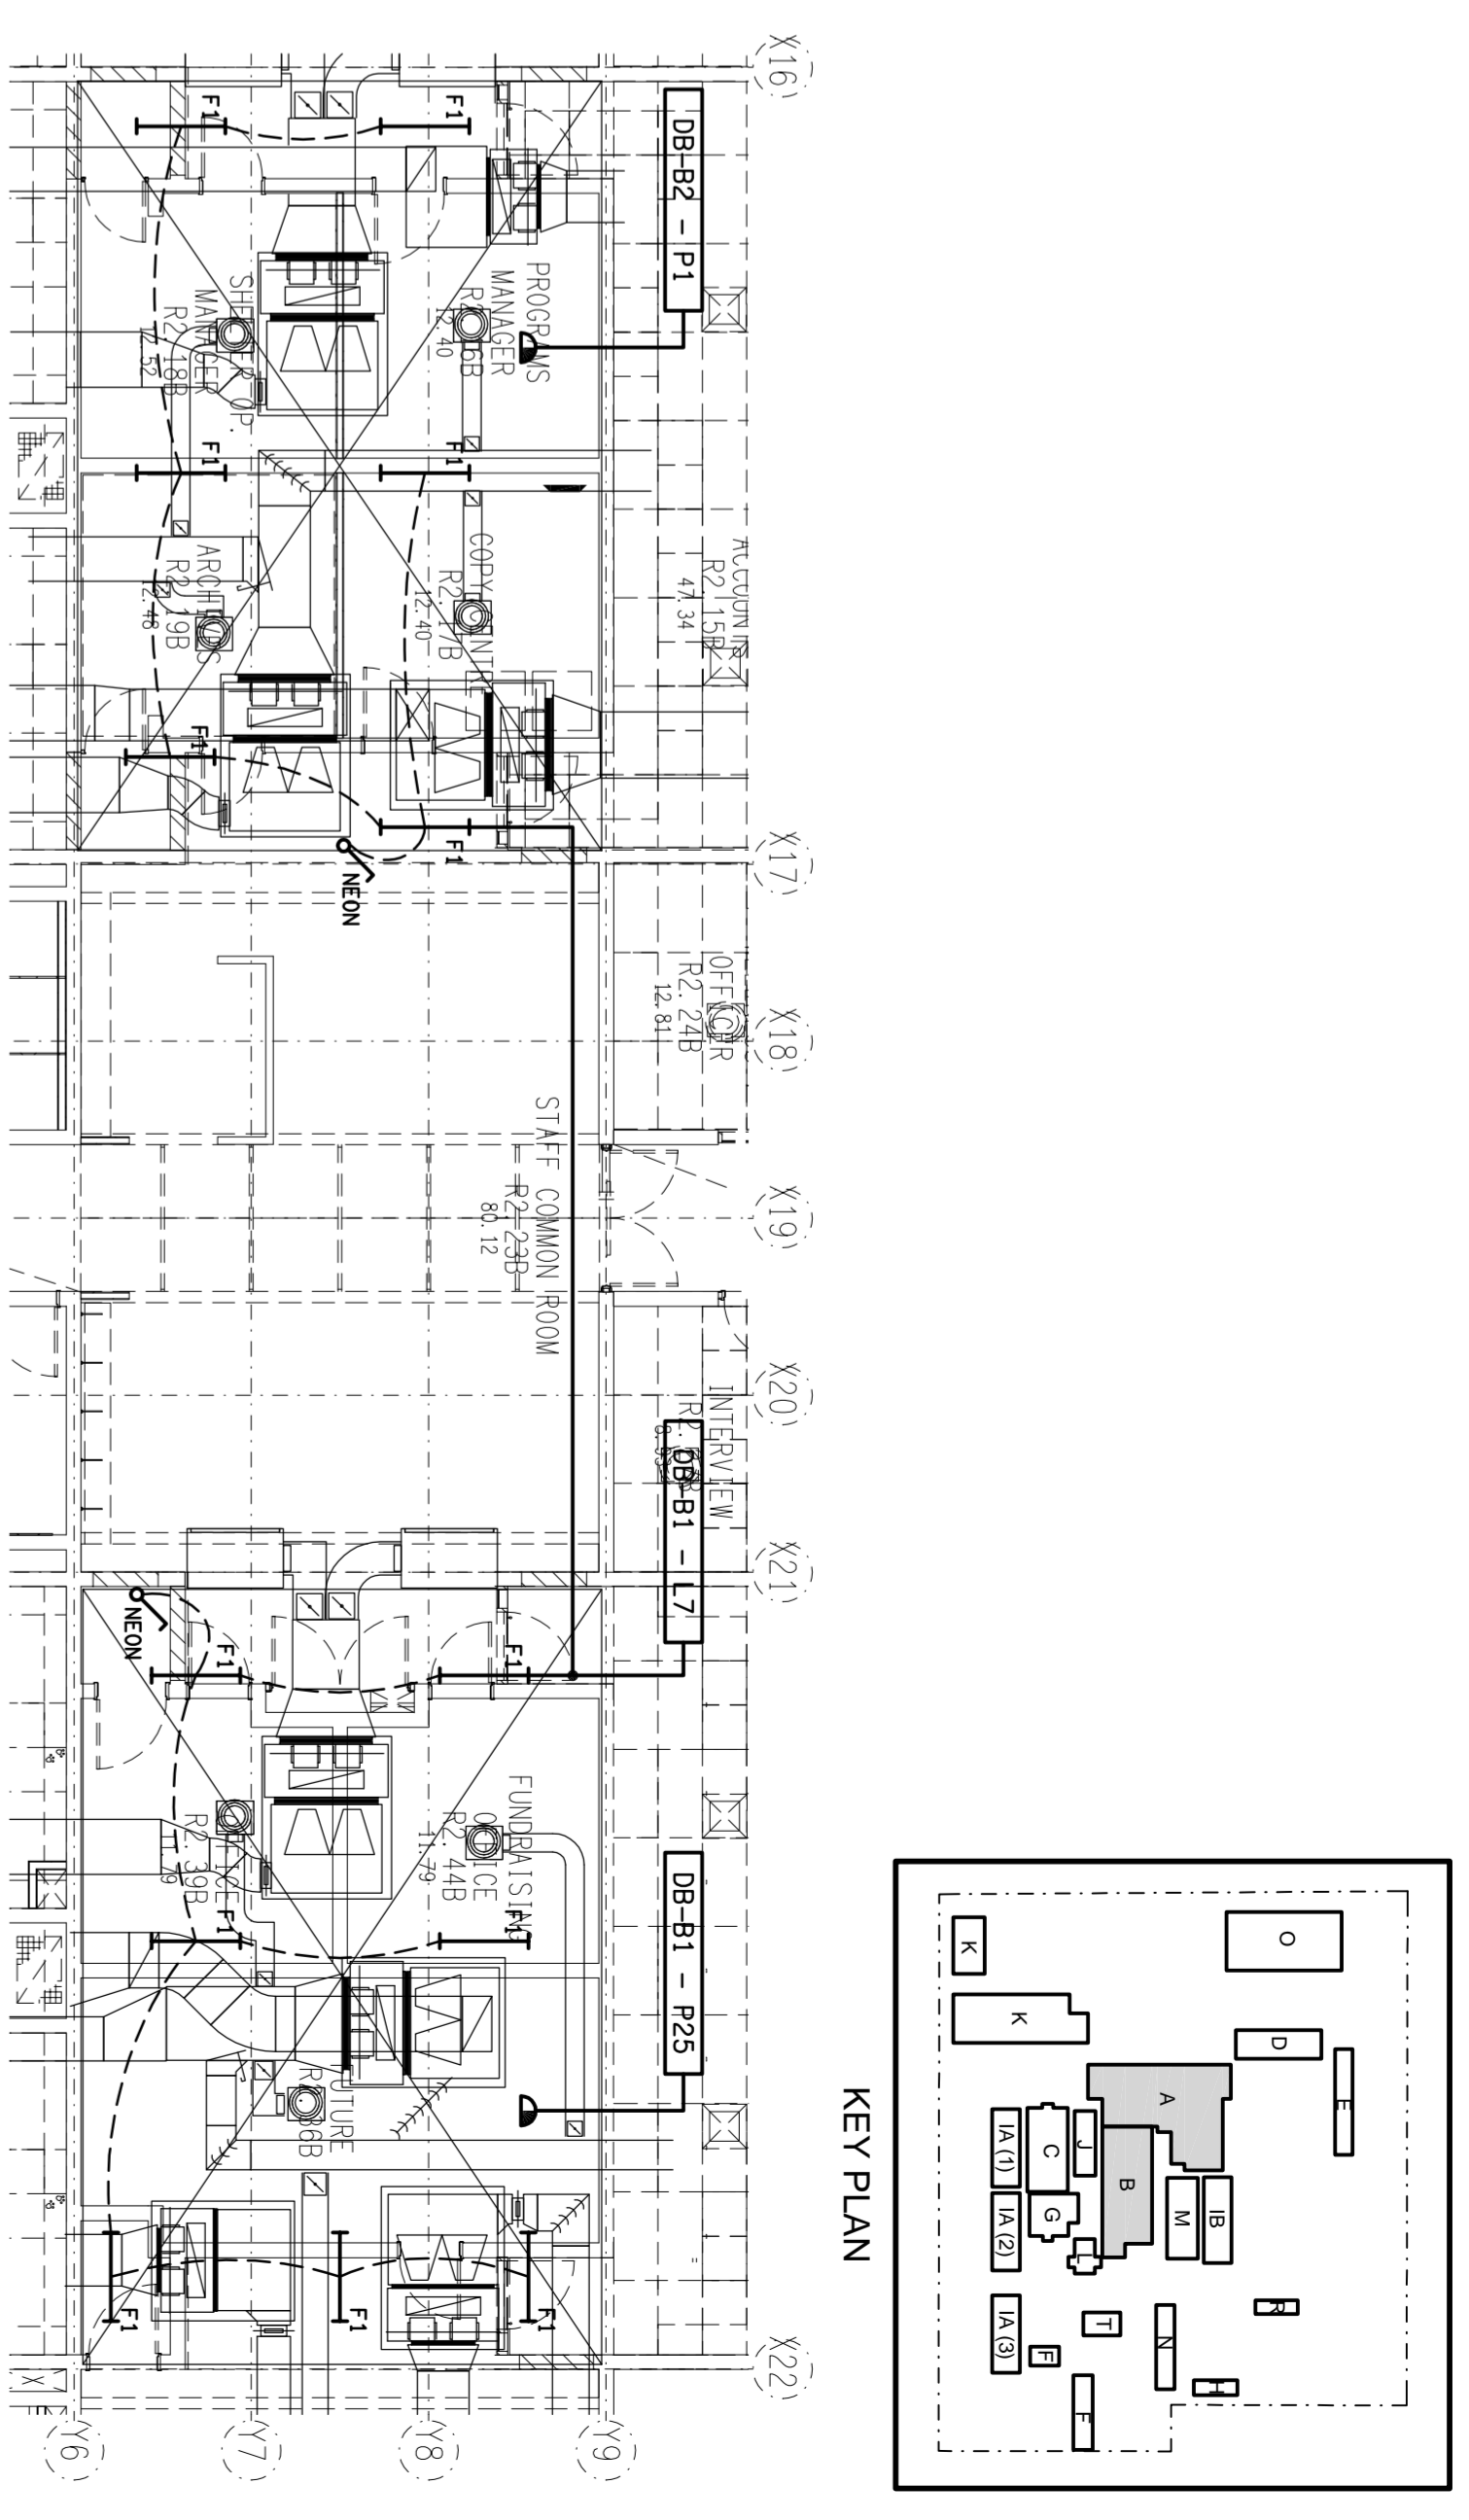


BUILDING B
CEILING SPACE PART PLAN
SCALE 1:100

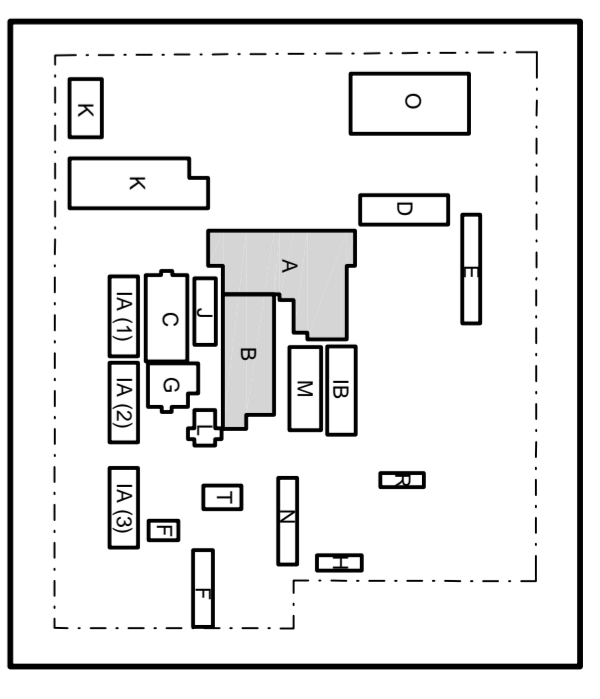

KEY PLAN

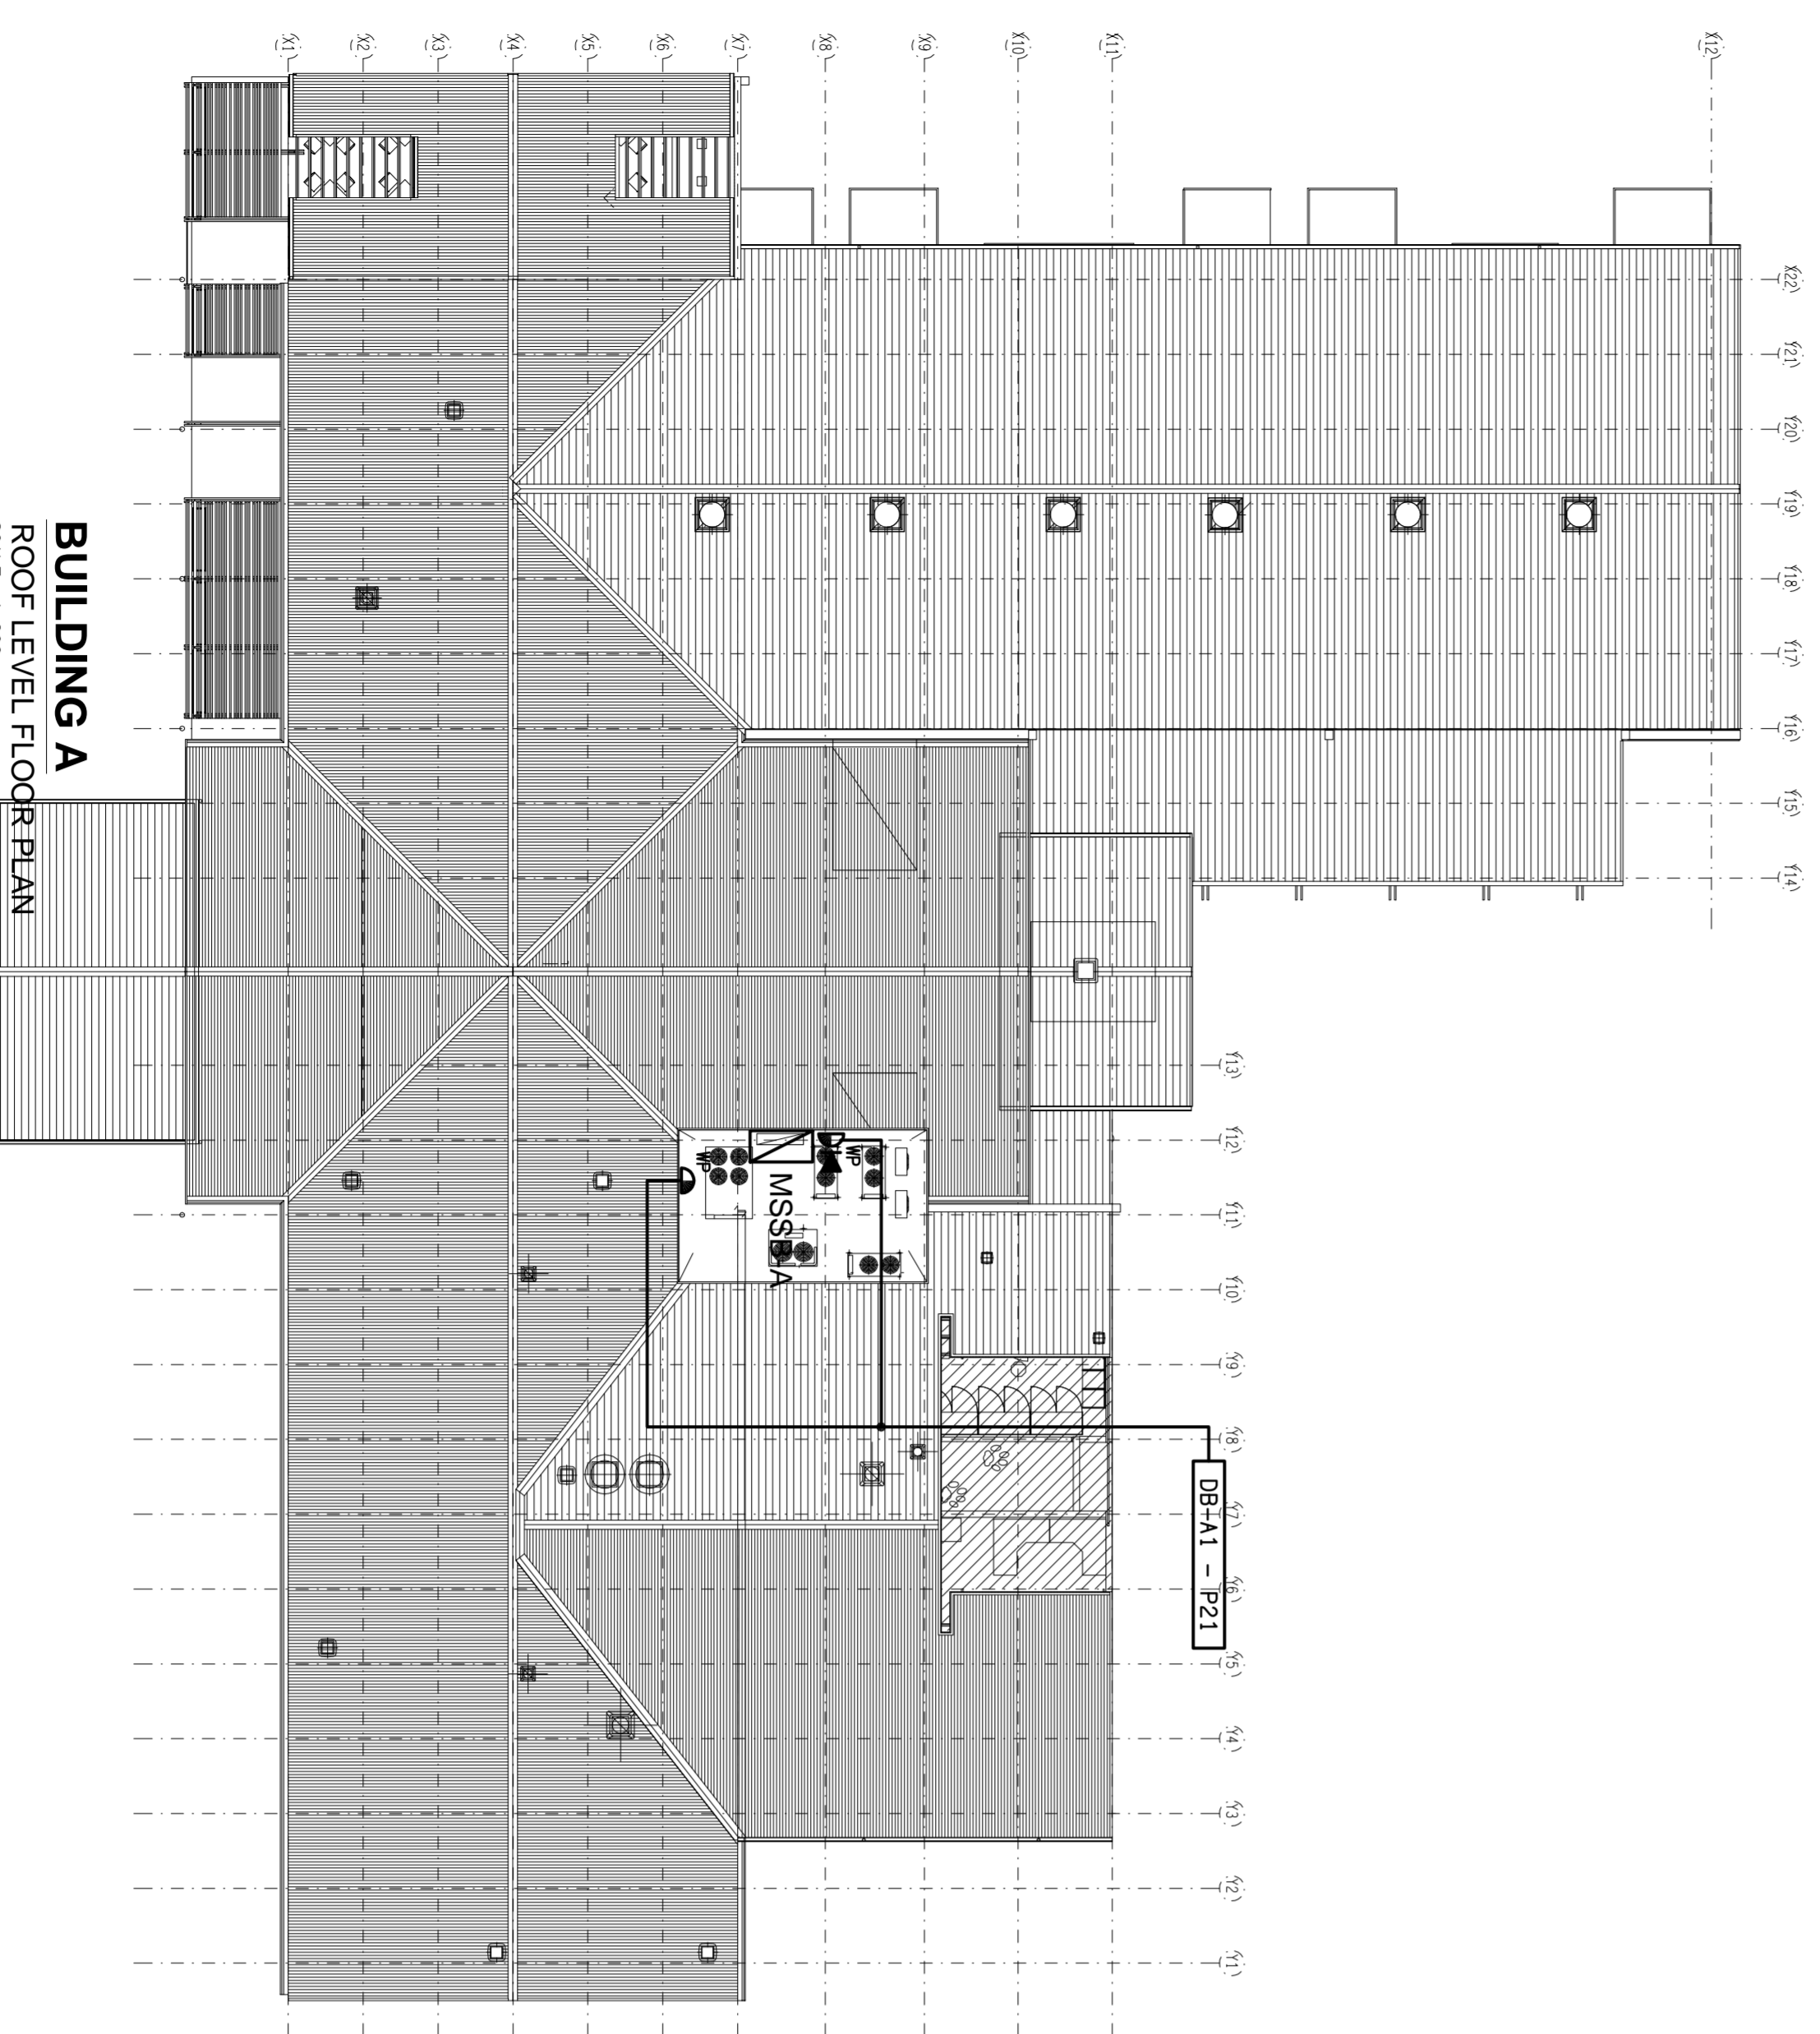

BUILDING A
ROOF LEVEL FLOOR PLAN
SCALE 1:200

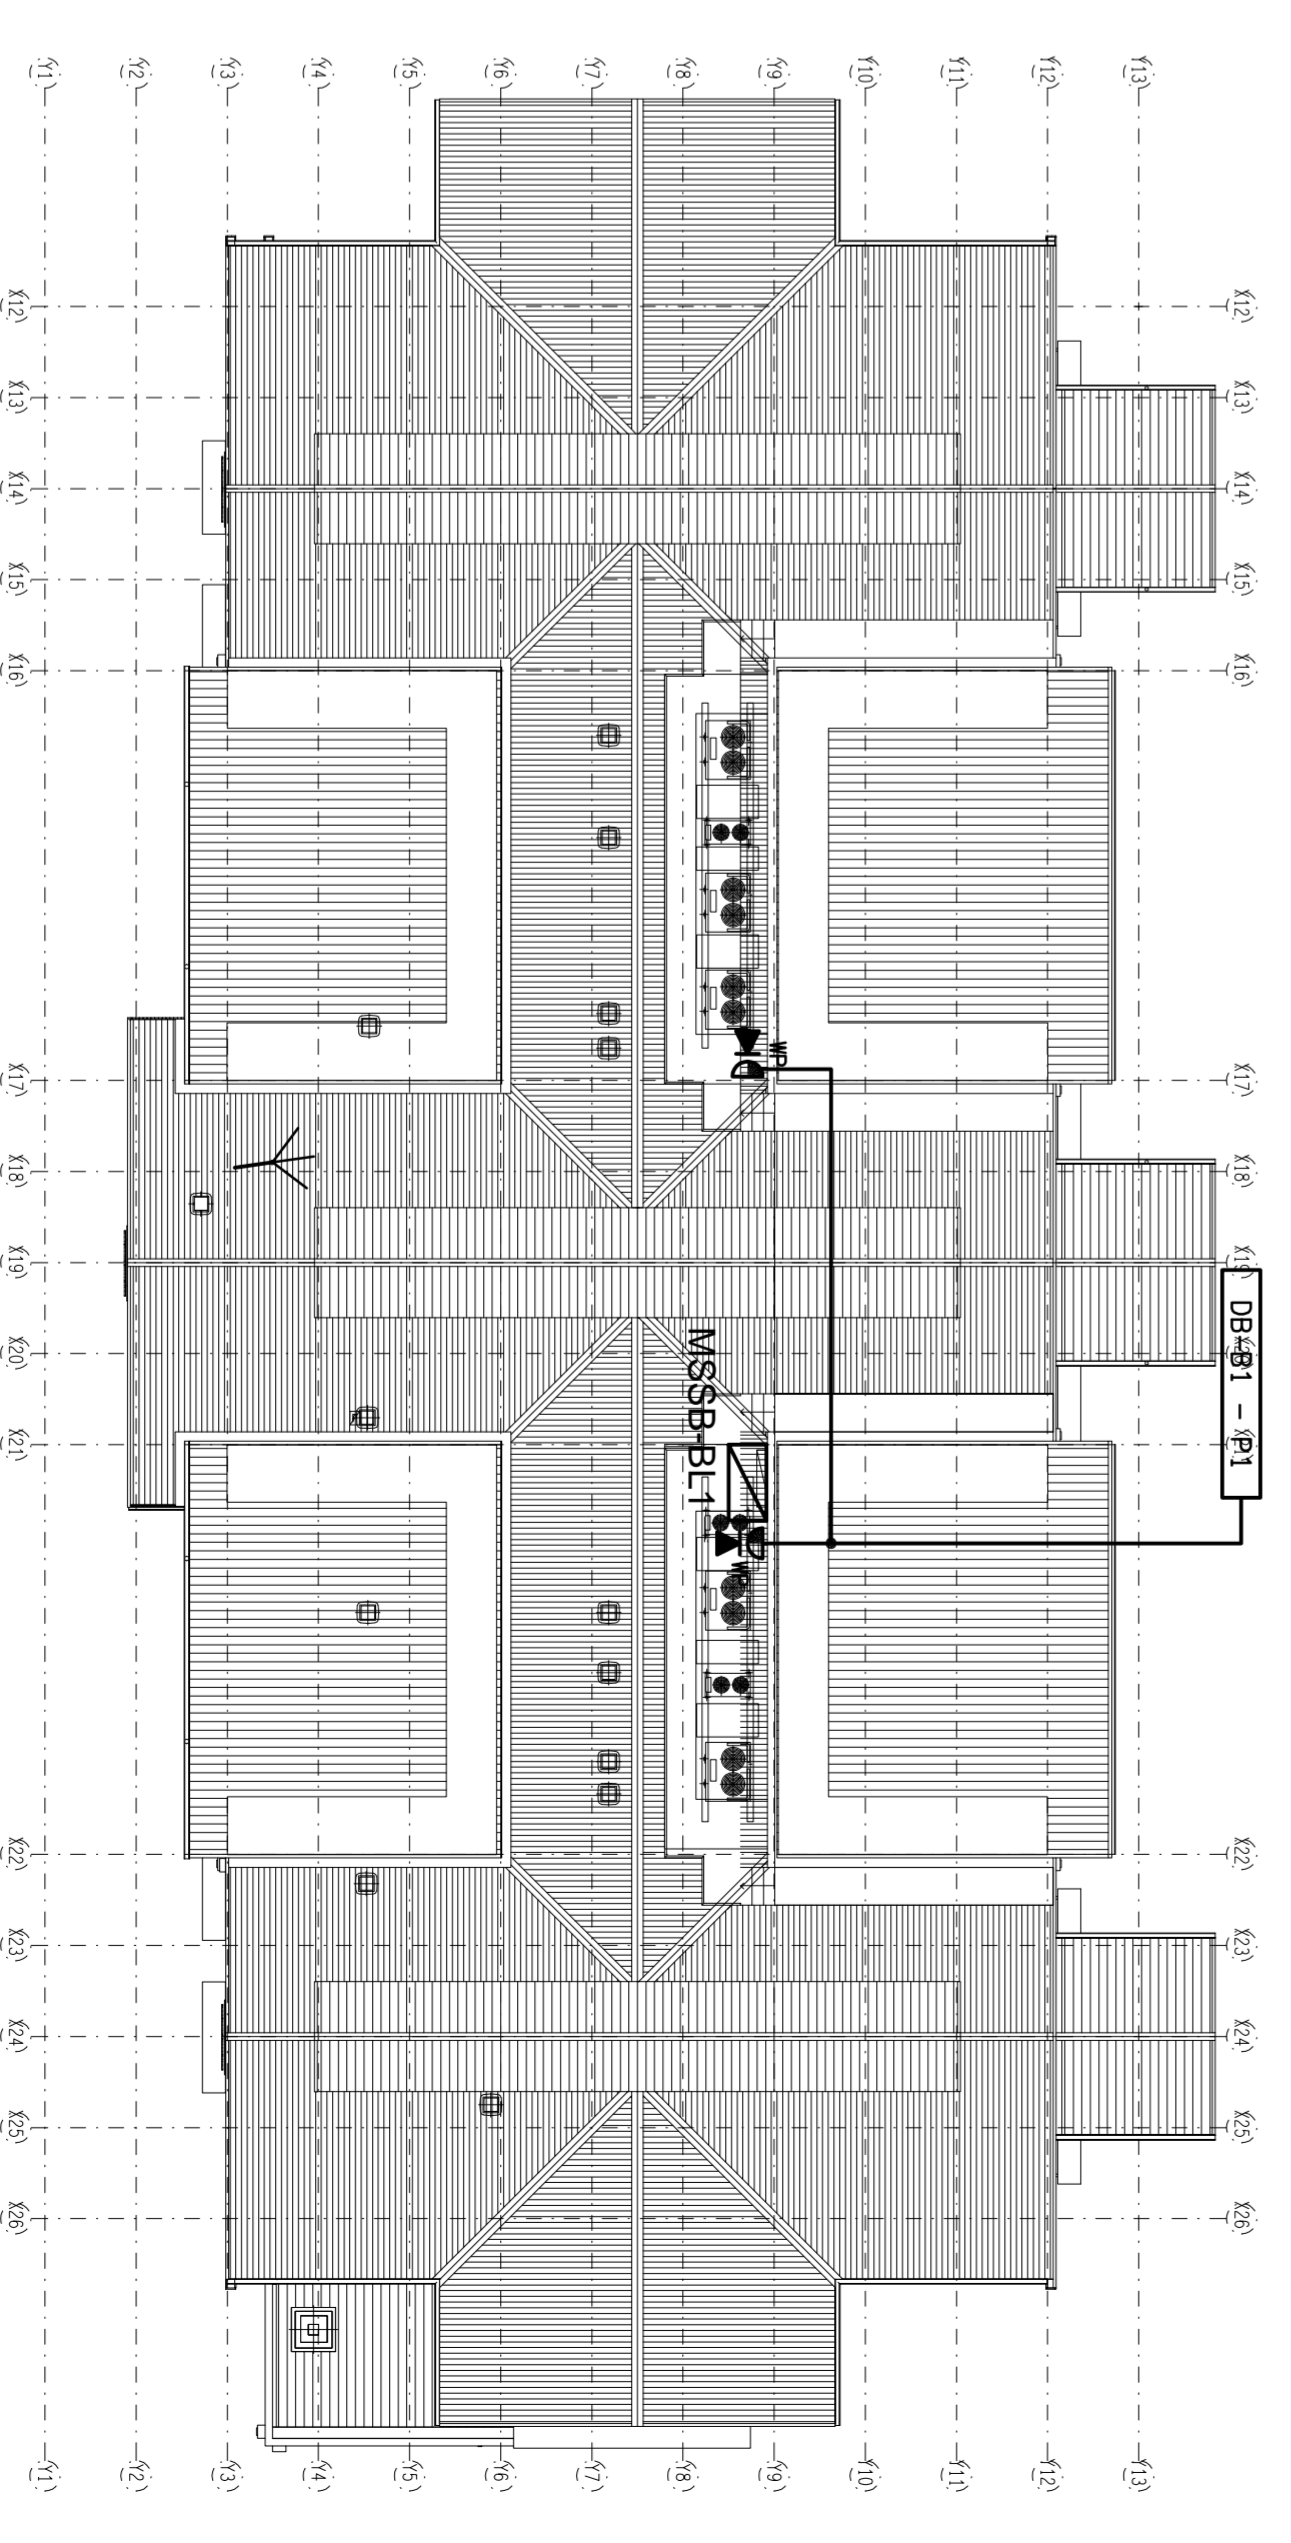

BUILDING B
ROOF LEVEL FLOOR PLAN
SCALE 1:200

OFFICE USE ONLY:

MARKUP: DRAFT: CHECK:

ELECTRICAL DESIGN GROUP BRISBANE
PROJECT NO. 06777a
DRAWING NO. E15
TRADING AS
ELECTRICAL DESIGN GROUP

THE COPYRIGHT OF THIS DRAWING
REMAINS THE PROPERTY OF THE
ELECTRICAL DESIGN GROUP.
USE FIGURED DIMENSIONS
IN PREFERENCE TO SCALE.
ALL DIMENSIONS TO BE
VERIFIED ONSITE.

ELECTRICAL DESIGN GROUP
ELECTRICAL BUILDING SERVICES CONSULTANTS
BRISBANE
P.O. Box 15, Sherwood Q.4075
Phone: (07) 3278 4375
Fax: (07) 316 0222

GOLD COAST
P.O. Box 4248, Ashmore Q.4214
Phone: (07) 5587 7551
Fax: (07) 5587 7552

PROJECT:
RSPCA - WACOL
WACOL STATION ROAD, WACOL

REV.	DESCRIPTION	DATE
E	CONSTRUCTION	27/10/2010

DRAWING:
ELECTRICAL SERVICES
BUILDING ROOF PLANS, CEILING SPACE
PLANS & COVERED WALKWAY PLAN
SCALE:
AS SHOWN AT A1
PROJECT NO. **C0677a** DRAWING NO. **E15** REVISION: **E**