


DETAIL
TYPICAL LIGHT TYPE A ELEVATION
NOT TO SCALE

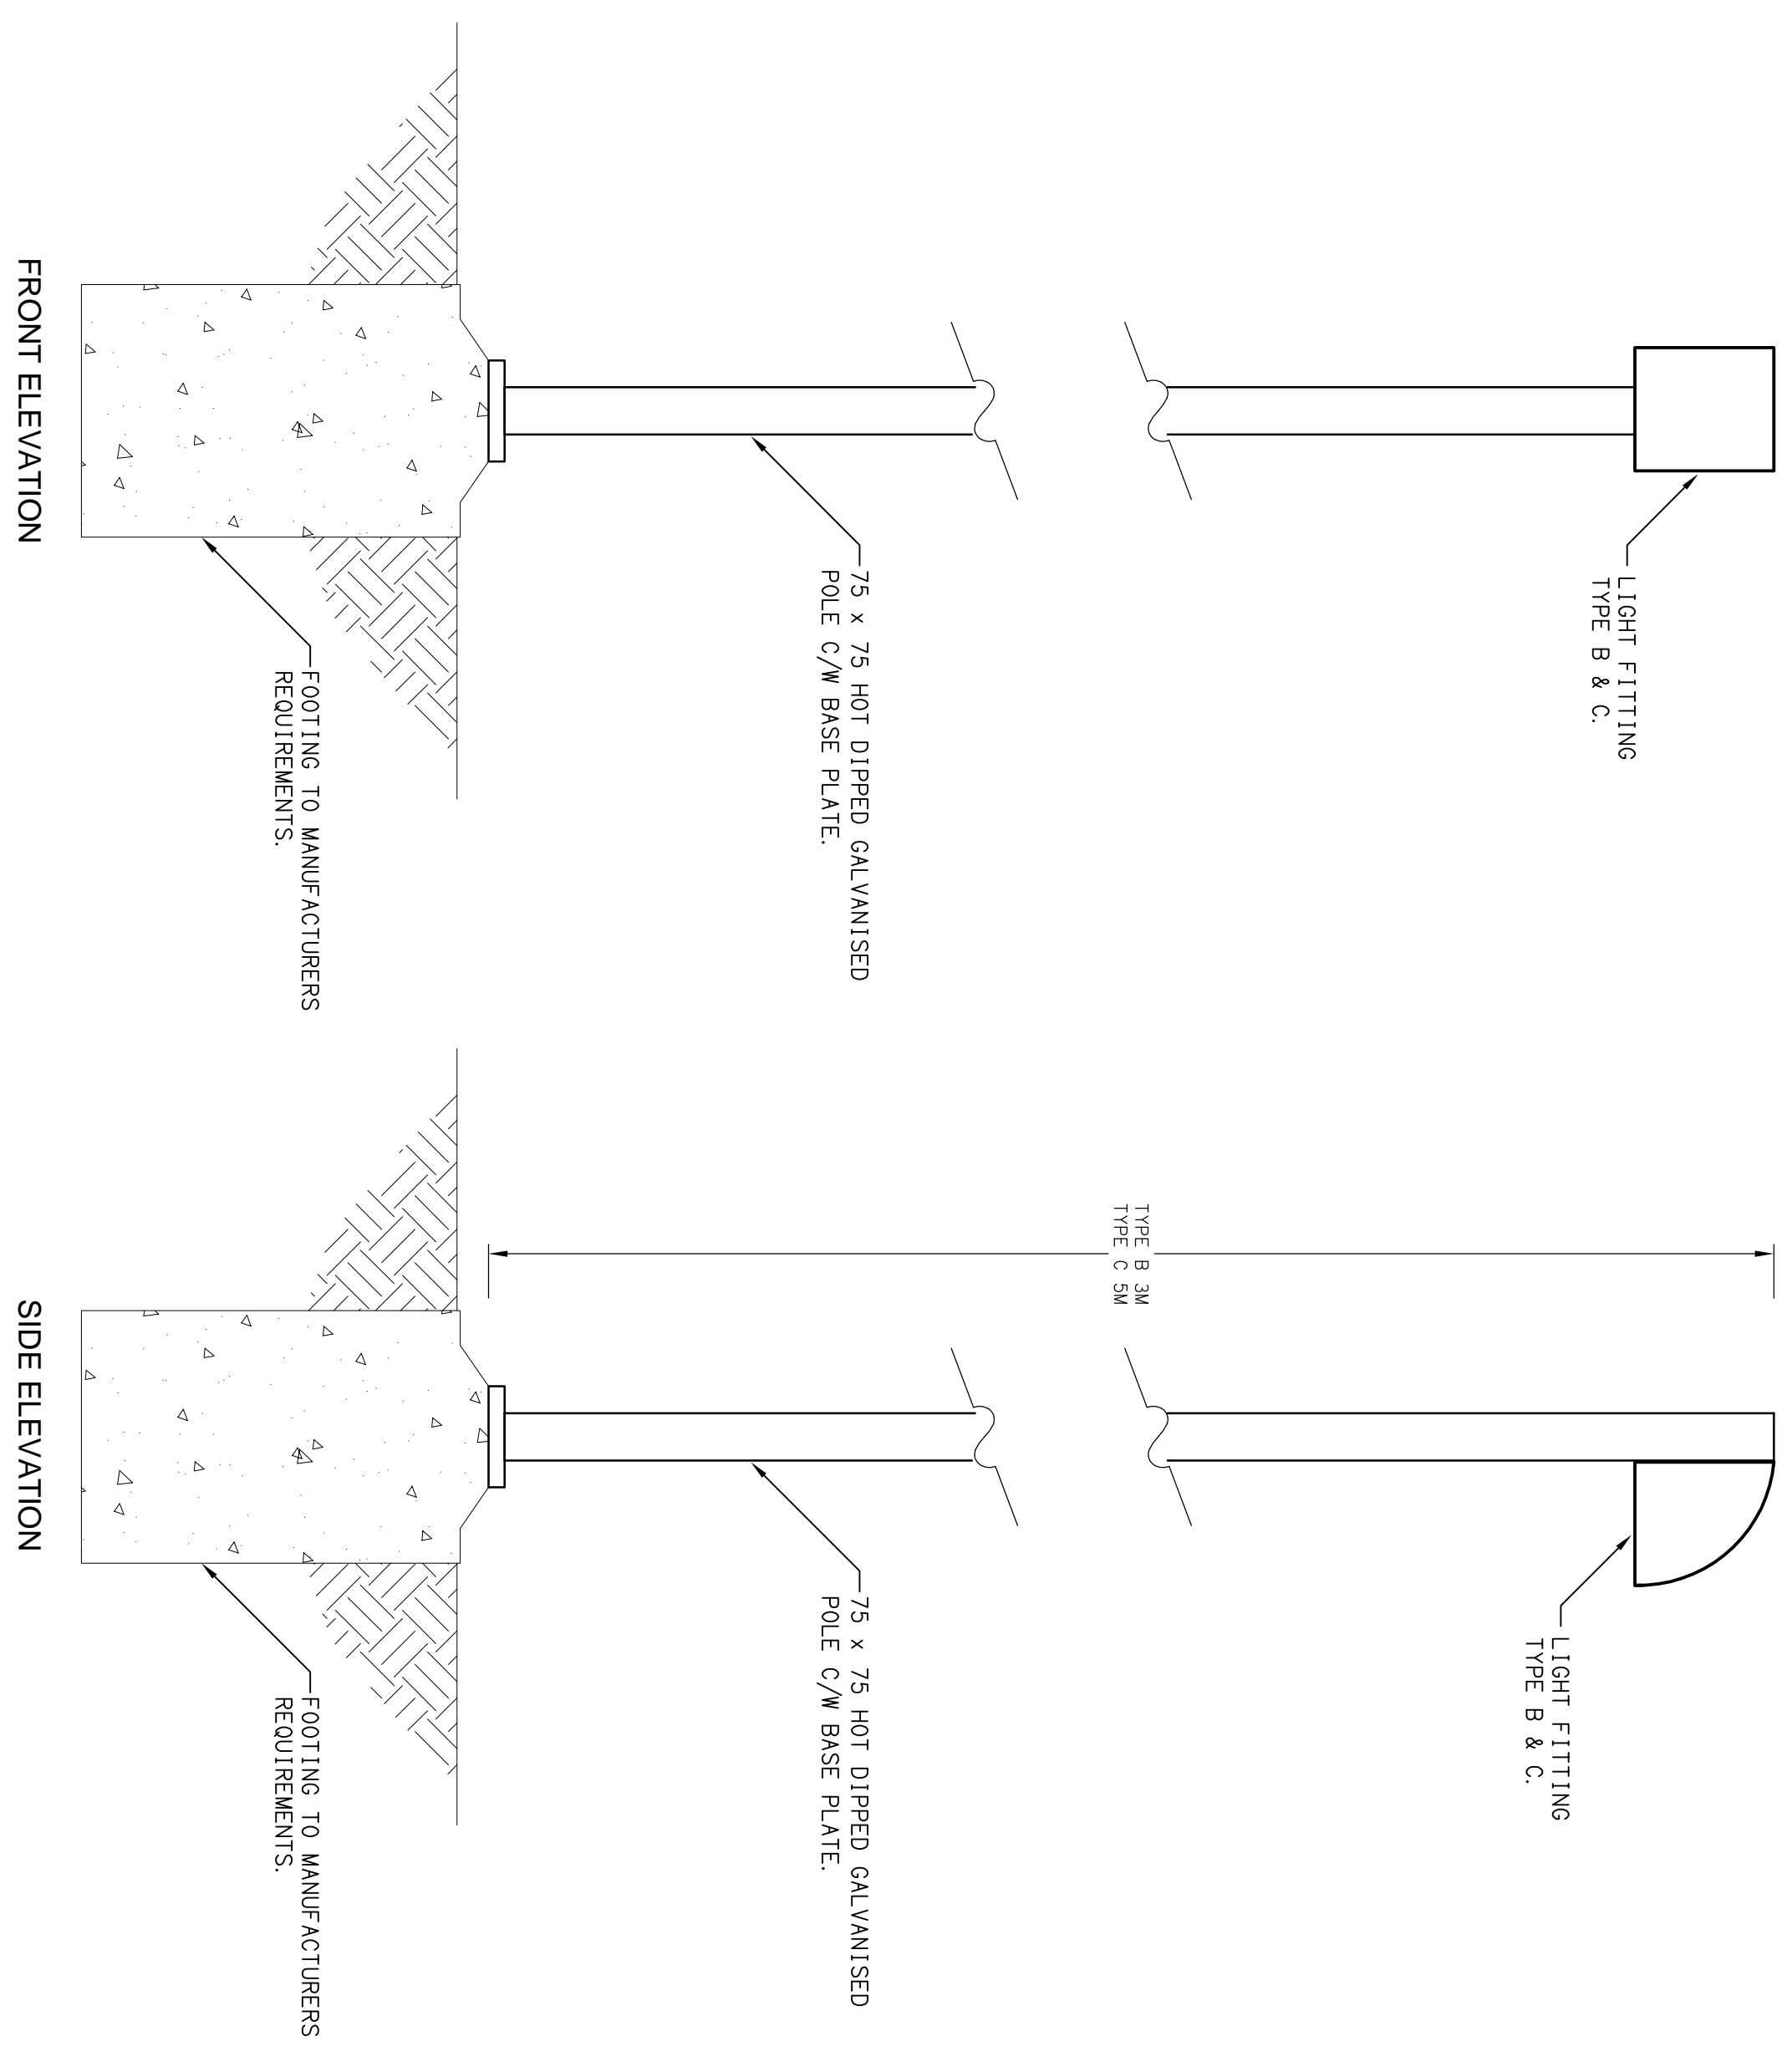

DETAIL
TYPICAL LIGHT TYPE B & C
NOT TO SCALE

OFFICE USE ONLY:		
MARKUP:	DRAFT:	CHECK:

ELECTRICAL DESIGN GROUP BRISBANE
 PTV LID
 10/10/2009
 READING AS
 ELECTRICAL DESIGN GROUP

THE COPYRIGHT OF THIS DRAWING
 REMAINS THE PROPERTY OF THE
 ELECTRICAL DESIGN GROUP.
 USE FIGURED DIMENSIONS
 IN PREFERENCE TO SCALE.
 ALL DIMENSIONS TO BE
 VERIFIED ON SITE.

ELECTRICAL DESIGN GROUP
 ELECTRICAL COMMUNICATIONS FIRE SYSTEMS DESIGNERS
 BRISBANE
 P.O. Box 15, Sharnood Q. 4075
 Phone: (07) 378 4375
 Fax: (07) 378 0222

PROJECT:
129 BARRACK ROAD
 MURRARIE

DRAWING:
ELECTRICAL SERVICES
LIGHTING SITE PLAN & DETAILS
 SCALE:
 1:500
 PROJECT NO.:
C0757a
 DRAWING NO.:
E03
 REVISION:
B

REV:	DESCRIPTION:	DATE:
B	TENDER	31/07/2009