

|                  |        |        |
|------------------|--------|--------|
| OFFICE USE ONLY: |        |        |
| MARKUP:          | DRAFT: | CHECK: |

ELECTRICAL DESIGN GROUP BRISBANE  
 PTY LTD  
 ACN 62 710 793  
 TRADING AS  
 ELECTRICAL DESIGN GROUP

THE COPYRIGHT OF THIS DRAWING  
 REMAINS THE PROPERTY OF THE  
 ELECTRICAL DESIGN GROUP.  
 USE FIGURED DIMENSIONS  
 IN PREFERENCE TO SCALE.  
 ALL DIMENSIONS TO BE  
 VERIFIED ON SITE.

**ELECTRICAL DESIGN GROUP**  
 ELECTRICAL COMMUNICATIONS FIRE SYSTEMS DESIGNERS  
 BRISBANE  
 P O Box 15, Sharnood Q. 4075  
 Phone: (07) 3278 4375  
 Fax: (07) 3716 0222


**GOLD COAST**  
 P O Box 4248, Ashmore Q. 4214  
 Phone: (07) 5597 7551  
 Fax: (07) 5597 7552

Product:  
**129 BARRACK ROAD**  
 MURRARIE


Drawings:  
**ELECTRICAL SERVICES**  
**ENERGEX PADMOUNT SUBSTATION**  
**ARRANGEMENTS**  
 SCALE: AS SHOWN AT A1  
 PROJECT NO: **C0757a**  
 DRAWING NO: **E05**  
 REVISION: **B**

|      |              |            |
|------|--------------|------------|
| REV: | DESCRIPTION: | DATE:      |
| B    | APPROVAL     | 19/03/2010 |


**SITE PLAN**  
 PADMOUNT SUBSTATION LOCATION  
 SCALE: 1:500

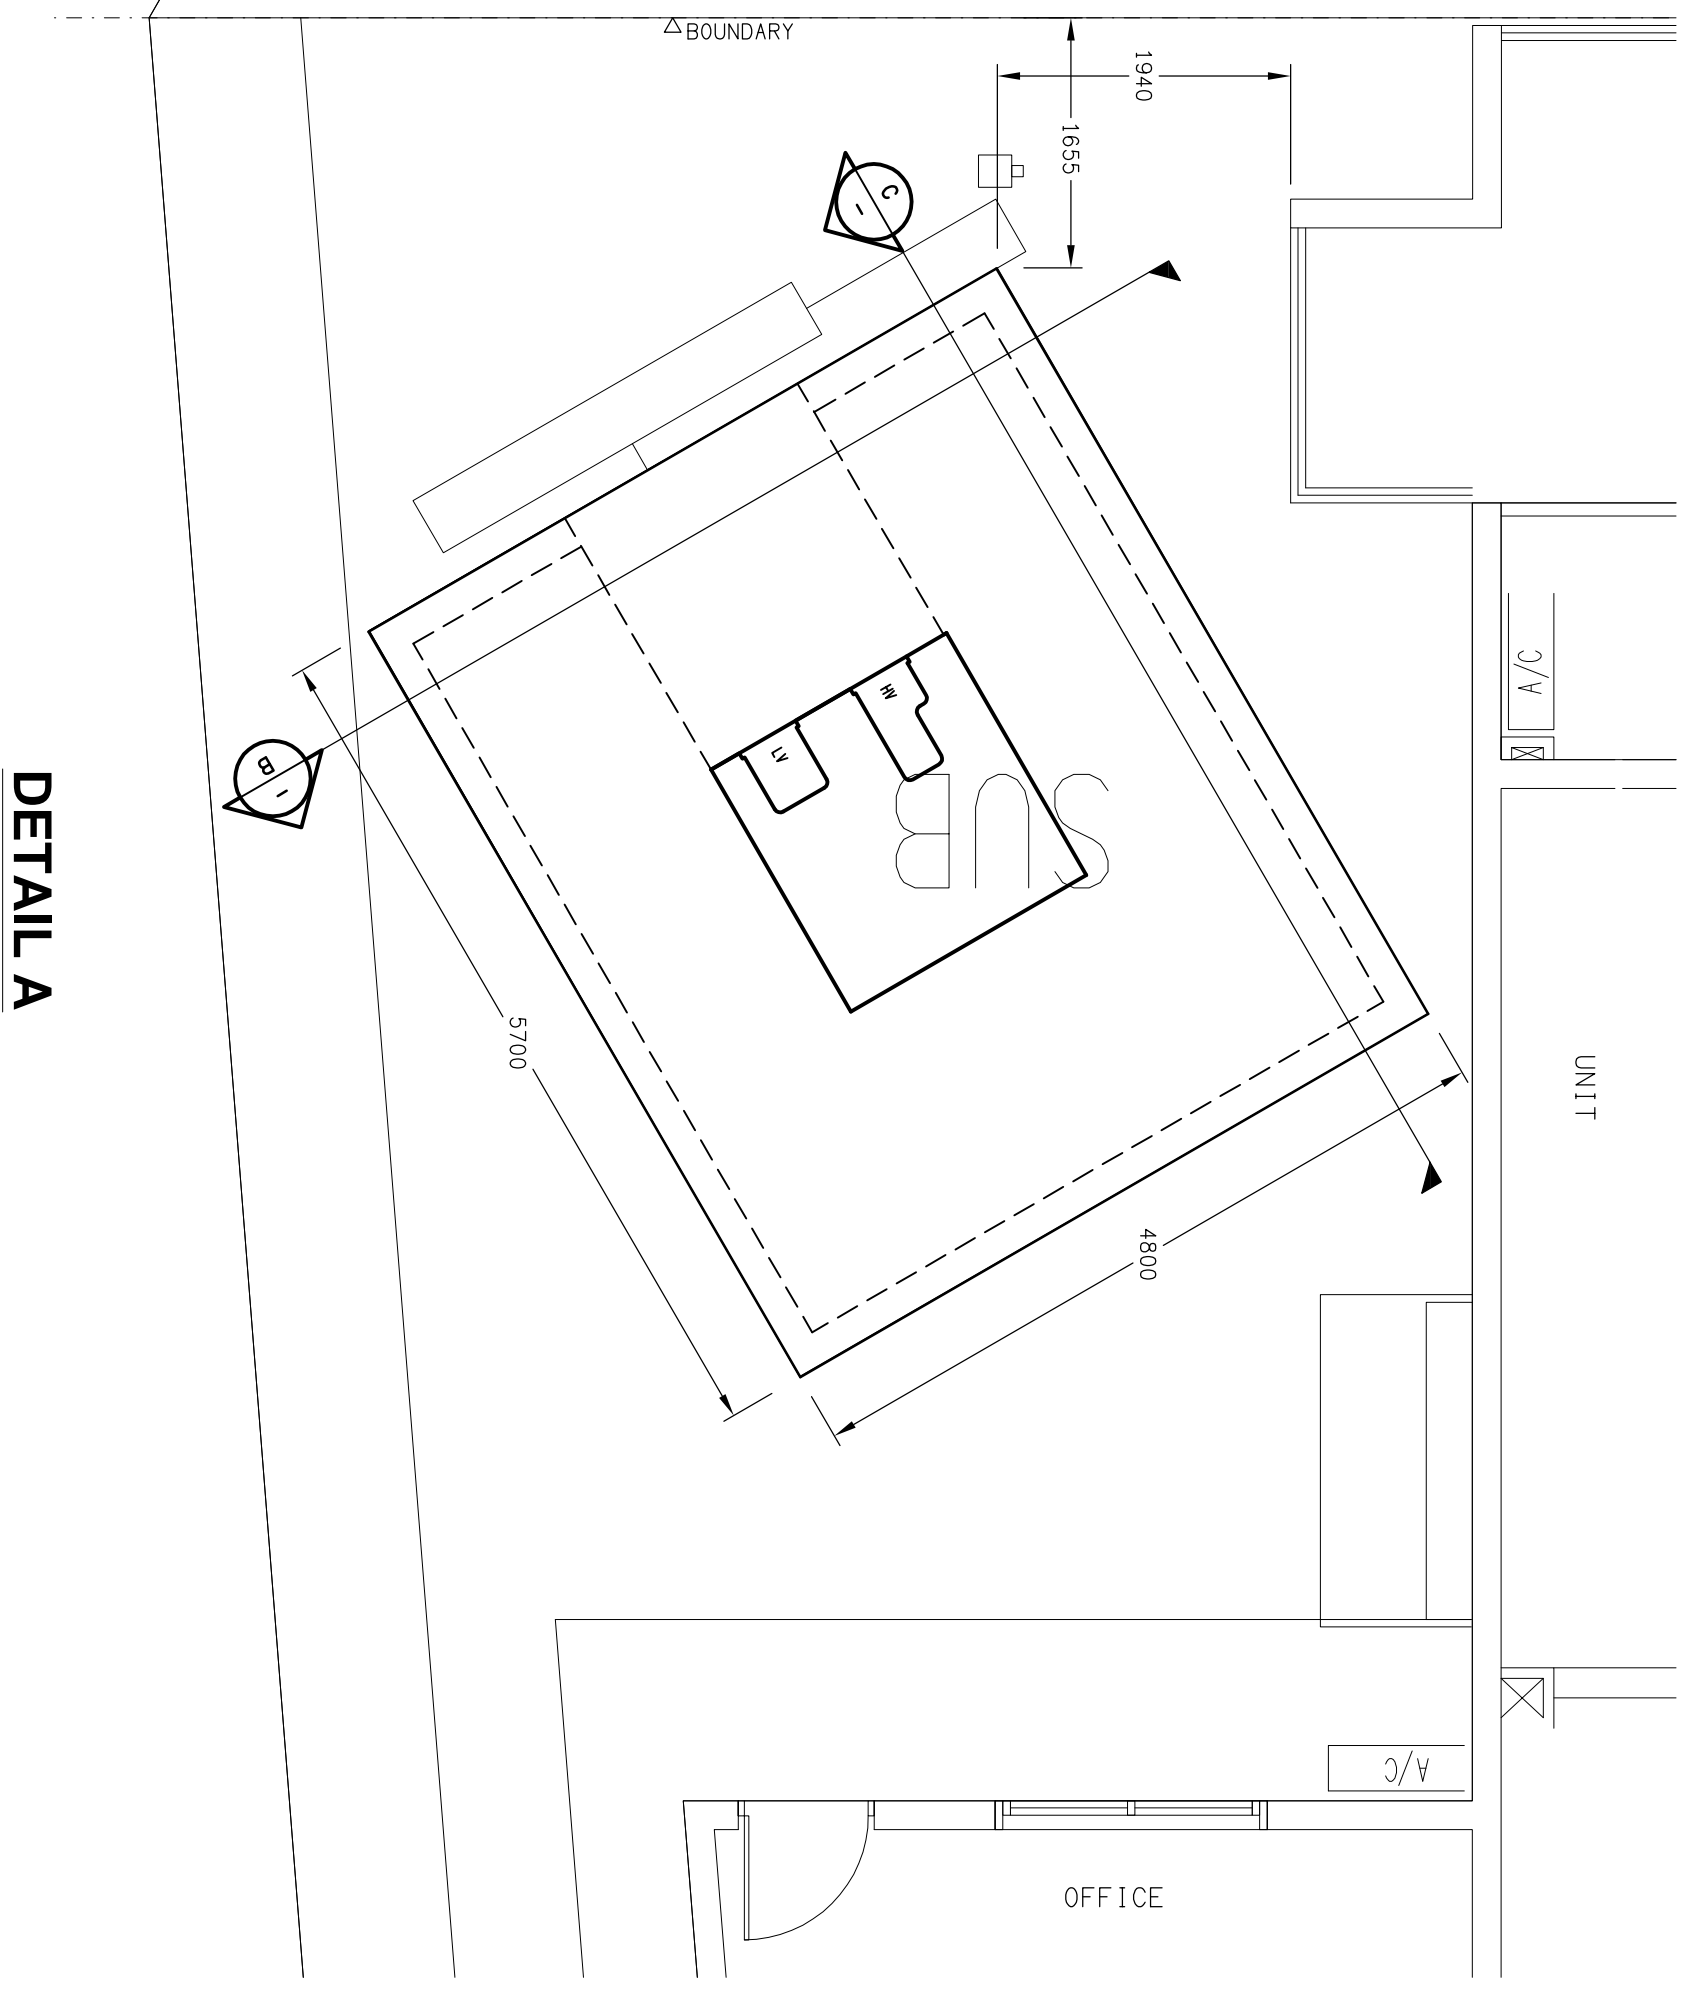

**DETAIL A**  
 PADMOUNT PLAN VIEW  
 SCALE: 1:50

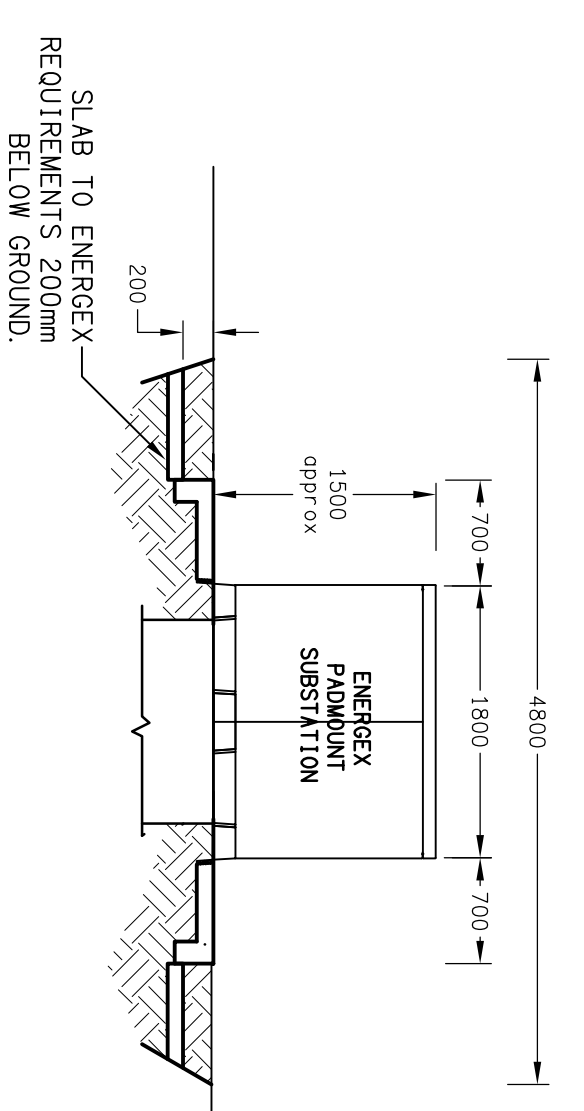

**DETAIL B**  
 PADMOUNT SECTION VIEW  
 SCALE: 1:50

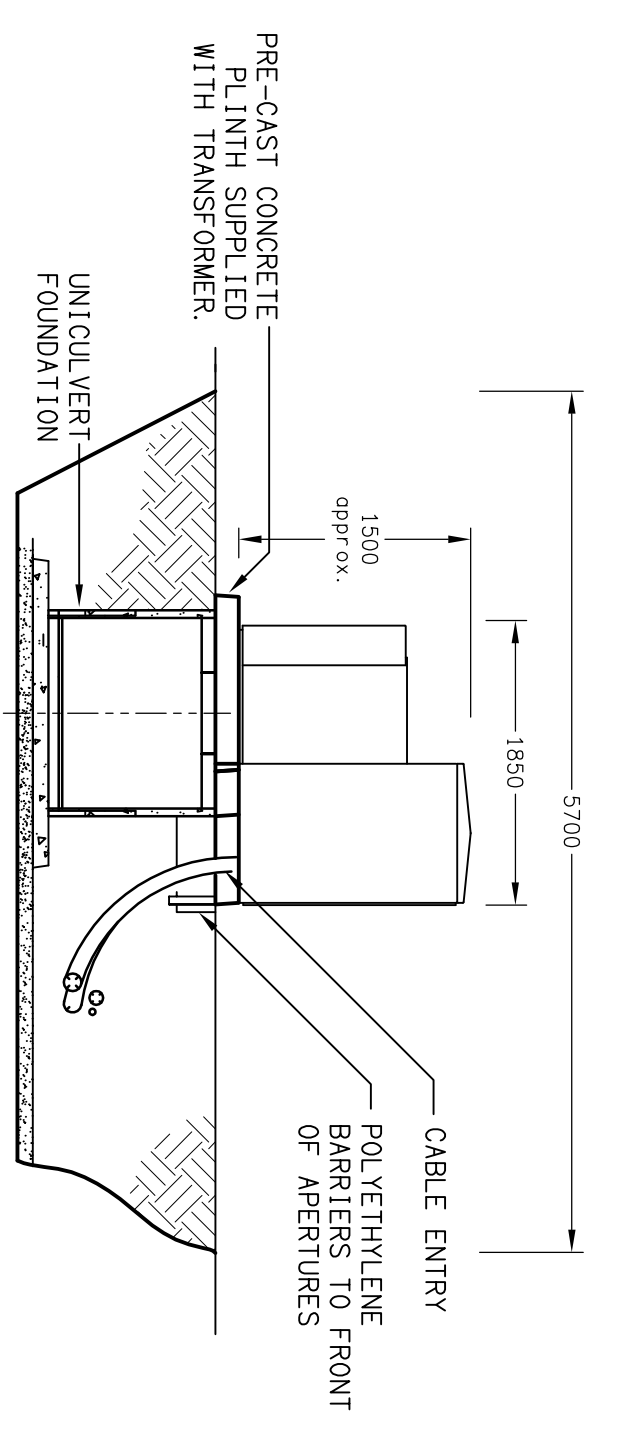

**DETAIL C**  
 PADMOUNT SECTION VIEW  
 SCALE: 1:50