


DETAIL A

STAFF ROOM KITCHENETTE ELEVATION

SCALE 1:25

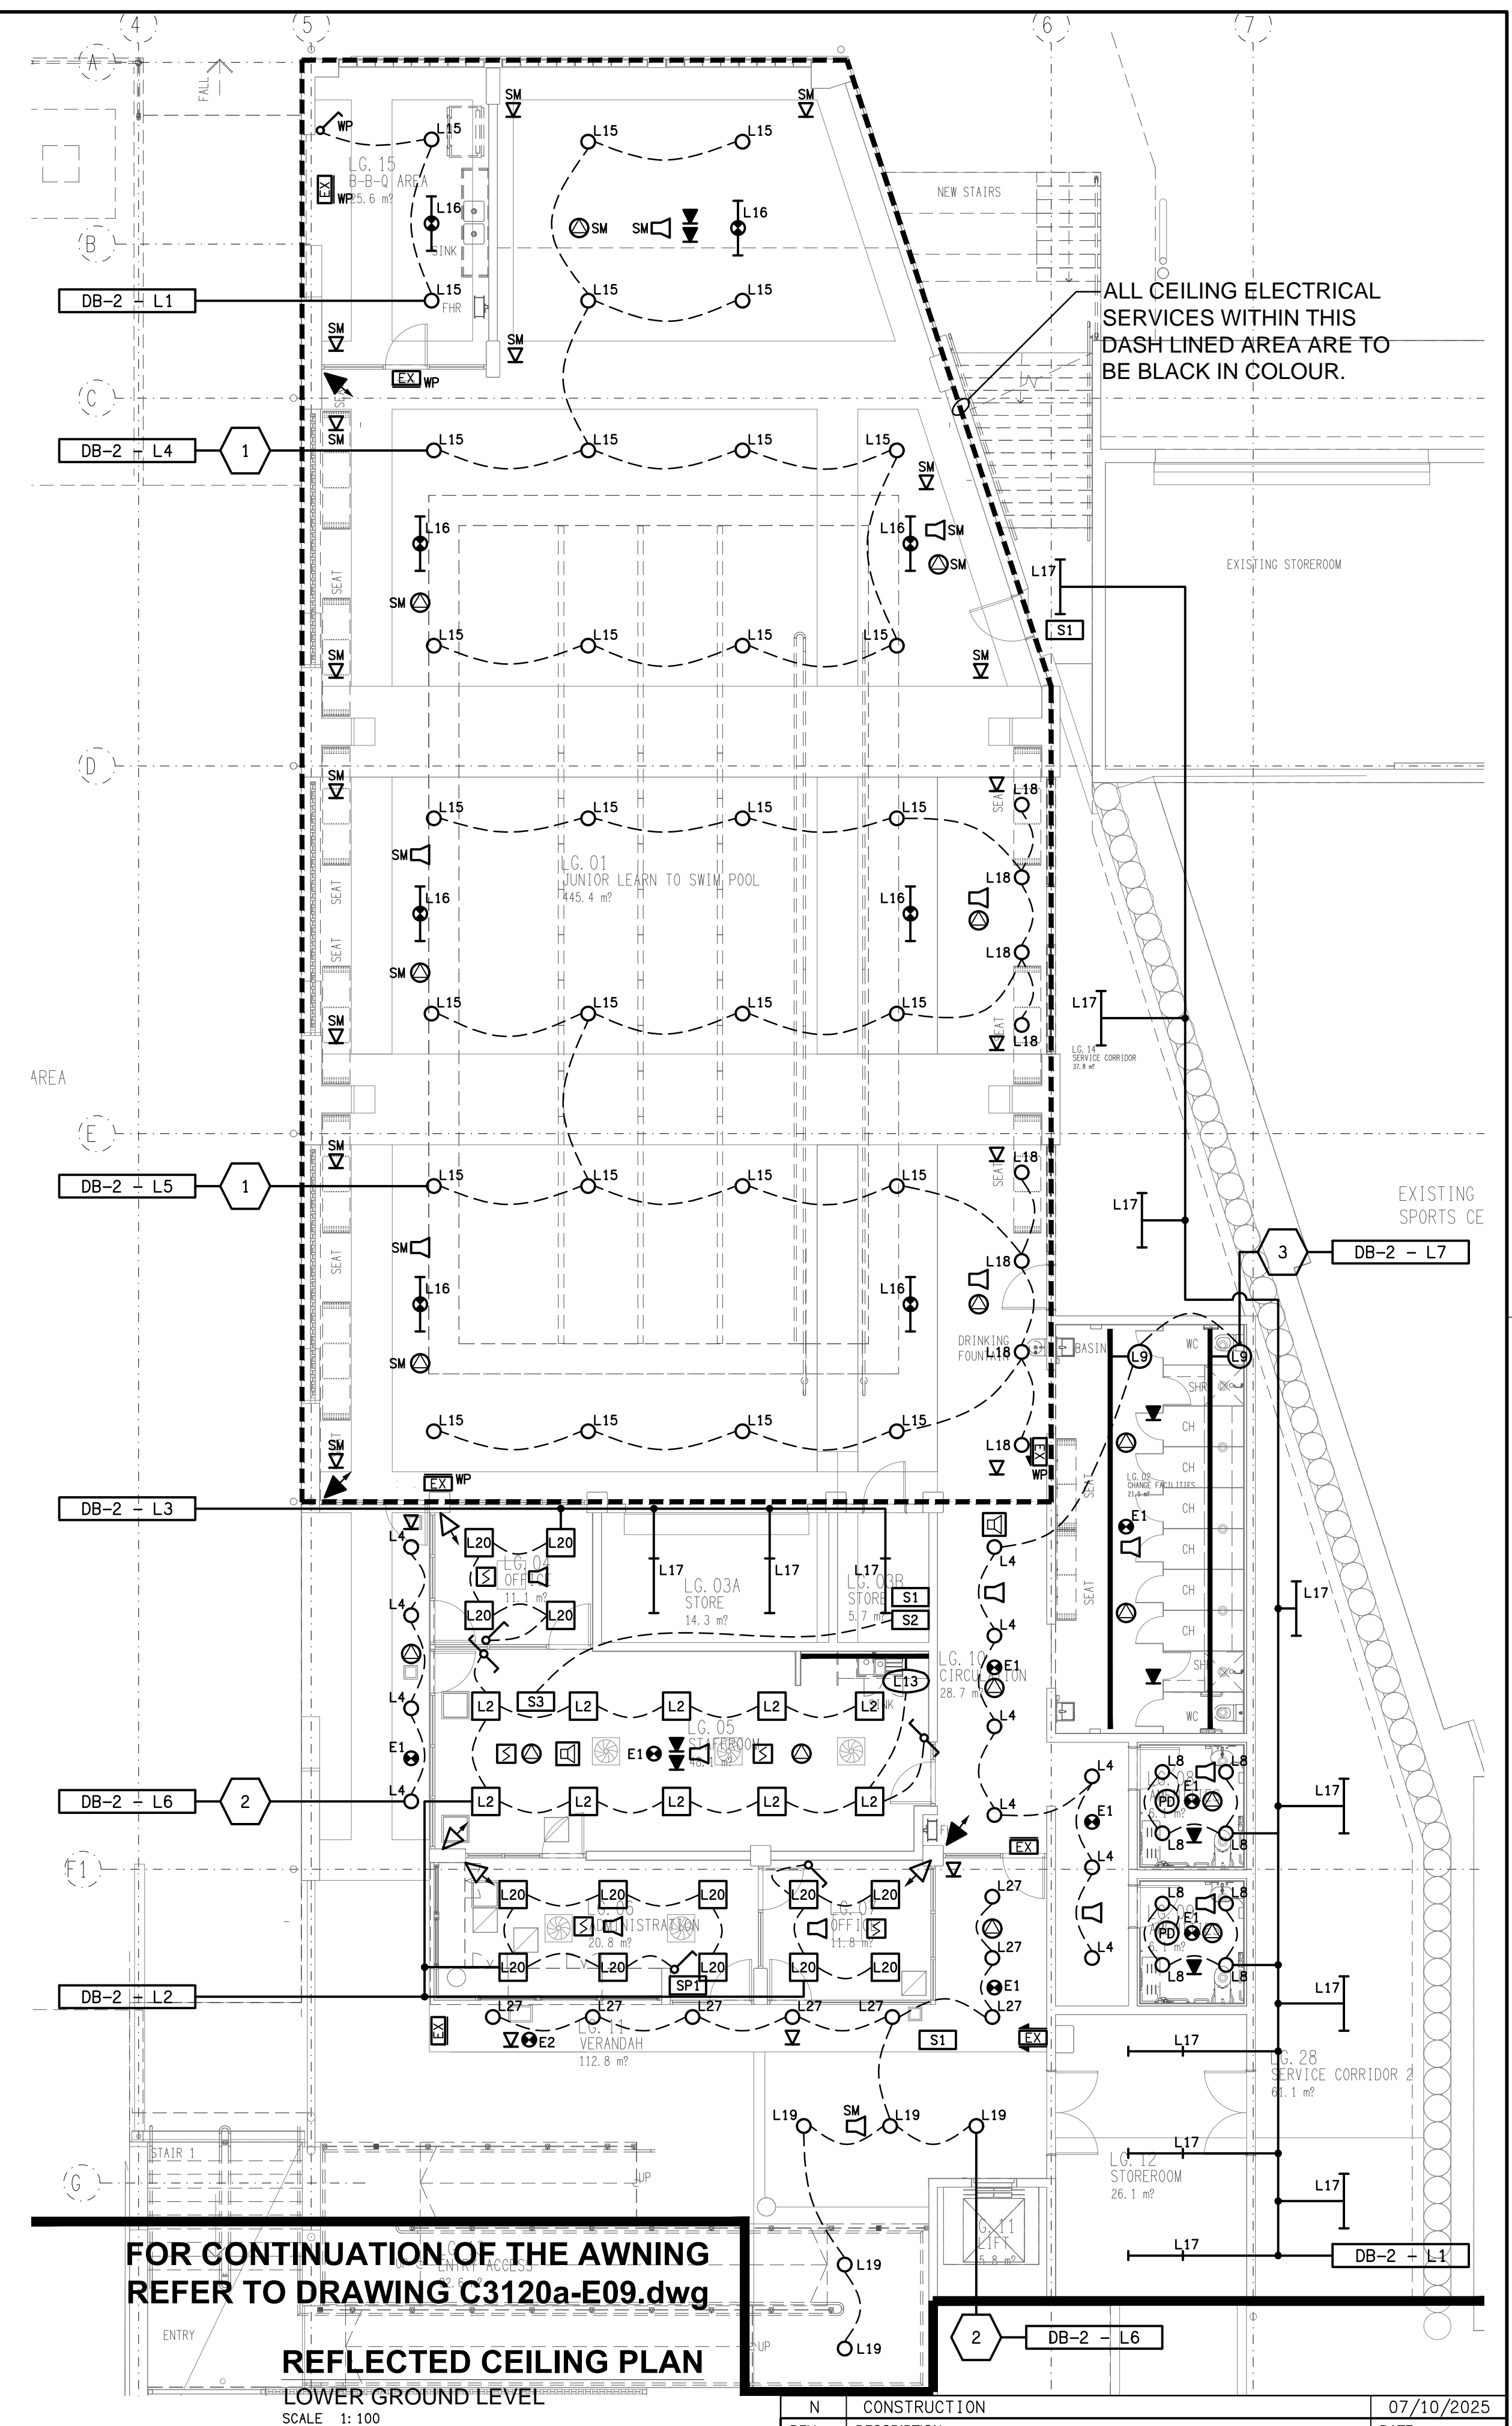

**FOR CONTINUATION OF THE AWNING
REFER TO DRAWING C3120a-E09.dwg**

REFLECTED CEILING PLAN
LOWER GROUND LEVEL
SCALE 1:100

N	CONSTRUCTION	07/10/2025
REV:	DESCRIPTION:	DATE:
DRAWING:		
ELECTRICAL SERVICES AQUATIC CENTRE LOWER GROUND PLANS		
SCALE:	PROJECT NO:	DRAWING NO:
1:100	C3120a	E03
AT A1		REVISION:
		N

PROJECT:
ST JOHN'S ANGLICAN COLLEGE
FOREST LAKE
AQUATIC CENTRE STAGE 1
COLLEGE AVENUE, FOREST LAKE