




**GROUND LEVEL**  
FLOOR PLAN  
SCALE 1: 100

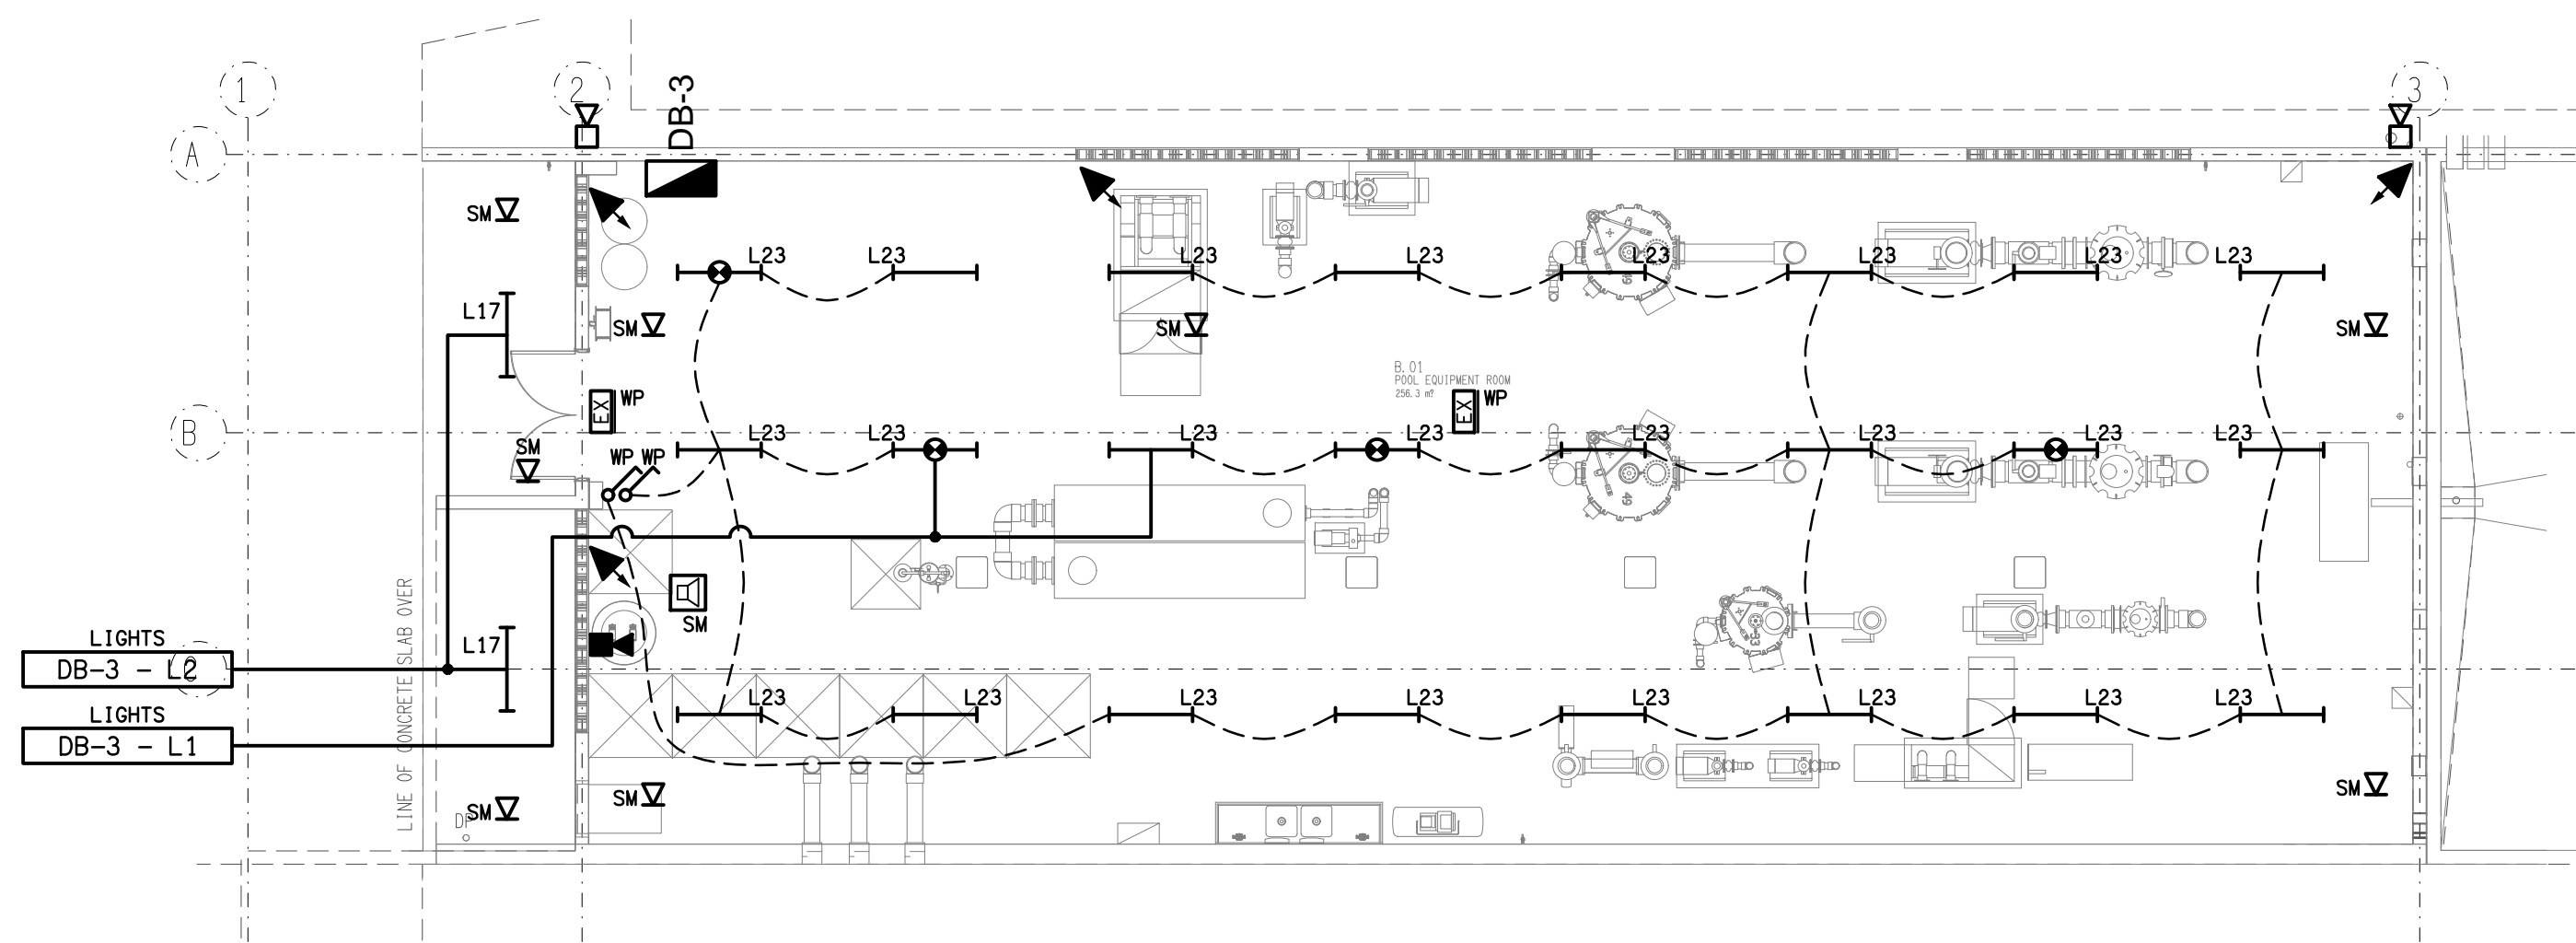


**BASEMENT LEVEL**  
REFLECTED CEILING PLAN  
SCALE 1: 100

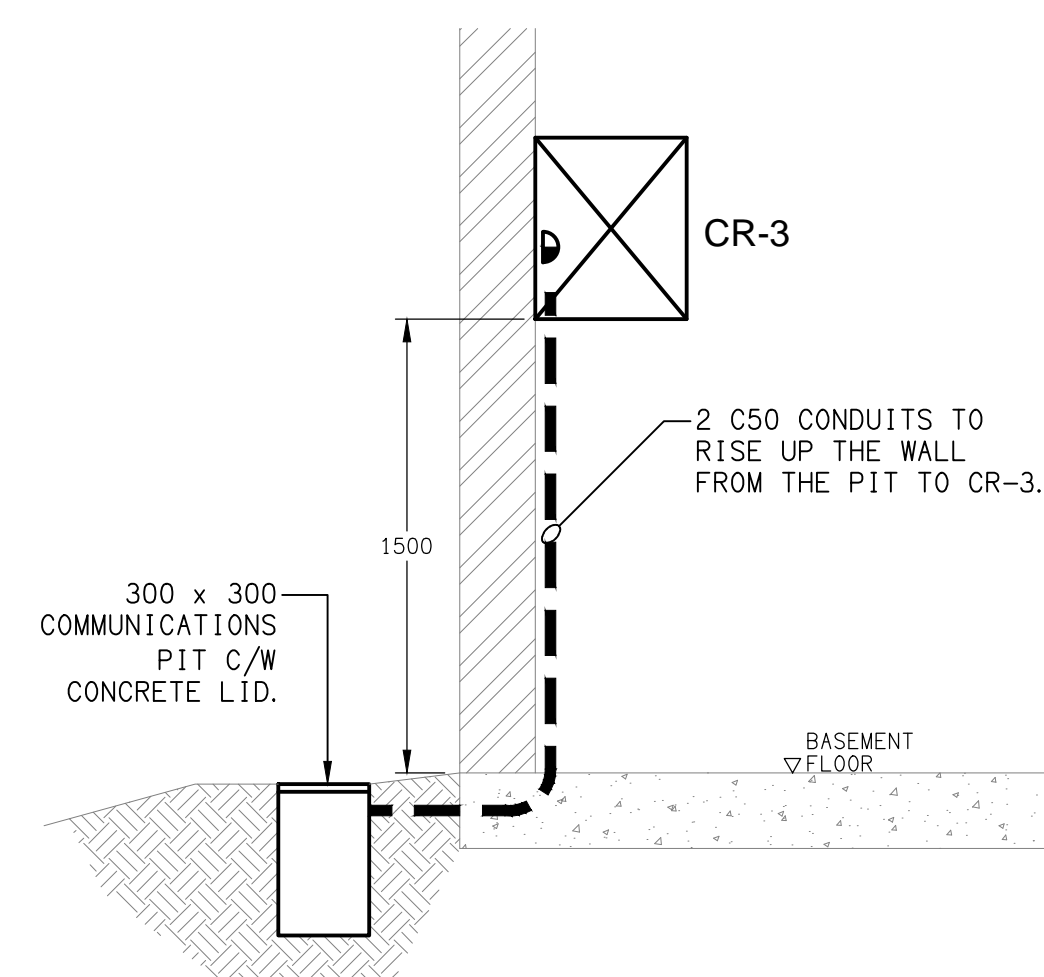

**DETAIL A**  
COMMUNICATION RACK CR-3 SECTION  
NOT TO SCALE

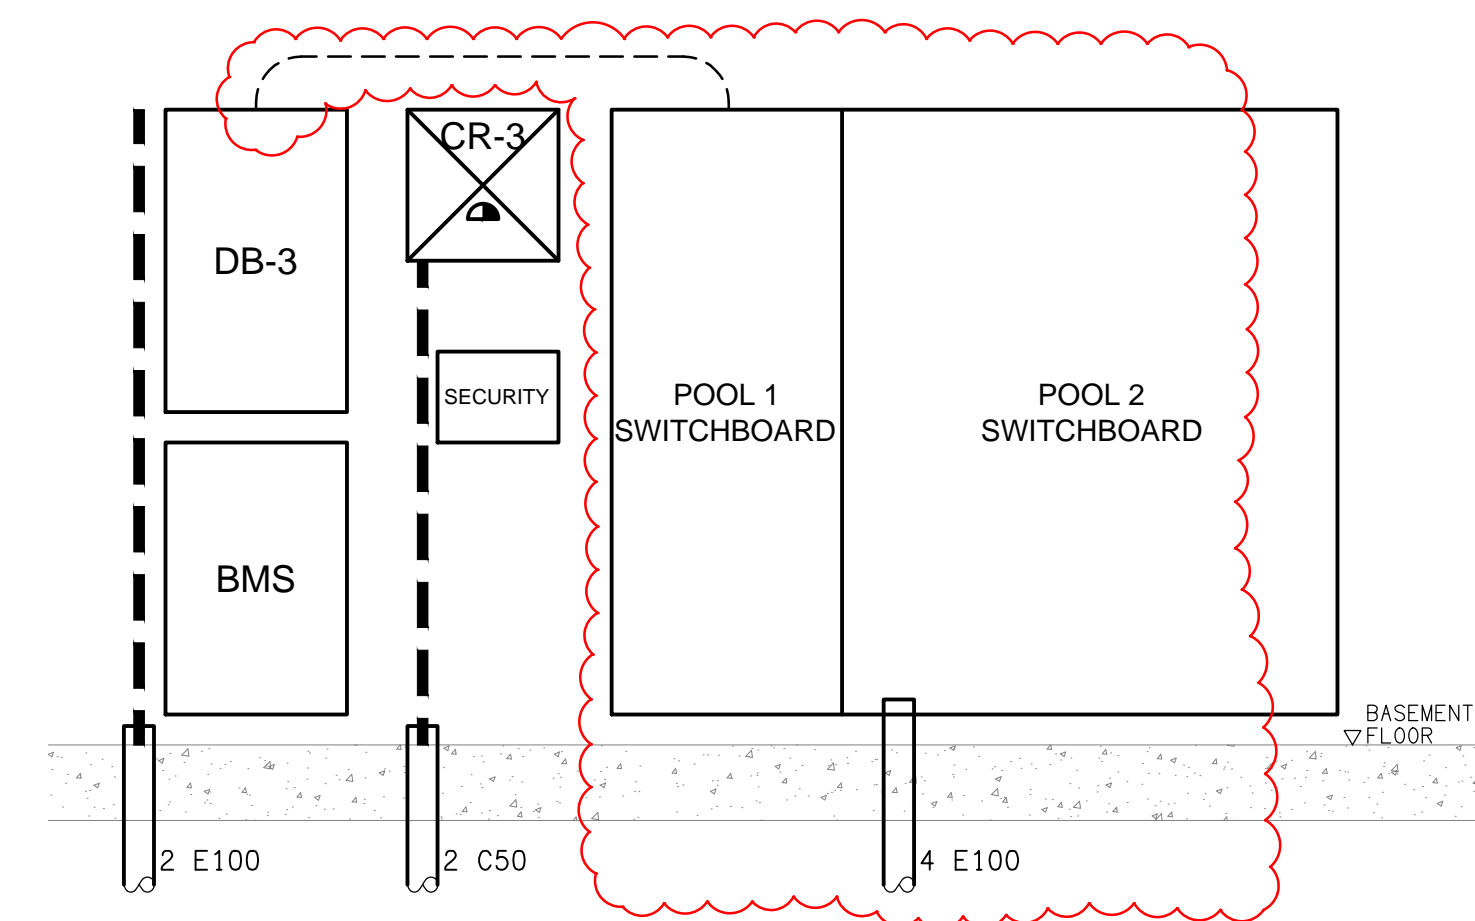

**DETAIL B**  
ELECTRICAL EQUIPMENT ELEVATION  
NOT TO SCALE

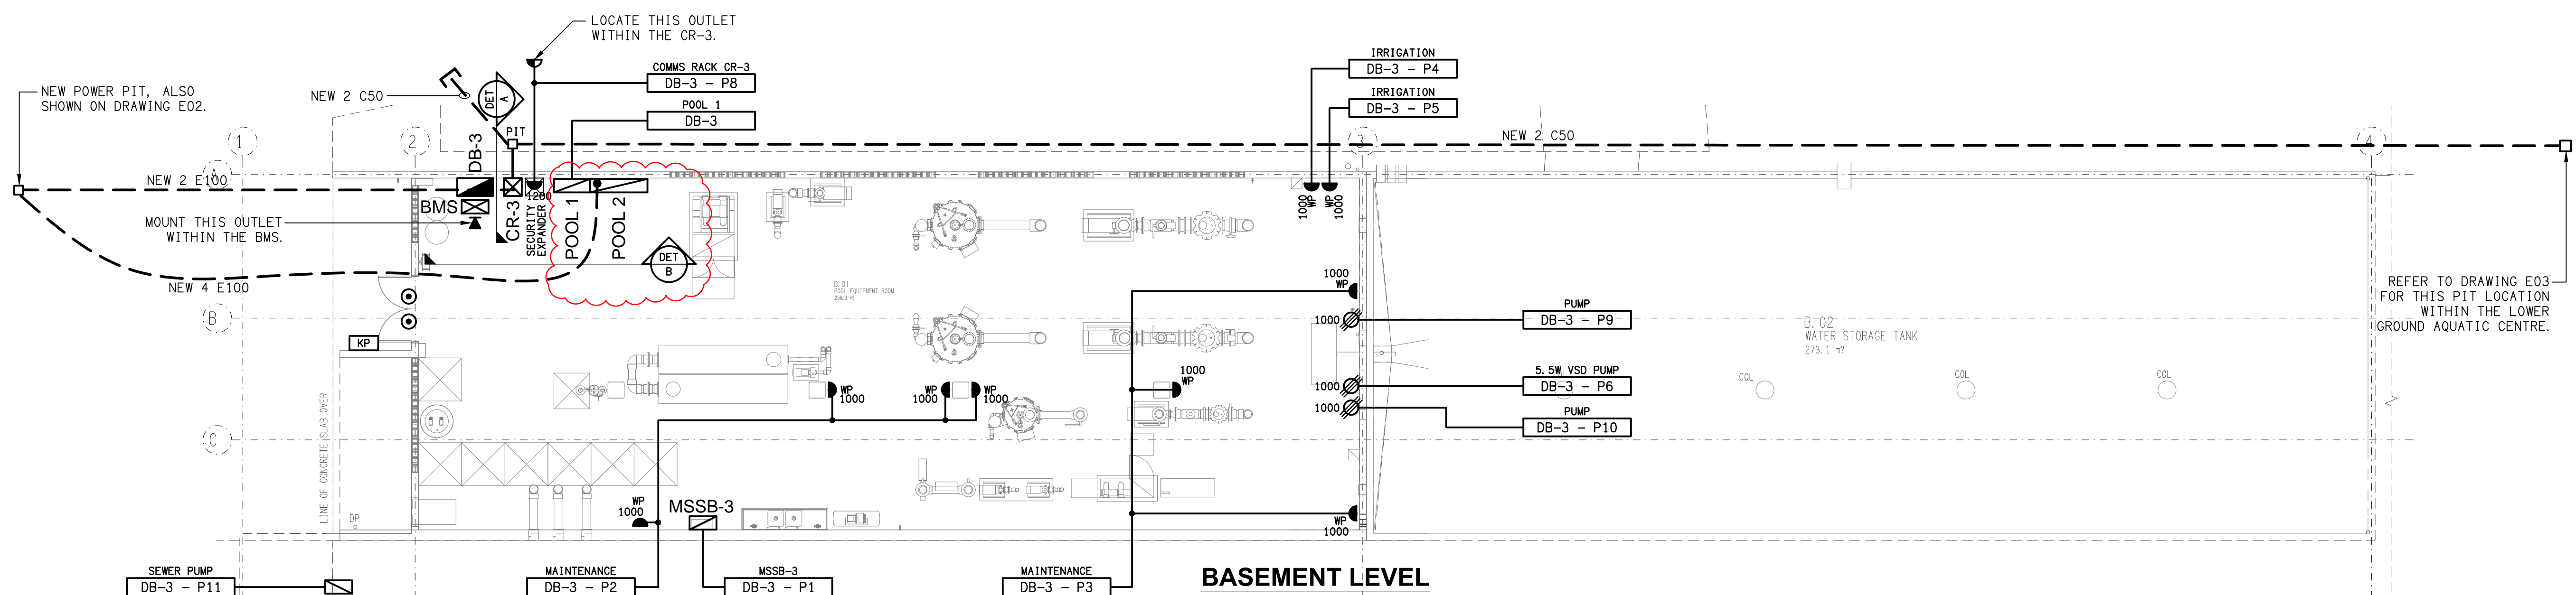

**BASEMENT LEVEL**  
FLOOR PLAN  
SCALE 1: 100

ELECTRICAL DESIGN GROUP BRISBANE  
PTY LTD  
ACN 092 710 793  
TRADING AS:  
ELECTRICAL DESIGN GROUP

THE COPYRIGHT OF THIS DRAWING  
REMAINS THE PROPERTY OF THE  
ELECTRICAL DESIGN GROUP.  
USE FIGURED DIMENSIONS  
IN PREFERENCE TO SCALE.  
ALL DIMENSIONS TO BE  
VERIFIED ONSITE.

**ELECTRICAL DESIGN GROUP**  
ELECTRICAL BUILDING SERVICES CONSULTANTS  
BRISBANE GOLD COAST  
P.O. Box 15, Sherwood Q.4075  
Phone: (07) 3278 4375  
Email: brisbane@edg.net.au  
Web: www.edg.net.au

PROJECT:  
**ST JOHN'S ANGLICAN COLLEGE  
FOREST LAKE  
AQUATIC CENTRE STAGE 1  
COLLEGE AVENUE, FOREST LAKE**

G	CONSTRUCTION	02/06/2025
REV:	DESCRIPTION:	DATE:

DRAWING: <b>ELECTRICAL SERVICES POOL EQUIPMENT BUILDING PLANS</b>	PROJECT NO: <b>C3120a</b>	DRAWING NO: <b>E07</b>	REVISION: <b>G</b>
SCALE: 1:100	AT A1		