



NORTH
EXTERNAL BUILDING ELEVATION
SCALE 1: 100

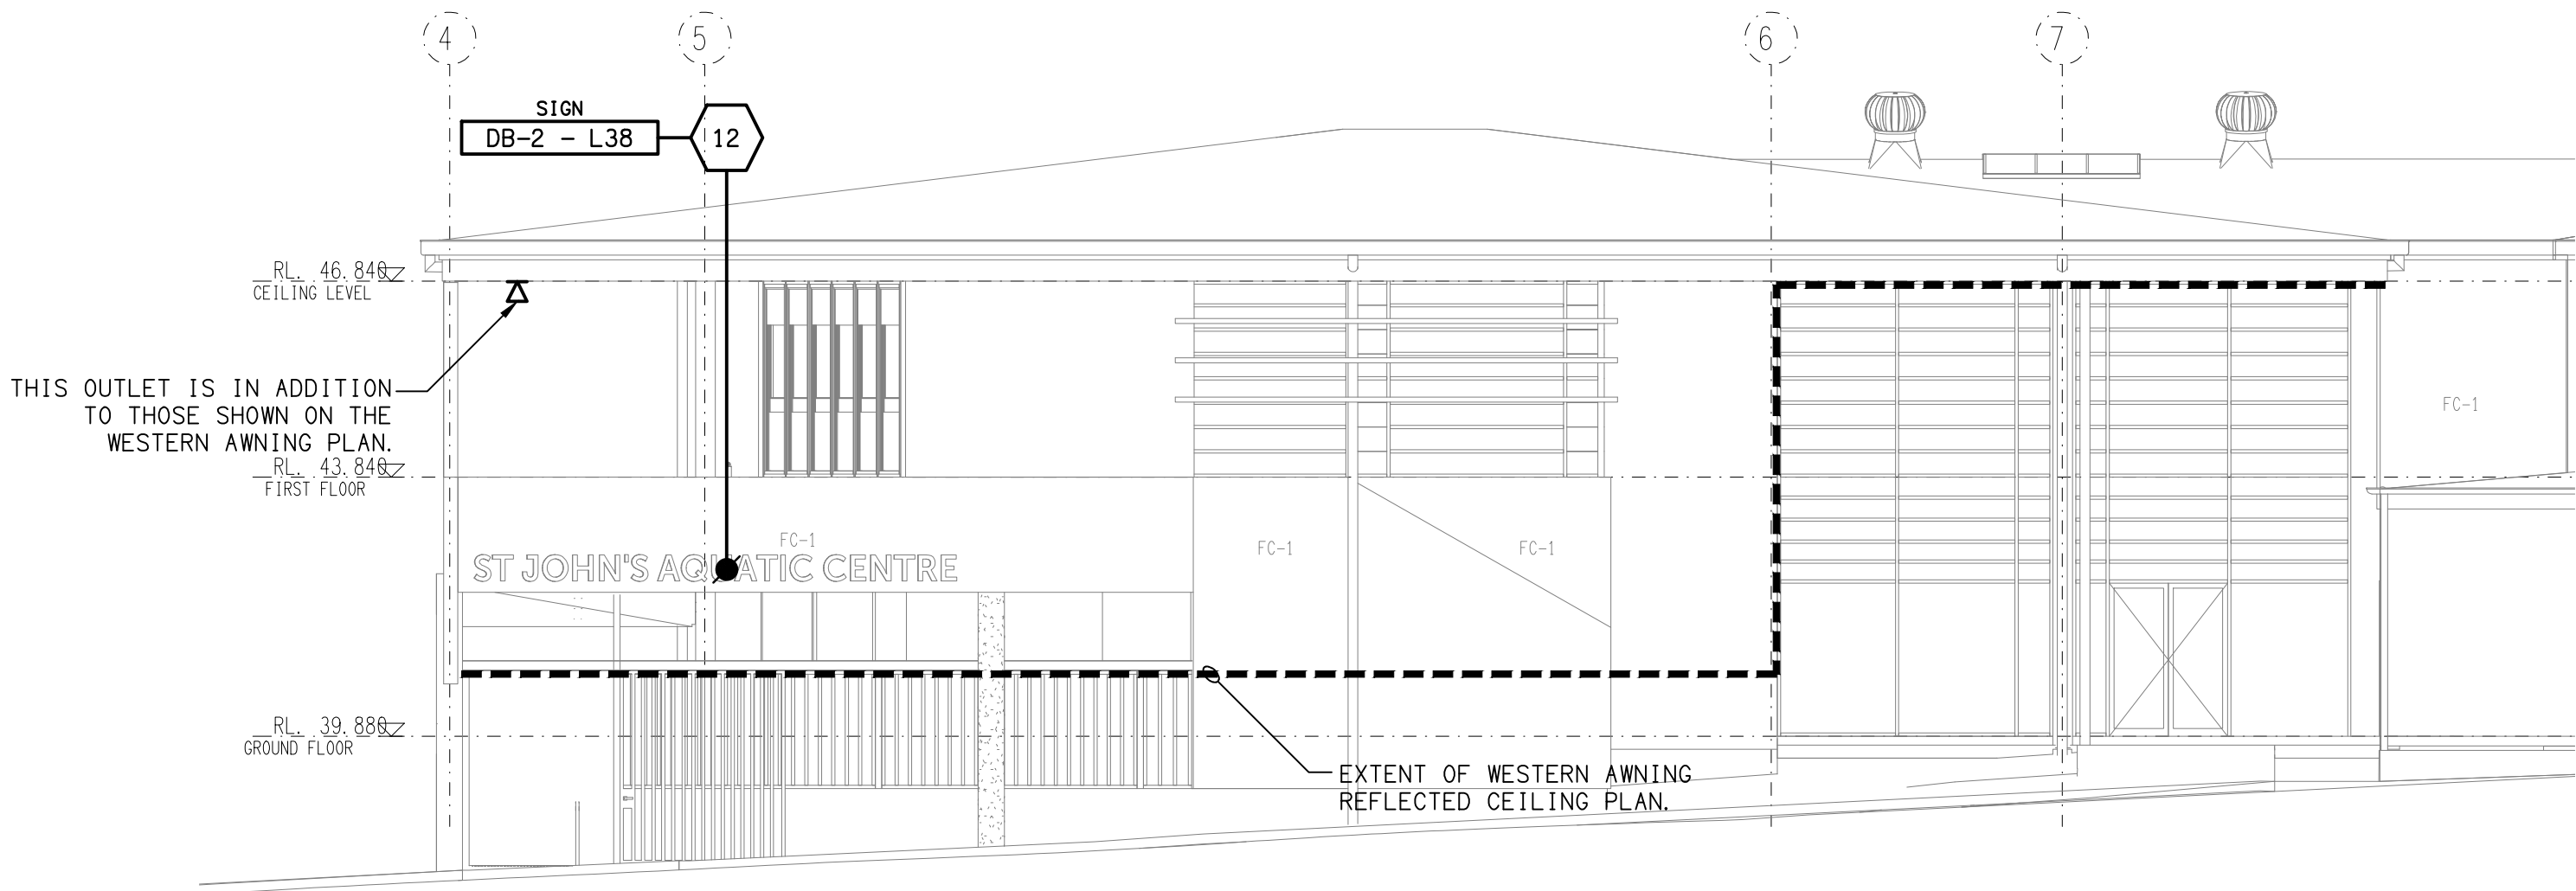

WEST
EXTERNAL BUILDING ELEVATION
SCALE 1: 100

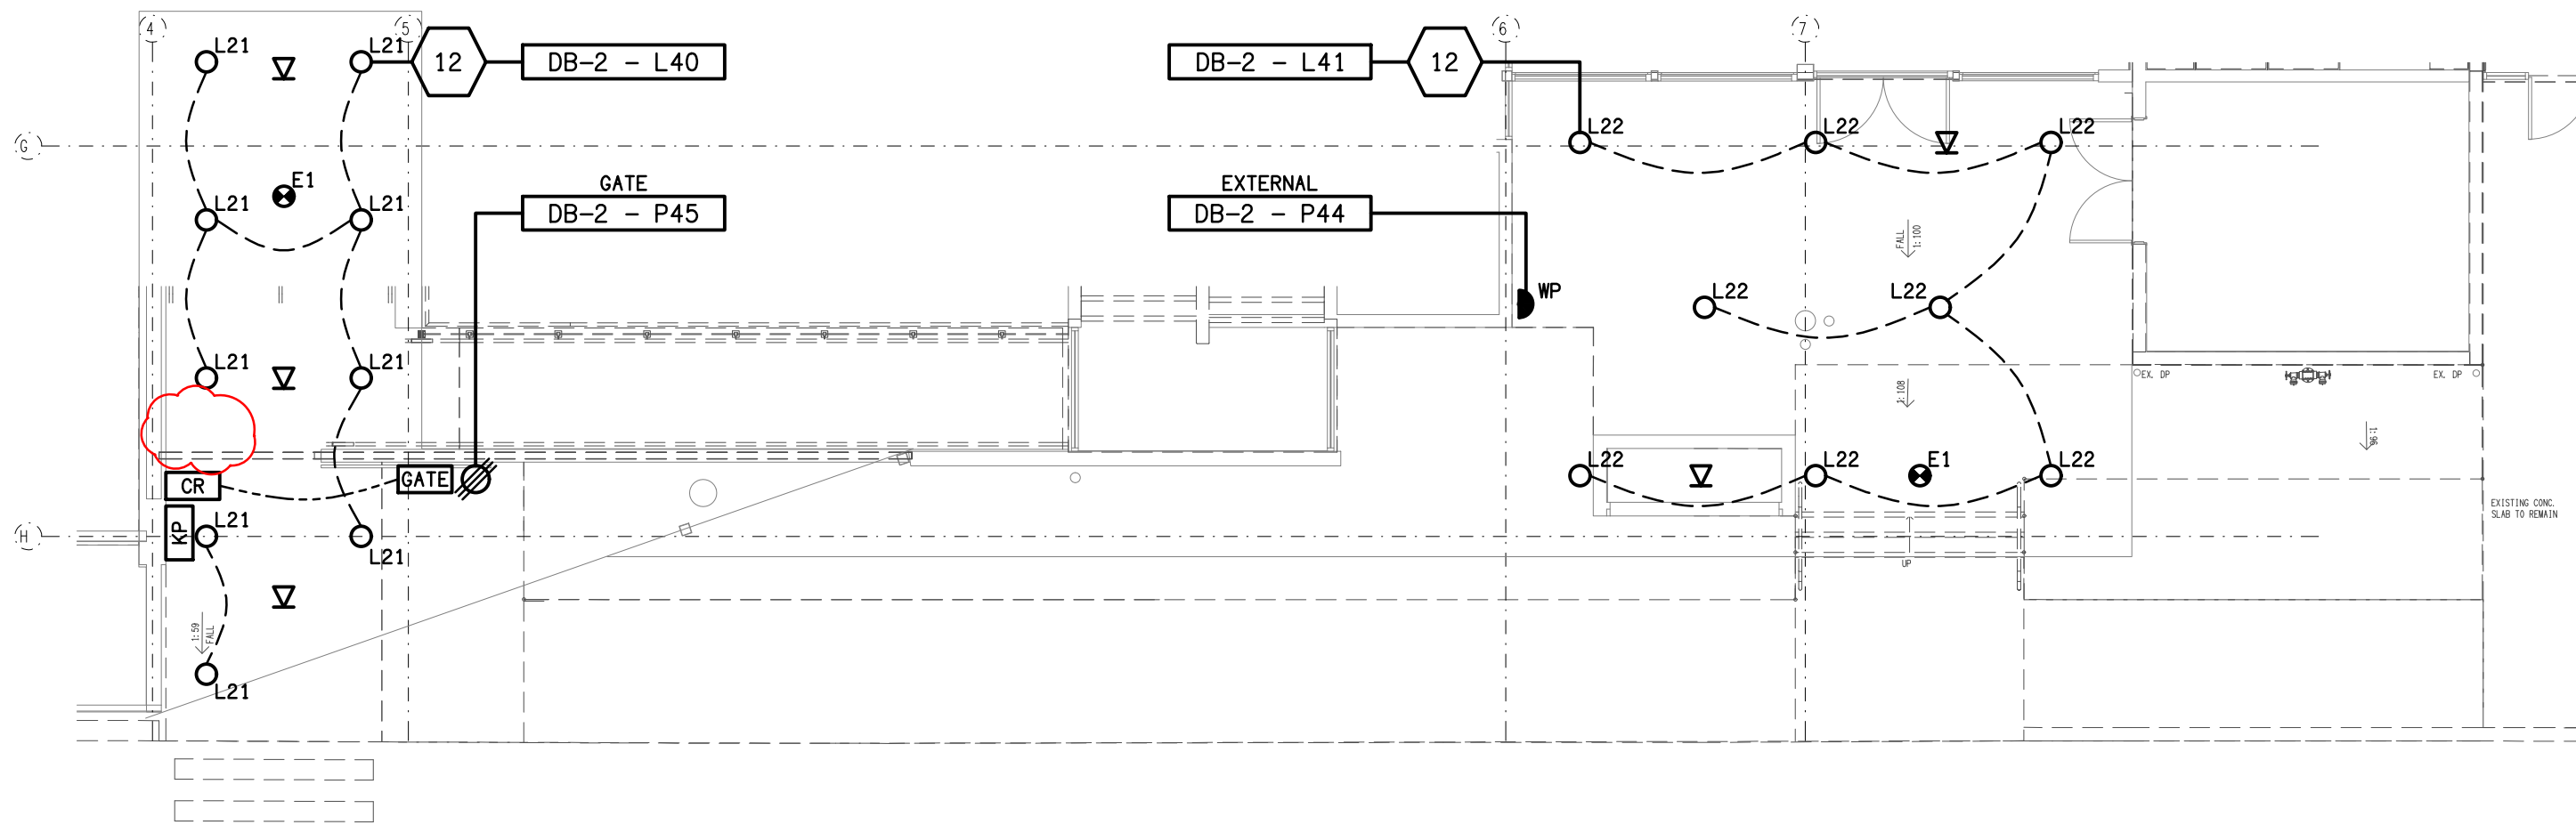

WESTERN AWNING
FLOOR / REFLECTED CEILING PLAN
SCALE 1: 100

ELECTRICAL DESIGN GROUP BRISBANE
PTY LTD
ACN 092 710 793
TRADING AS:
ELECTRICAL DESIGN GROUP

THE COPYRIGHT OF THIS DRAWING
REMAINS THE PROPERTY OF THE
ELECTRICAL DESIGN GROUP.
USE FIGURED DIMENSIONS
IN PREFERENCE TO SCALE.
ALL DIMENSIONS TO BE
VERIFIED ONSITE.

ELECTRICAL DESIGN GROUP
ELECTRICAL BUILDING SERVICES CONSULTANTS
BRISBANE GOLD COAST

P.O.Box 15, Sherwood Q.4075
Phone: (07) 3278 4375
Email: brisbane@edg.net.au
Web: www.edg.net.au

PROJECT:
**ST JOHN'S ANGLICAN COLLEGE
FOREST LAKE
AQUATIC CENTRE STAGE 1**
COLLEGE AVENUE, FOREST LAKE

D	CONSTRUCTION	06/08/2025
REV.	DESCRIPTION:	DATE:

DRAWING: ELECTRICAL SERVICES WESTERN AWNING PLAN & EXTERNAL ELEVATIONS	PROJECT NO: C3120a	DRAWING NO: E09	REVISION: D
SCALE: 1:100	AT A1		