



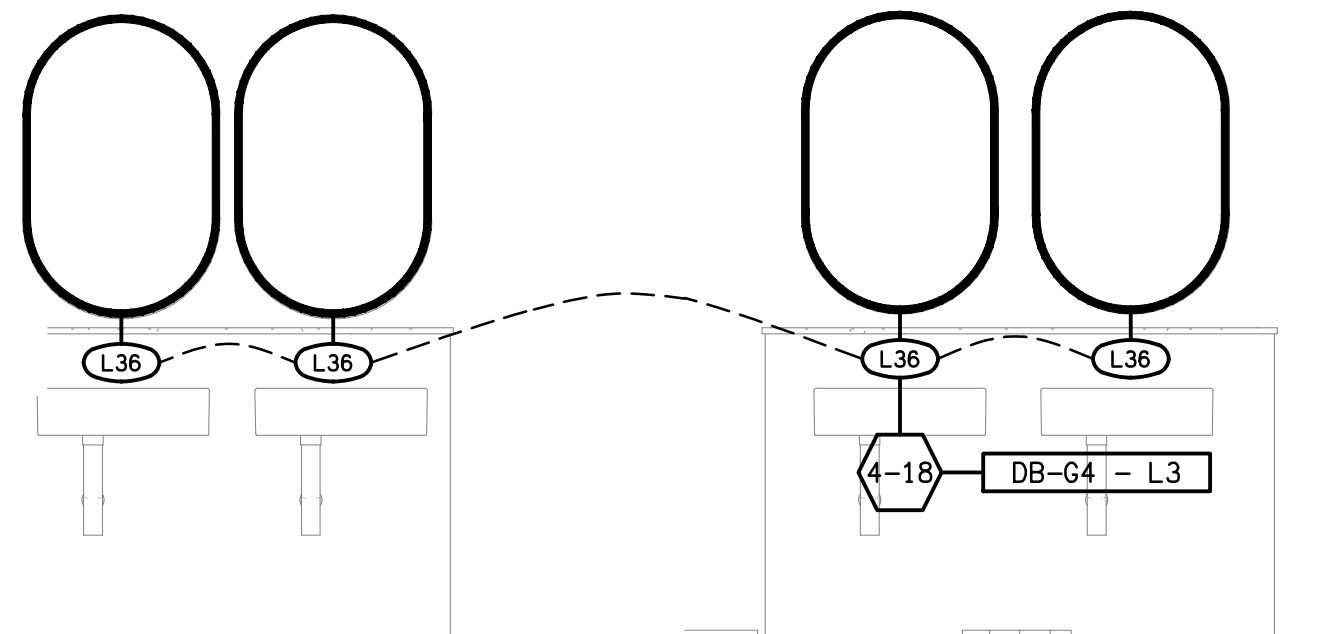

DETAIL A
FEMALE WC ELEVATION
SCALE 1:25

DETAIL B
MALE WC ELEVATION
SCALE 1:25

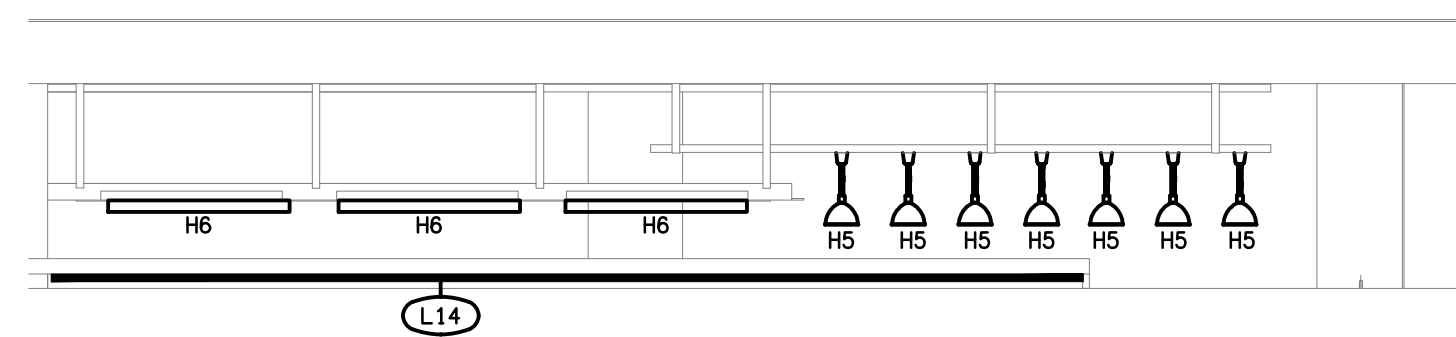

DETAIL D
SERVERY COUNTER ELEVATION
SCALE 1:50

**ELECTRICAL SERVICES
WITHIN THIS DASH LINED
AREA ARE TO BE REMOVED**

- DB-G8 - L2 8-3
- DB-G8 - L13 8-27
- DB-G8 - L12 8-24
- DB-G8 - L12 8-23
- DB-G8 - L12 8-22
- DB-G8 - L2 8-4
- DB-G8 - L17 8-41
- DB-G8 - L2 8-5
- DB-G8 - L2 8-6
- DB-G5 - L1 5-2
- DB-G5 - L1 5-14
- DB-G5 - L1 5-3
- DB-G8 - L18 8-36
- DB-G4 - L1 4-1
- DB-G4 - L1 4-13
- DB-G5 - L1 5-2
- DB-G4 - L1 4-2
- DB-G5 - L1 5-13
- DB-G5 - L1 5-2
- DB-G4 - L1 4-2
- DB-G4 - L1 4-14
- DB-G4 - L2 4-15

- DB-G8 - L15 8-32
- DB-G8 - L15 8-31
- DB-G8 - L14 8-30
- DB-G8 - L12 8-26
- DB-G8 - L12 8-25

- DB-G8 - L4
- DB-G8 - L5
- DB-G8 - L6
- DB-G8 - L6
- DB-G8 - L11
- DB-G8 - L14
- DB-G8 - L11
- DB-G8 - L13
- DB-G8 - L6
- DB-G8 - L11
- DB-G8 - L10
- DB-G8 - L7
- DB-G8 - L18
- DB-G8 - L6
- DB-G8 - L9
- DB-G8 - L18
- DB-G4 - L4
- DB-G4 - P4
- DB-G4 - P5
- DB-G8 - L8
- DB-G4 - L1
- DB-G4 - L3
- DB-G4 - L3

THE COPYRIGHT OF THIS DRAWING REMAINS THE PROPERTY OF
THE ELECTRICAL DESIGN GROUP.

USE FIGURED DIMENSIONS IN PREFERENCE TO SCALE.

ALL DIMENSIONS TO BE VERIFIED ONSITE.

J	CONSTRUCTION	16/10/2025
REV:	DESCRIPTION:	DATE:

ELECTRICAL DESIGN GROUP
ELECTRICAL BUILDING SERVICES CONSULTANTS

BRISBANE: P.O. Box 15 Sherwood Qld 4075
Phone: (07) 3278 4375
Email: brisbane@edg.net.au
Web: www.edg.net.au

ELECTRICAL DESIGN GROUP BRISBANE PTY LTD
ACN 092 710 793

TRADING AS:
ELECTRICAL DESIGN
GROUP

PROJECT:
**SUNNYBANK COMMUNITY
SPORTS CLUB**

SITE ADDRESS:
470 McCULLOUGH STREET
SUNNYBANK

SCALE: 1:100 UNO SHEET SIZE: AT A1

DRAWING TITLE:

**ELECTRICAL SERVICES
BISTRO & BAR
REFLECTED CEILING PLAN**

PROJECT NO: DRAWING NO: REVISION:

C3179a E06 J