



FLOOR PLAN
HALL REFURBISHMENT
SCALE 1:100

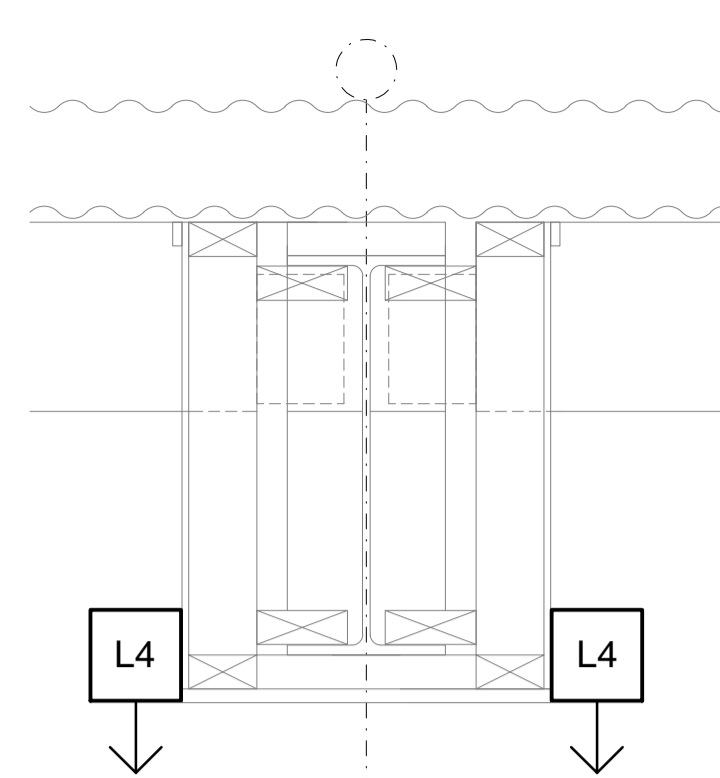

DETAIL A
L4 LIGHT MOUNTING
NOT TO SCALE

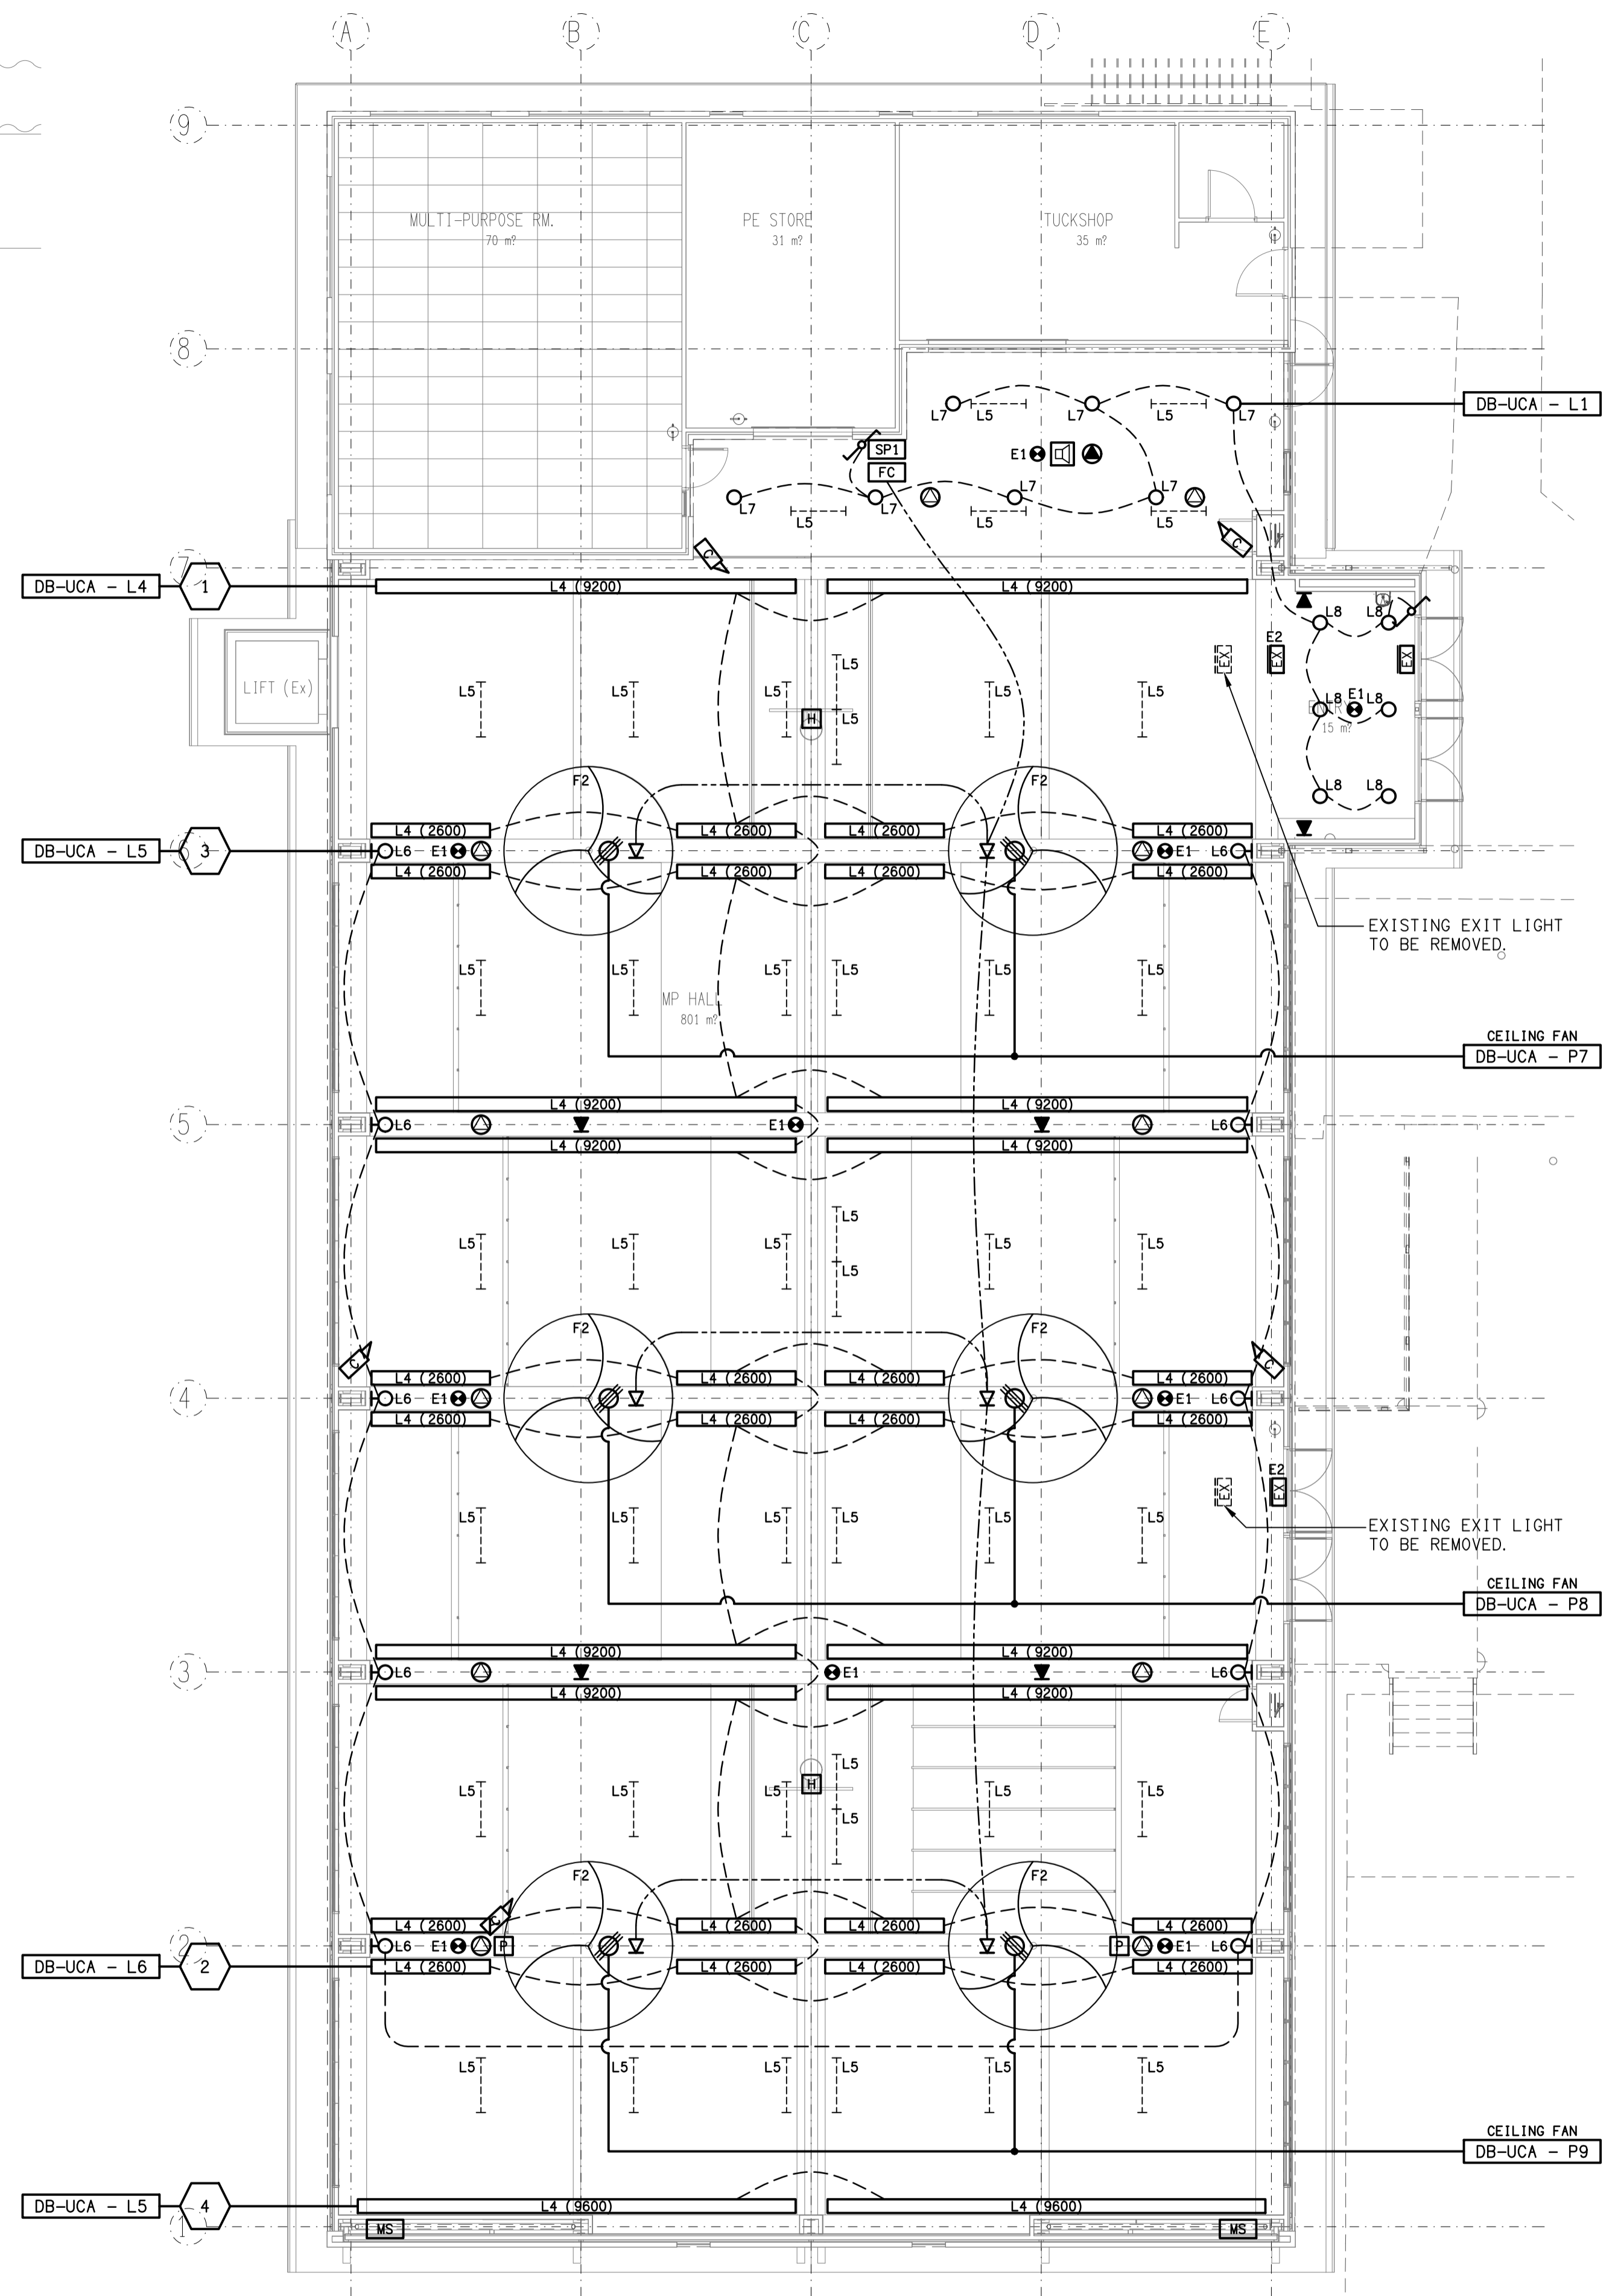

REFLECTED CEILING PLAN
HALL REFURBISHMENT
SCALE 1:100