



NOTE:
CORRUGATED CONDUIT IS NOT TO BE USED
IN THE AREAS SHOWN ON THIS PLAN.

THE COPYRIGHT OF THIS DRAWING REMAINS THE PROPERTY OF
THE ELECTRICAL DESIGN GROUP.


USE FIGURED DIMENSIONS IN PREFERENCE TO SCALE.

ALL DIMENSIONS TO BE VERIFIED ONSITE.


BURGER URGE

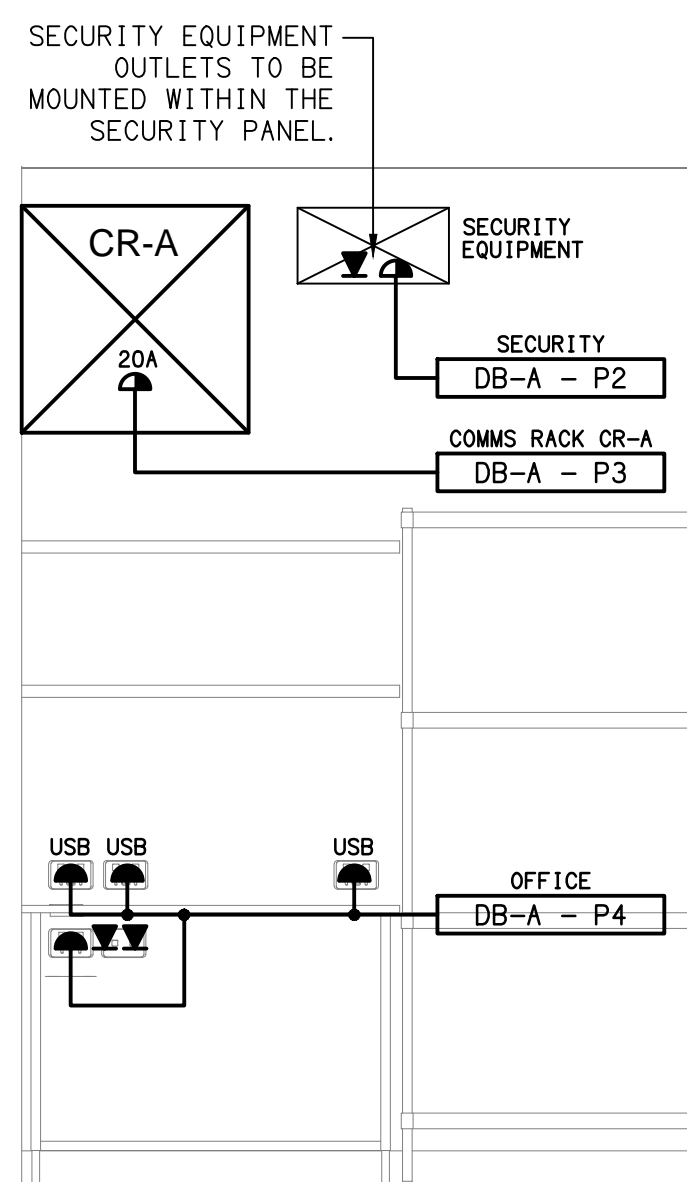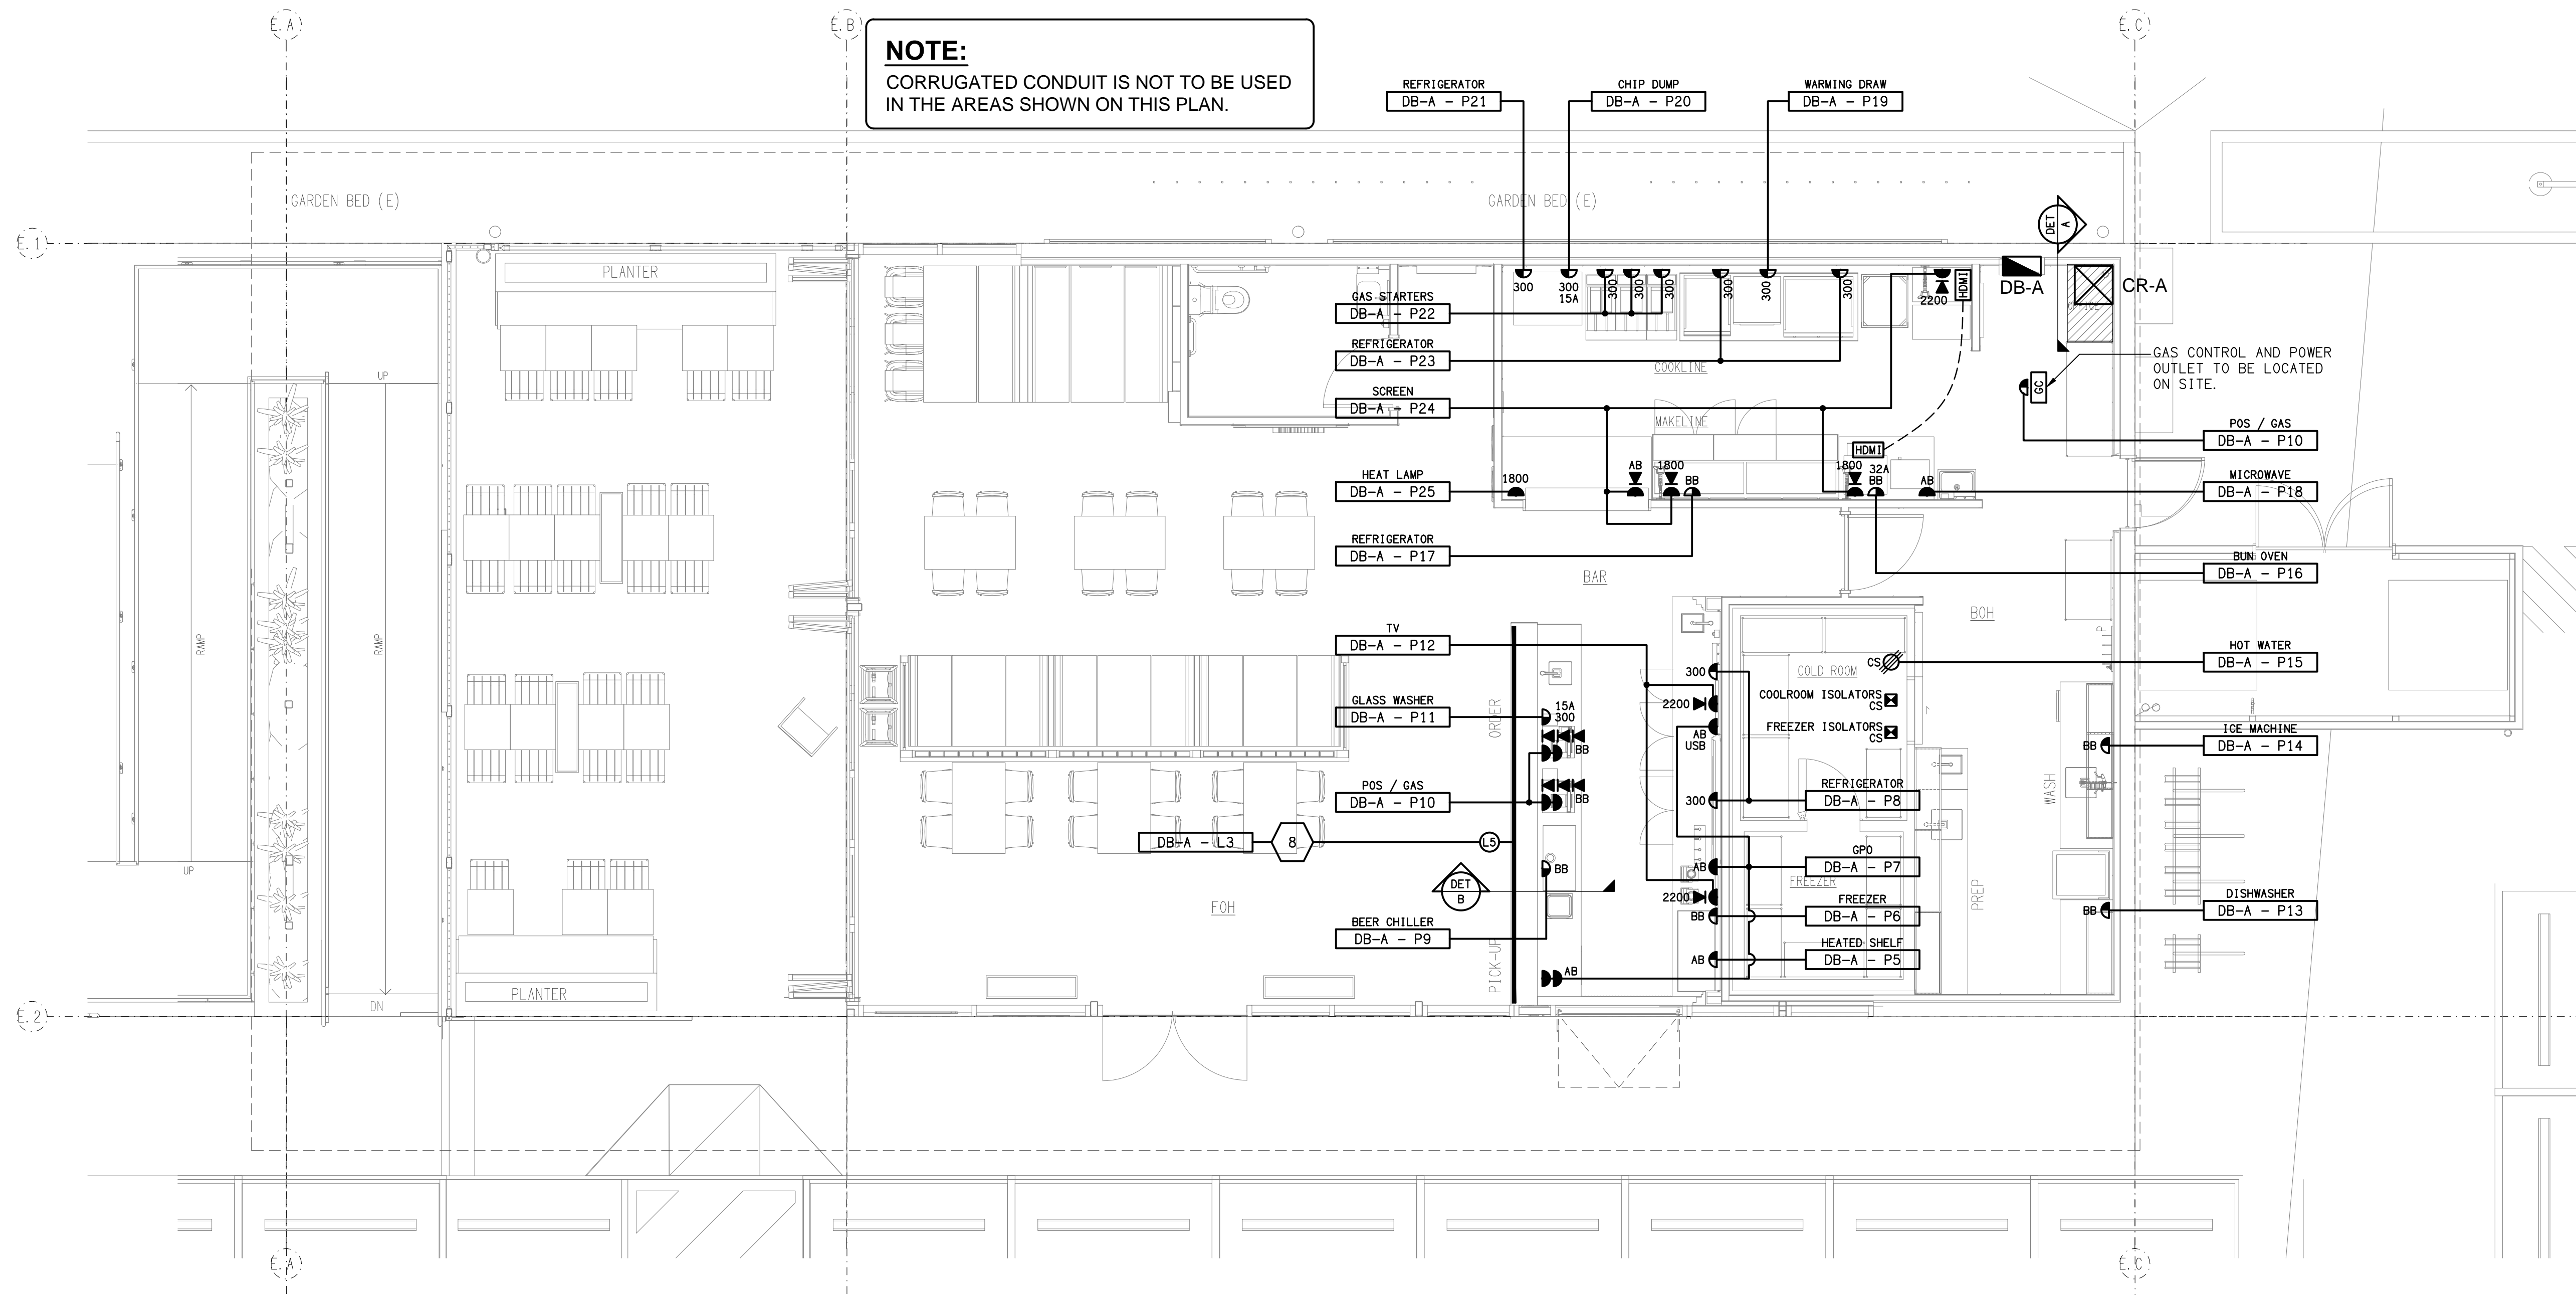

DETAIL A
MANAGERS ELEVATION
SCALE 1: 20

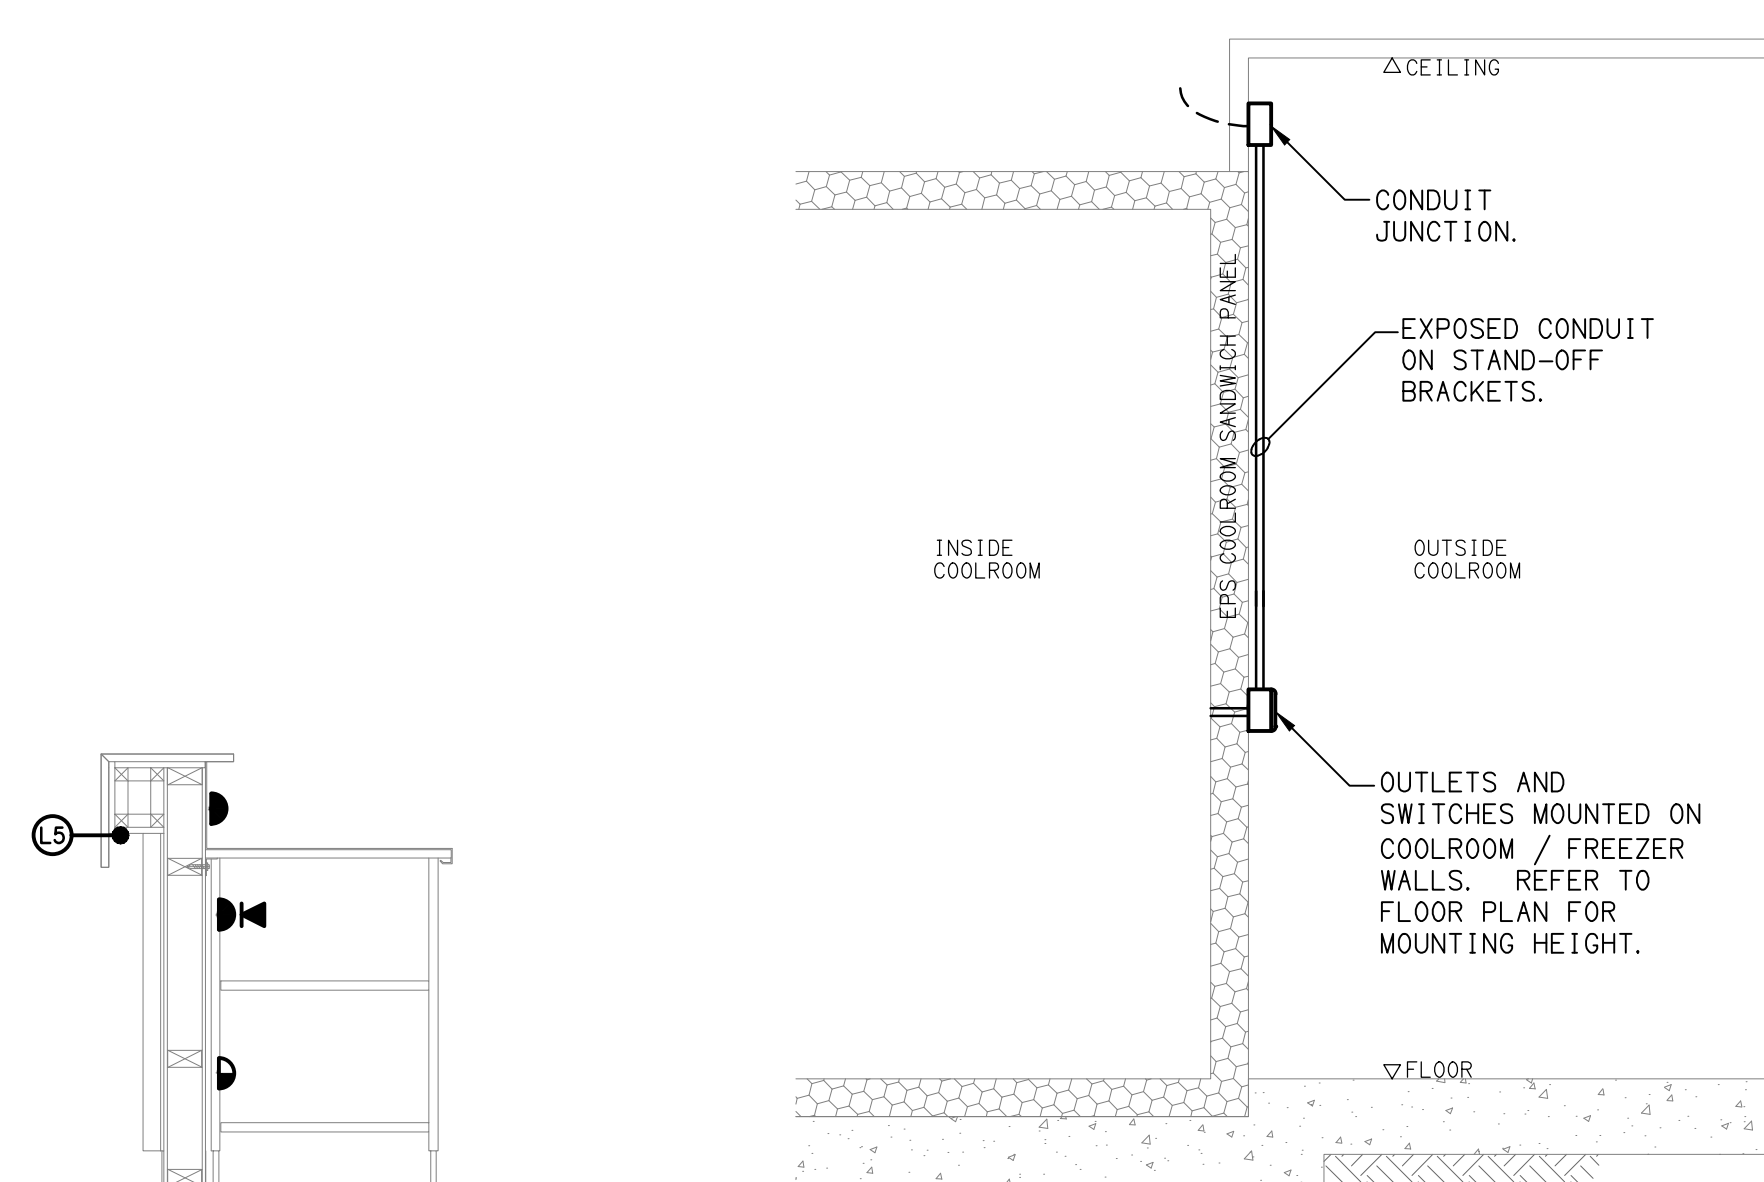

DETAIL B
SERVERY COUNTER SECTION
SCALE 1: 20

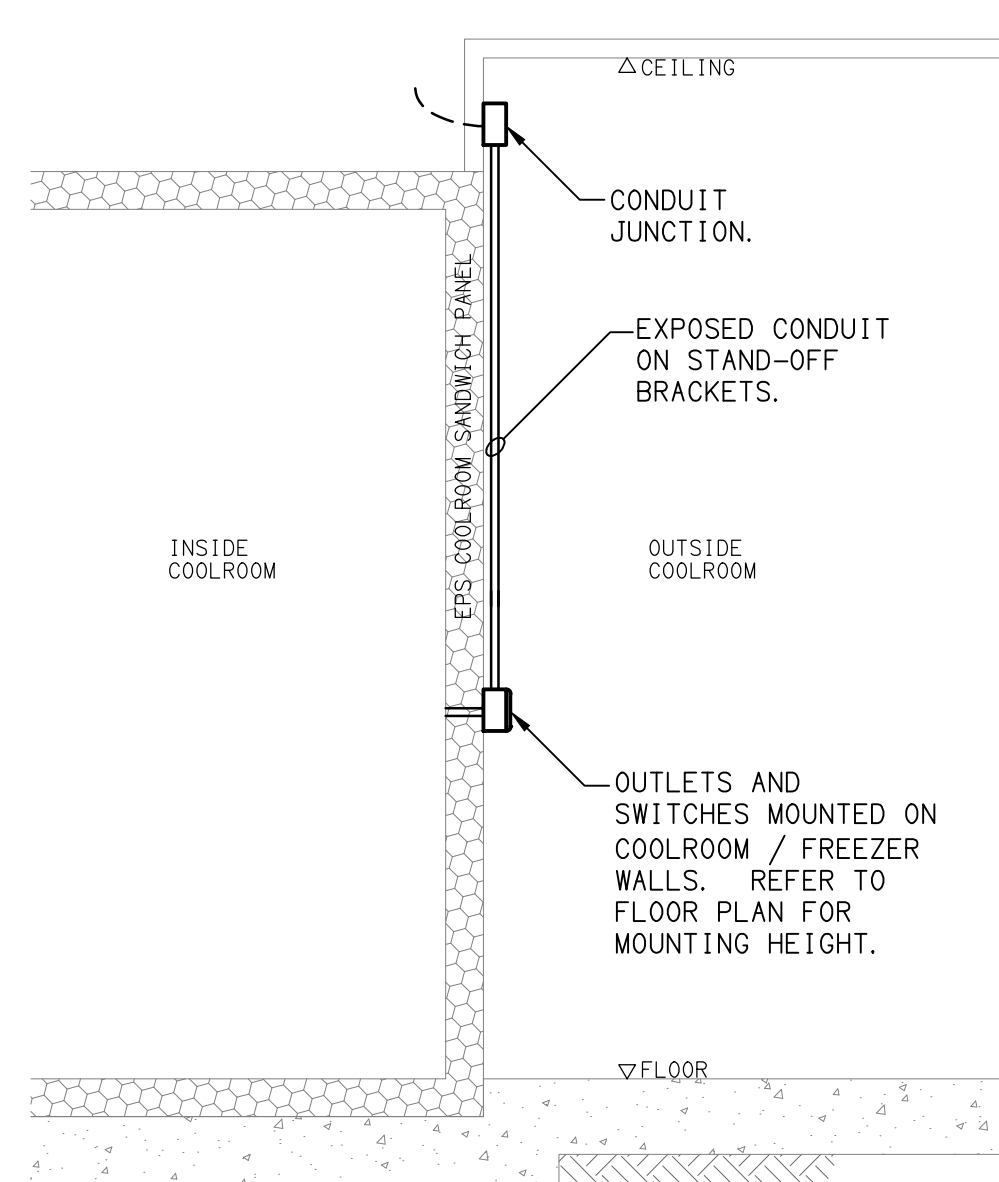

DETAIL C
COOLROOM / FREEZER OUTLETS
NOT TO SCALE

B	PRELIMINARY	27/06/2025
REV:	DESCRIPTION:	DATE:

ELECTRICAL DESIGN GROUP
ELECTRICAL BUILDING SERVICES CONSULTANTS

BRISBANE: P.O. Box 15, Sherwood Qld 4075
Phone: (07) 3278 4375
Email: brisbane@edg.net.au
Web: www.edg.net.au

ELECTRICAL DESIGN GROUP BRISBANE PTY LTD
ACN 092 710 793

TRADING AS:
ELECTRICAL DESIGN
GROUP

PROJECT:

**BURGER URGE
WILSONTON**

SITE ADDRESS:

CORNER BRIDGE STREET &
RICHMOND DRIVE, WILSONTON,
QUEENSLAND

SCALE: SHEET SIZE:

1:50 UNO AT A1

DRAWING TITLE:

**ELECTRICAL SERVICES
FLOOR PLAN**

PROJECT NO: DRAWING NO: REVISION:

C3520a E03 B