



SCHEMATIC

MSB CONFIGURATION
NOT TO SCALE

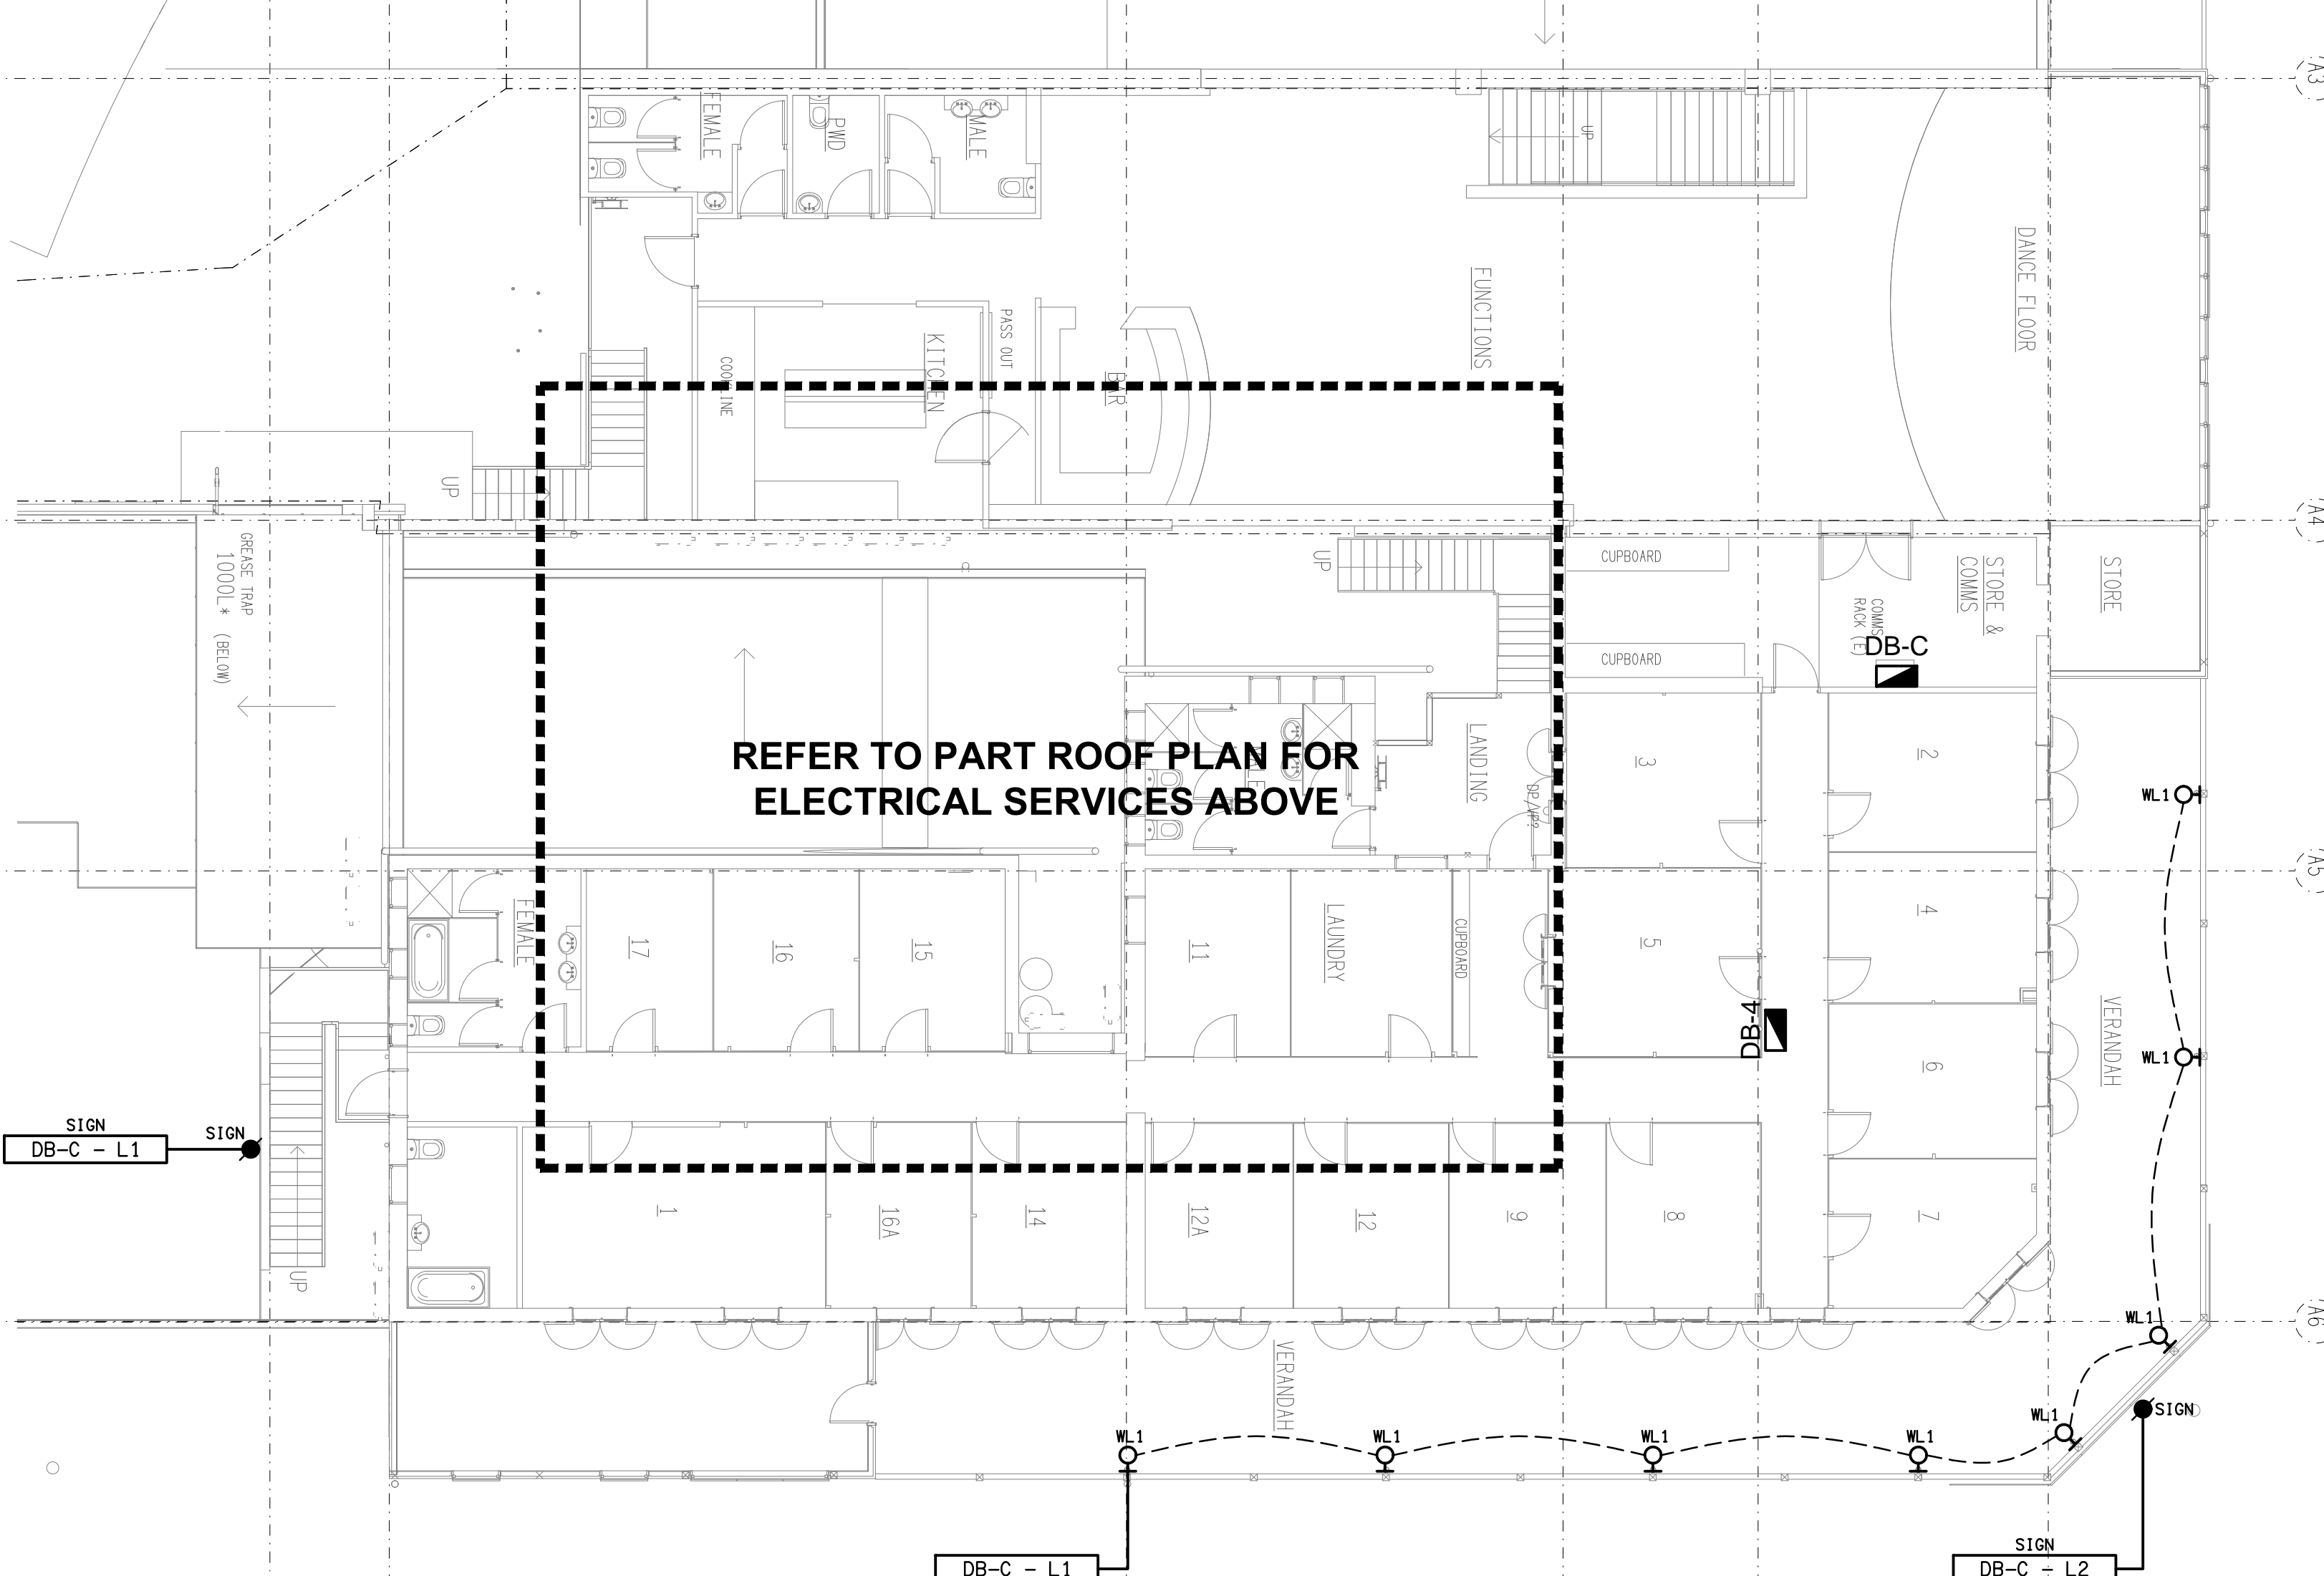

LEVEL 1
FLOOR PLAN
SCALE 1: 100

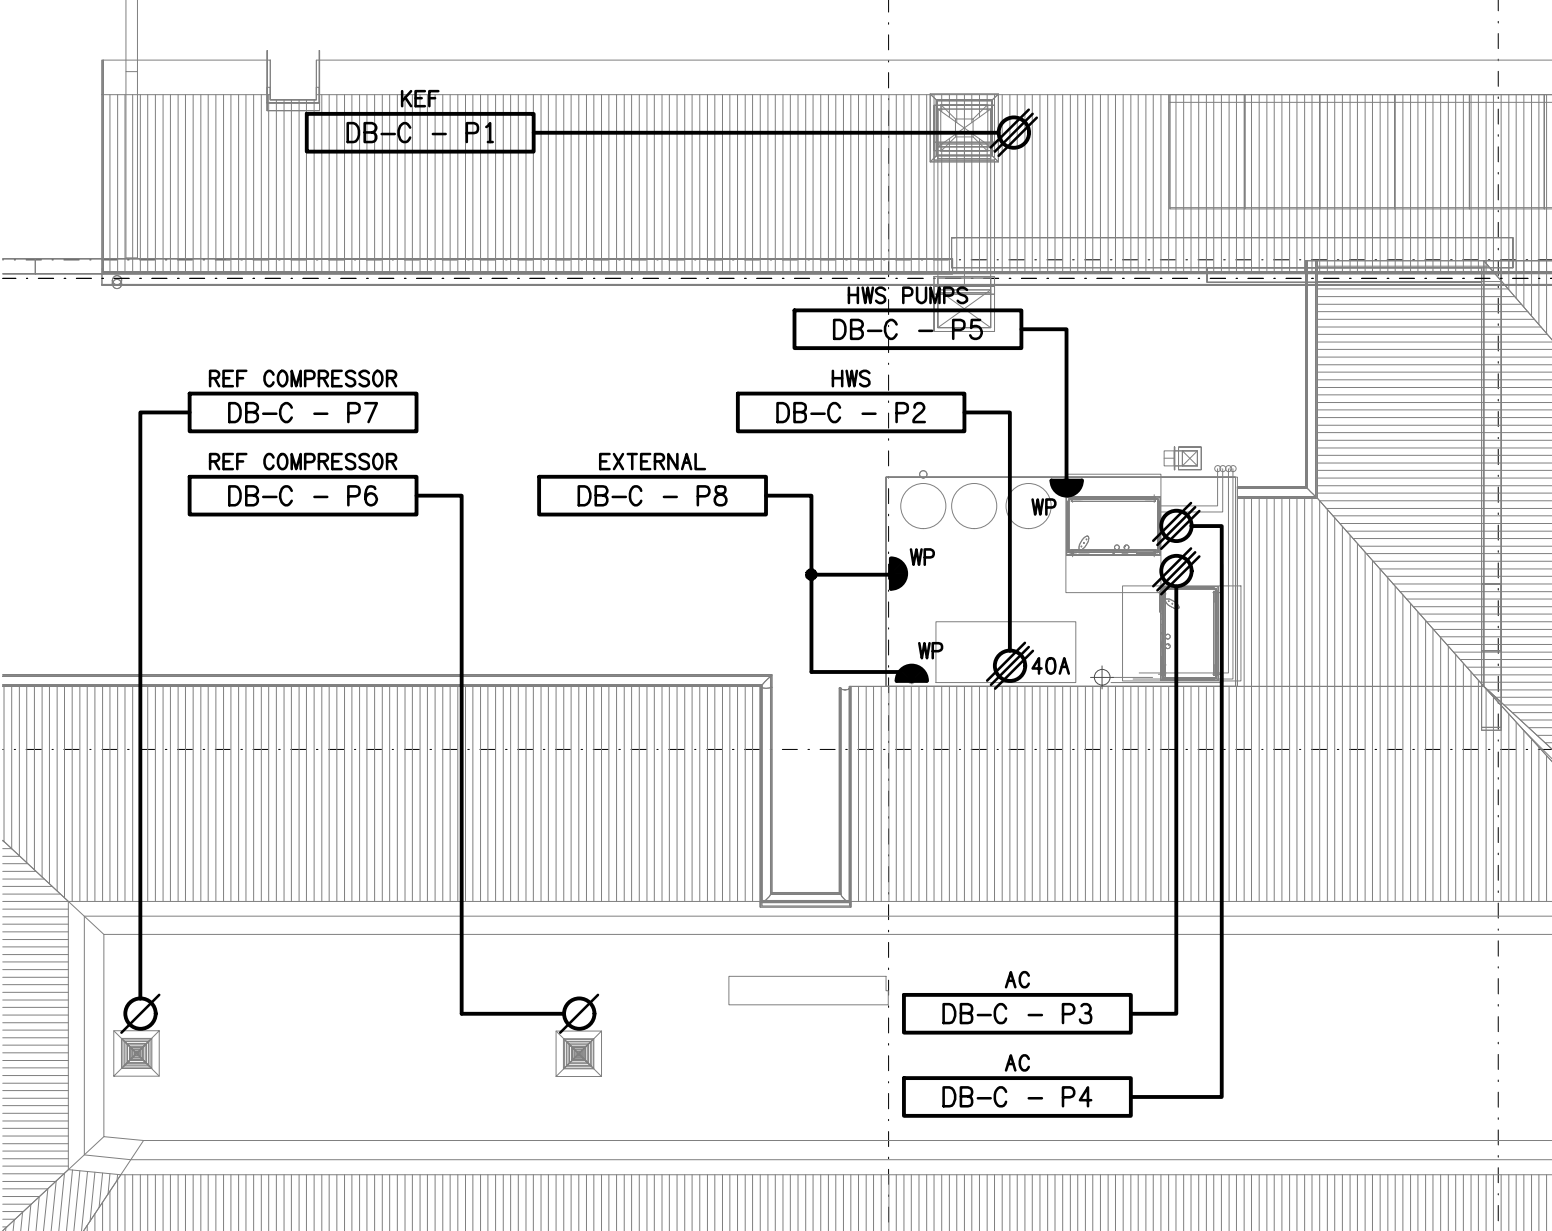

ROOF LEVEL
PART FLOOR PLAN
SCALE 1: 100

A	PRELIMINARY	16/10/2025
REV:	DESCRIPTION:	DATE:
DRAWING:		
ELECTRICAL SERVICES LEVEL 1 & MSB SCHEMATIC		
SCALE:	PROJECT NO:	DRAWING NO:
1:100 UNO AT A1	C3584a	E09
		REVISION:
		A