


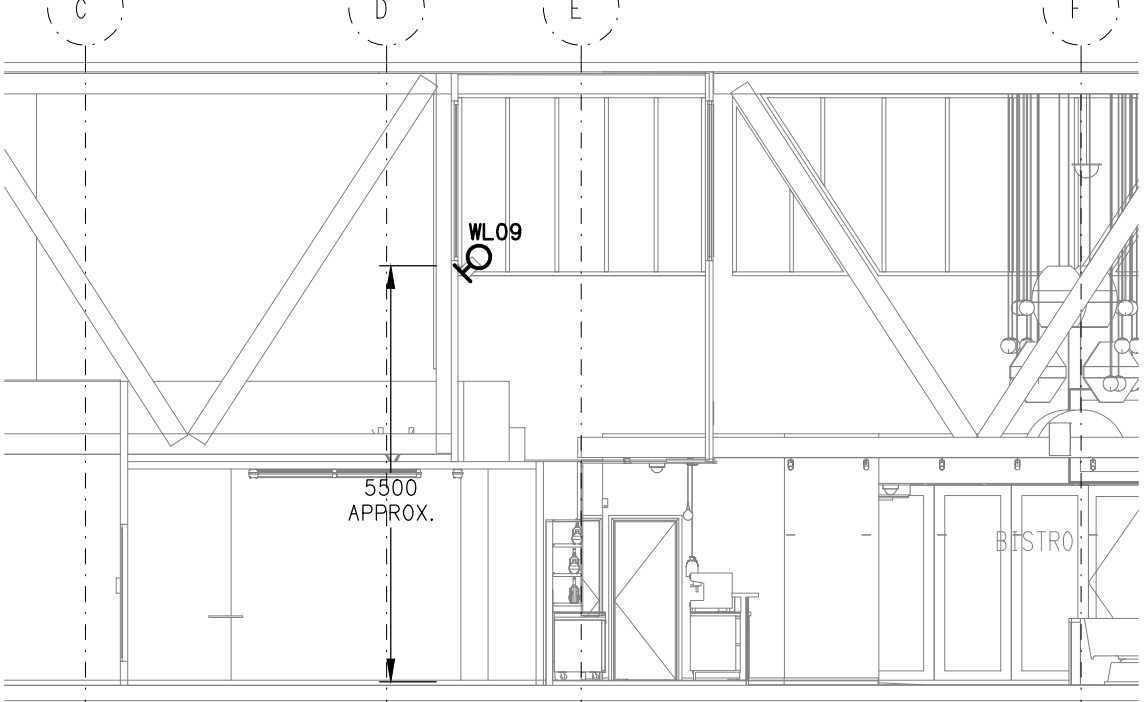

DETAIL A
WL09 MOUNTING SECTION
SCALE 1: 100

EXISTING ELECTRICAL SERVICES WITHIN THIS DASH LINED AREA ARE TO REMAIN AS IS, UNLESS NOTED OTHERWISE.

REFER TO DRAWING C3600a-E07.dwg FOR THE GAMING ROOM JOINERY & WALL LIGHTING PLAN

E	TENDER	27/11/2025
REV:	DESCRIPTION:	DATE:

ELECTRICAL DESIGN GROUP
ELECTRICAL BUILDING SERVICES CONSULTANTS

BRISBANE: P.O. Box 15 Sherwood Qld 4075
PTY LTD Phone: (07) 3278 4375
ACN 092 710 793 Email: brisbane@edg.net.au
Web: www.edg.net.au

ELECTRICAL DESIGN GROUP BRISBANE TRADING AS:
PTY LTD ELECTRICAL DESIGN GROUP
ACN 092 710 793

PROJECT:
BENOWA TAVERN

SITE ADDRESS:
**117 ASHMORE ROAD, BENOWA
GOLD COAST**

SCALE: 1:100 SHEET SIZE: A1
AT

DRAWING TITLE:
**ELECTRICAL SERVICES
JOINERY & WALL
LIGHTING PLAN**

PROJECT NO: DRAWING NO: REVISION:

C3600a E10 E