




**LEVEL 1**  
FLOOR PLAN  
SCALE 1: 100

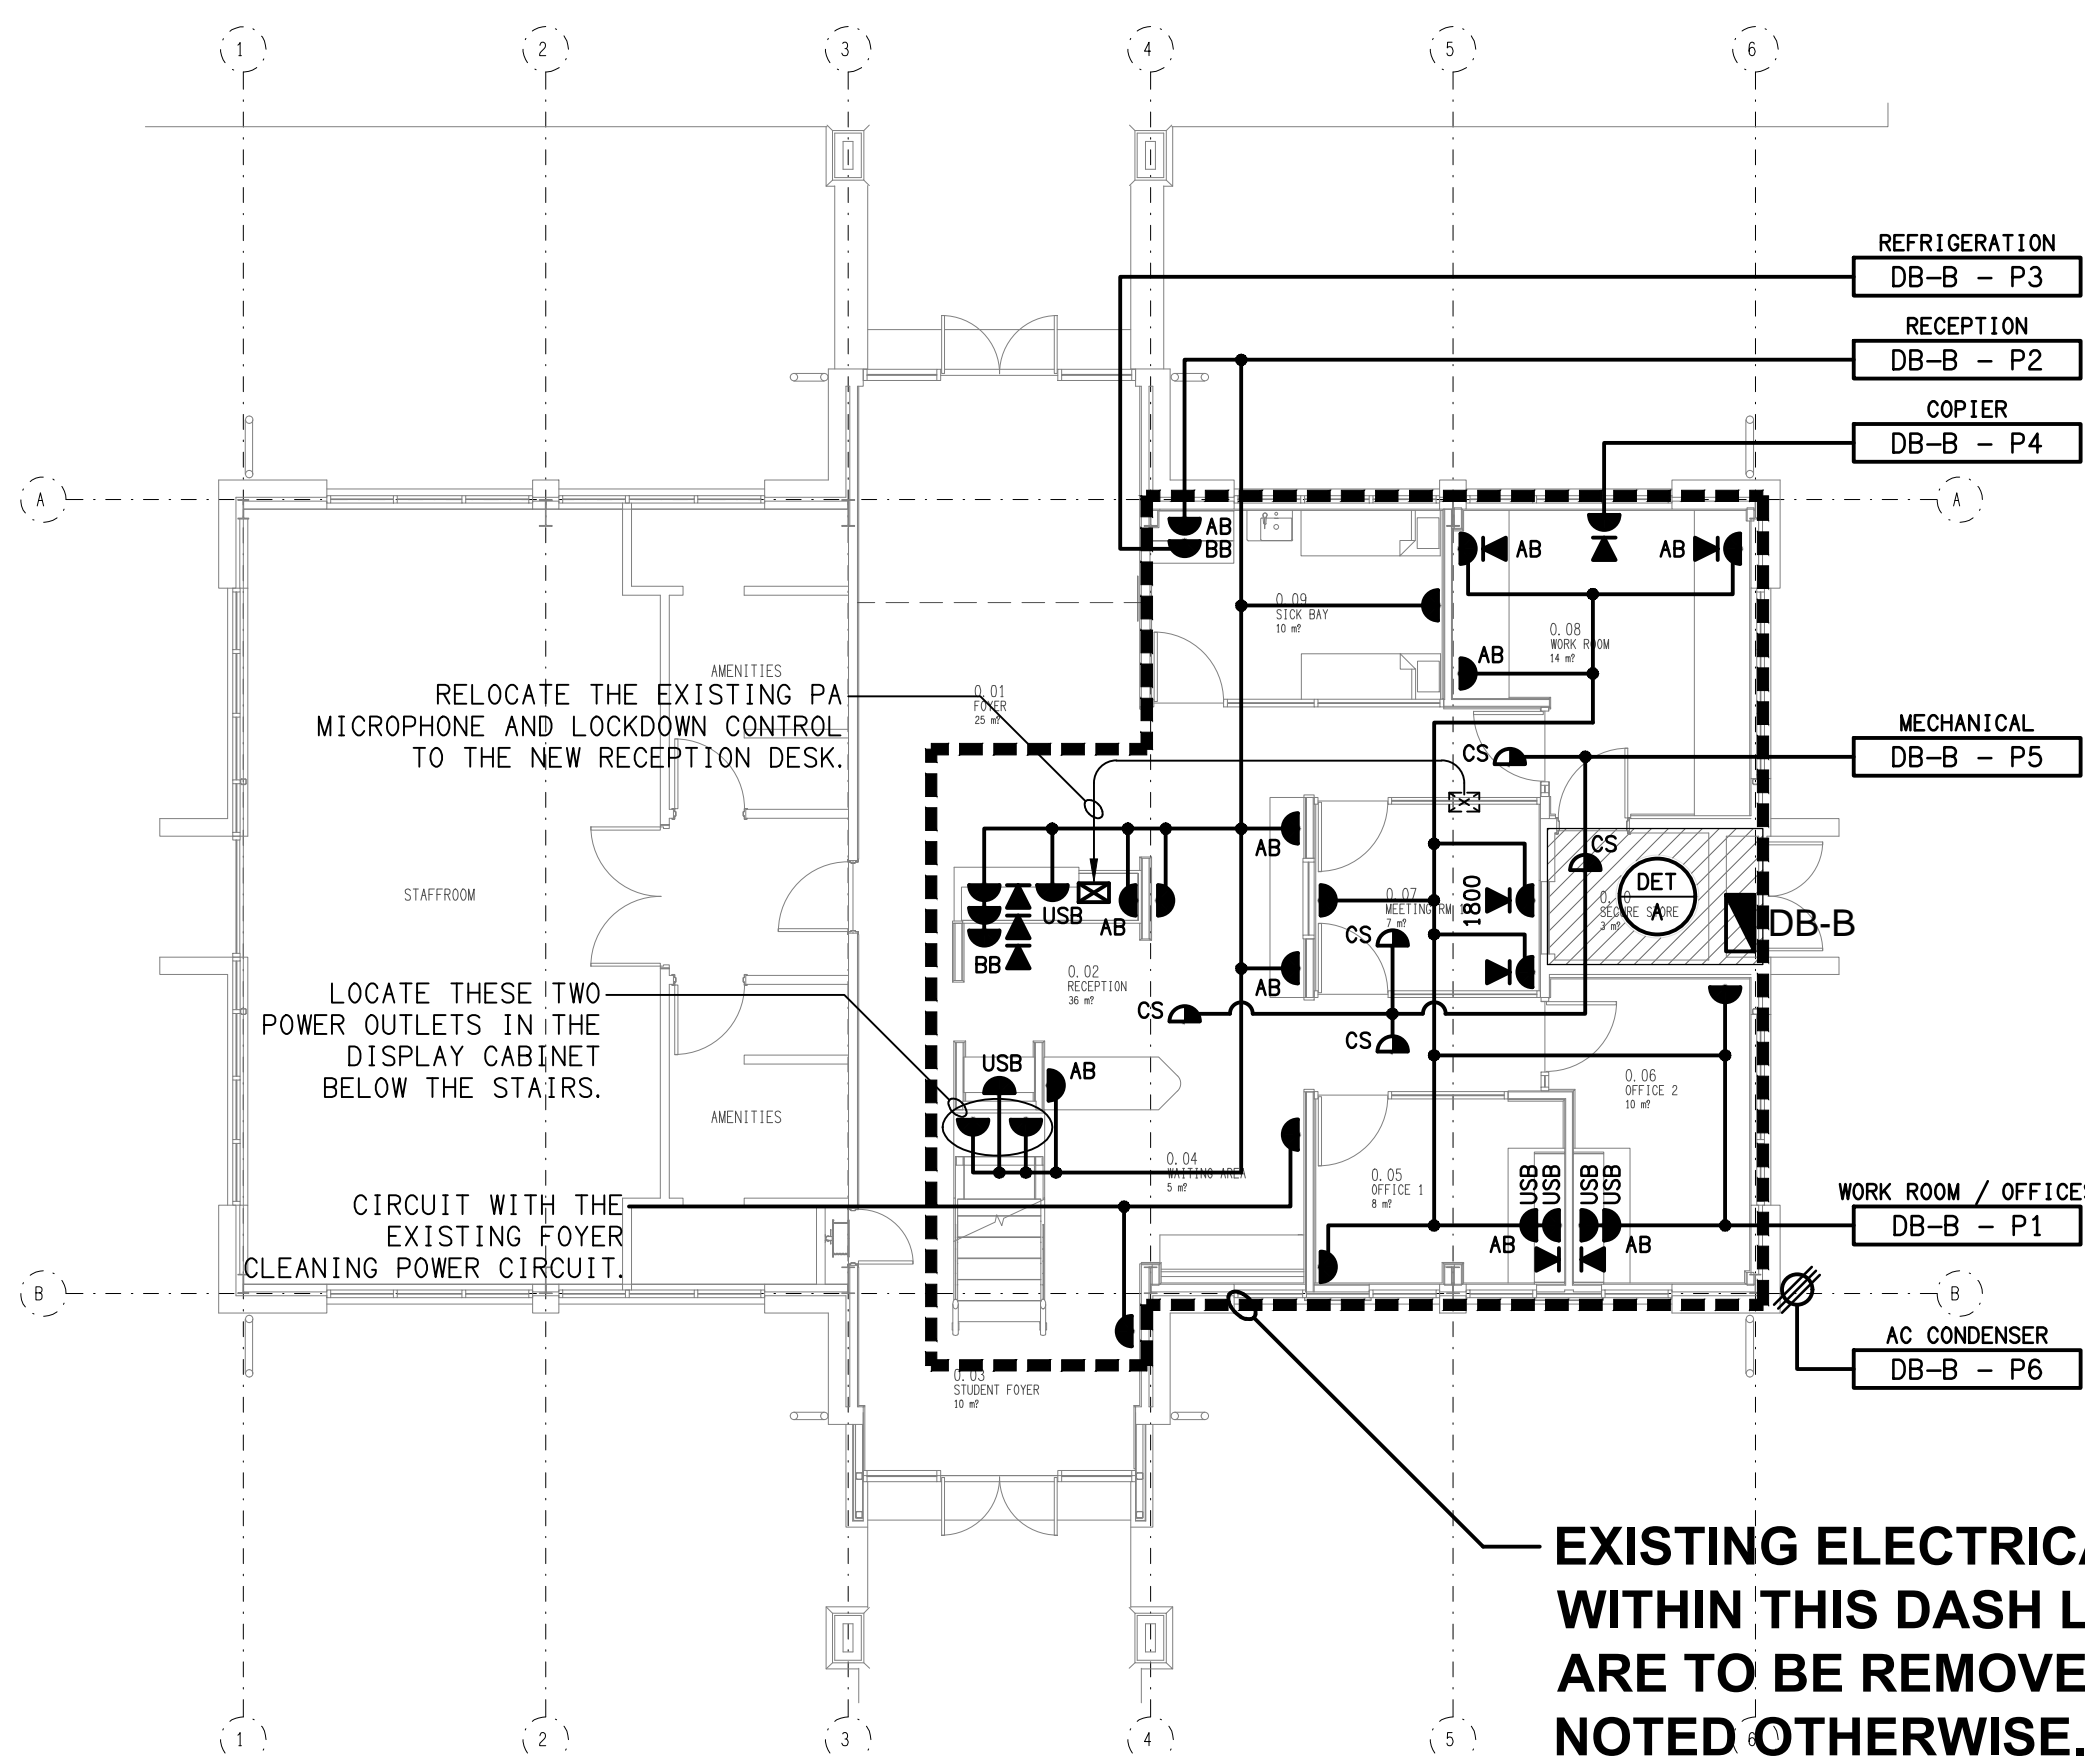


**GROUND LEVEL**  
FLOOR PLAN  
SCALE 1: 100

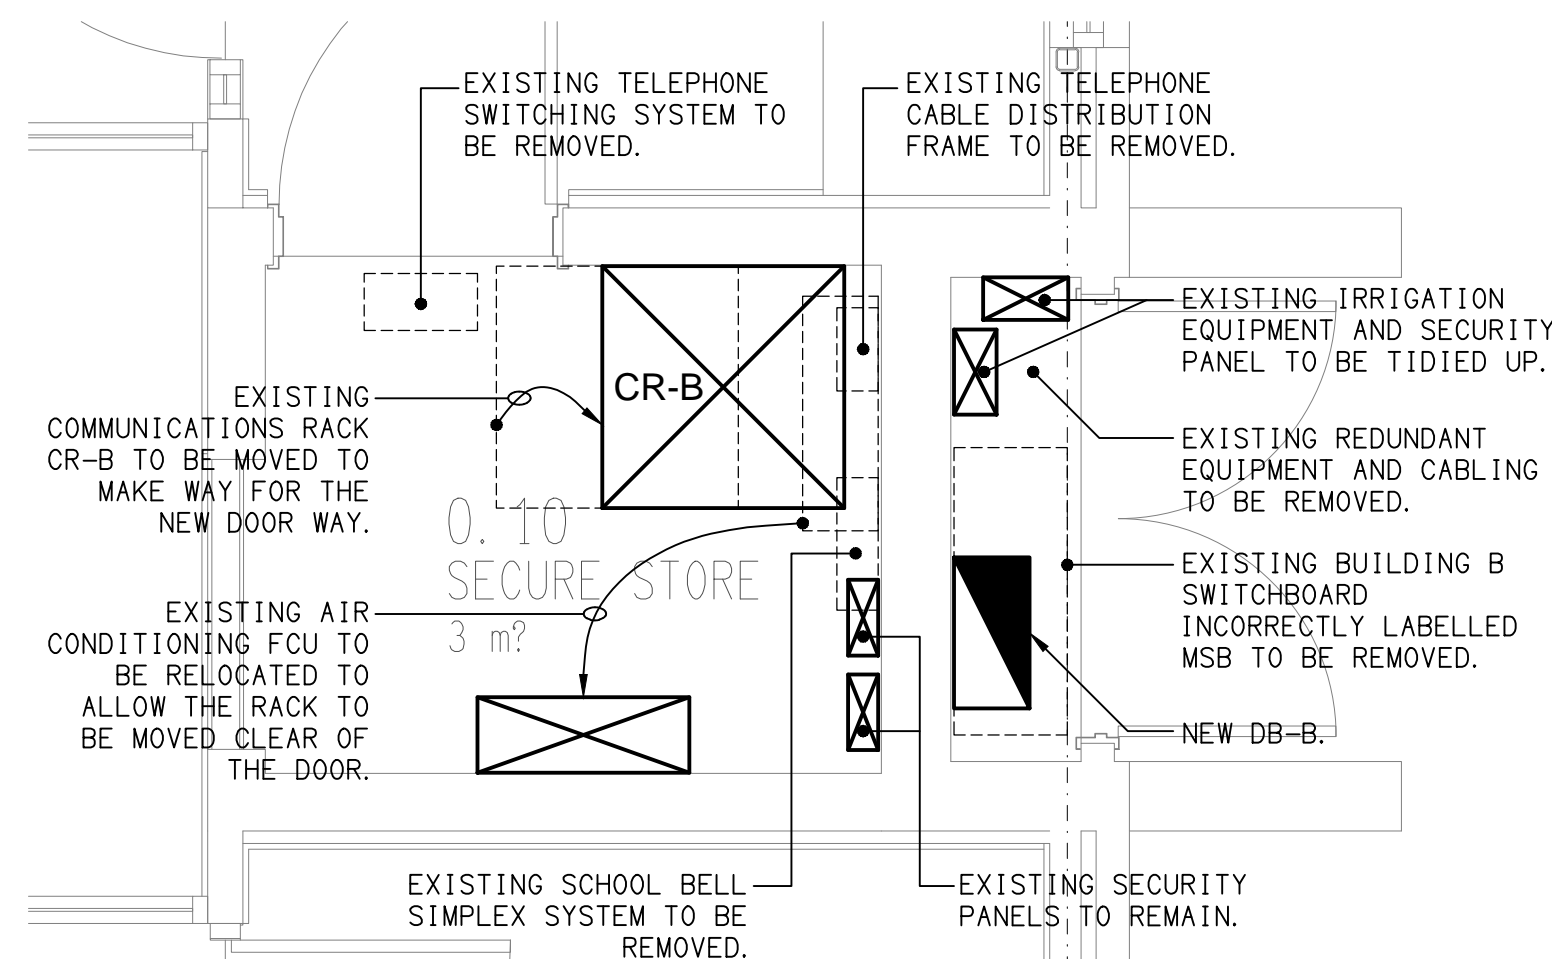

**DETAIL A**  
SECURITY STORE RECONFIGURATION  
SCALE 1: 25

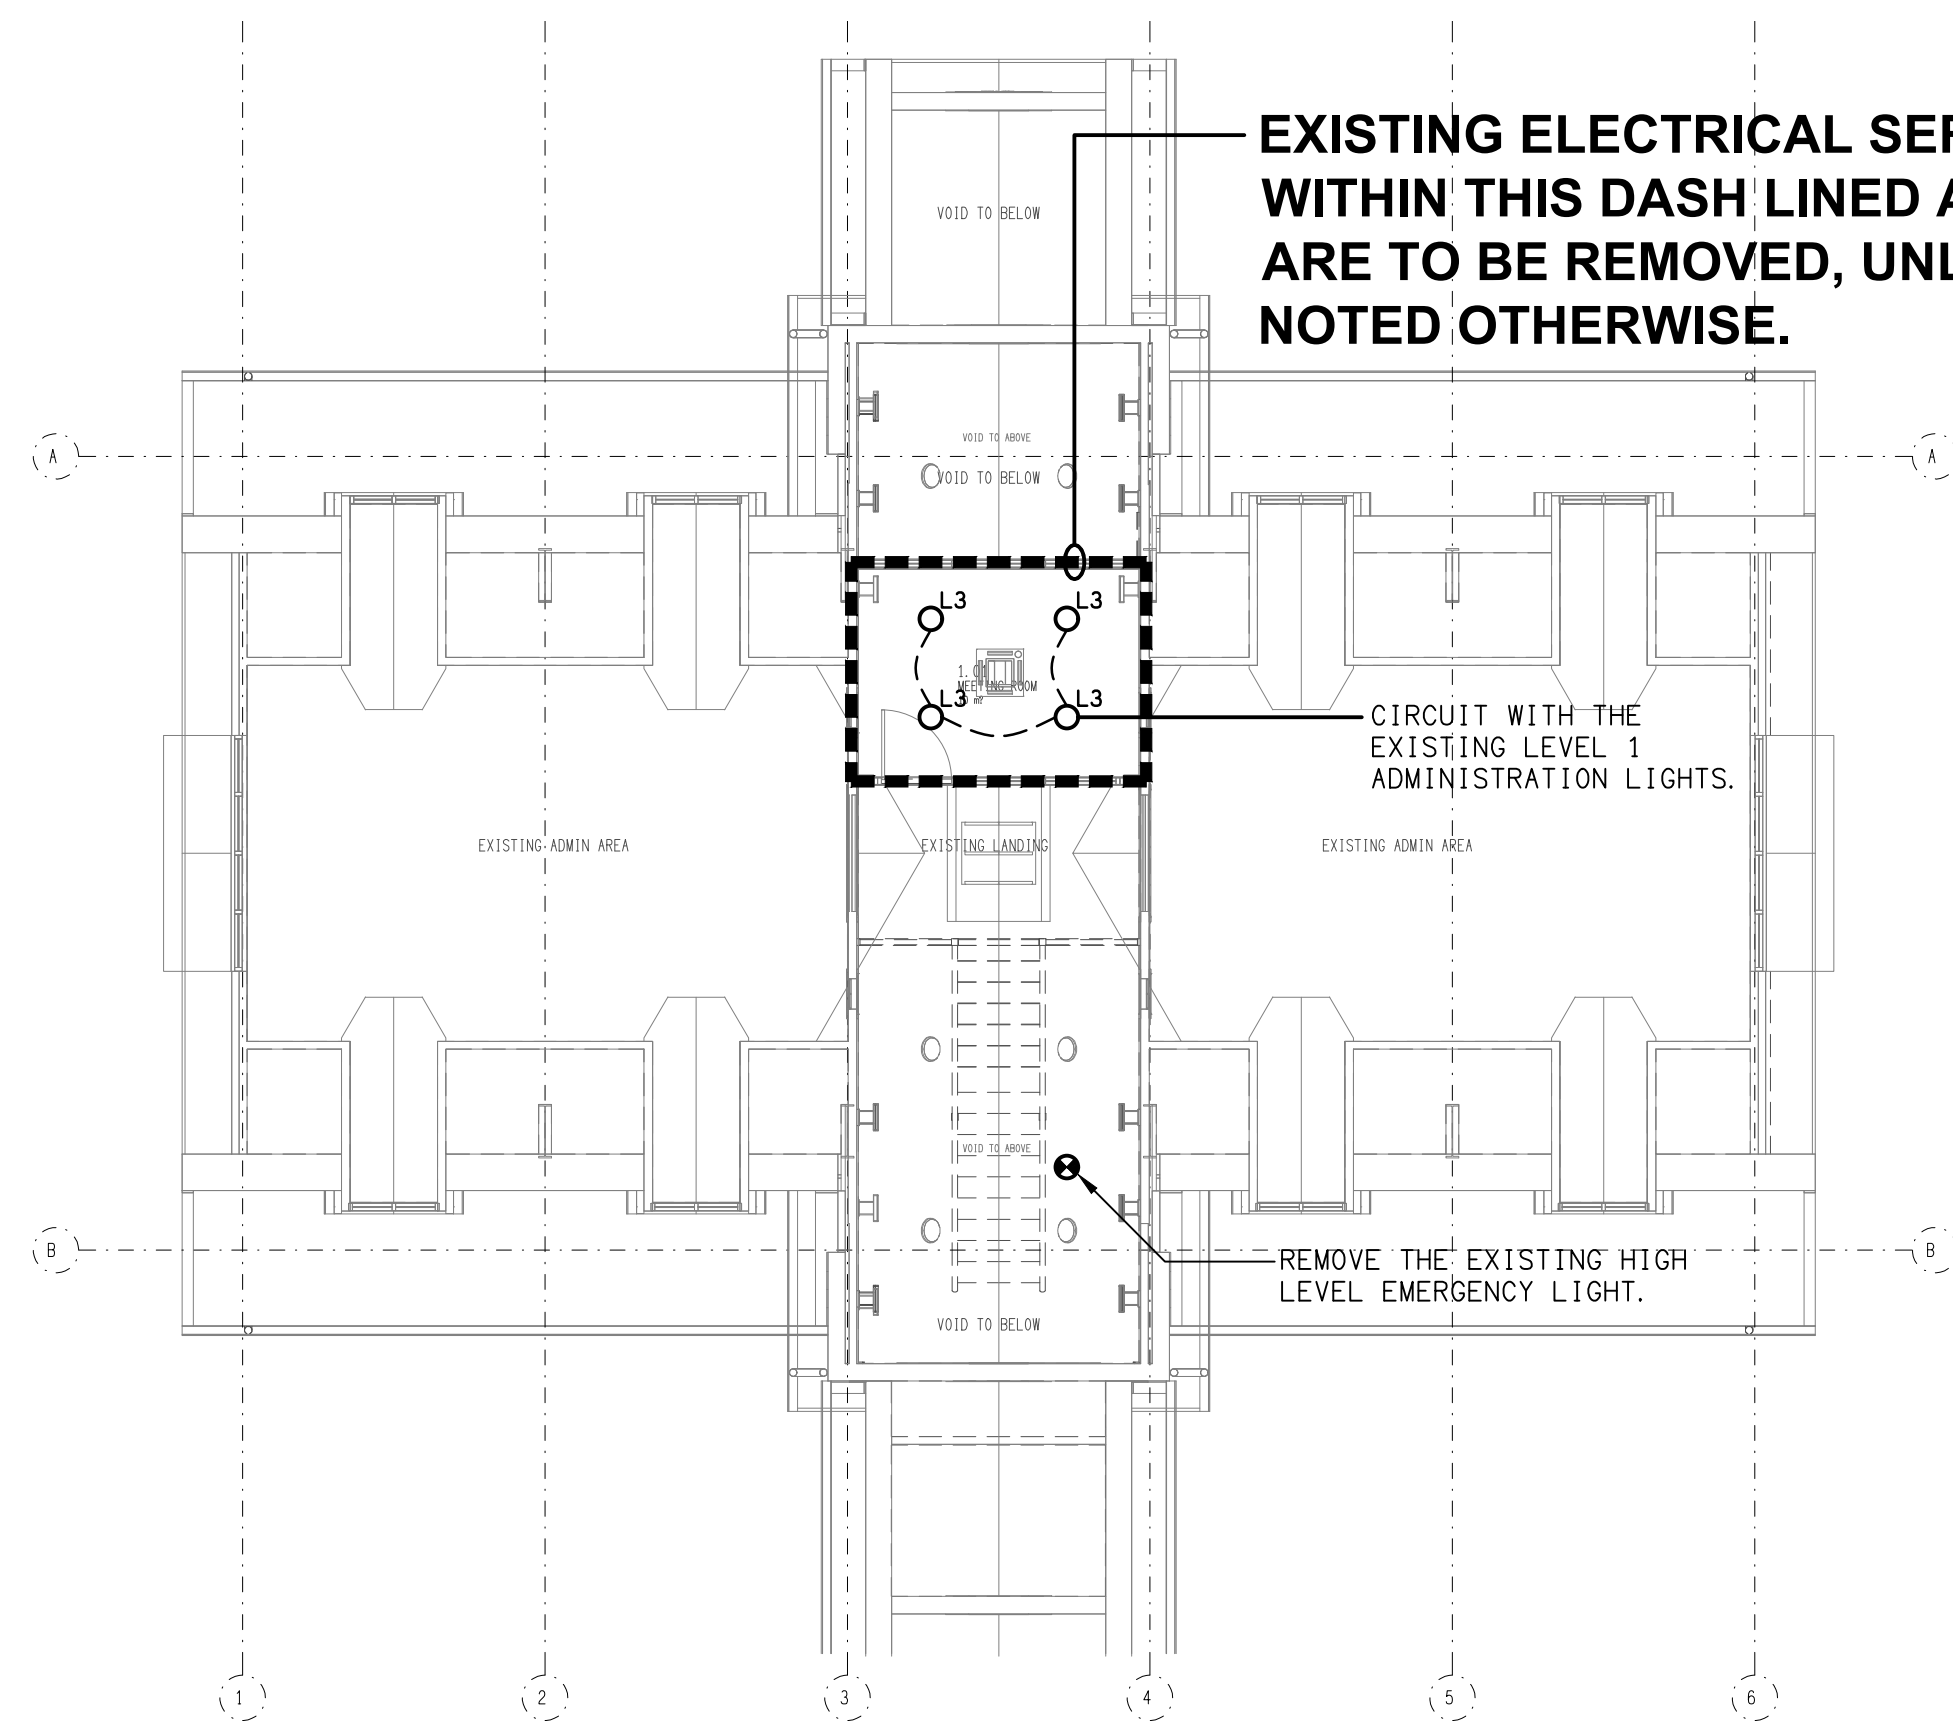

**LEVEL 1**  
REFLECTED CEILING PLAN  
SCALE 1: 100

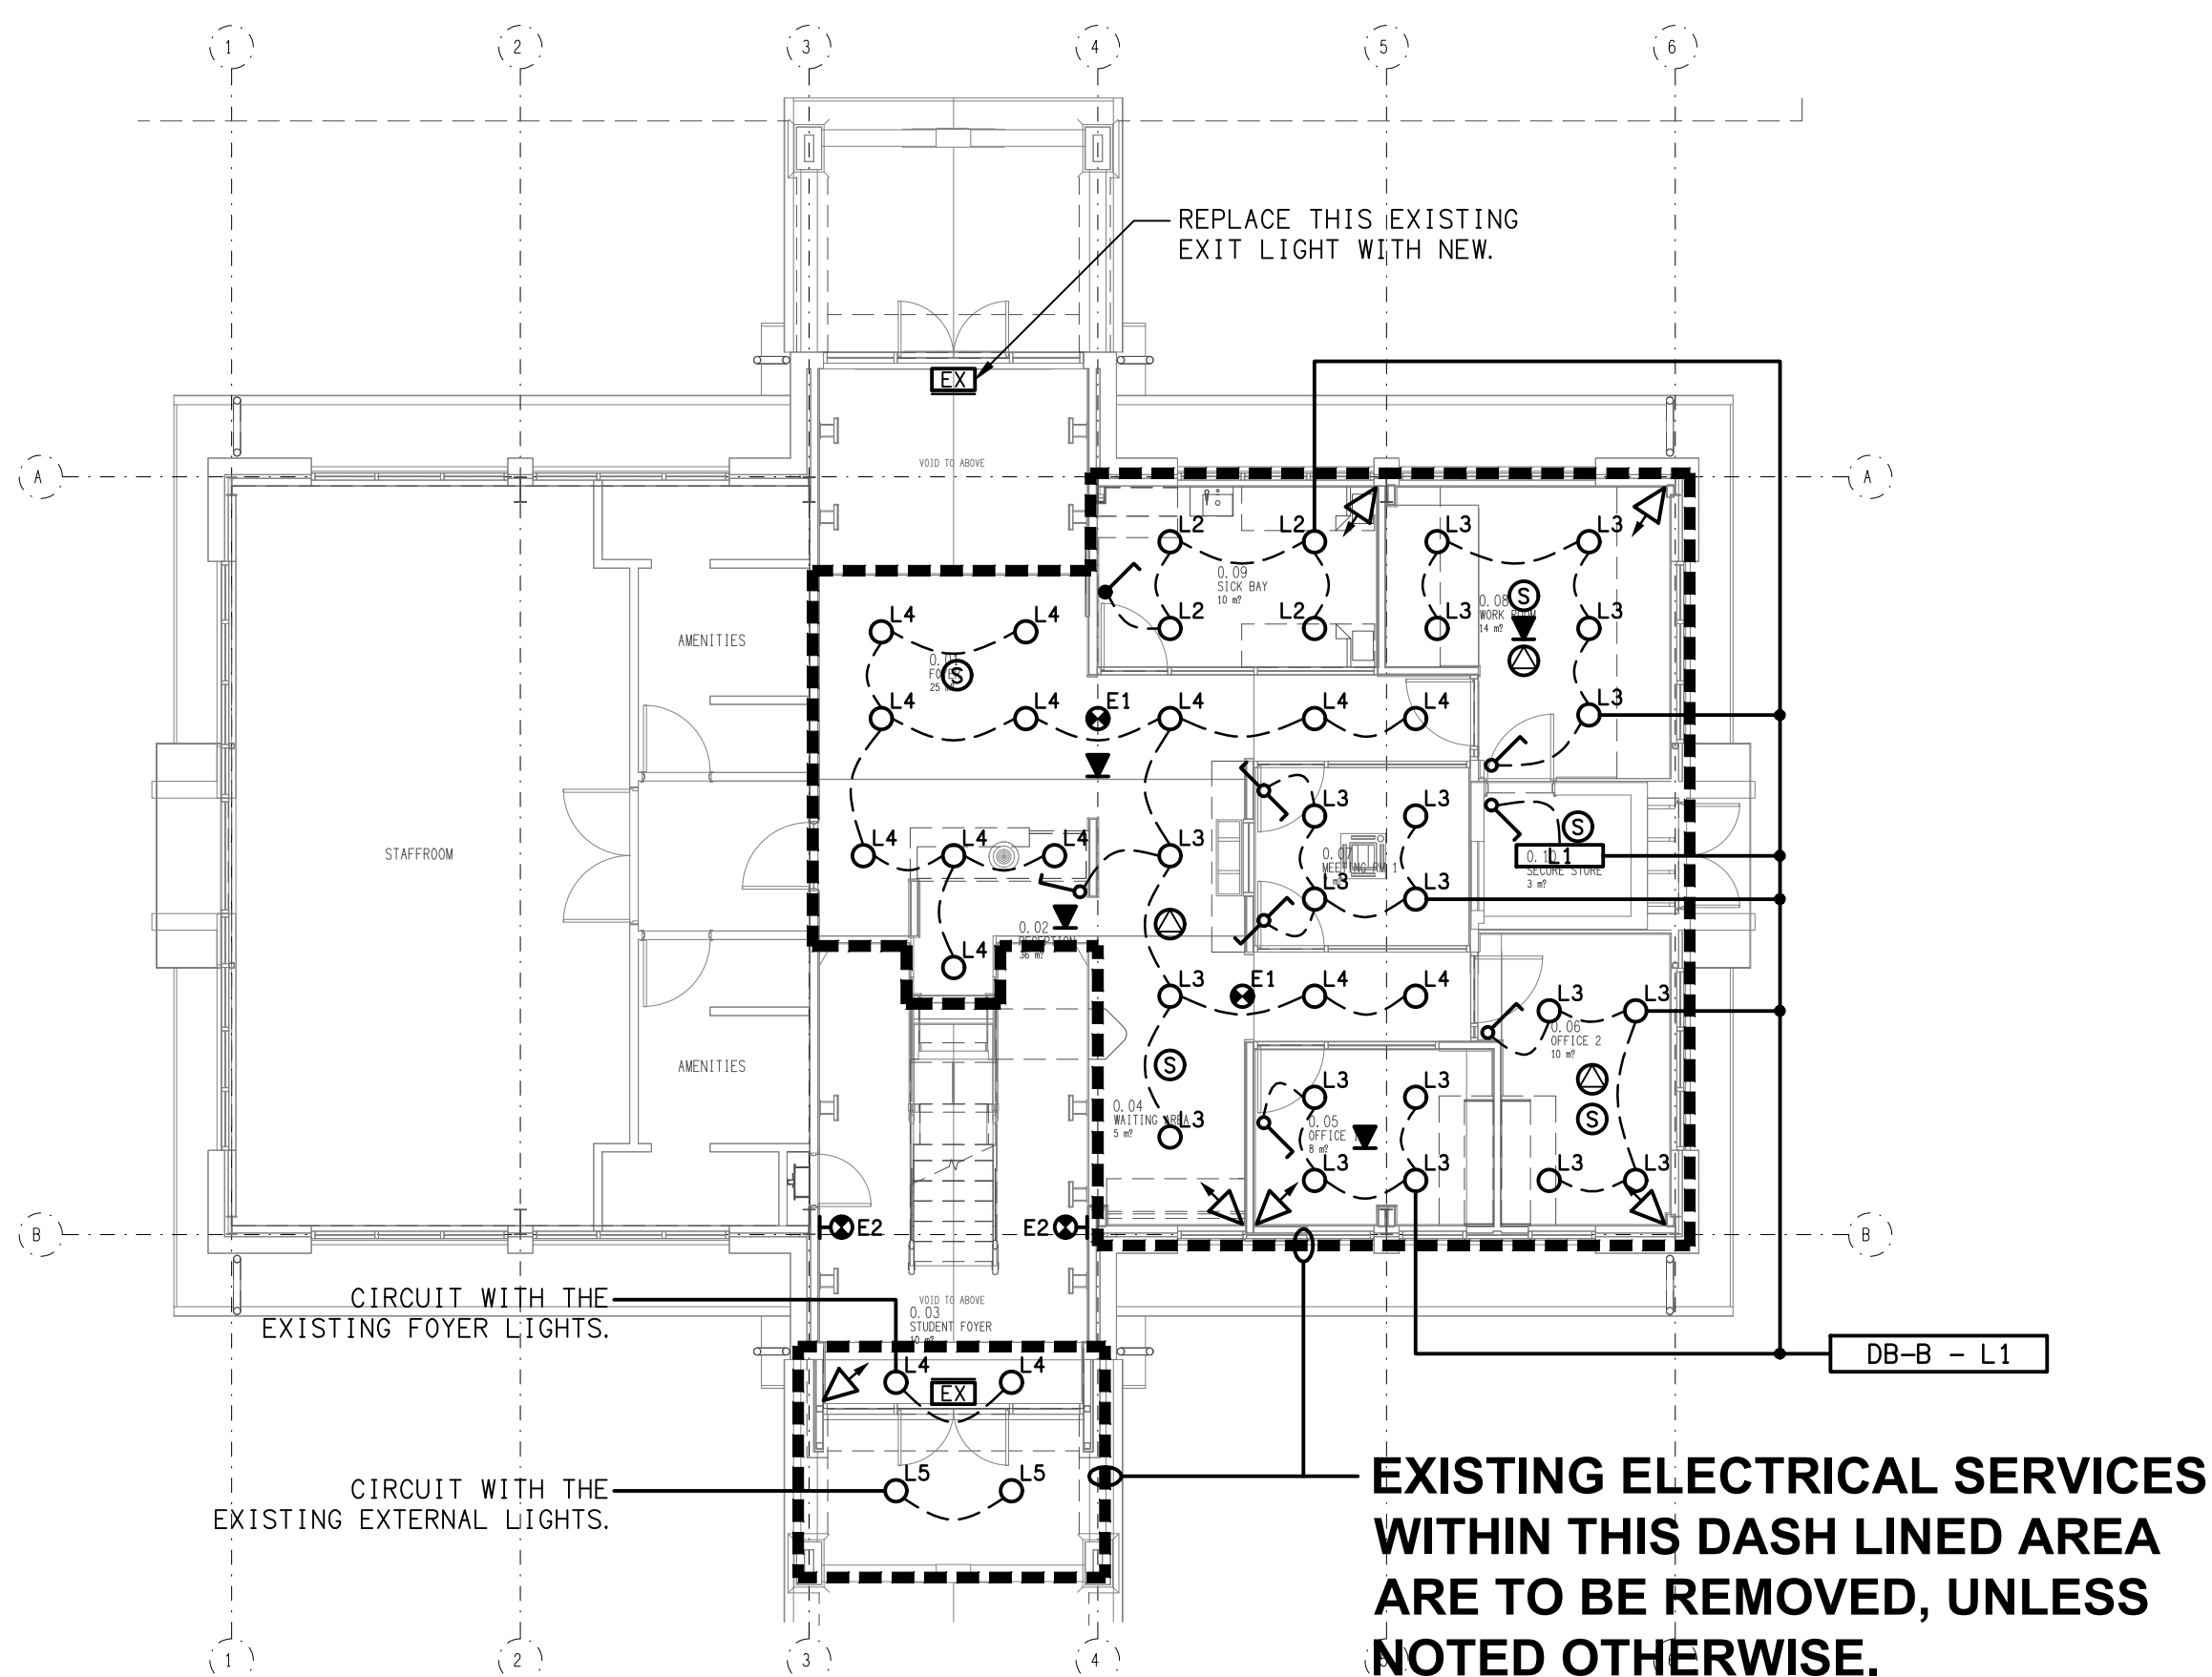

**GROUND LEVEL**  
REFLECTED CEILING PLAN  
SCALE 1: 100

ELECTRICAL DESIGN GROUP BRISBANE  
PTY LTD  
ACN 092 710 793  
TRADING AS:  
ELECTRICAL DESIGN GROUP

THE COPYRIGHT OF THIS DRAWING  
REMAINS THE PROPERTY OF THE  
ELECTRICAL DESIGN GROUP.  
USE FIGURED DIMENSIONS  
IN PREFERENCE TO SCALE.  
ALL DIMENSIONS TO BE  
VERIFIED ONSITE.

**ELECTRICAL DESIGN GROUP**  
ELECTRICAL BUILDING SERVICES CONSULTANTS  
BRISBANE GOLD COAST

P.O.Box 15, Sherwood Q.4075  
Phone: (07) 3278 4375  
Email: brisbane@edg.net.au  
Web: www.edg.net.au

PROJECT:  
**ST JOHNS ANGLICAN COLLEGE,  
FOREST LAKE - JUNIOR CAMPUS  
ADMINISTRATION UPGRADE**  
ALPINE PLACE, FOREST LAKE, QUEENSLAND

B	TENDER	09/09/2025
REV:	DESCRIPTION:	DATE:

DRAWING:  
**ELECTRICAL SERVICES  
GROUND & LEVEL 1 PLANS**

SCALE:  
1:100

AT A1

PROJECT NO:  
**C3613a**

DRAWING NO:  
**E02**

REVISION:  
**B**