


**FLOOR PLAN**  
GAMING ROOM & BAR  
SCALE 1:50

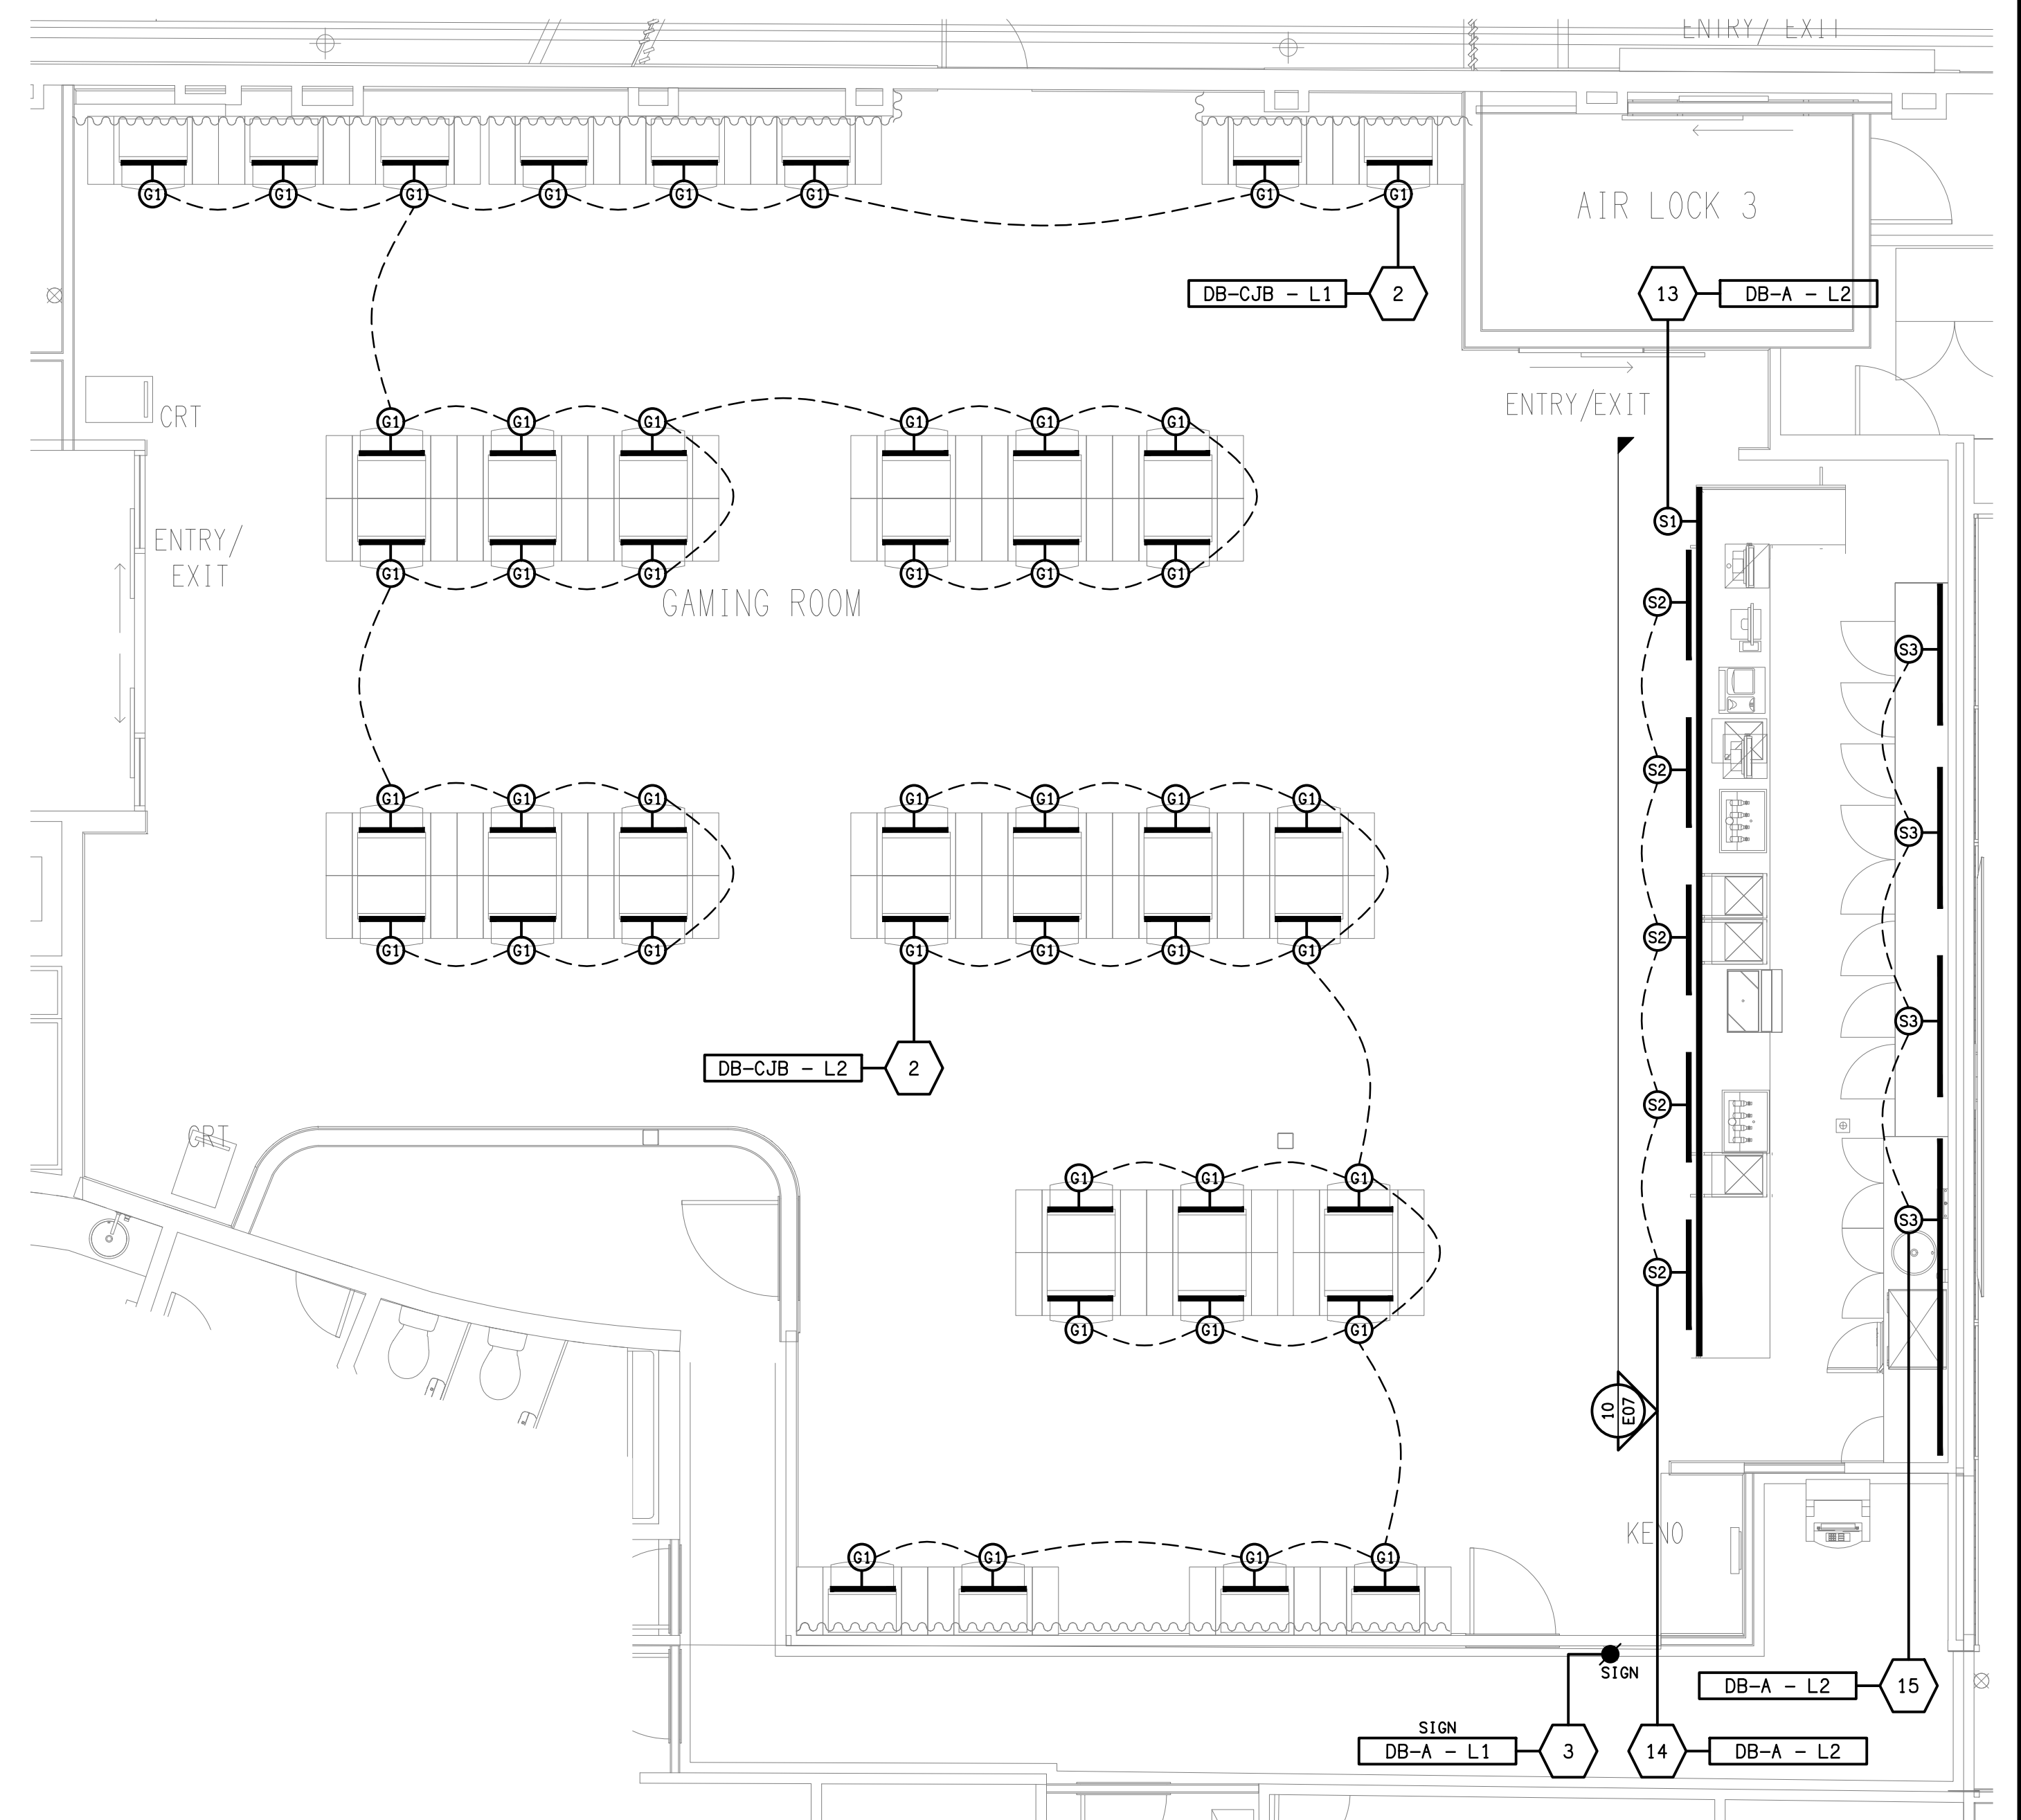

**JOINERY LIGHTING PLAN**  
GAMING ROOM & BAR  
SCALE 1:50