


SCHEMATIC
RGB CONTROL
NOT TO SCALE

REMOVE THE
EXISTING LIGHTING
WITHIN THIS AREA.

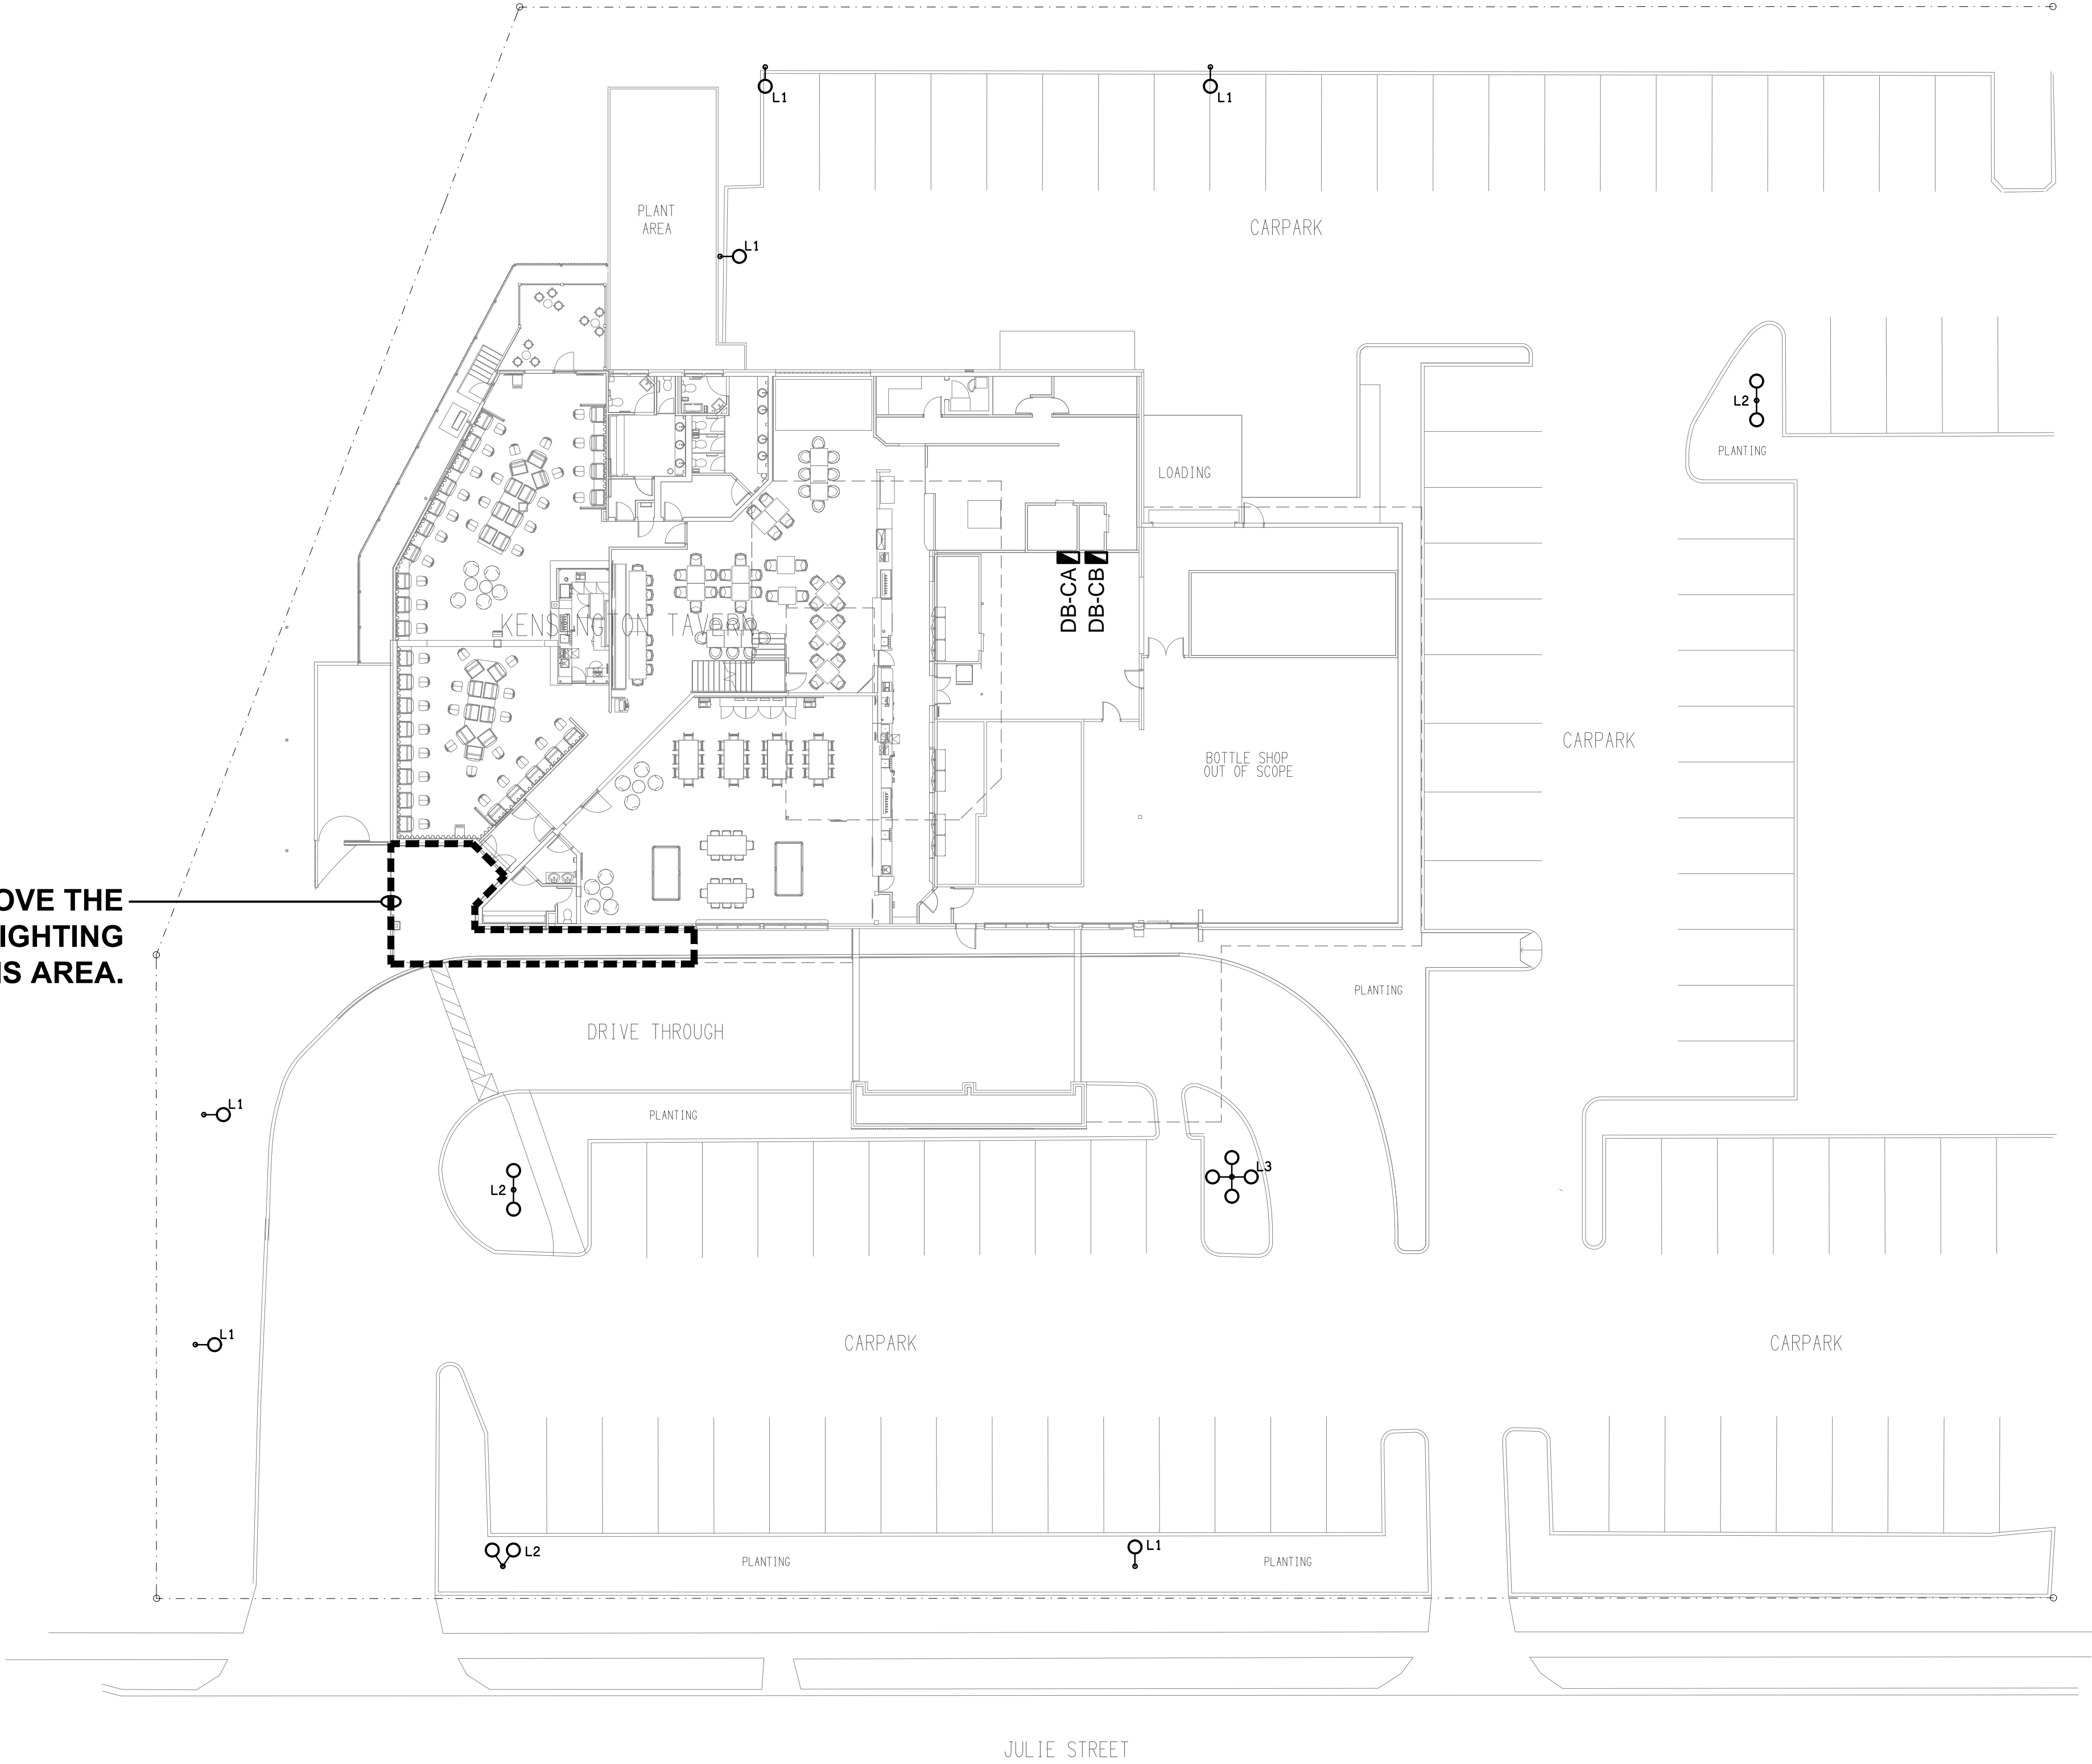

B	TENDER	03/11/2025
REV:	DESCRIPTION:	DATE:

ELECTRICAL DESIGN GROUP
ELECTRICAL BUILDING SERVICES CONSULTANTS

BRISBANE: P.O. Box 15, Sherwood Qld 4075
Phone: (07) 3278 4375
Email: brisbane@edg.net.au
Web: www.edg.net.au

ELECTRICAL DESIGN GROUP BRISBANE PTY LTD
ACN 092 710 793

TRADING AS:
ELECTRICAL DESIGN GROUP

PROJECT:

KENSINGTON TAVERN

SITE ADDRESS:

**25 JULIE STREET, CRESTMEAD
QUEENSLAND**

SCALE: SHEET SIZE:

1:200 AT **A1**

DRAWING TITLE:

**ELECTRICAL SERVICES
SITE PLAN & SCHEMATIC**

PROJECT NO: DRAWING NO: REVISION:

C3638a E03 B