



BURGER URGE

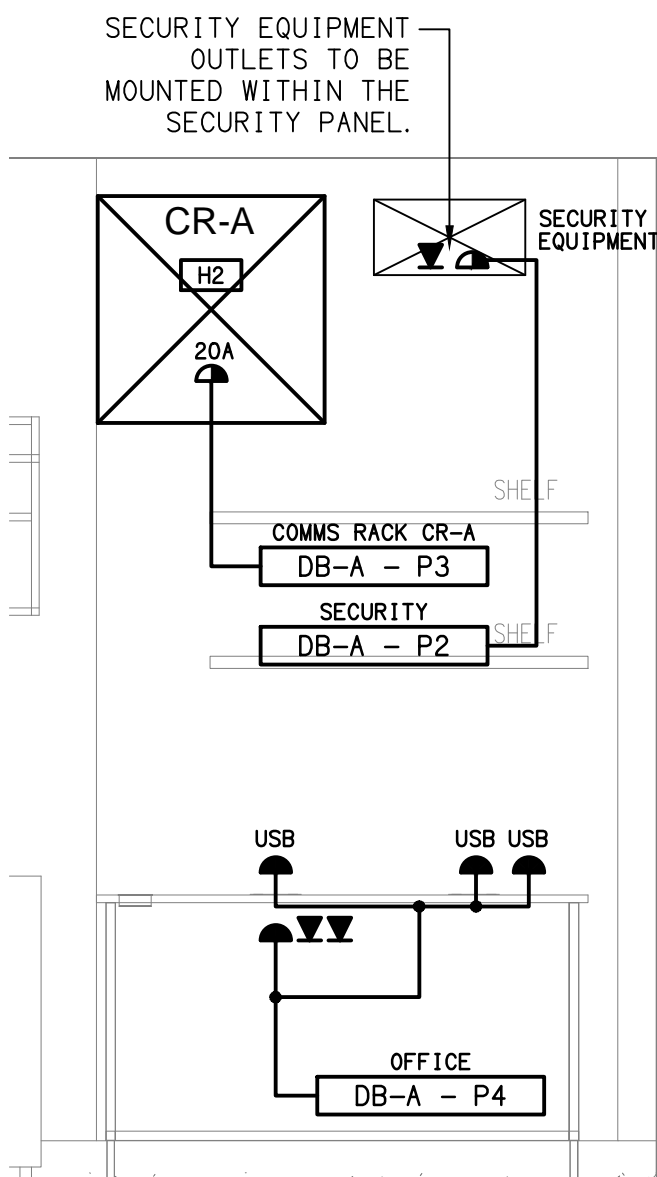

DETAIL A
MANAGERS ELEVATION
SCALE 1:20

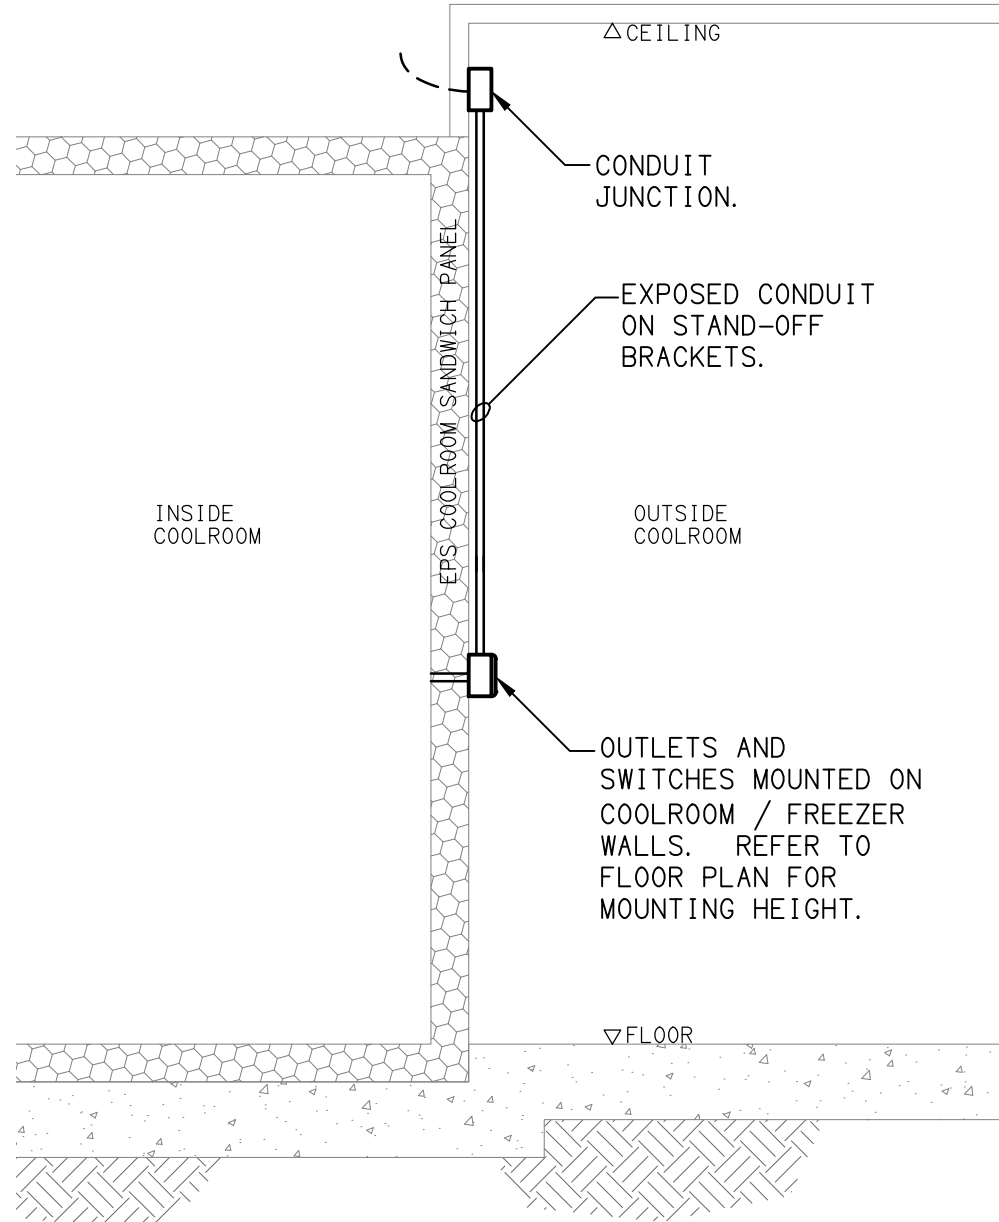

DETAIL B
COOLROOM / FREEZER OUTLETS
NOT TO SCALE

NOTE:
CORRUGATED CONDUIT ARE NOT TO BE USED IN THE AREAS SHOWN ON THIS PLAN.

SHARE SITE AMENITIES

DISHWASHER DB-A - P13

ICE MACHINE DB-A - P14

HOT WATER DB-A - P15

FREEZER ISOLATORS CS

COOLROOM ISOLATORS CS

WARMING DRAW DB-A - P19

REFRIGERATOR DB-A - P21

PHIP DUMP DB-A - P20

WASH-UP DB-A - P22

FRYERS SCREEN DB-A - P23

COOKLINE DB-A - P24

SCREEN DB-A - P25

HEAT LAMP DB-A - P26

TV DB-A - P27

REFRIGERATOR DB-A - P28

GP0 DB-A - P29

REFRIGERATOR DB-A - P30

GLASS WASHER DB-A - P31

BEER CHILLER DB-A - P32

POS / GAS DB-A - P33

BEER CHILLER DB-A - P34

POS / GAS DB-A - P35

BEER CHILLER DB-A - P36

POS / GAS DB-A - P37

BEER CHILLER DB-A - P38

POS / GAS DB-A - P39

BEER CHILLER DB-A - P40

POS / GAS DB-A - P41

BEER CHILLER DB-A - P42

POS / GAS DB-A - P43

BEER CHILLER DB-A - P44

POS / GAS DB-A - P45

BEER CHILLER DB-A - P46

POS / GAS DB-A - P47

BEER CHILLER DB-A - P48

POS / GAS DB-A - P49

BEER CHILLER DB-A - P50

POS / GAS DB-A - P51

BEER CHILLER DB-A - P52

POS / GAS DB-A - P53

BEER CHILLER DB-A - P54

POS / GAS DB-A - P55

BEER CHILLER DB-A - P56

POS / GAS DB-A - P57

BEER CHILLER DB-A - P58

POS / GAS DB-A - P59

BEER CHILLER DB-A - P60

ADJACENT TENANCY

ADJACENT TENANCY

11

12

OUTDOOR DINING 1

OUTDOOR DINING 2

GARDEN BED(E)

GARDEN BED(E)

A	TENDER	19/12/2025
REV:	DESCRIPTION:	DATE:

ELECTRICAL DESIGN GROUP
ELECTRICAL BUILDING SERVICES CONSULTANTS

BRISBANE: P.O. Box 15 Sherwood Qld 4075
Phone: (07) 3278 4375
Email: brisbane@edg.net.au
Web: www.edg.net.au

ELECTRICAL DESIGN GROUP BRISBANE PTY LTD
ACN 092 710 793

TRADING AS:
ELECTRICAL DESIGN GROUP

PROJECT:

**BURGER URGE
RIPLEY**

SITE ADDRESS:

7004 BARRAMS ROAD, SOUTH RIPLEY
QUEENSLAND

SCALE: SHEET SIZE:

1:50 UNO AT A1

DRAWING TITLE:

**ELECTRICAL SERVICES
FLOOR PLAN & DETAILS**

PROJECT NO: DRAWING NO: REVISION:

C3693a E03 A