



**BURGER URGE**

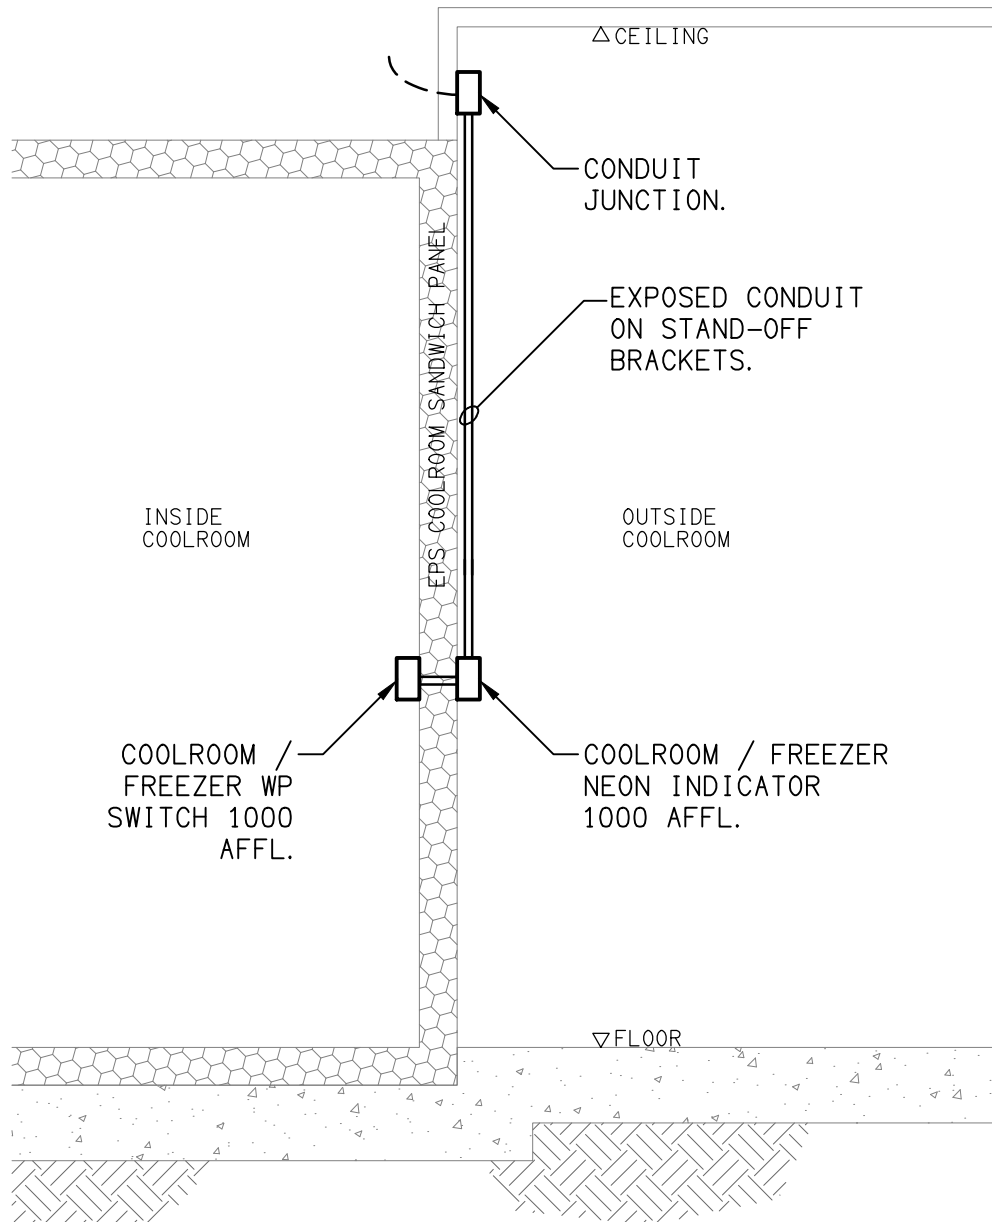

**DETAIL A**  
COOLROOM / FREEZER LIGHTING CONTROL  
NOT TO SCALE

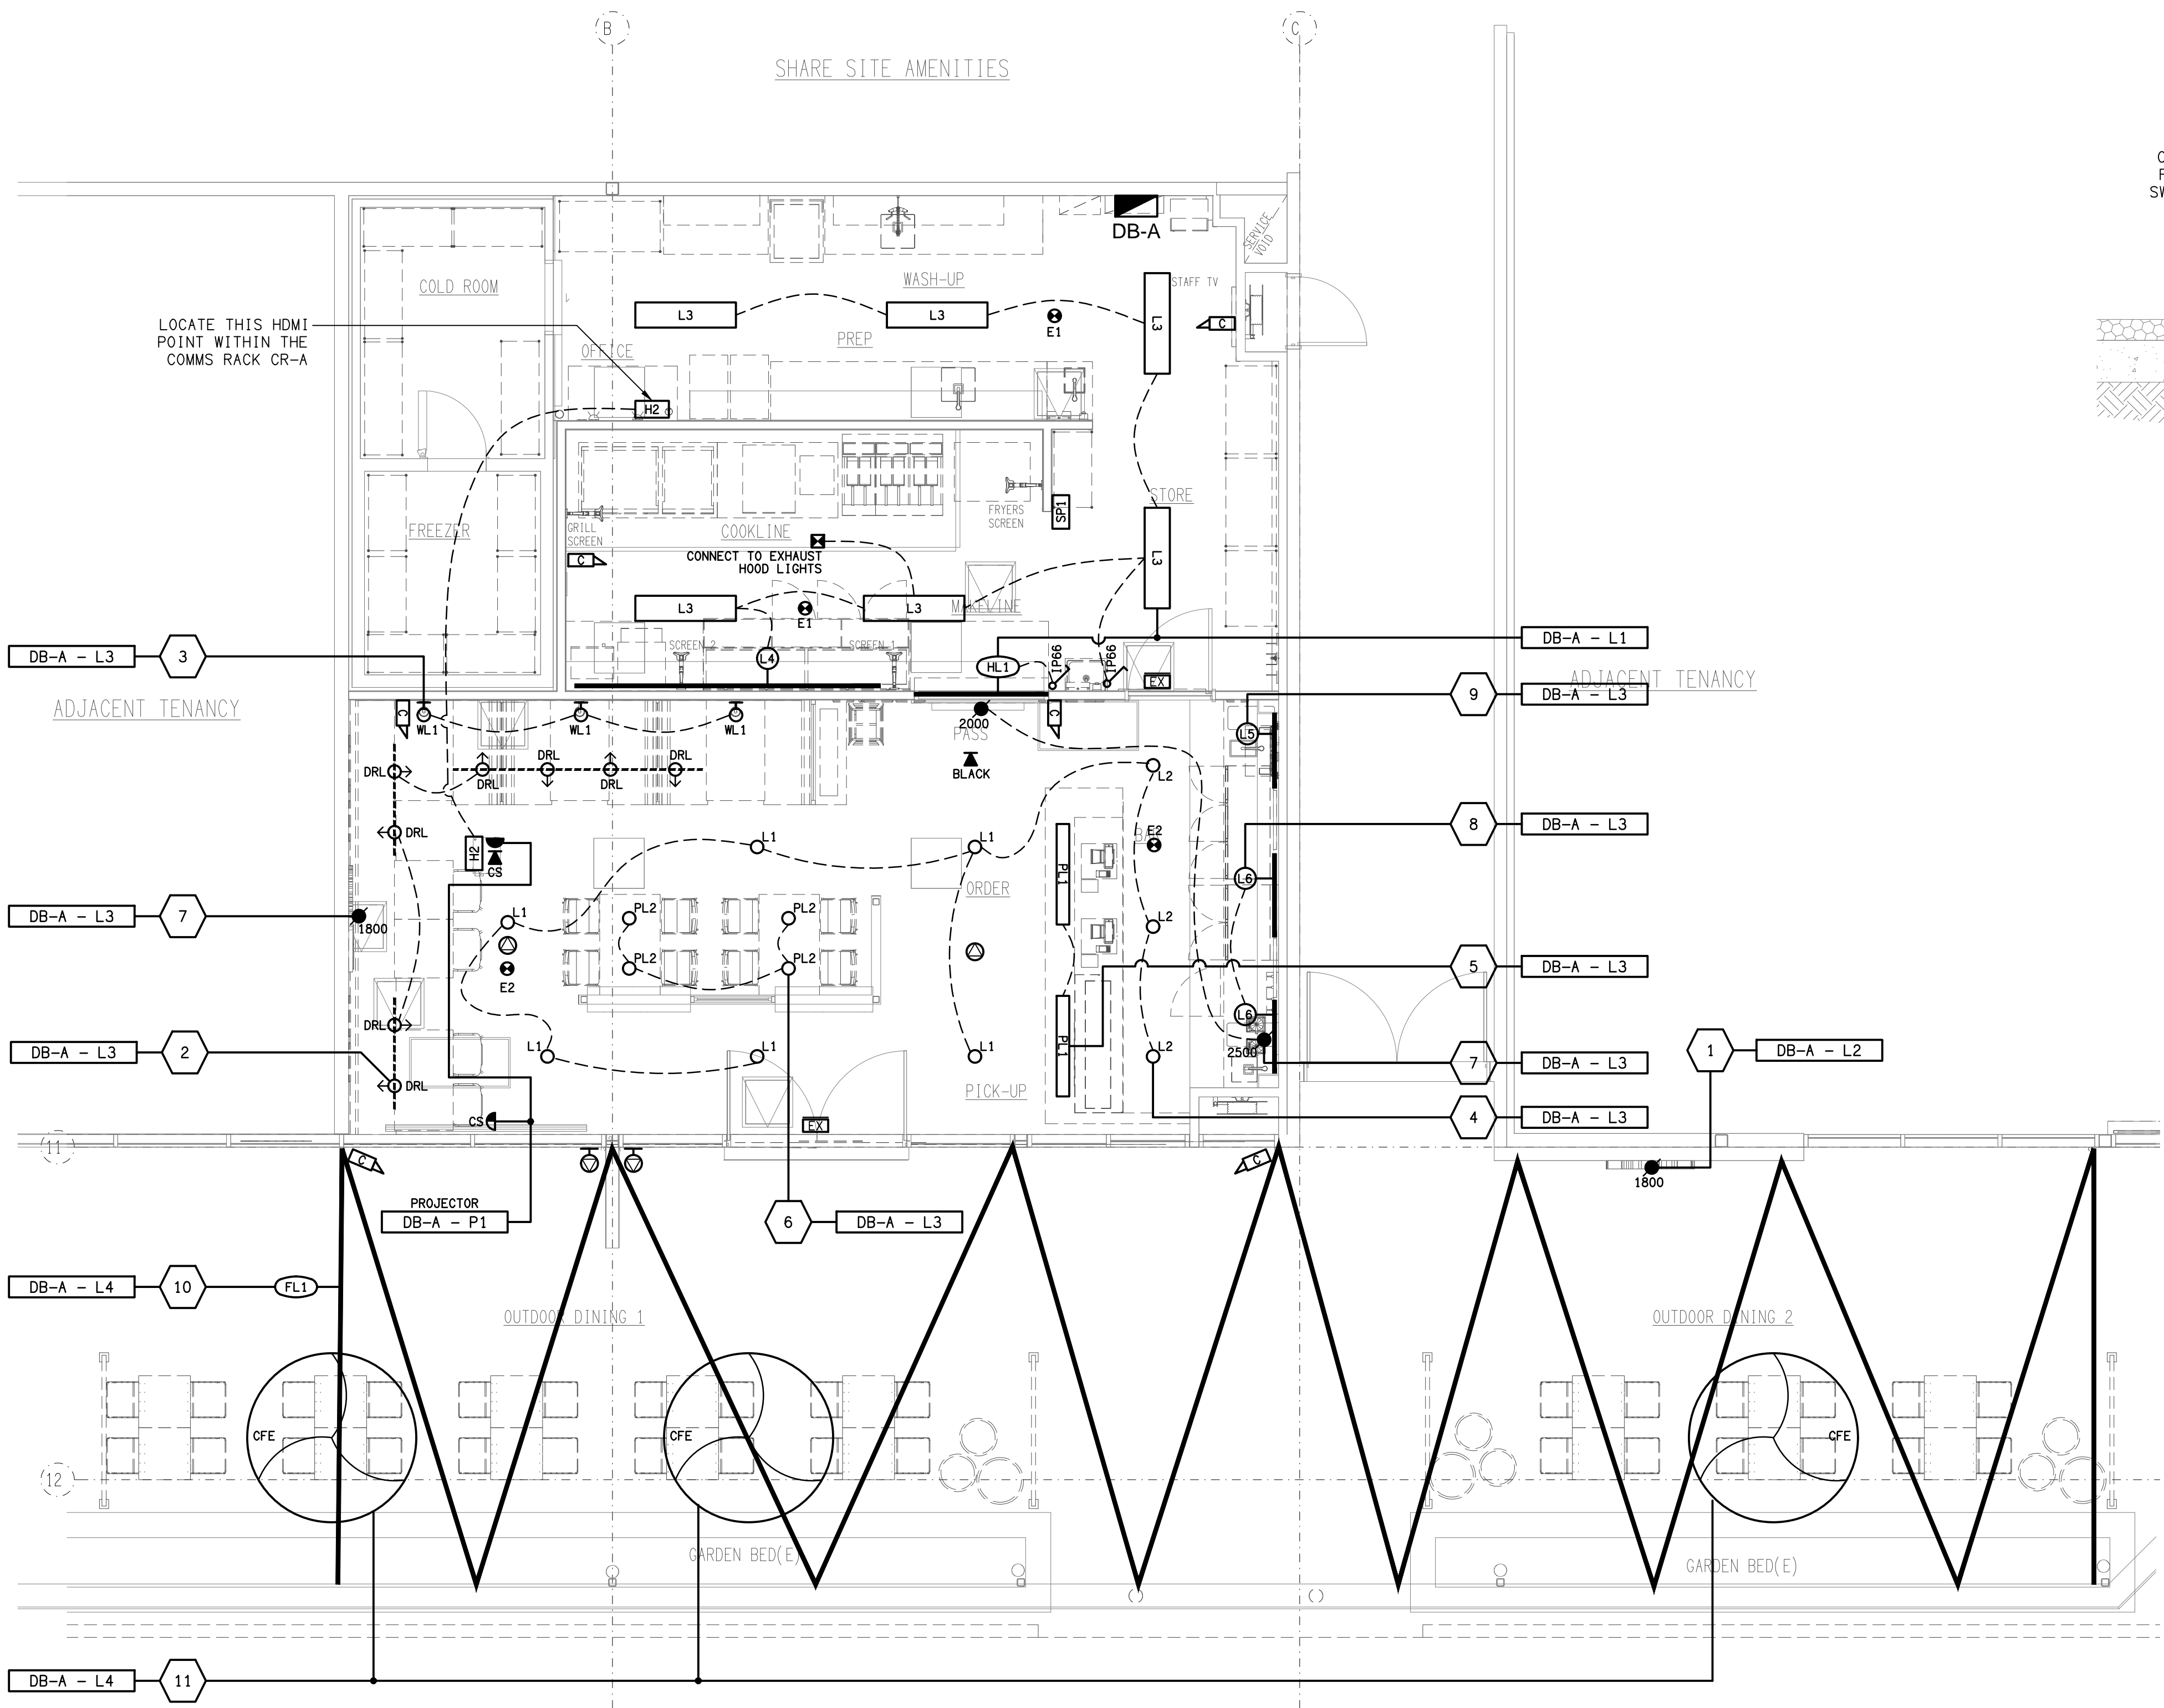

**REFLECTED CEILING PLAN**  
BURGER URGE TENANCY  
SCALE 1:50

A	TENDER	19/12/2025
REV:	DESCRIPTION:	DATE:

**ELECTRICAL DESIGN GROUP**  
ELECTRICAL BUILDING SERVICES CONSULTANTS

BRISBANE: P.O. Box 15 Sherwood Qld 4075  
Phone: (07) 3278 4375  
Email: brisbane@edg.net.au  
Web: www.edg.net.au

ELECTRICAL DESIGN GROUP BRISBANE PTY LTD  
ACN 092 710 793

TRADING AS:  
ELECTRICAL DESIGN  
GROUP

PROJECT:

**BURGER URGE  
RIPLEY**

SITE ADDRESS:

7004 BARRAMS ROAD, SOUTH RIPLEY  
QUEENSLAND

SCALE: SHEET SIZE:

1:50 AT A1

DRAWING TITLE:

**ELECTRICAL SERVICES  
REFLECTED CEILING PLAN**

PROJECT NO: DRAWING NO: REVISION:

**C3693a E04 A**