

BURGER URGE


NOTE

ALL ELECTRICAL PENETRATIONS THROUGH THE ROOF SHEETING ARE TO BE IN LINE WITH THE STRUCTURAL OR MECHANICAL SERVICES PENETRATIONS TO AVOID DEDICATED FLASHINGS FOR THE ELECTRICAL SERVICES.

NOTE:


ALL MECHANICAL SERVICES ROOF OUTLET LOCATIONS ARE TO BE CONFIRMED ON SITE WITH THE MECHANICAL SUBCONTRACTOR.

LAYOUT PENDING RECEIPT OF ROOF PLANT DECK EQUIPMENT

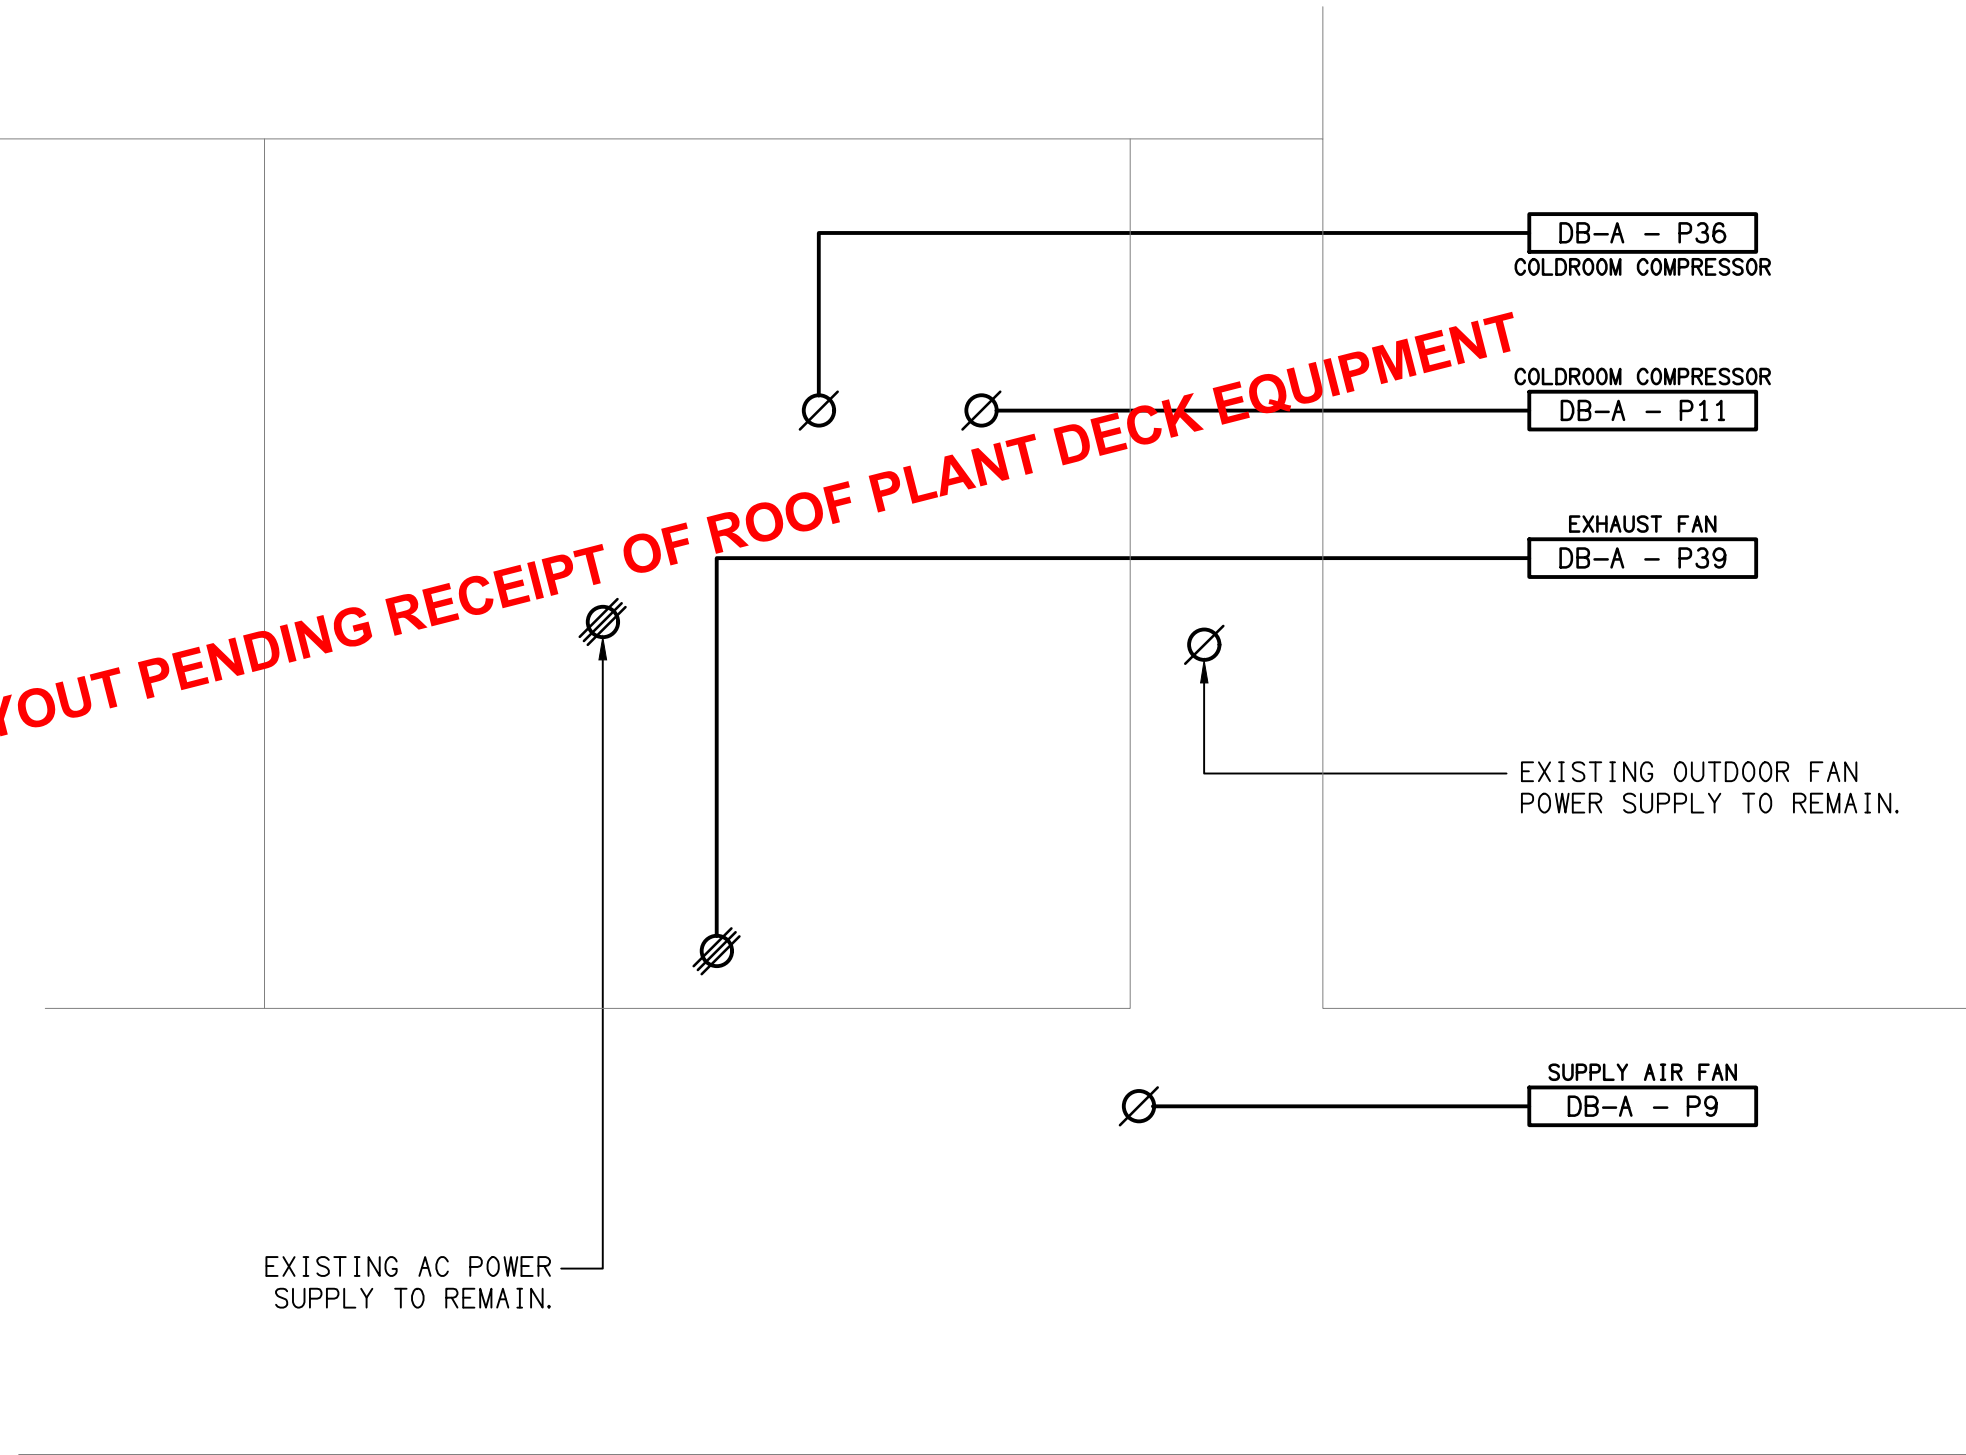

ROOF PLAN

BURGER URGE TENANCY
SCALE 1: 100

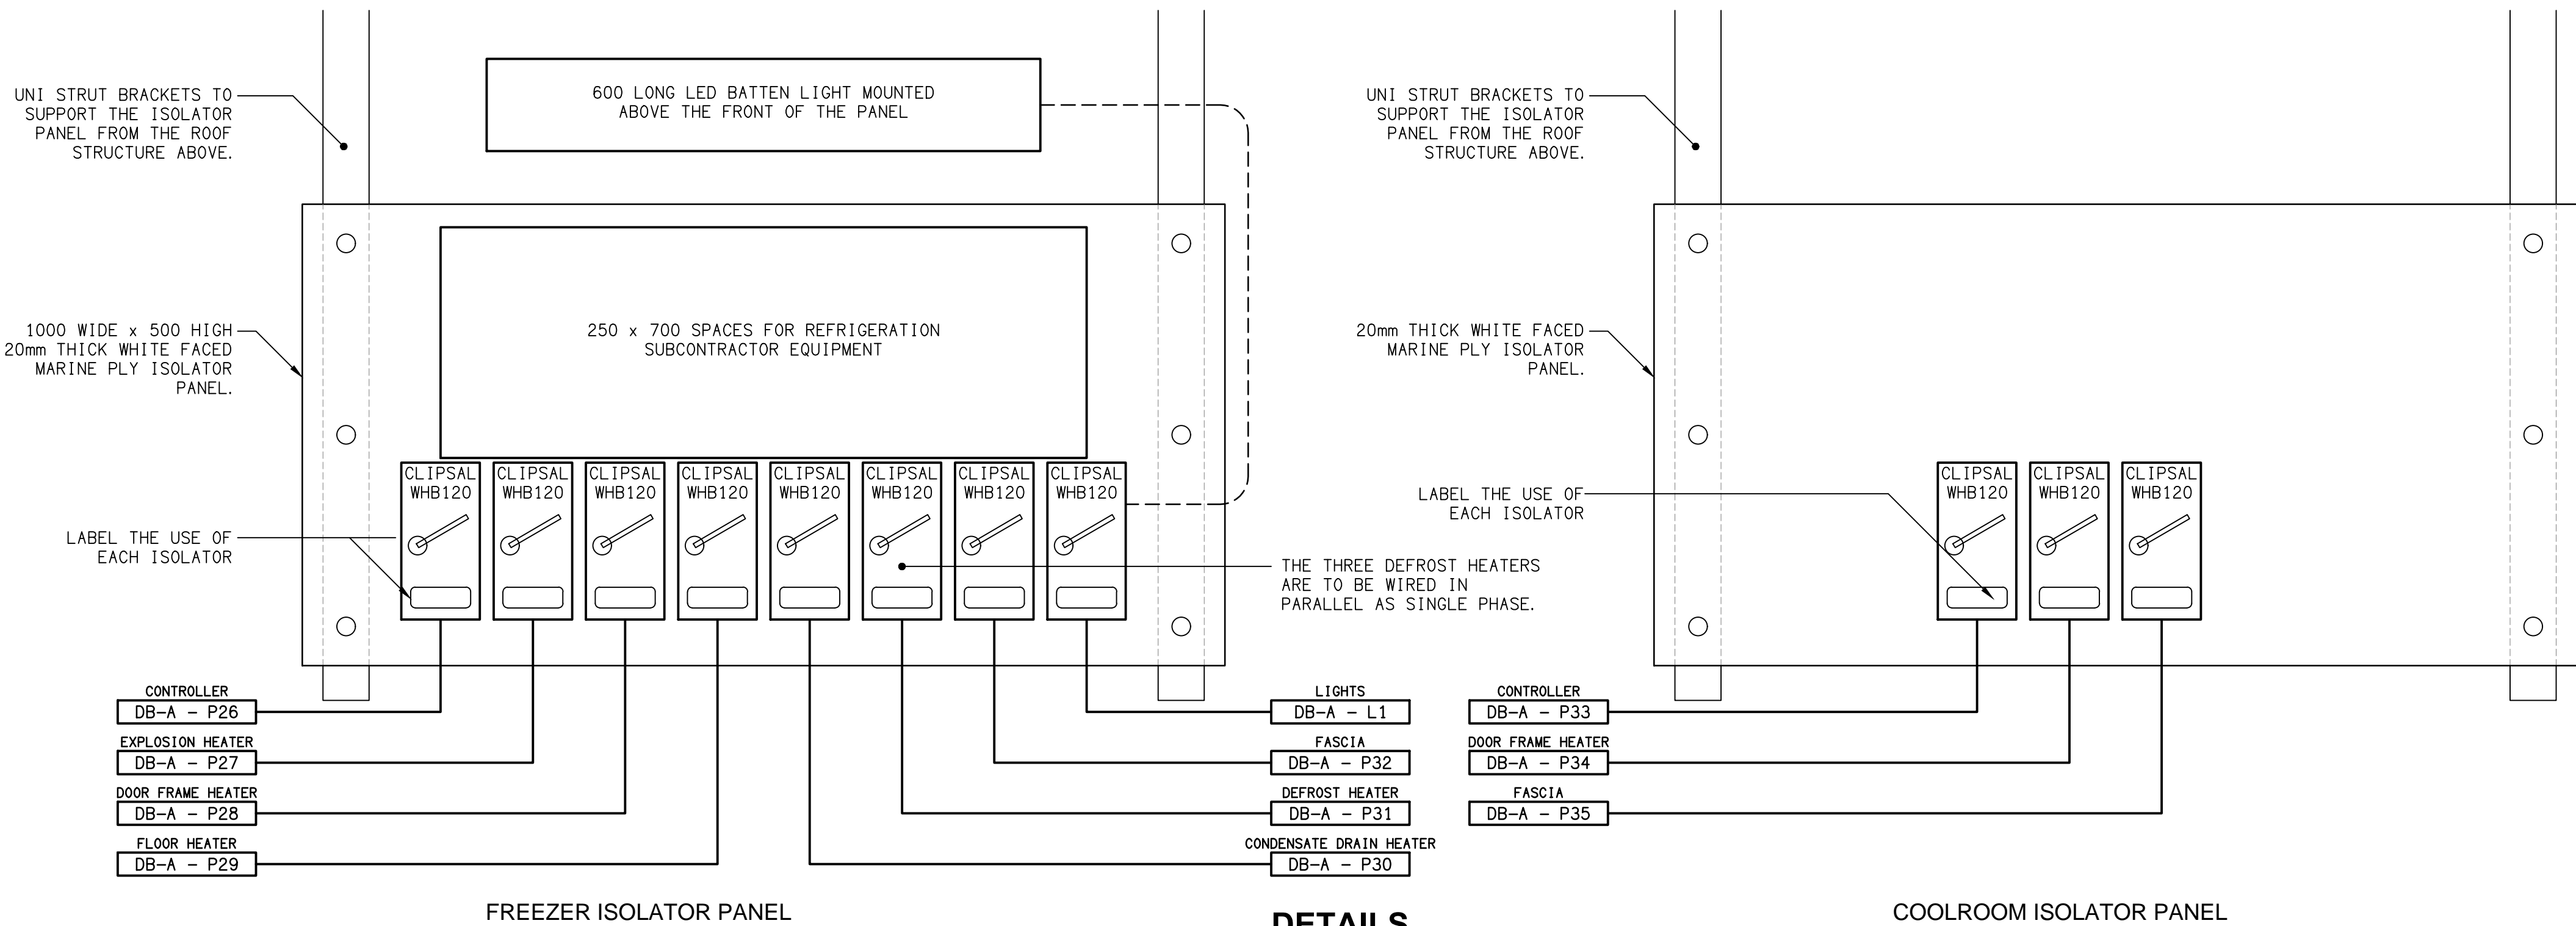

NOTE:

LOCATE THE ELECTRICAL ISOLATOR PANELS IN THE CEILING SPACE ABOVE THE ENTRY DOORS OF THE FREEZER AND COOLROOMS. CEILING ACCESS PANEL TO BE PROVIDED BY THE BUILDER.

DETAILS

ISOLATOR PANEL ELEVATIONS
NOT TO SCALE

| | | |
|------|--------------|------------|
| A | TENDER | 19/12/2025 |
| REV: | DESCRIPTION: | DATE: |

ELECTRICAL DESIGN GROUP
ELECTRICAL BUILDING SERVICES CONSULTANTS

BRISBANE: P.O. Box 15, Sherwood Qld 4075
Phone: (07) 3278 4375
Email: brisbane@edg.net.au
Web: www.edg.net.au

ELECTRICAL DESIGN GROUP BRISBANE PTY LTD
ACN 092 710 793

TRADING AS:
ELECTRICAL DESIGN GROUP

PROJECT:

**BURGER URGE
RIPLEY**

SITE ADDRESS:

7004 BARRAMS ROAD, SOUTH RIPLEY
QUEENSLAND

SCALE:

1:100 UNO

SHEET SIZE:

AT A1

DRAWING TITLE:

**ELECTRICAL SERVICES
ROOF PLAN & DETAILS**

PROJECT NO: DRAWING NO: REVISION:

C3693a E06 A