




| DRAWING LIST | | | |
|--------------|-----------------------------|-----|----------|
| DRAWING NO. | DRAWING NAME | REV | DATE |
| DME600 | COVER SHEET & DRAWING INDEX | A | 20/10/21 |
| DME601 | LIGHTING CONCEPT LAYOUT | A | 20/10/21 |
| DME602 | POWER LAYOUT | A | 20/10/21 |
| DME603 | CABLE WAY LAYOUT | A | 20/10/21 |
| DME604 | SINGLE LINE DIAGRAM | A | 20/10/21 |
| DME605 | DATA LAYOUT | A | 20/10/21 |
| DME606 | PUBLIC ADDRESS LAYOUT | A | 20/10/21 |
| DME607 | CCTV & SECURITY LAYOUT | A | 20/10/21 |
| DME608 | LED CABINET LIGHTS | A | 20/10/21 |

2022.1 DAN MURPHYS DOCUMENTATION KIT

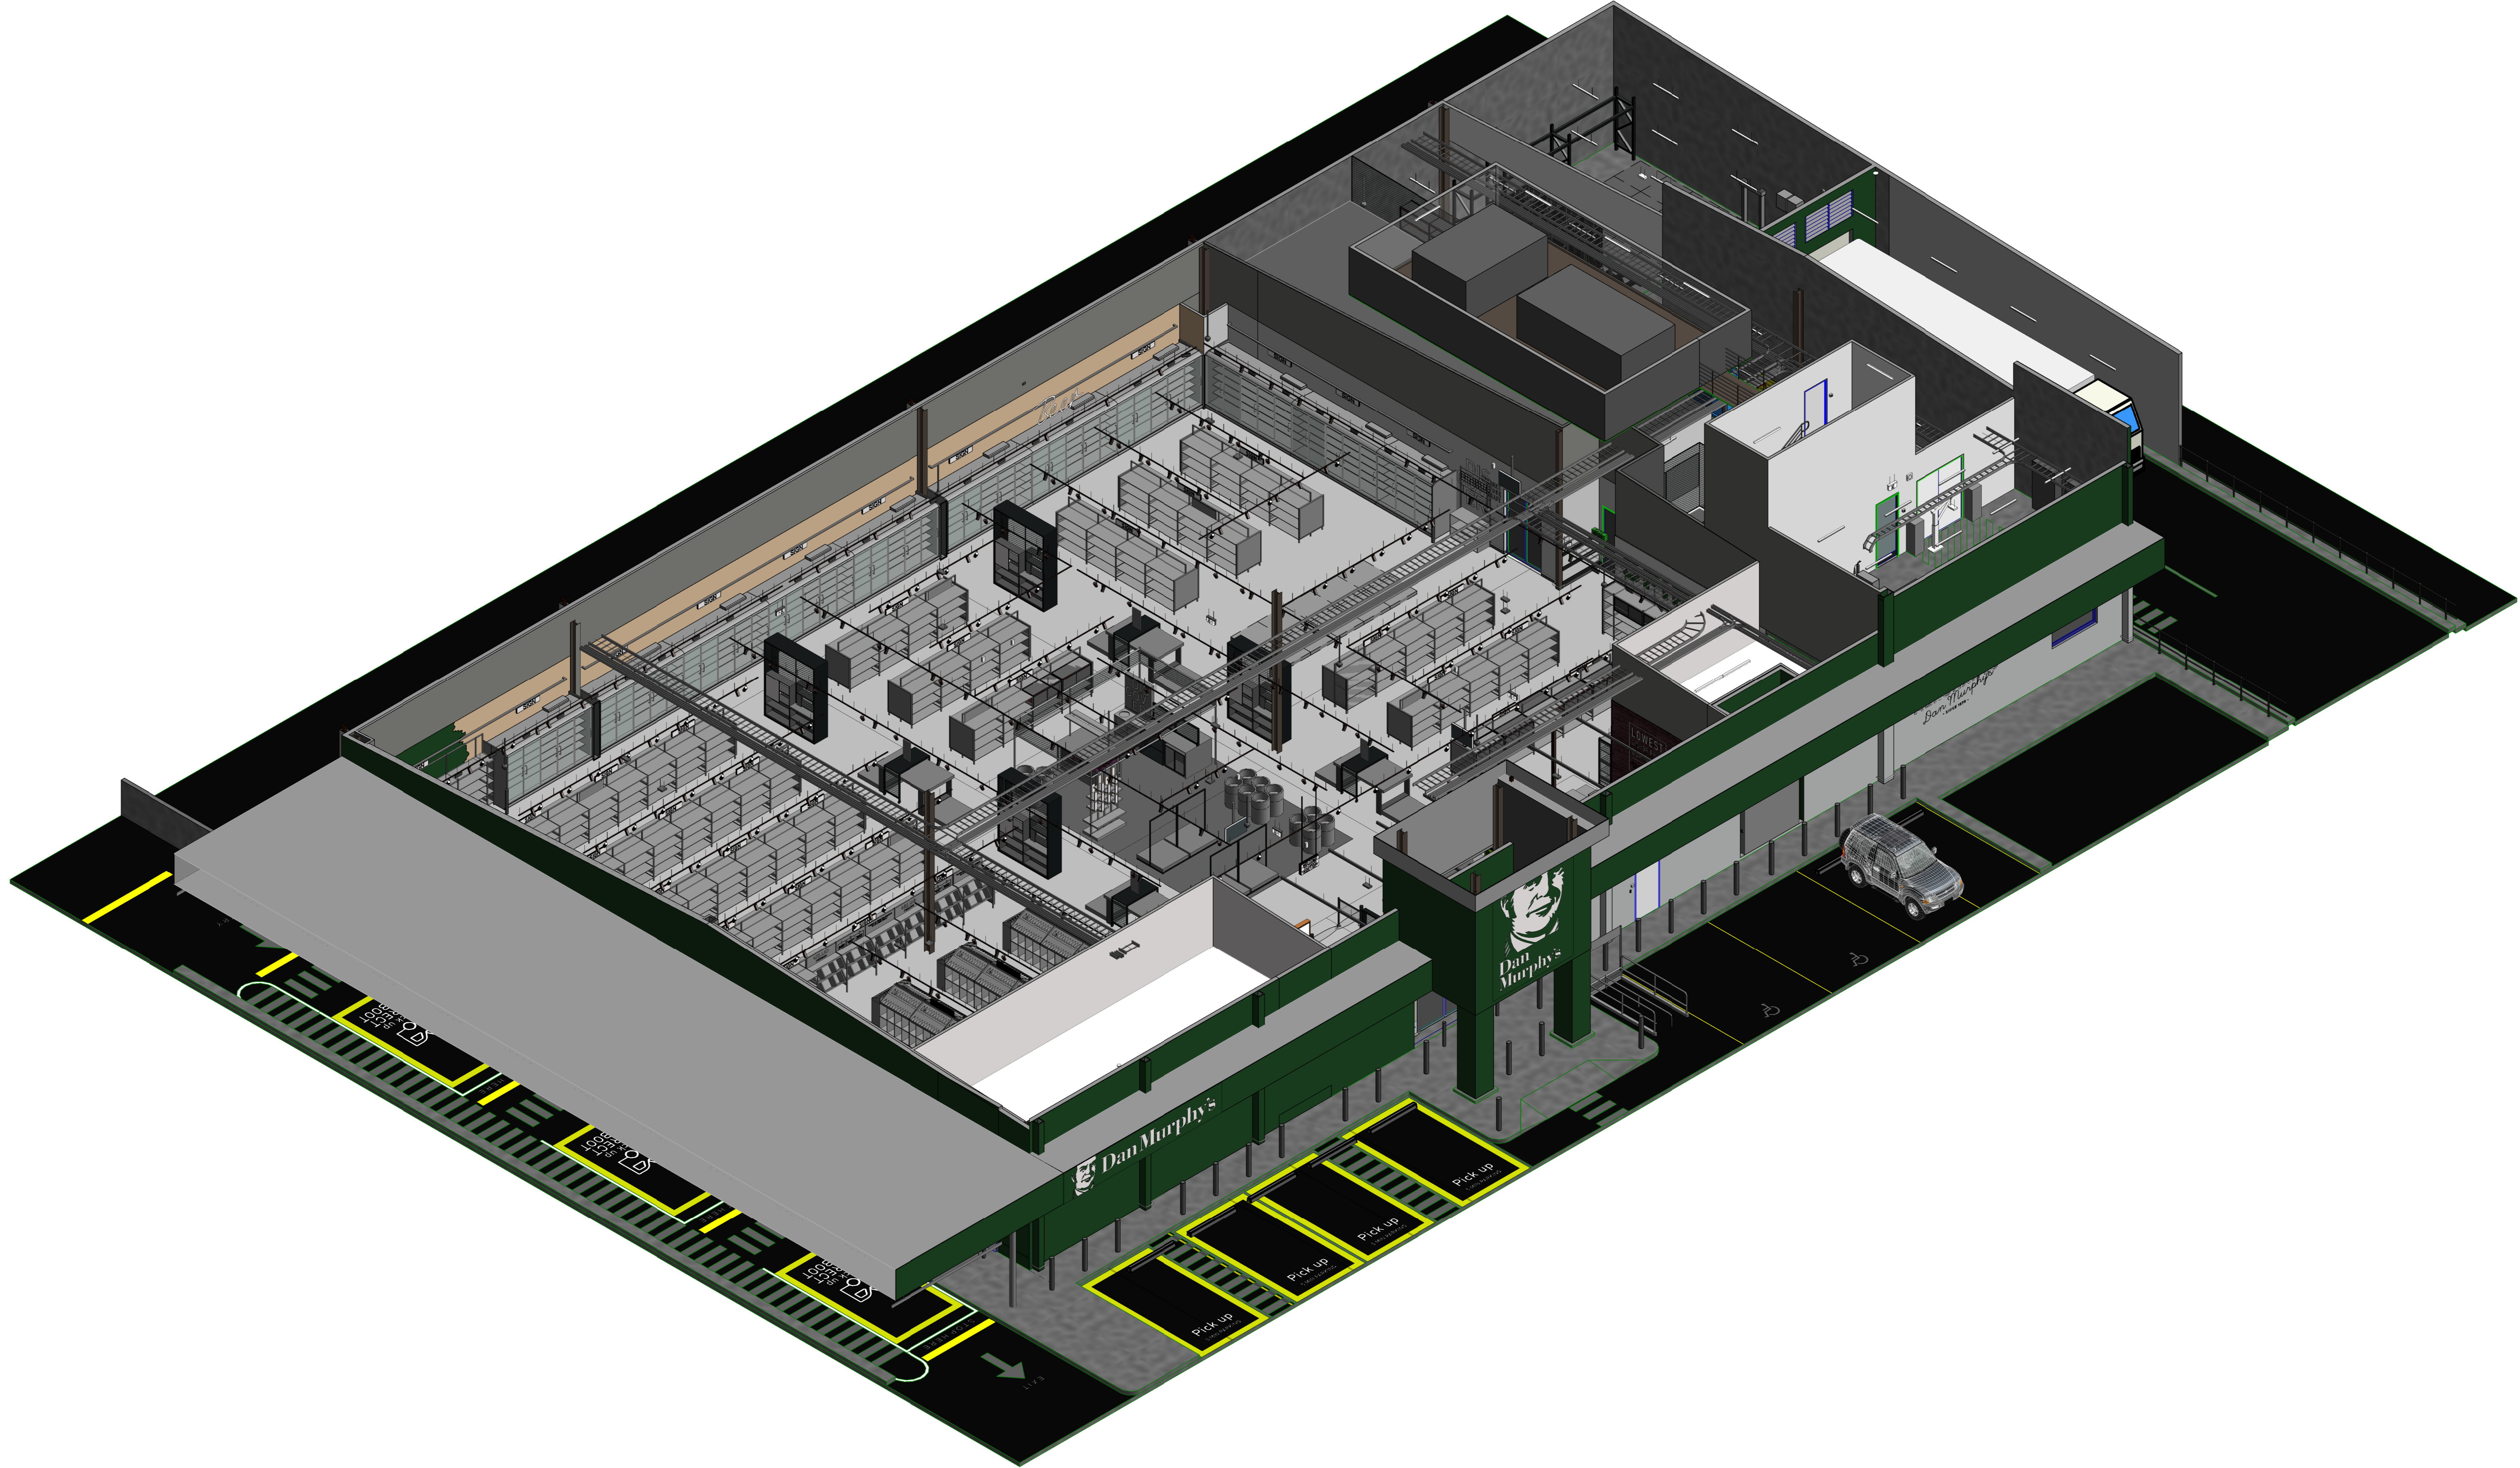

COMPANY DETAILS
 PROJECT ADDRESS: LEVEL 1, 26 WATERLOO STREET, SURRY HILLS NSW
 PROJECT NO: DM 2022 KIT
 DRAWING NO: DME600
 DRAWING NAME: COVER SHEET & DRAWING INDEX
 SCALE: NTS & AO
 REGION / STATE: ALL
 KIT VERSION: DM 2022 KIT
 STORE NO: 0000
 REVISION: A

REV. REVISION DETAILS

| REV. | REVISION DETAILS | DATE | BY |
|------|------------------|----------|----|
| A | FIRST ISSUE | 20/10/21 | CT |

DATE

| DATE | BY |
|----------|----|
| 20/10/21 | CT |

PROJECT ADDRESS:

LEVEL 1, 26 WATERLOO STREET, SURRY HILLS NSW

DRAWING NAME:

COVER SHEET & DRAWING INDEX

SCALE:
 NTS & AO
 REGION / STATE:
 ALL
 DRAWING No.:
DME600
 REVISION:
A

DRAWN BY: ENDEAVOUR GROUP
APPROVED BY: ENDEAVOUR GROUP
CT
EDG

DOC STAGE: DA200 | FITOUT
PROJECT: 2022 KIT
KIT VERSION: DM 2022 KIT
STORE No: 0000

