


**DATA LEGEND**


TO	SCS TELECOMMUNICATIONS OUTLET REG = REGISTER, PC = COMPUTER, TEL = PHONE, SEC = SECURITY, PR = PRINTS, FAX = TELETYPE FAX, FAX MACHINE, TV = TV, DIGITAL SURVEY, DS = DATA OUTLET, DM = DATA OUTLET, FS = FINGER SCAL, RP = RF OUTLET, LPS = LIFE OUTLET
RF	RF OUTLET - REFER TO PREDICTIVE SURVEY REPORT FOR LOCATIONS QUANTITIES ARE INDICATIVE ONLY
BD	SCS BUILDING DISTRIBUTOR
	BLACK 3-CHANNEL METAL DUCT, 100mm X 80mm, ECD OR CABLEWAY

**DATA NOTES**


- SCS DATA SYSTEM TO BE INSTALLED AS PER WOOLWORTHS STORES SCS SPECIFICATION.
- DATA CONTRACTOR TO Liaise WITH ELECTRICAL CONTRACTOR FOR POWER AND CABLE WAY REQUIREMENTS.

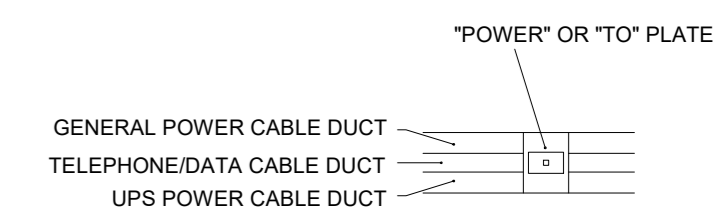

**4 WALL DUCT DETAILS**

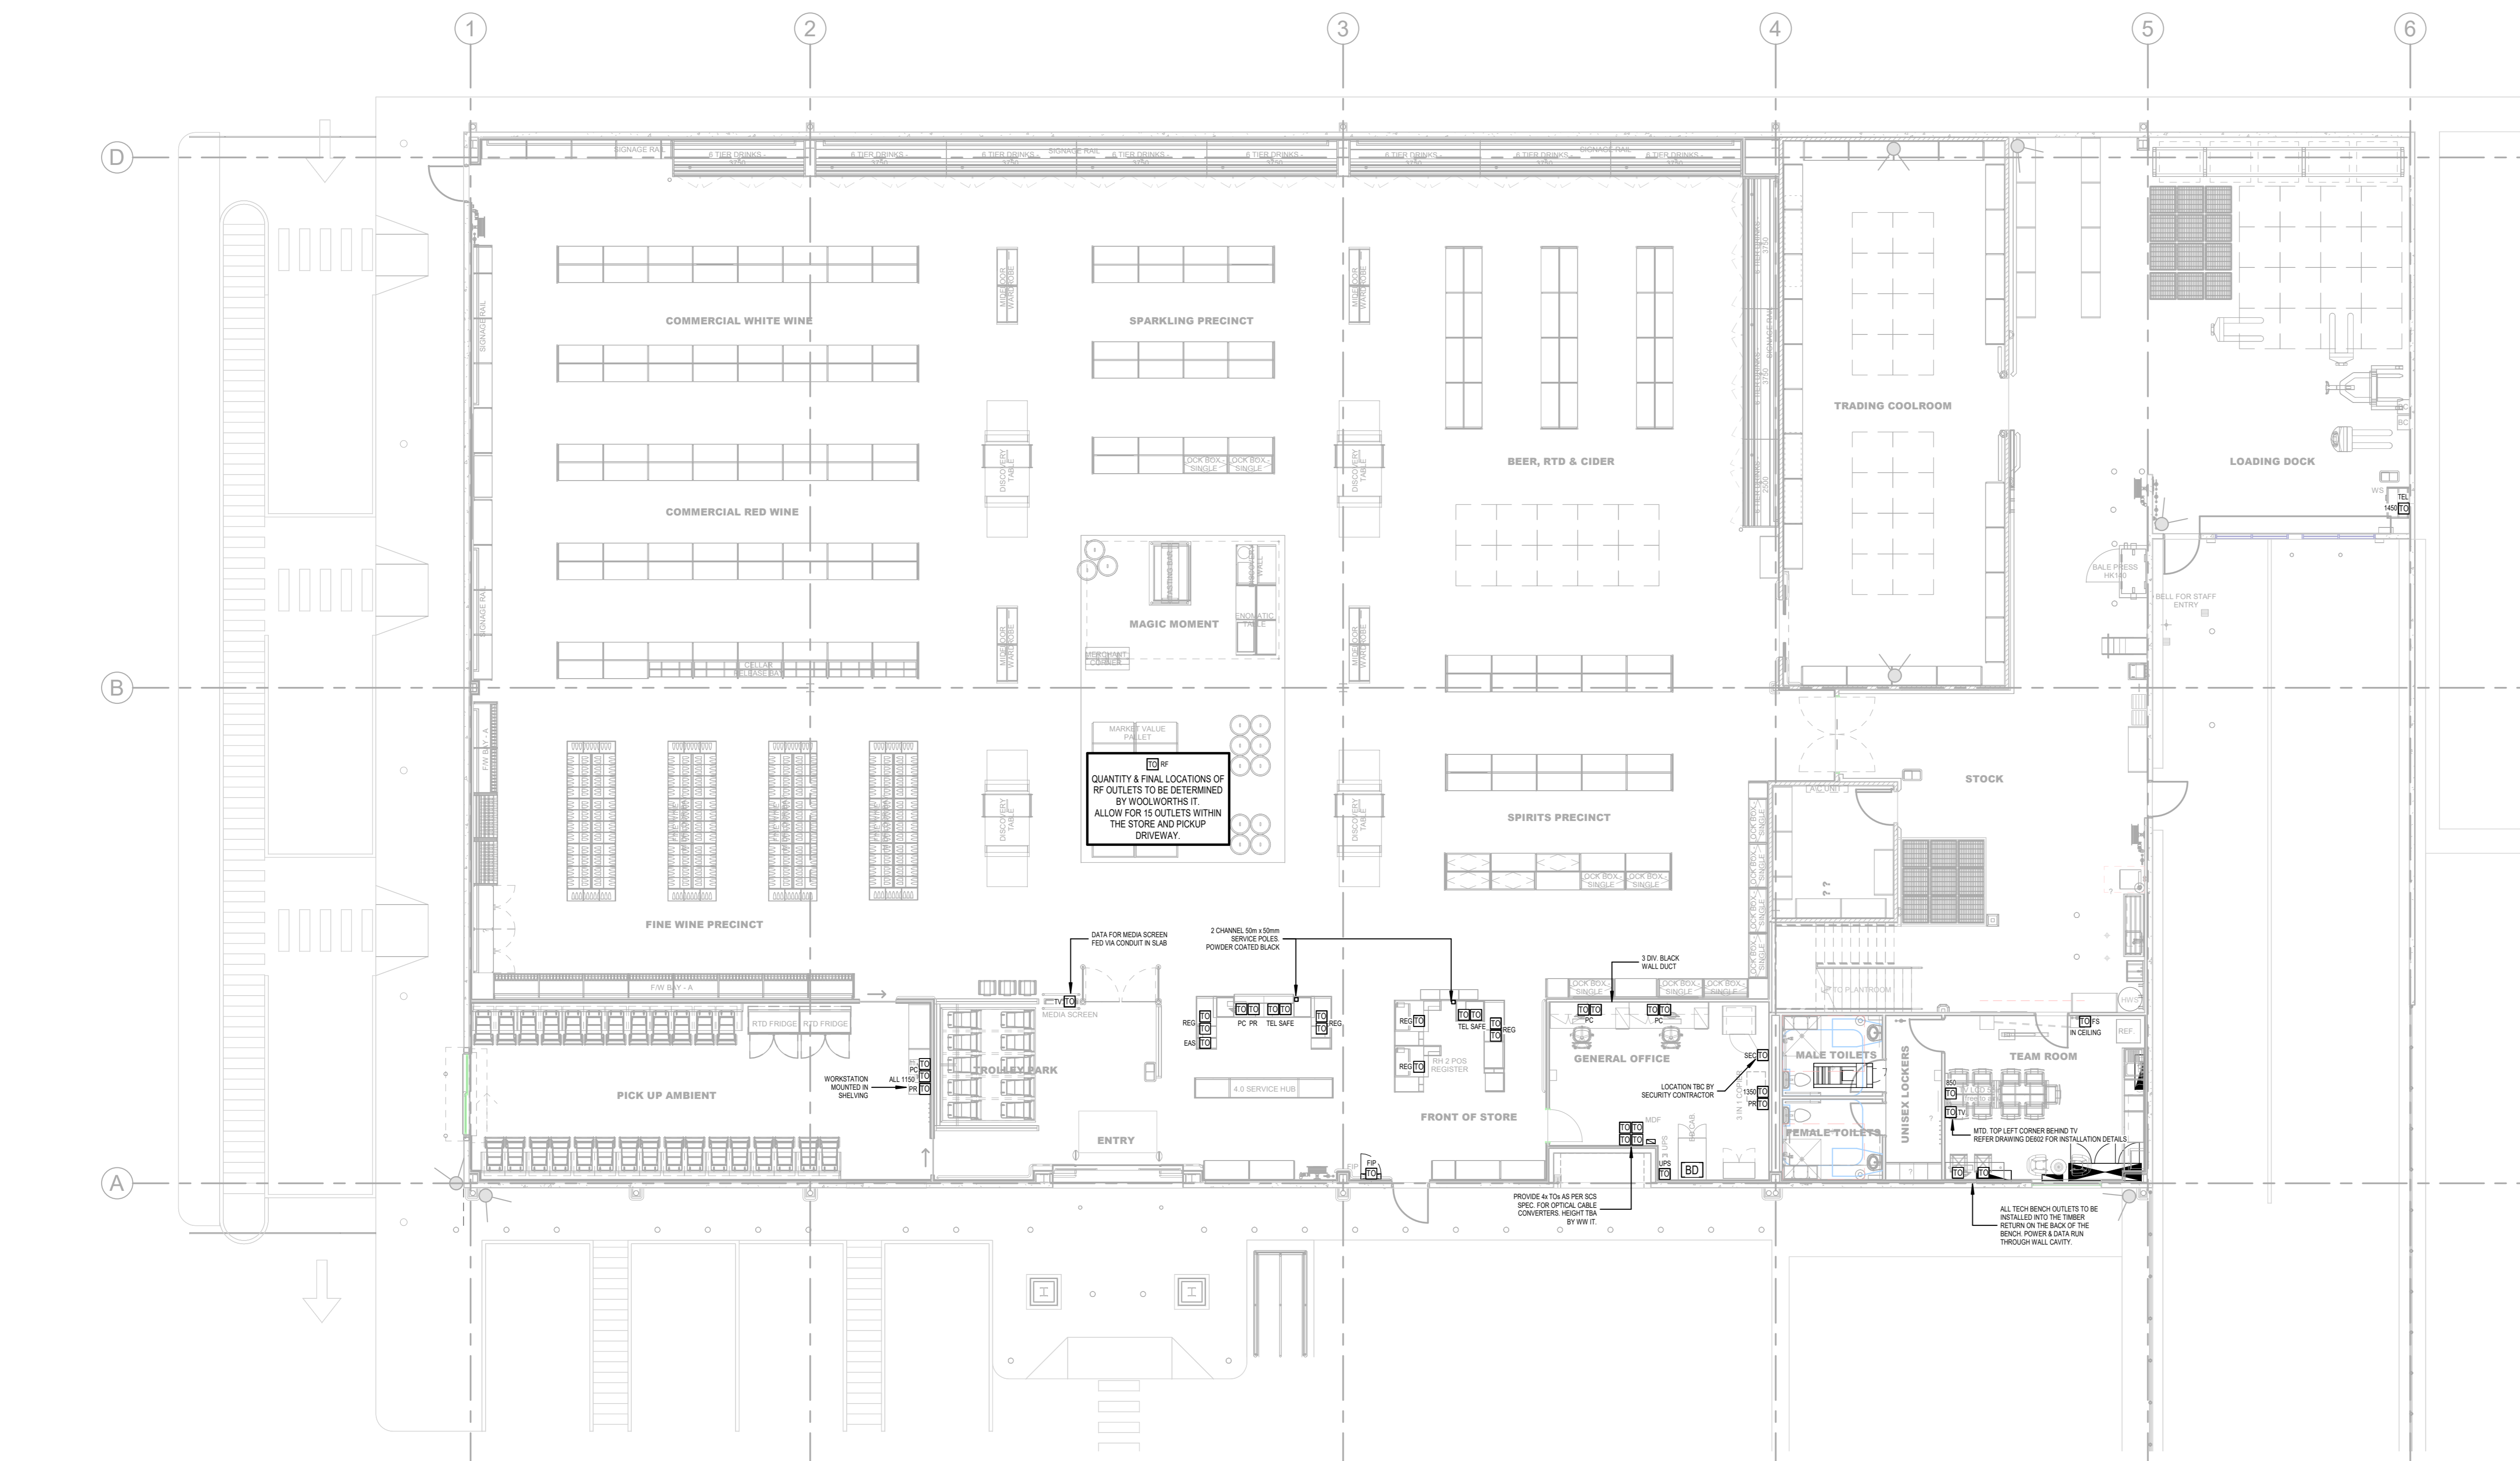

**1 GROUND FLOOR**  
1:100

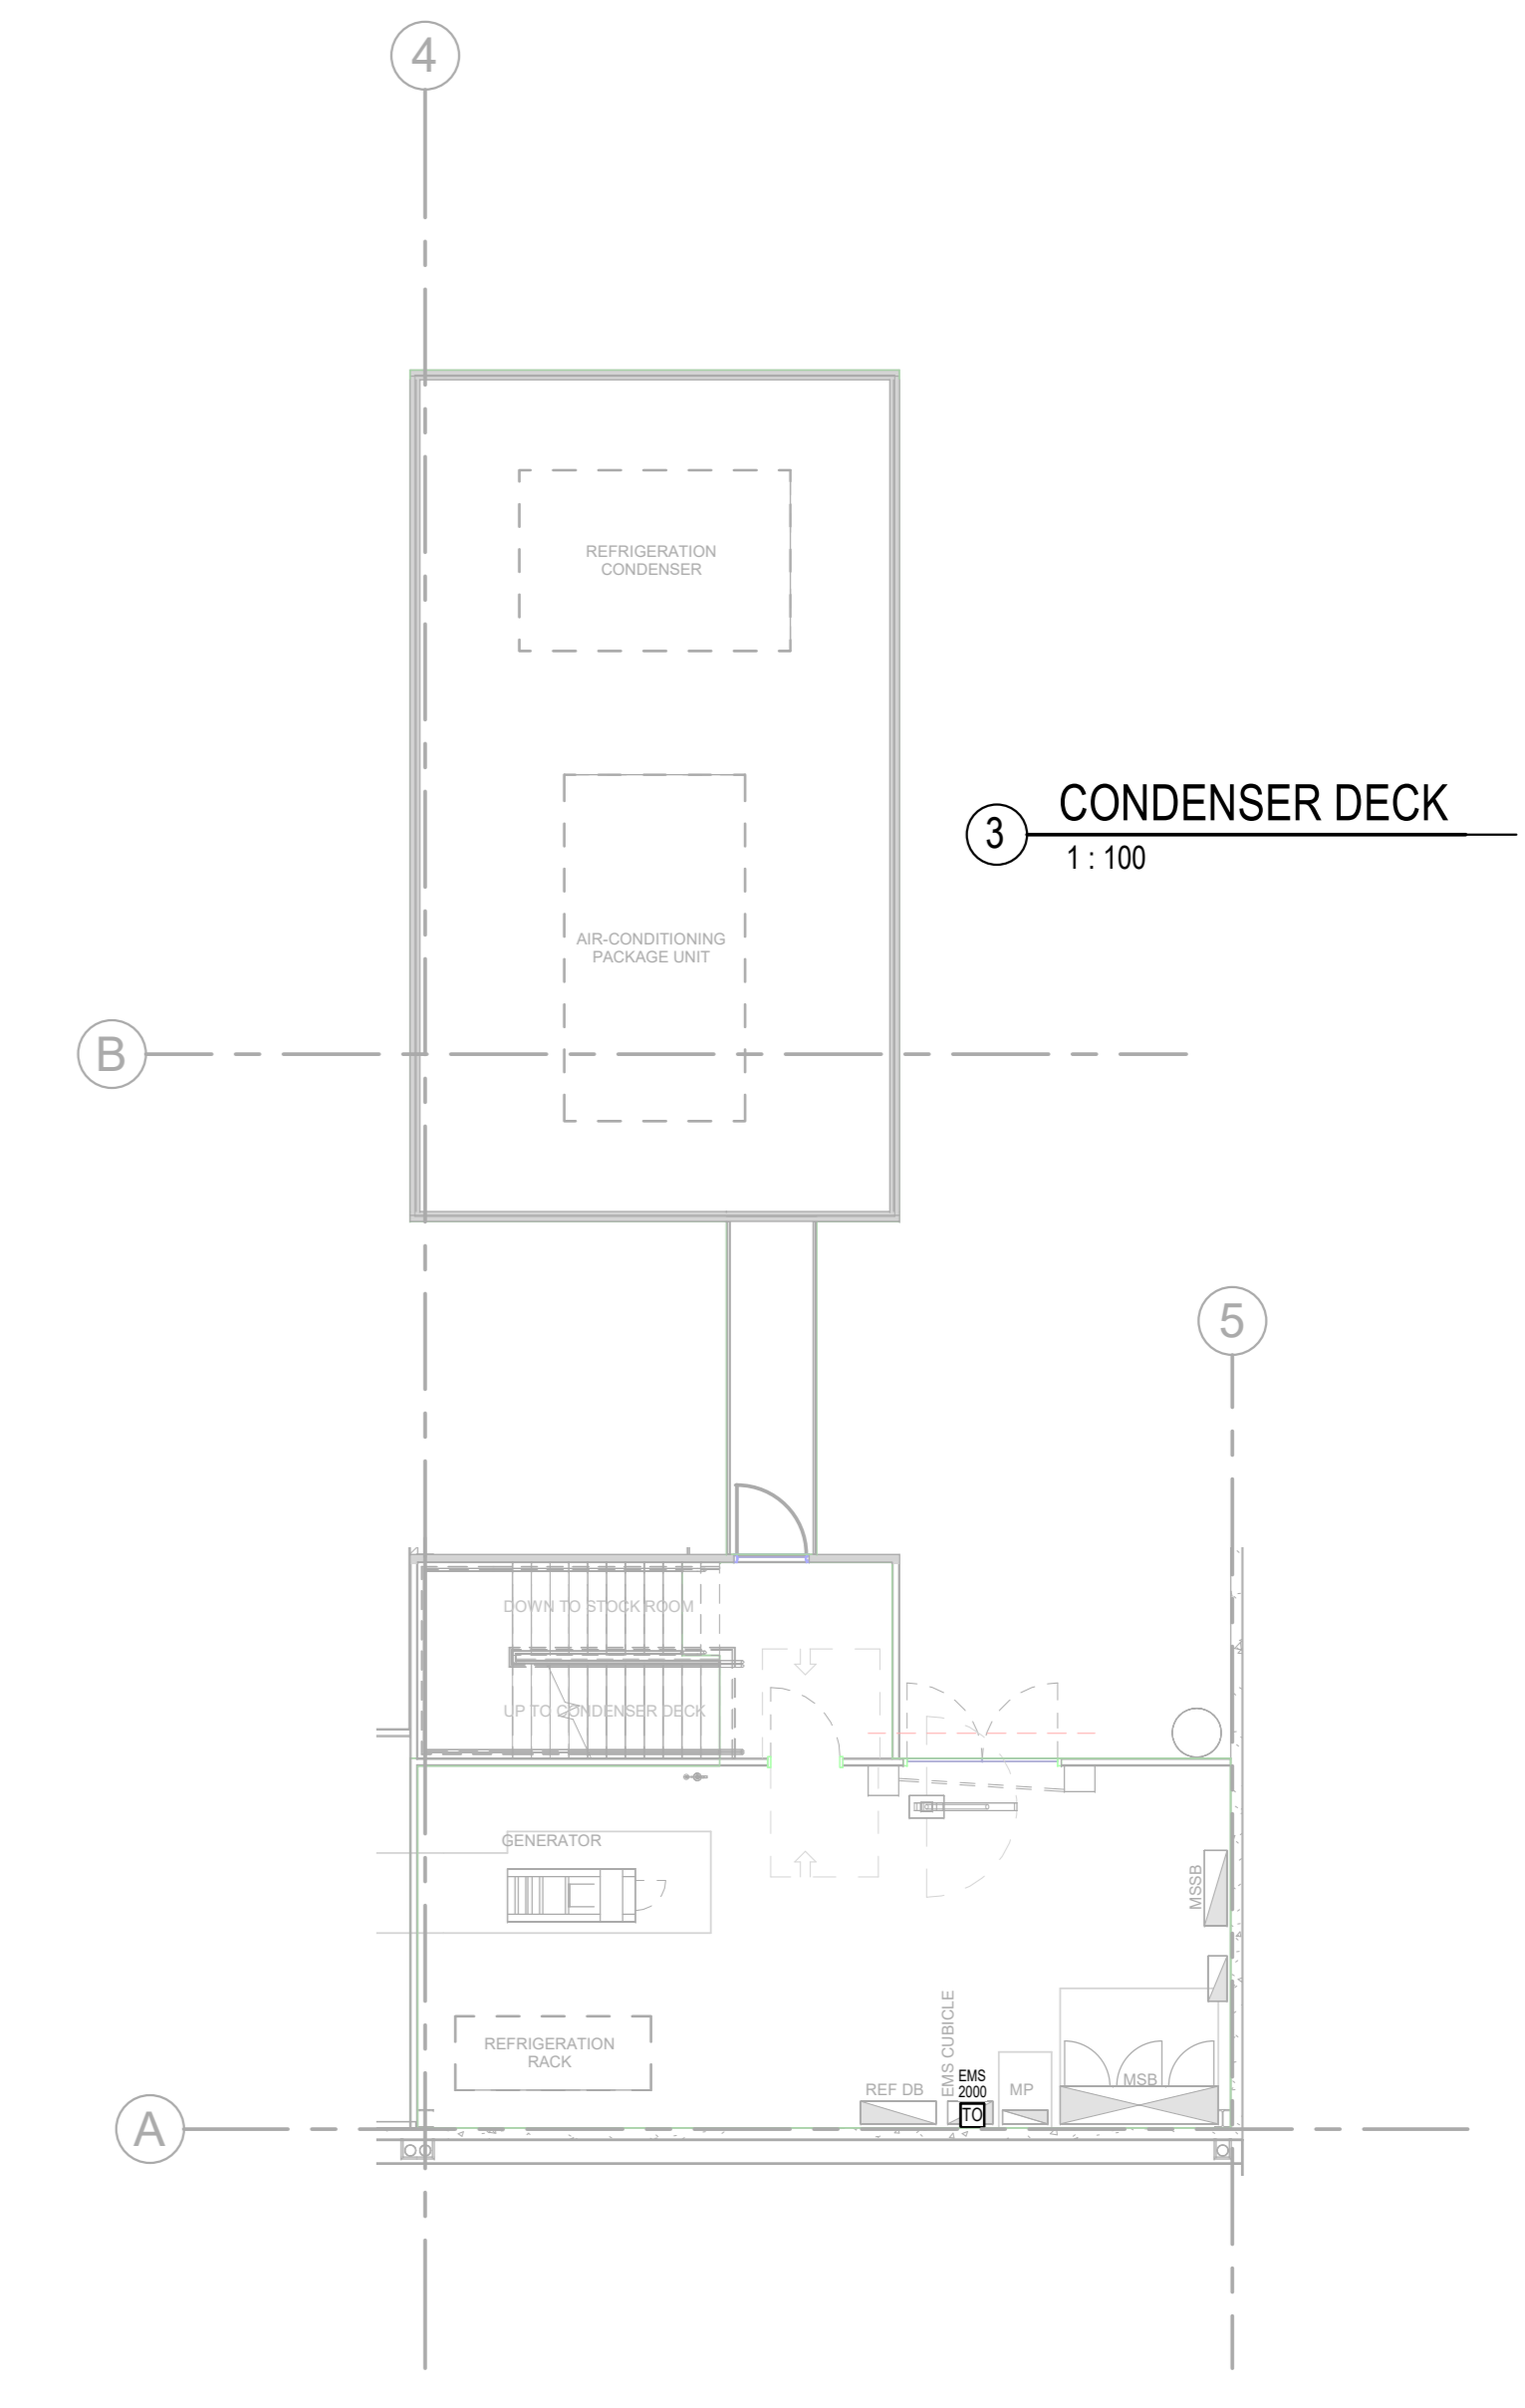


**2 PLANTROOM**  
1:100

**COMPANY DETAILS**  
WOOLWORTHS STORES, 26 WATERLOO STREET, LEVEL 1, 26 WATERLOO STREET, SURRY HILLS NSW  
END EMBLEM  
COPYRIGHT OF THIS DOCUMENT REMAINS WITH ENDEAVOUR GROUP  
NO PART OF THIS DOCUMENT IS TO BE REPRODUCED OR COPIED IN ANY FORM OR BY ANY MEANS, ELECTRONIC, MECHANICAL, PHOTOCOPYING, RECORDING, OR BY ANY INFORMATION STORAGE AND RETRIEVAL SYSTEM, WITHOUT THE WRITTEN PERMISSION OF ENDEAVOUR GROUP.  
ALL DIMENSIONS UNLESS OTHERWISE SPECIFIED ARE IN METERS.  
SCALE SHOWN WITHIN DRAWINGS  
THIS DRAWING IS FOR INFORMATION PURPOSES ONLY AND DOES NOT REPRESENT A CONTRACT. CONTRACT DOCUMENTS SHALL PREVAIL.  
THIS DRAWING IS THE PROPERTY OF ENDEAVOUR GROUP AND IS NOT TO BE REPRODUCED OR COPIED IN ANY FORM OR BY ANY MEANS, ELECTRONIC, MECHANICAL, PHOTOCOPYING, RECORDING, OR BY ANY INFORMATION STORAGE AND RETRIEVAL SYSTEM, WITHOUT THE WRITTEN PERMISSION OF ENDEAVOUR GROUP.

**REV. REVISION DETAILS**

A	FIRST ISSUE
---	-------------

<b>DATE</b>	<b>BY</b>
26/10/21	CT

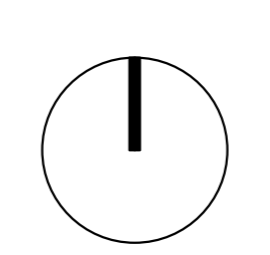

**PROJECT ADDRESS:**  
LEVEL 1, 26 WATERLOO STREET, SURRY HILLS NSW

**DRAWING NAME:**  
DATA LAYOUT

**DOC STAGE:**  
DA200 | FITOUT

**PROJECT:**  
2022 KIT

**ISSUE TO:**  
EDG

**APPROVED BY:**  
ENDEAVOUR GROUP

**SCALE:**  
1:100 @ A0  
REGION / STATE:  
ALL  
**DME605**  
REVISION:  
A

**KIT VERSION:**  
DM 2022 KIT

**STORE No.:**  
0000

