
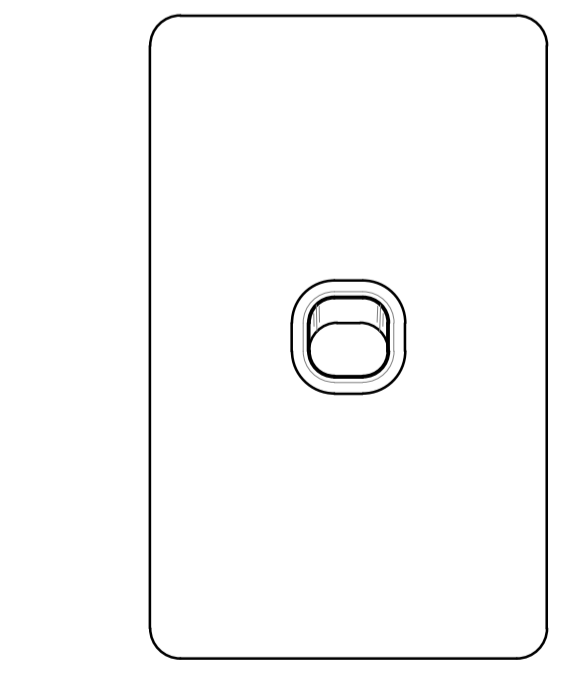
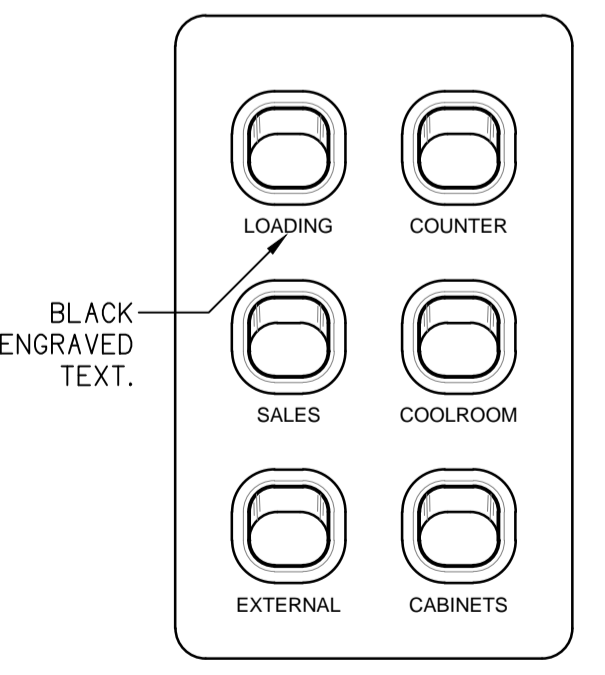



NOTE:
 LIGHT FITTINGS DENOTED WITH A "X" SYMBOL ARE 24-HOUR OPERATION LIGHTS ON CIRCUIT DB-DM - L1

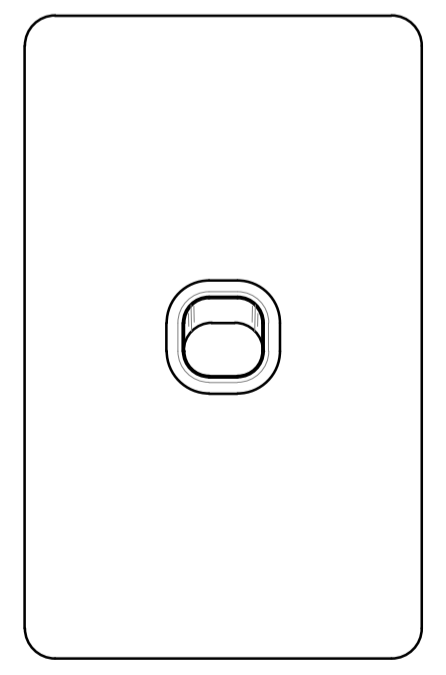


DETAIL B
 SP1 SWITCH PANEL
 NOT TO SCALE

DETAIL C
 SP2 SWITCH PANEL
 NOT TO SCALE

DETAIL D
 SP3 SWITCH PANEL
 NOT TO SCALE

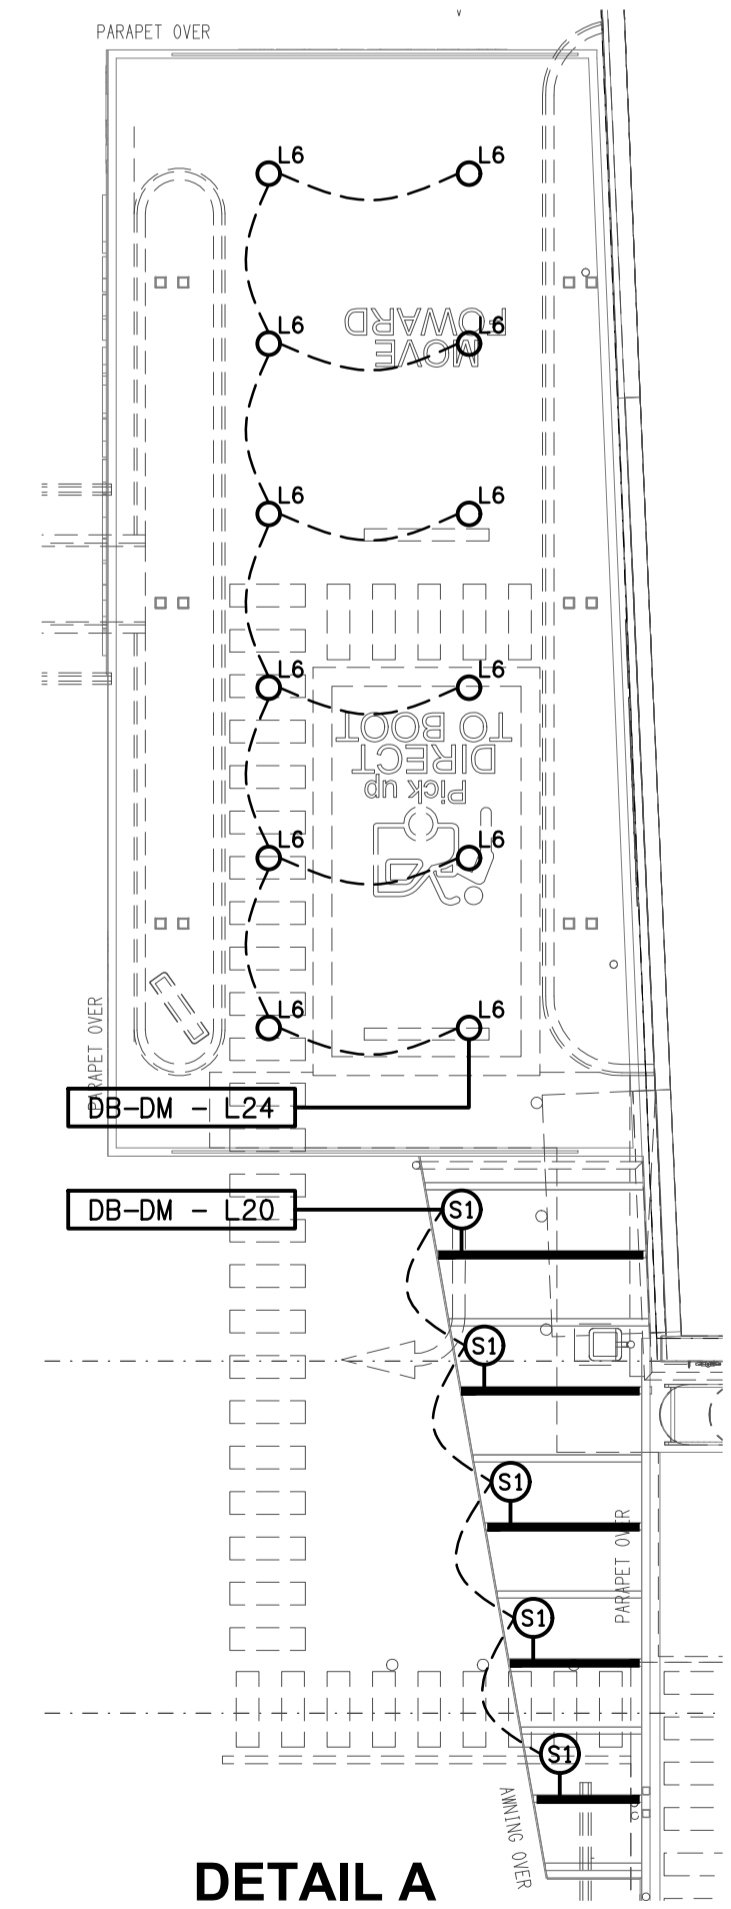

DETAIL A
 PICK UP & AWNING PLAN
 SCALE 1:100

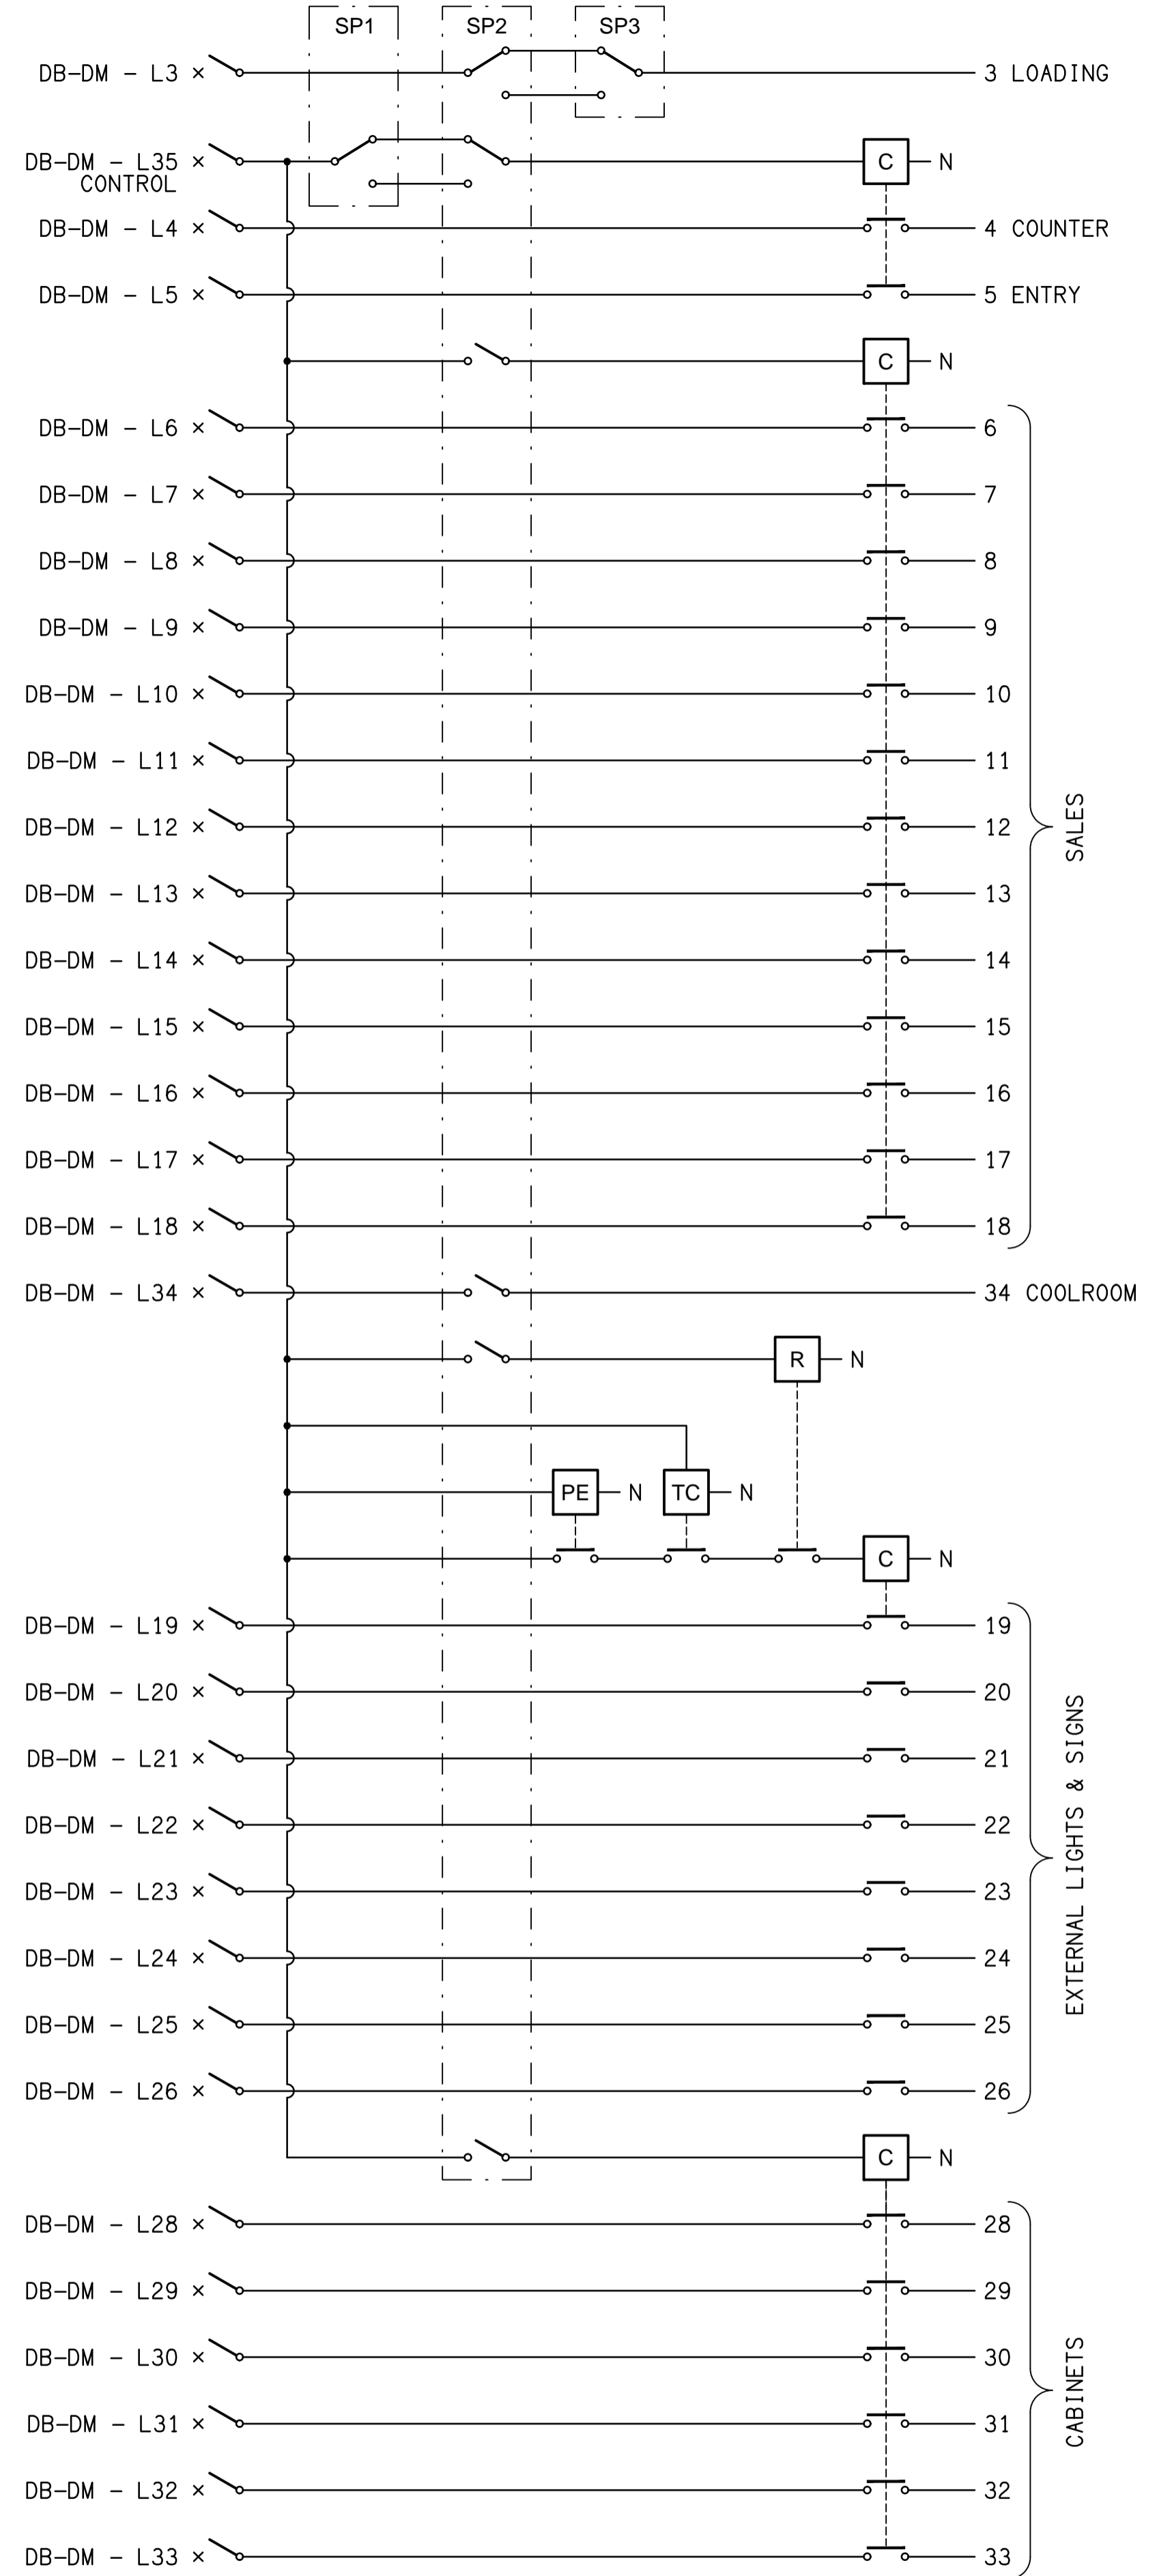

SCHEMATIC
 SP1, SP2, SP3 LIGHTING CONTROL
 NOT TO SCALE

REMOTE DAN MURPHY'S STORAGE

ELECTRICAL DESIGN GROUP BRISBANE
 PTY LTD
 ACN 092 710 793
 TRADING AS:
 ELECTRICAL DESIGN GROUP

THE COPYRIGHT OF THIS DRAWING
 REMAINS THE PROPERTY OF THE
 ELECTRICAL DESIGN GROUP.
 USE FIGURED DIMENSIONS
 IN PREFERENCE TO SCALE.
 ALL DIMENSIONS TO BE
 VERIFIED ONSITE.

ELECTRICAL DESIGN GROUP
 ELECTRICAL BUILDING SERVICES CONSULTANTS
 BRISBANE GOLD COAST

P.O. Box 15, Sherwood Q.4075
 Phone: (07) 3278 4375
 Email: brisbane@edg.net.au
 Web: www.edg.net.au

PROJECT:
PALM BEACH DAN MURPHYS

118 GOLD COAST HIGHWAY, PALM BEACH, GOLD COAST

B	TENDER	19/06/2023
REV.	DESCRIPTION:	DATE:

DRAWING:
**ELECTRICAL SERVICES
 LIGHTING LAYOUT**

SCALE:
 1:100 AT A1
 PROJECT NO:
C2582a
 DRAWING NO:
E04
 REVISION:
B