

ALARM SECURITY LEGEND

⬇R	ROLLER SHUTTER REED SWITCHES
⬇F	CONCEALED MAGNETIC REED SWITCHES
⬇SM	SURFACE MOUNT REED SWITCHES
↑DA	DAY ALARM SIREN CW COVER
⬇WA	WIDE ANGLE MOVEMENT DETECTOR
⬇LRD	LONG RANGE MOVEMENT DETECTOR
⊙360	360 CEILING MOVEMENT DETECTOR
•	ENTRY / EXIT BUZZER
⬇GB	GLASS BREAK
⊙VI	STROBE
⬇HUP	HOLD UP BUTTON
⬇RADIO	RADIO DURESS RECEIVER UNIT
↑↑	INTERNAL SIREN
⬆	EXTERNAL SATELLITE SIREN
⬆	SECURITY PANEL
⬆	DATA GATHERING PANEL
⬆	ELECTRIC STRIKE
⬆	ELECTRO-MAGNETIC LOCK
⬆	INTERCOM MASTER UNIT
⬆	INTERCOM DOOR UNIT
⬆	ALARM OVER IP BACKUP UNIT

ALARM SECURITY LEGEND


⬆GSM	GSM BACKUP UNIT
⬆PWR	POWER SUPPLY UNIT
⬆LIGHT	LIGHTING CONTROL INTERFACE
⬆INTER	ROLLER SHUTTER INTERFACE UNIT
⬆FRIDGE	REFRIGERATION ALARM
⬆UPS	UPS INPUT POWER FAILURE
⬆RAS 8	8 AREA REMOTE ARMING STATION
⬆RAS 16	16 AREA REMOTE ARMING STATION
⬆RAS E	EXTERNAL REMOTE ARMING STATION
⬆SMOKE	SMOKE DETECTOR
⬆CR	CARD READER

CCTV SECURITY LEGEND

⬆NVR	NETWORK VIDEO RECORDER
⬆6RU	6RU CCTV CABINET
⬆12RU	12RU CCTV CABINET
⬆SWITCH	CCTV SWITCH
⬆POE	POE EXTENDER
⬆DEC	IP CAMERA DECODER
⬆FD	FLOOR DISTRIBUTOR
⬆SE	STORE ENTRY 40" LED MONITOR
⬆SP	SPIRITS 40" LED MONITOR
⬆CR	COOLROOM 40" LED MONITOR
⬆IP	IP CAMERA

CCTV & SECURITY NOTES

1. SECURITY AND CCTV LAYOUT IS INDICATIVE ONLY. ELECTRICAL CONTRACTOR IS TO REFER TO SECURITY CONTRACTOR'S SITE SPECIFIC DESIGN TO ALLOW FOR POWER AND DATA OUTLETS AND ALL NECESSARY CONCEALED CONDUITS / WALL BOXES.

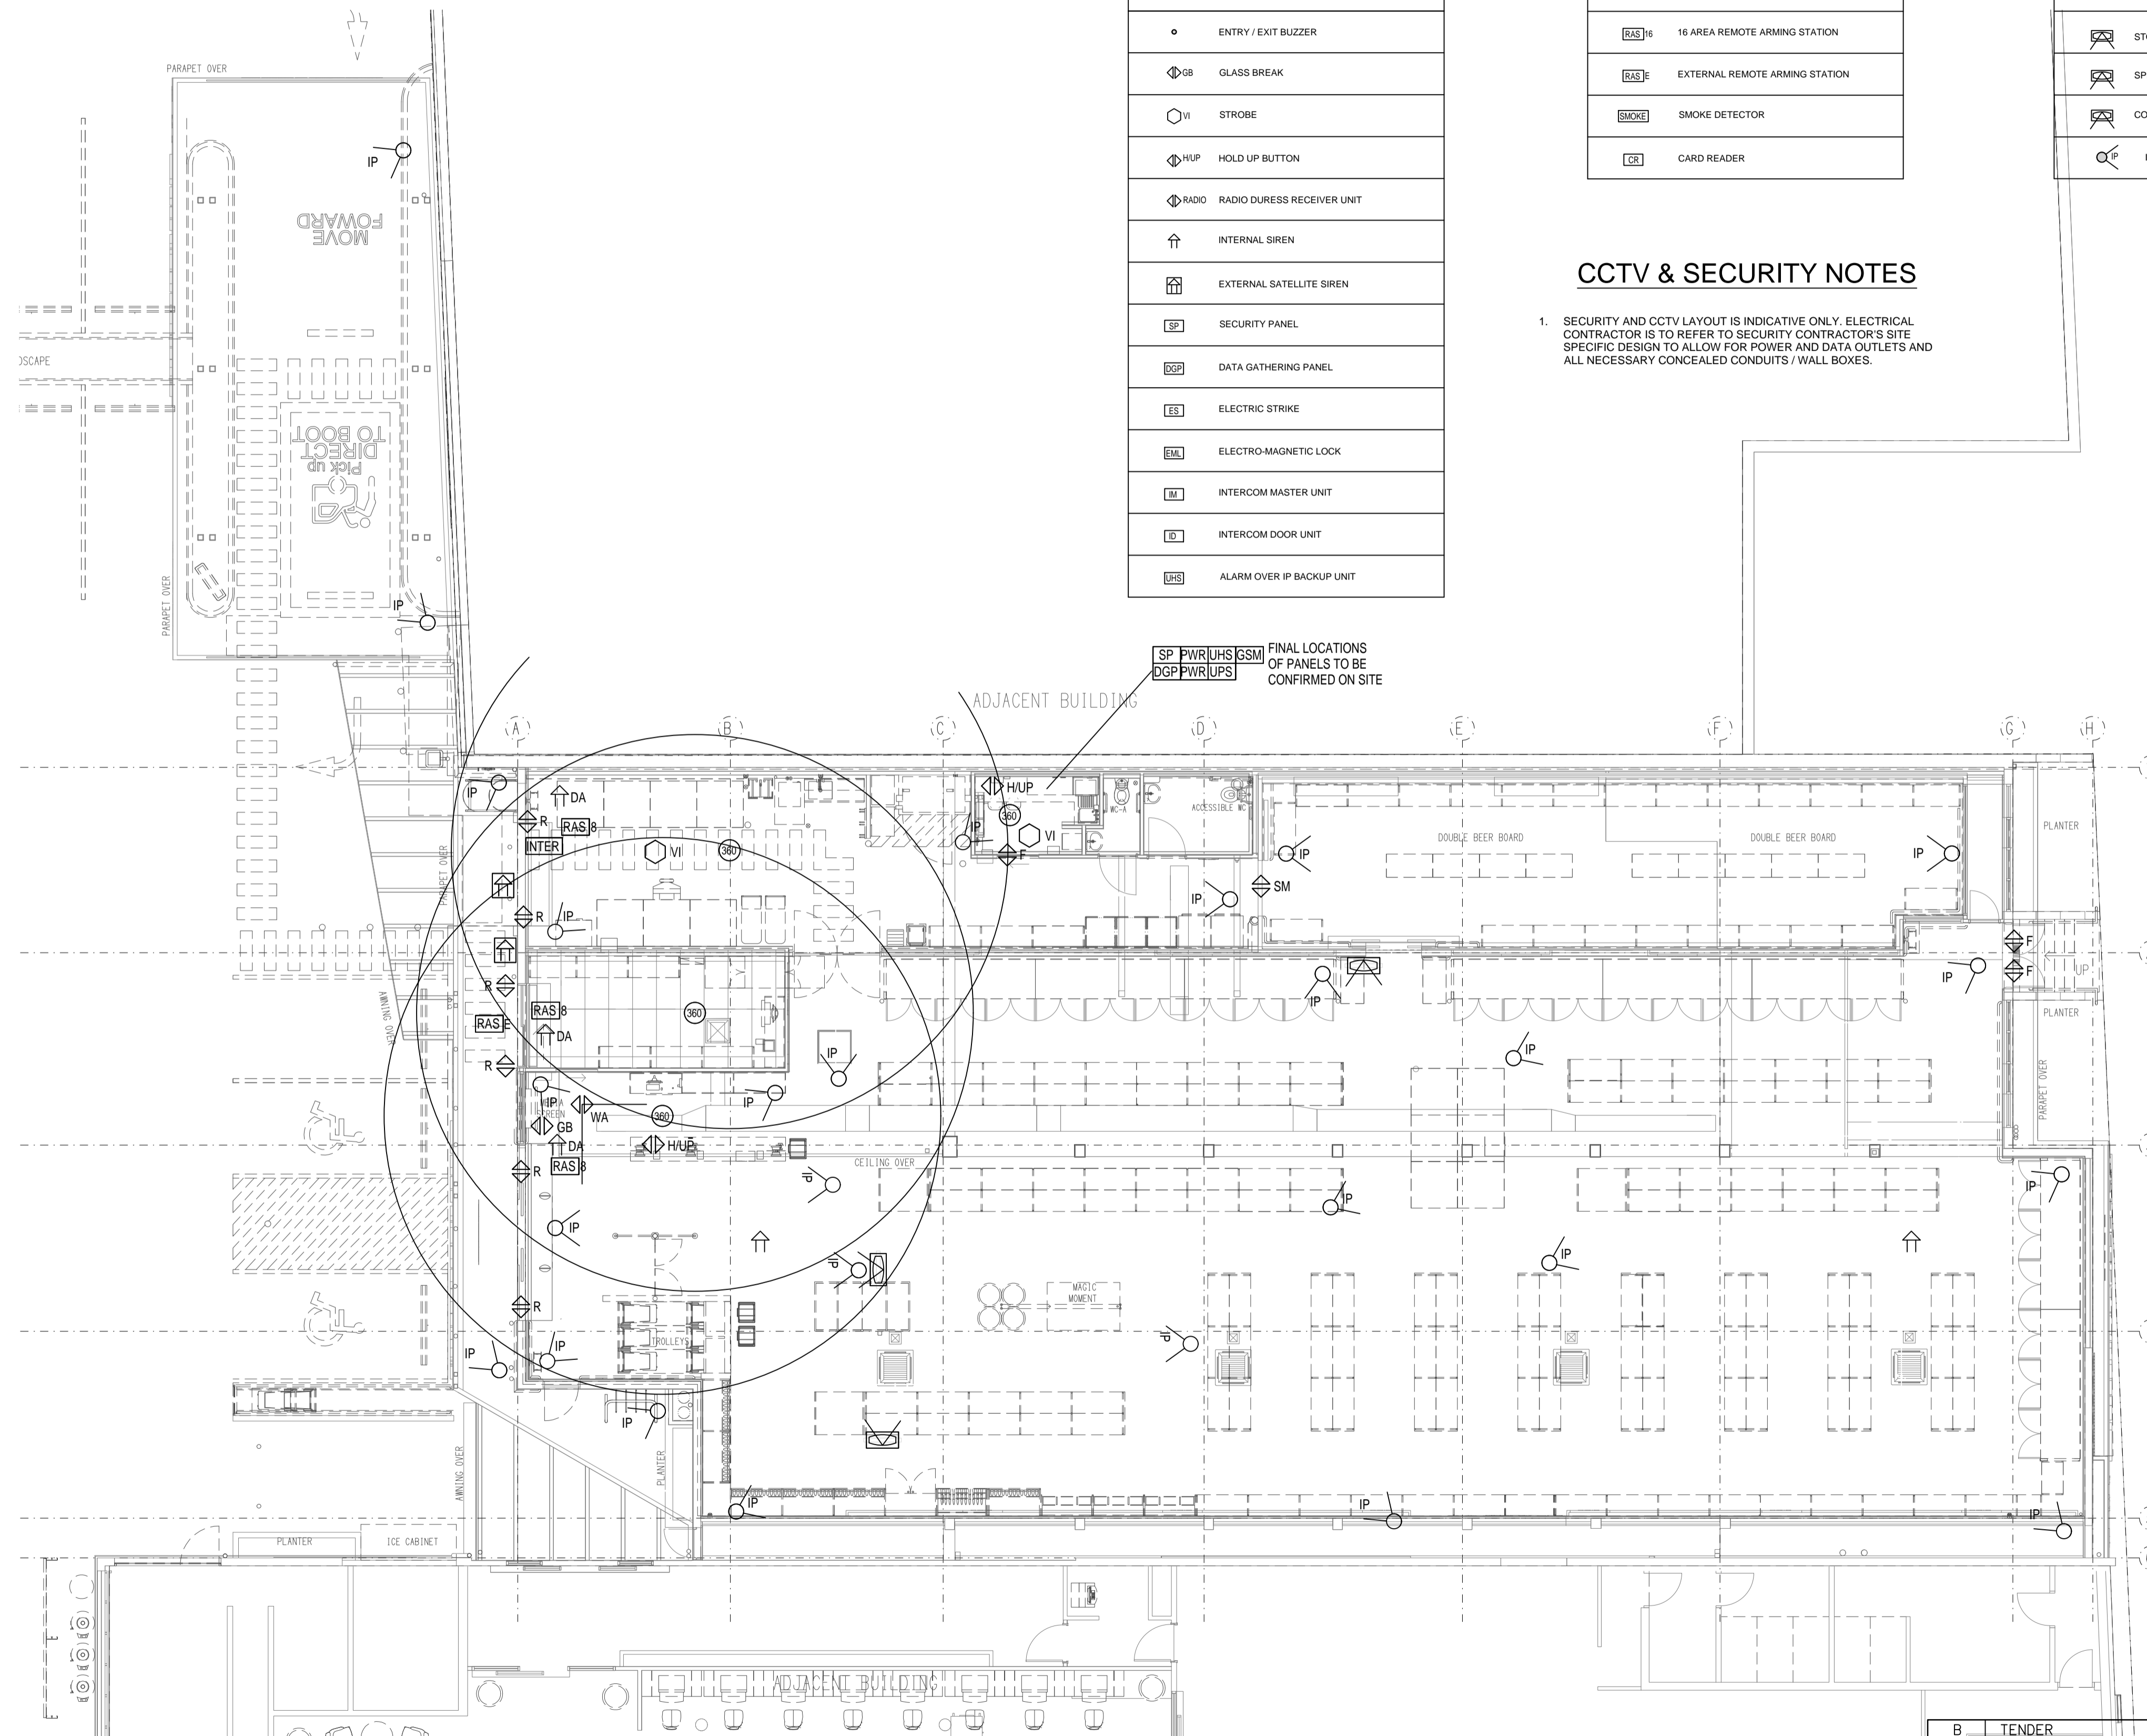

ELECTRICAL DESIGN GROUP BRISBANE
PTY LTD
ACN 092 710 793
TRADING AS:
ELECTRICAL DESIGN GROUP

THE COPYRIGHT OF THIS DRAWING
REMAINS THE PROPERTY OF THE
ELECTRICAL DESIGN GROUP.
USE FIGURED DIMENSIONS
IN PREFERENCE TO SCALE.
ALL DIMENSIONS TO BE
VERIFIED ONSITE.

ELECTRICAL DESIGN GROUP
ELECTRICAL BUILDING SERVICES CONSULTANTS
BRISBANE GOLD COAST

P.O.Box 15, Sherwood Q.4075
Phone: (07) 3278 4375
Email: brisbane@edg.net.au
Web: www.edg.net.au

PROJECT:
PALM BEACH DAN MURPHYS

118 GOLD COAST HIGHWAY, PALM BEACH, GOLD COAST

B	TENDER	19/06/2023
REV:	DESCRIPTION:	DATE:

DRAWING:
**ELECTRICAL SERVICES
DAN MURPHY'S CCTV & SECURITY LAYOUT**

SCALE: 1:100	AT A1	PROJECT NO: C2582a	DRAWING NO: E07	REVISION: B
-----------------	-------	------------------------------	---------------------------	-----------------------