




SITE PLAN
PROPOSED BUILDING 4
 SCALE 1: 200

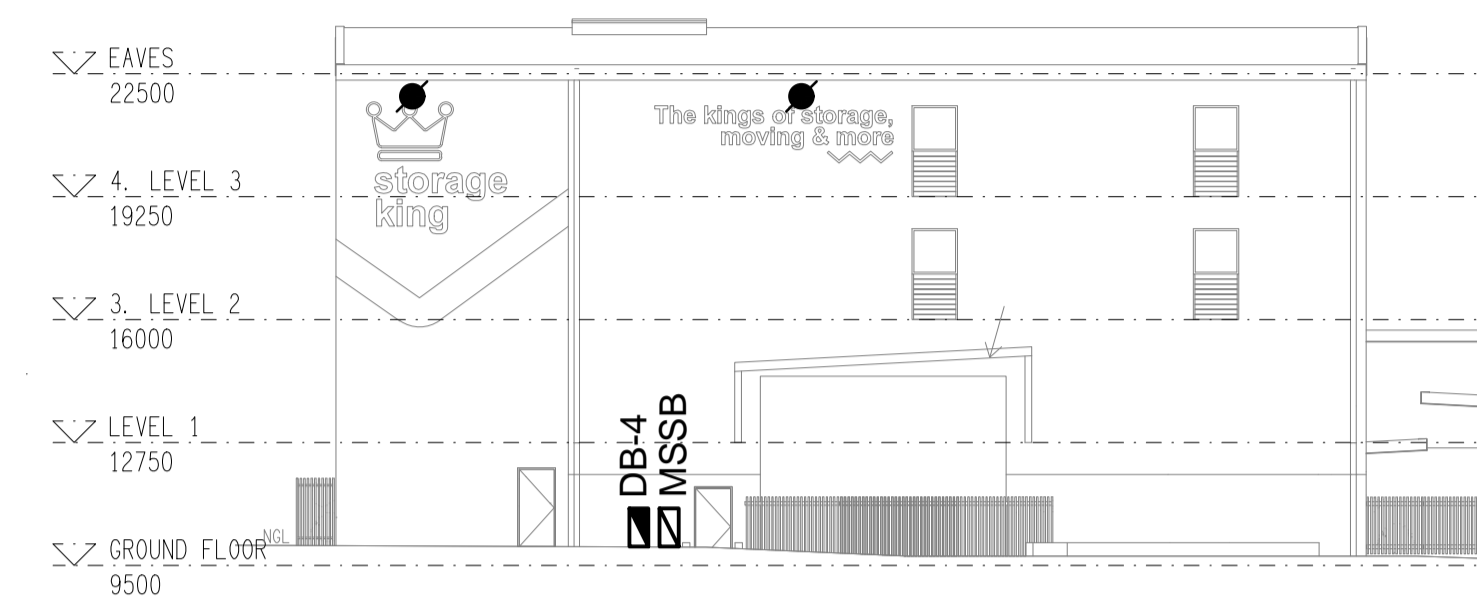

NORTH
EXTERNAL BUILDING ELEVATION
 SCALE 1: 200

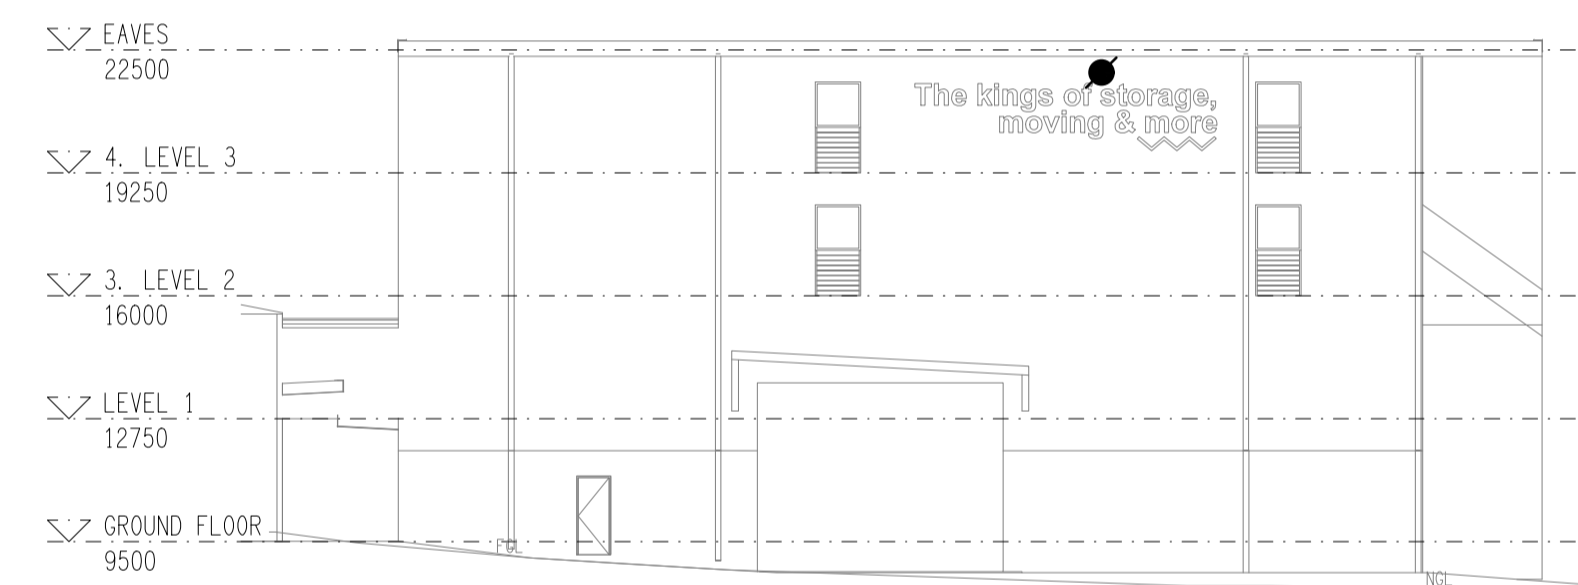

SOUTH
EXTERNAL BUILDING ELEVATION
 SCALE 1: 200

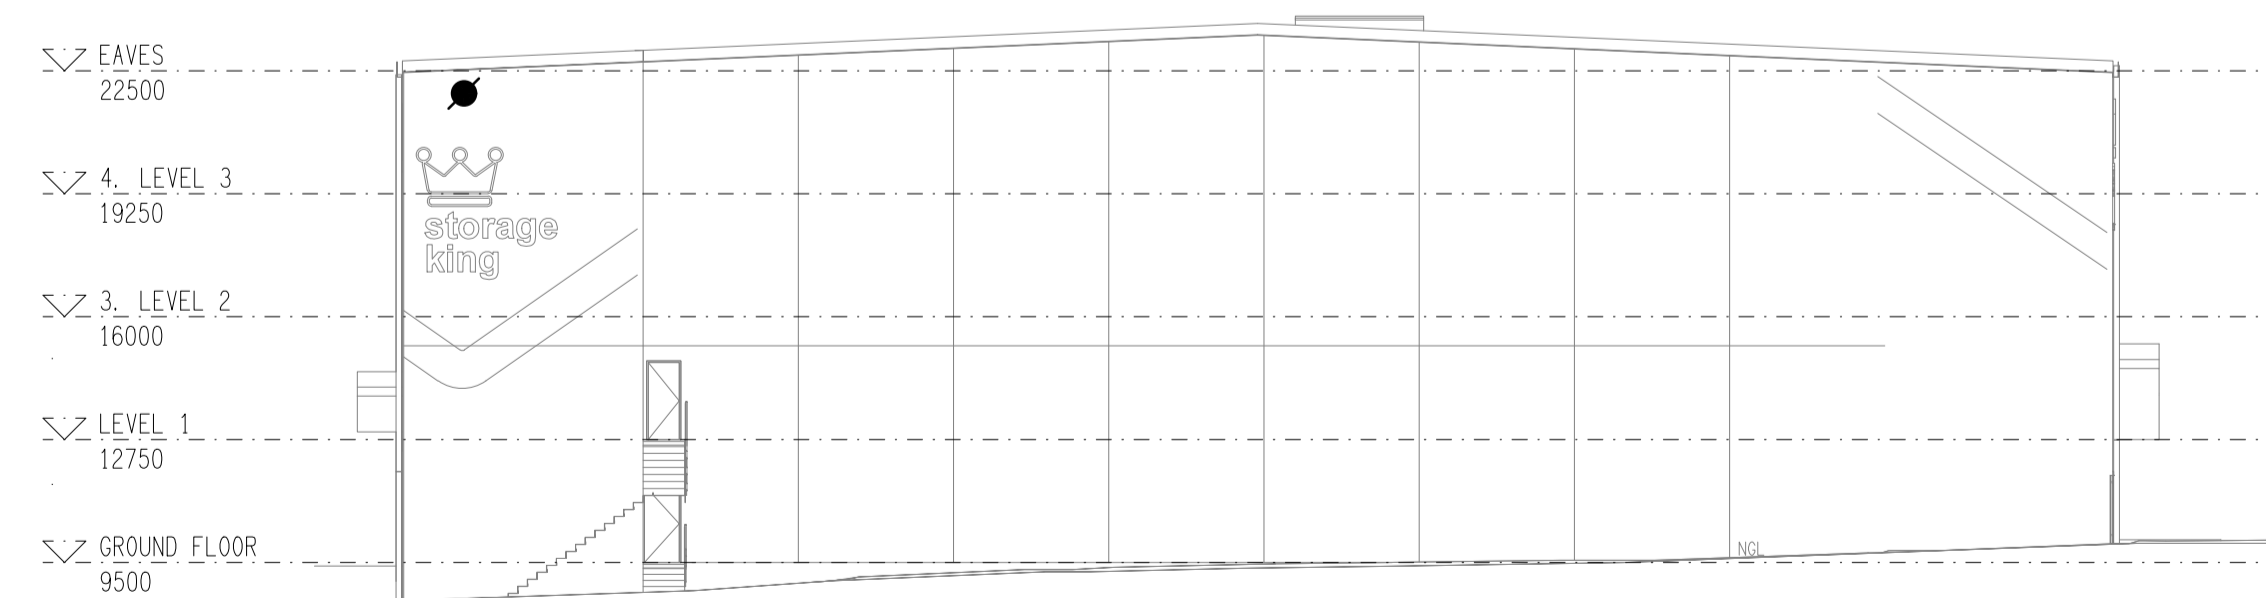

EAST
EXTERNAL BUILDING ELEVATION
 SCALE 1: 200

ELECTRICAL DESIGN GROUP BRISBANE
 PTY LTD
 ACN 092 710 793
 TRADING AS:
 ELECTRICAL DESIGN GROUP

THE COPYRIGHT OF THIS DRAWING
 REMAINS THE PROPERTY OF THE
 ELECTRICAL DESIGN GROUP.
 USE FIGURED DIMENSIONS
 IN PREFERENCE TO SCALE.
 ALL DIMENSIONS TO BE
 VERIFIED ONSITE.

ELECTRICAL DESIGN GROUP
 ELECTRICAL BUILDING SERVICES CONSULTANTS
 BRISBANE GOLD COAST

P.O. Box 15, Sherwood Q.4075
 Phone: (07) 3278 4375
 Email: brisbane@edg.net.au
 Web: www.edg.net.au

PROJECT:
STORAGE KING - MIAMI

15 PARADISE AVENUE, MIAMI, GOLD COAST

A	PRELIMINARY	24/11/2023
REV.	DESCRIPTION:	DATE:

DRAWING:
ELECTRICAL SERVICES
SITE PLAN

SCALE:
 1:200

AT A1

PROJECT NO:
C2806a

DRAWING NO:
E02

REVISION:
A