


NOTE
 ALL ELECTRICAL PENETRATIONS THROUGH THE ROOF SHEETING ARE TO BE IN LINE WITH THE STRUCTURAL OR MECHANICAL SERVICES PENETRATIONS TO AVOID DEDICATED FLASHINGS FOR THE ELECTRICAL SERVICES.

HOTEL ROOF PLAN
 PLANT DECK LAYOUT
 SCALE 1:200

ELECTRICAL LAYOUT STILL PENDING

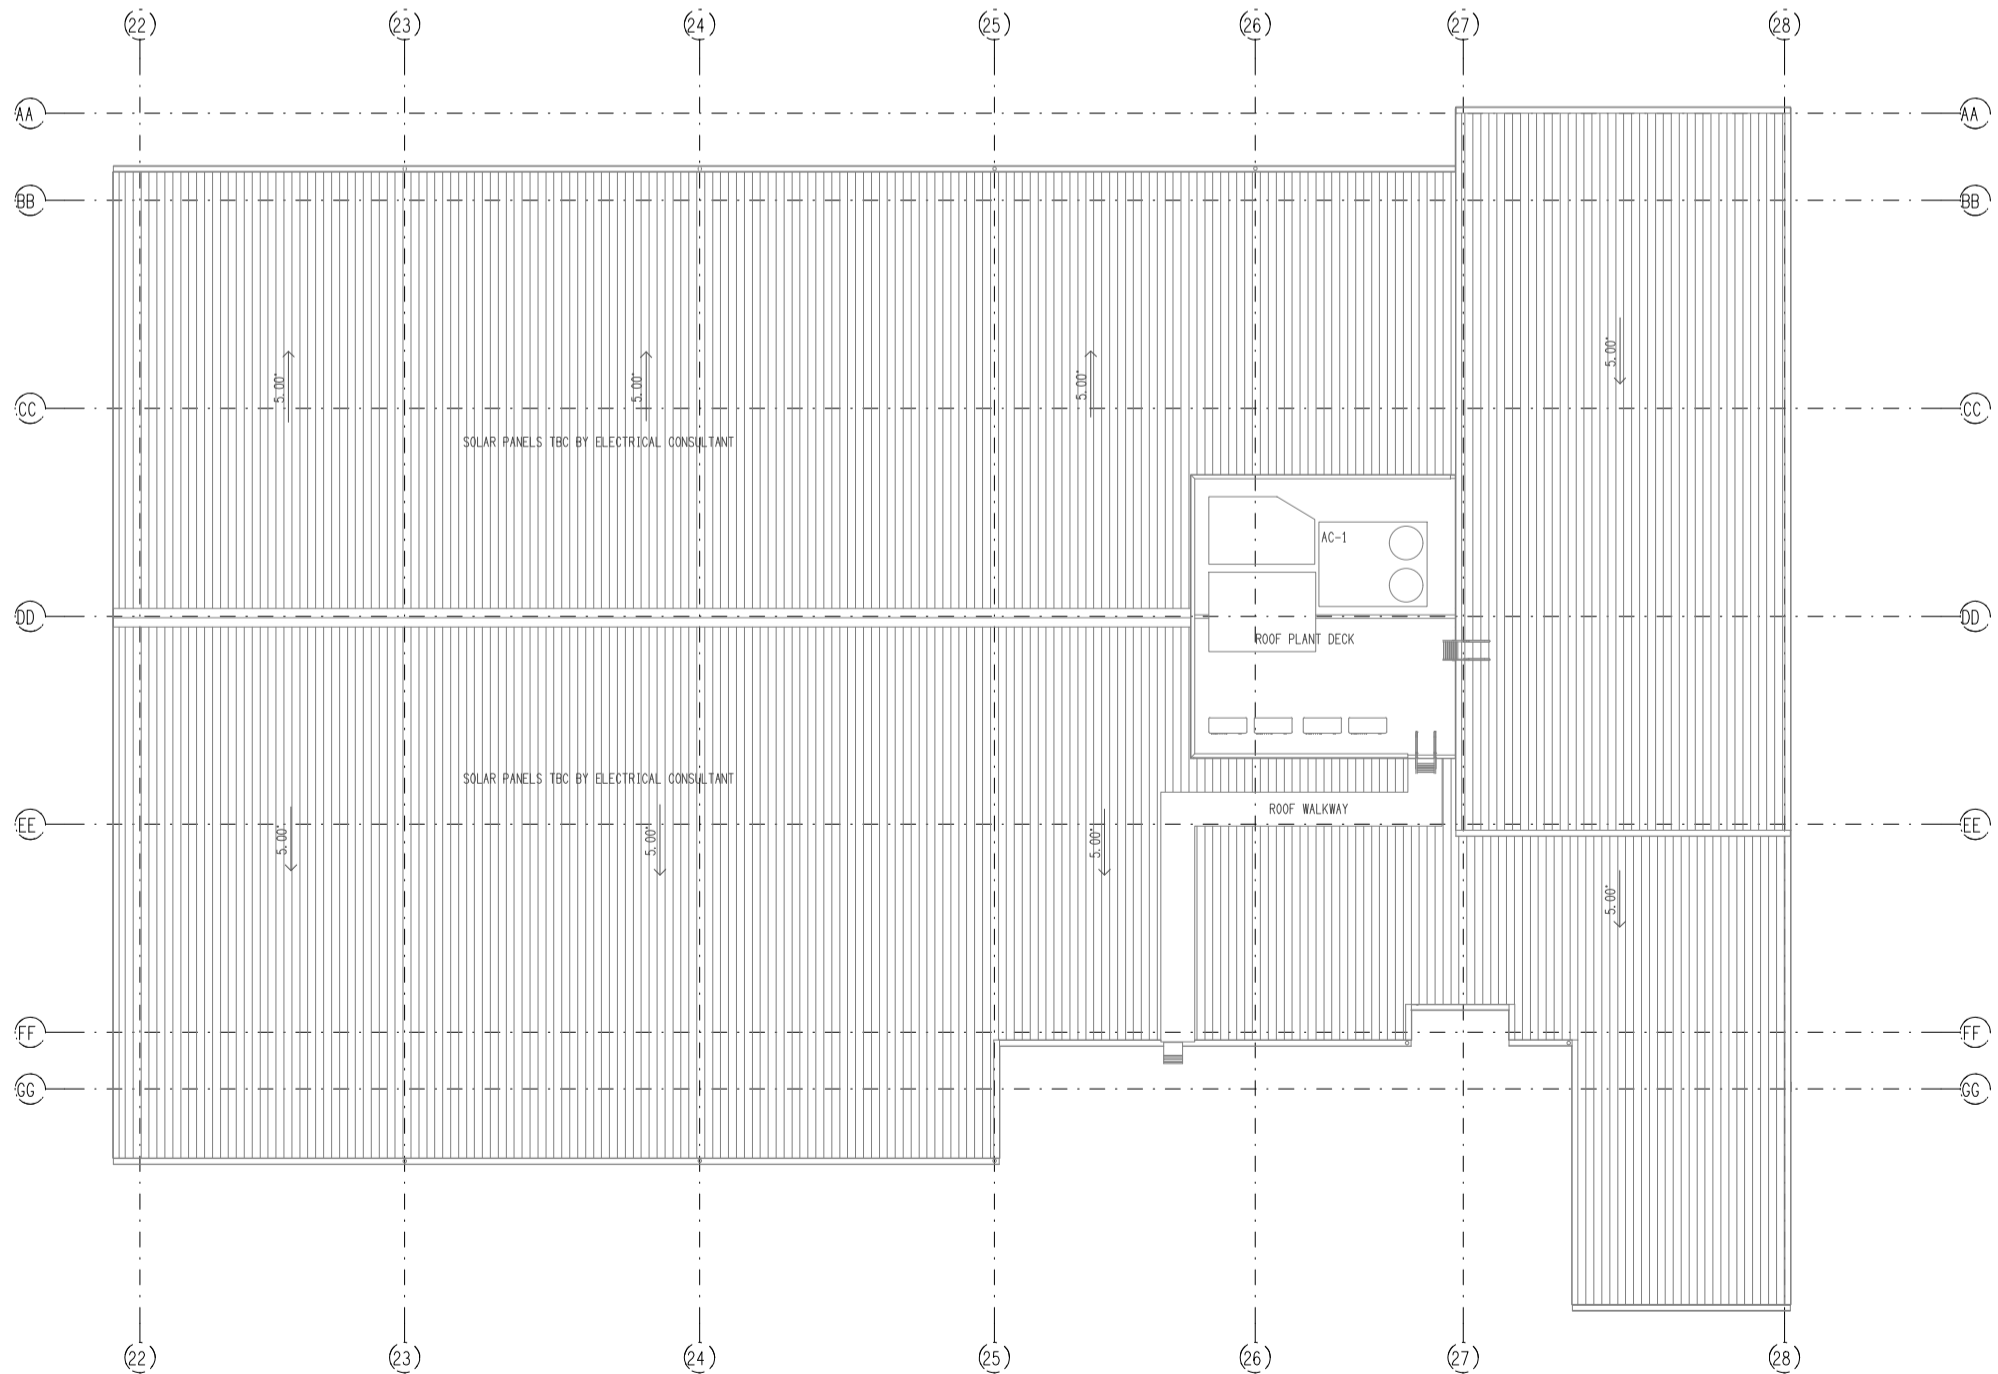

BOTTLE SHOP ROOF PLAN
 PLANT DECK LAYOUT
 SCALE 1:200

ELECTRICAL DESIGN GROUP BRISBANE
 PTY LTD
 ACN 092 710 793
 TRADING AS:
 ELECTRICAL DESIGN GROUP

THE COPYRIGHT OF THIS DRAWING
 REMAINS THE PROPERTY OF THE
 ELECTRICAL DESIGN GROUP.
 USE FIGURED DIMENSIONS
 IN PREFERENCE TO SCALE.
 ALL DIMENSIONS TO BE
 VERIFIED ONSITE.

ELECTRICAL DESIGN GROUP
 ELECTRICAL BUILDING SERVICES CONSULTANTS
 BRISBANE GOLD COAST
 P.O. Box 15, Sherwood Q.4075
 Phone: (07) 3278 4375
 Email: brisbane@edg.net.au
 Web: www.edg.net.au

PROJECT:
**DRY DOCK ROAD HOTEL,
 TWEED HEADS SOUTH**
 CORNER DOCK ROAD & FRASER DRIVE, NEW SOUTH WALES

A	PRELIMINARY	08/03/2024
REV:	DESCRIPTION:	DATE:
DRAWING: ELECTRICAL SERVICES ROOF PLANS		
SCALE: 1:200	AT A1	PROJECT NO: C2864a
		DRAWING NO: E10
		REVISION: A