


DETAIL A
TAB WALL ELEVATION 1
SCALE 1:25

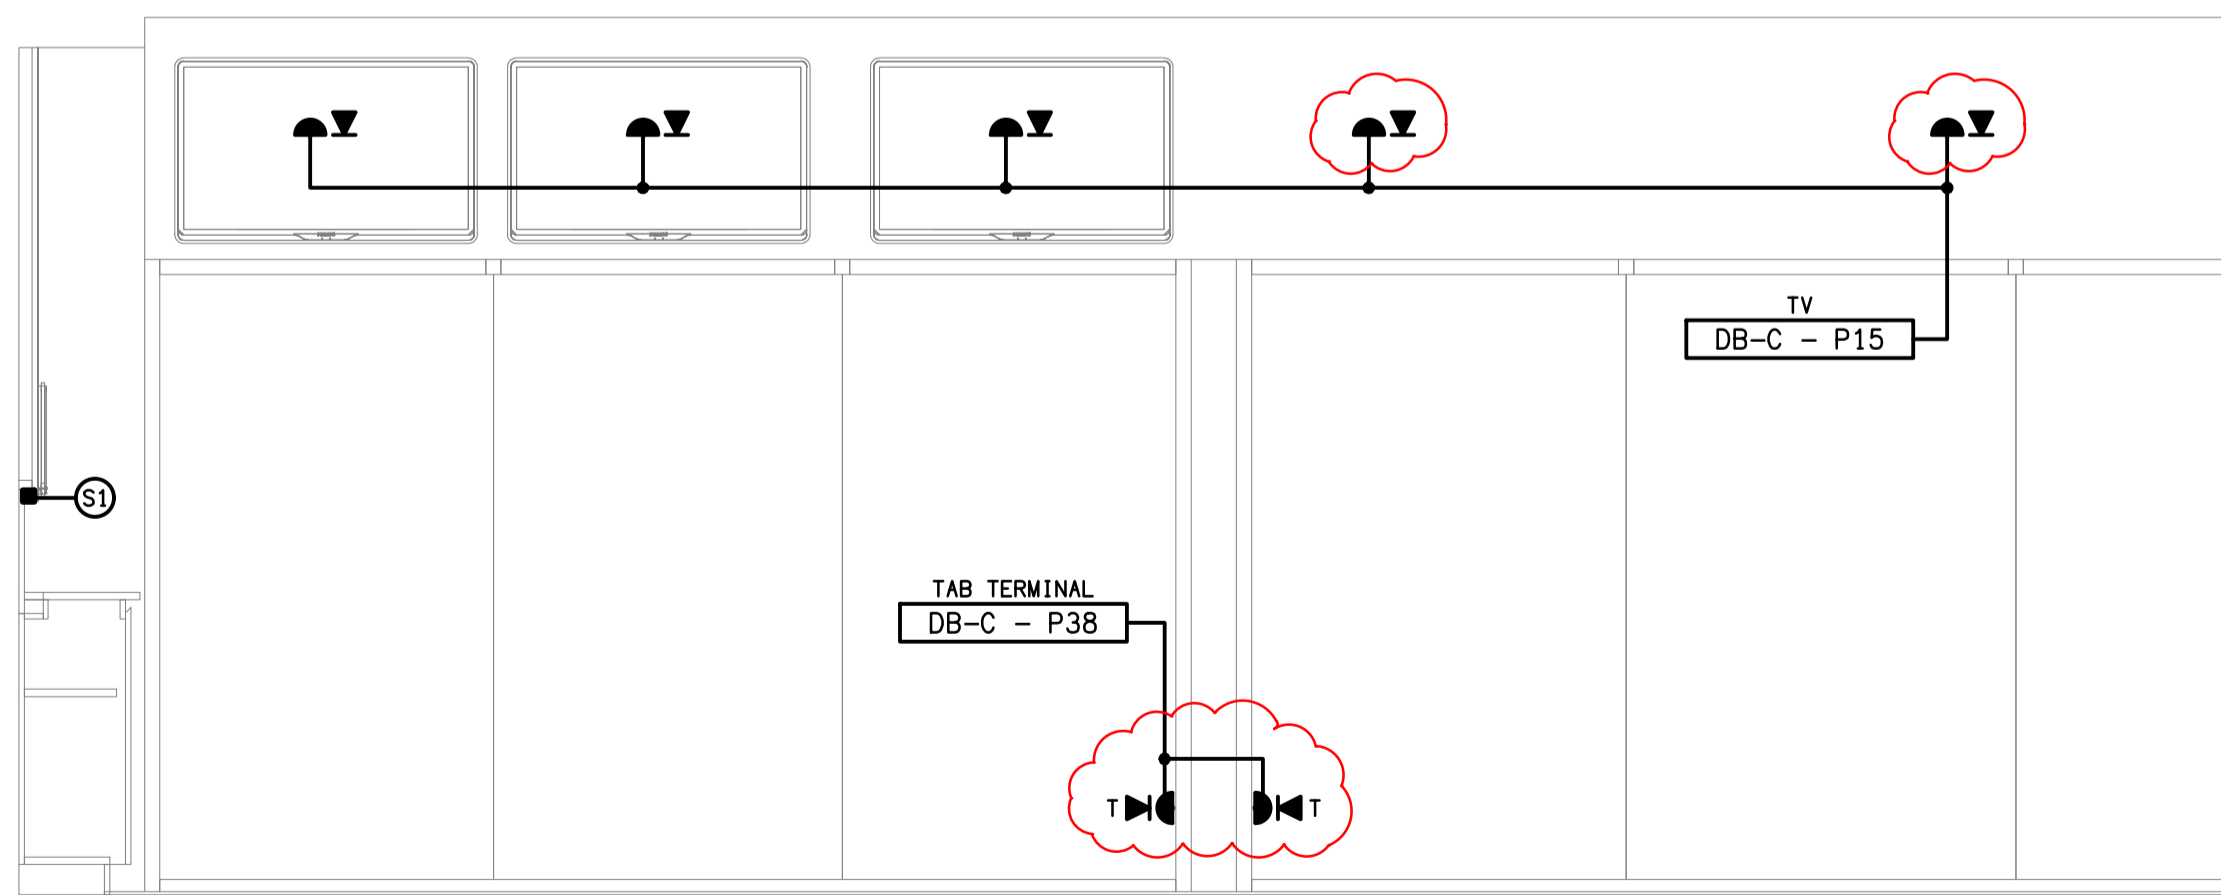

DETAIL B
TAB WALL ELEVATION 2
SCALE 1:25

ELECTRICAL DESIGN GROUP BRISBANE PTY LTD
ACN 092 710 793

THE COPYRIGHT OF THIS DRAWING REMAINS THE PROPERTY OF THE ELECTRICAL DESIGN GROUP.

USE FIGURED DIMENSIONS IN PREFERENCE TO SCALE.

ALL DIMENSIONS TO BE VERIFIED ONSITE.

ELECTRICAL DESIGN GROUP
ELECTRICAL BUILDING SERVICES CONSULTANTS
BRISBANE GOLD COAST

P.O. Box 15, Sherwood Q.4075
Phone: (07) 3278 4375
Email: brisbane@edg.net.au
Web: www.edg.net.au

PROJECT:
VICTORIA POINT SHARKS SPORTING CLUB

325 COLBURN AVENUE, VICTORIA POINT, QUEENSLAND

D	CONSTRUCTION	18/10/2023
REV:	DESCRIPTION:	DATE:

DRAWING:
ELECTRICAL SERVICES FLOOR PLAN

SCALE:
1:100

AT A1

PROJECT NO:
C2931a

DRAWING NO:
E02

REVISION:
D