




DETAIL C
MALE MIRROR ELEVATION
SCALE 1:25

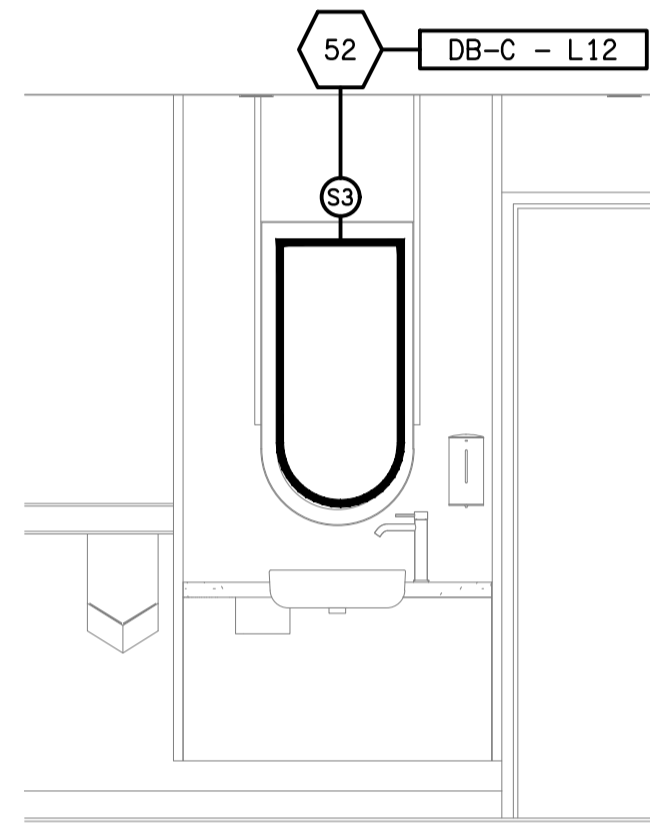


DETAIL D
FEMALE MIRROR ELEVATION
SCALE 1:25

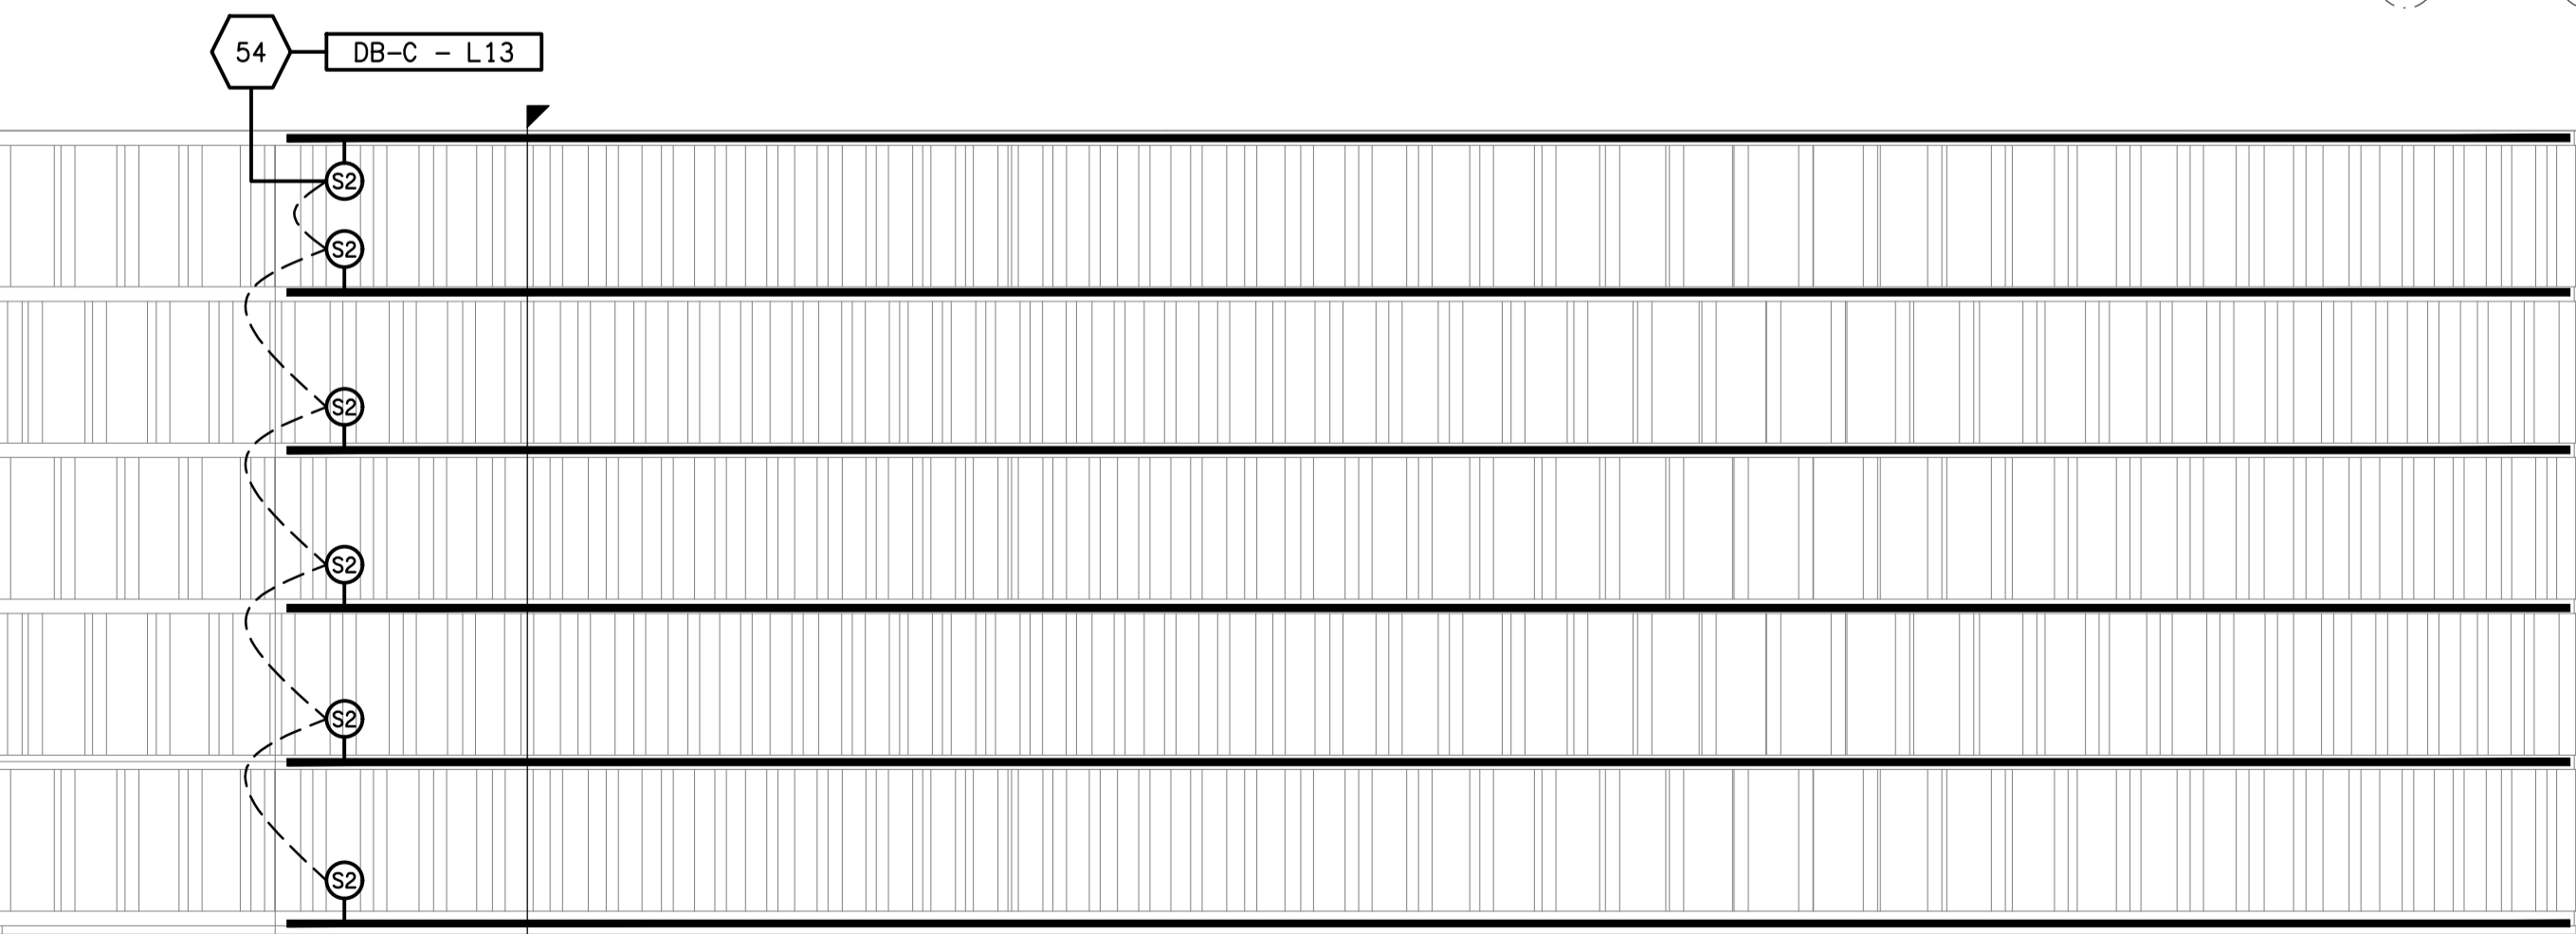

DETAIL A
RECEPTION FEATURE WALL ELEVATION
SCALE 1:25

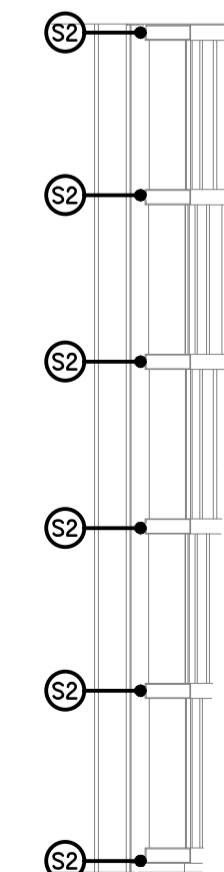

DETAIL B
RECEPTION FEATURE WALL SECTION
SCALE 1:25

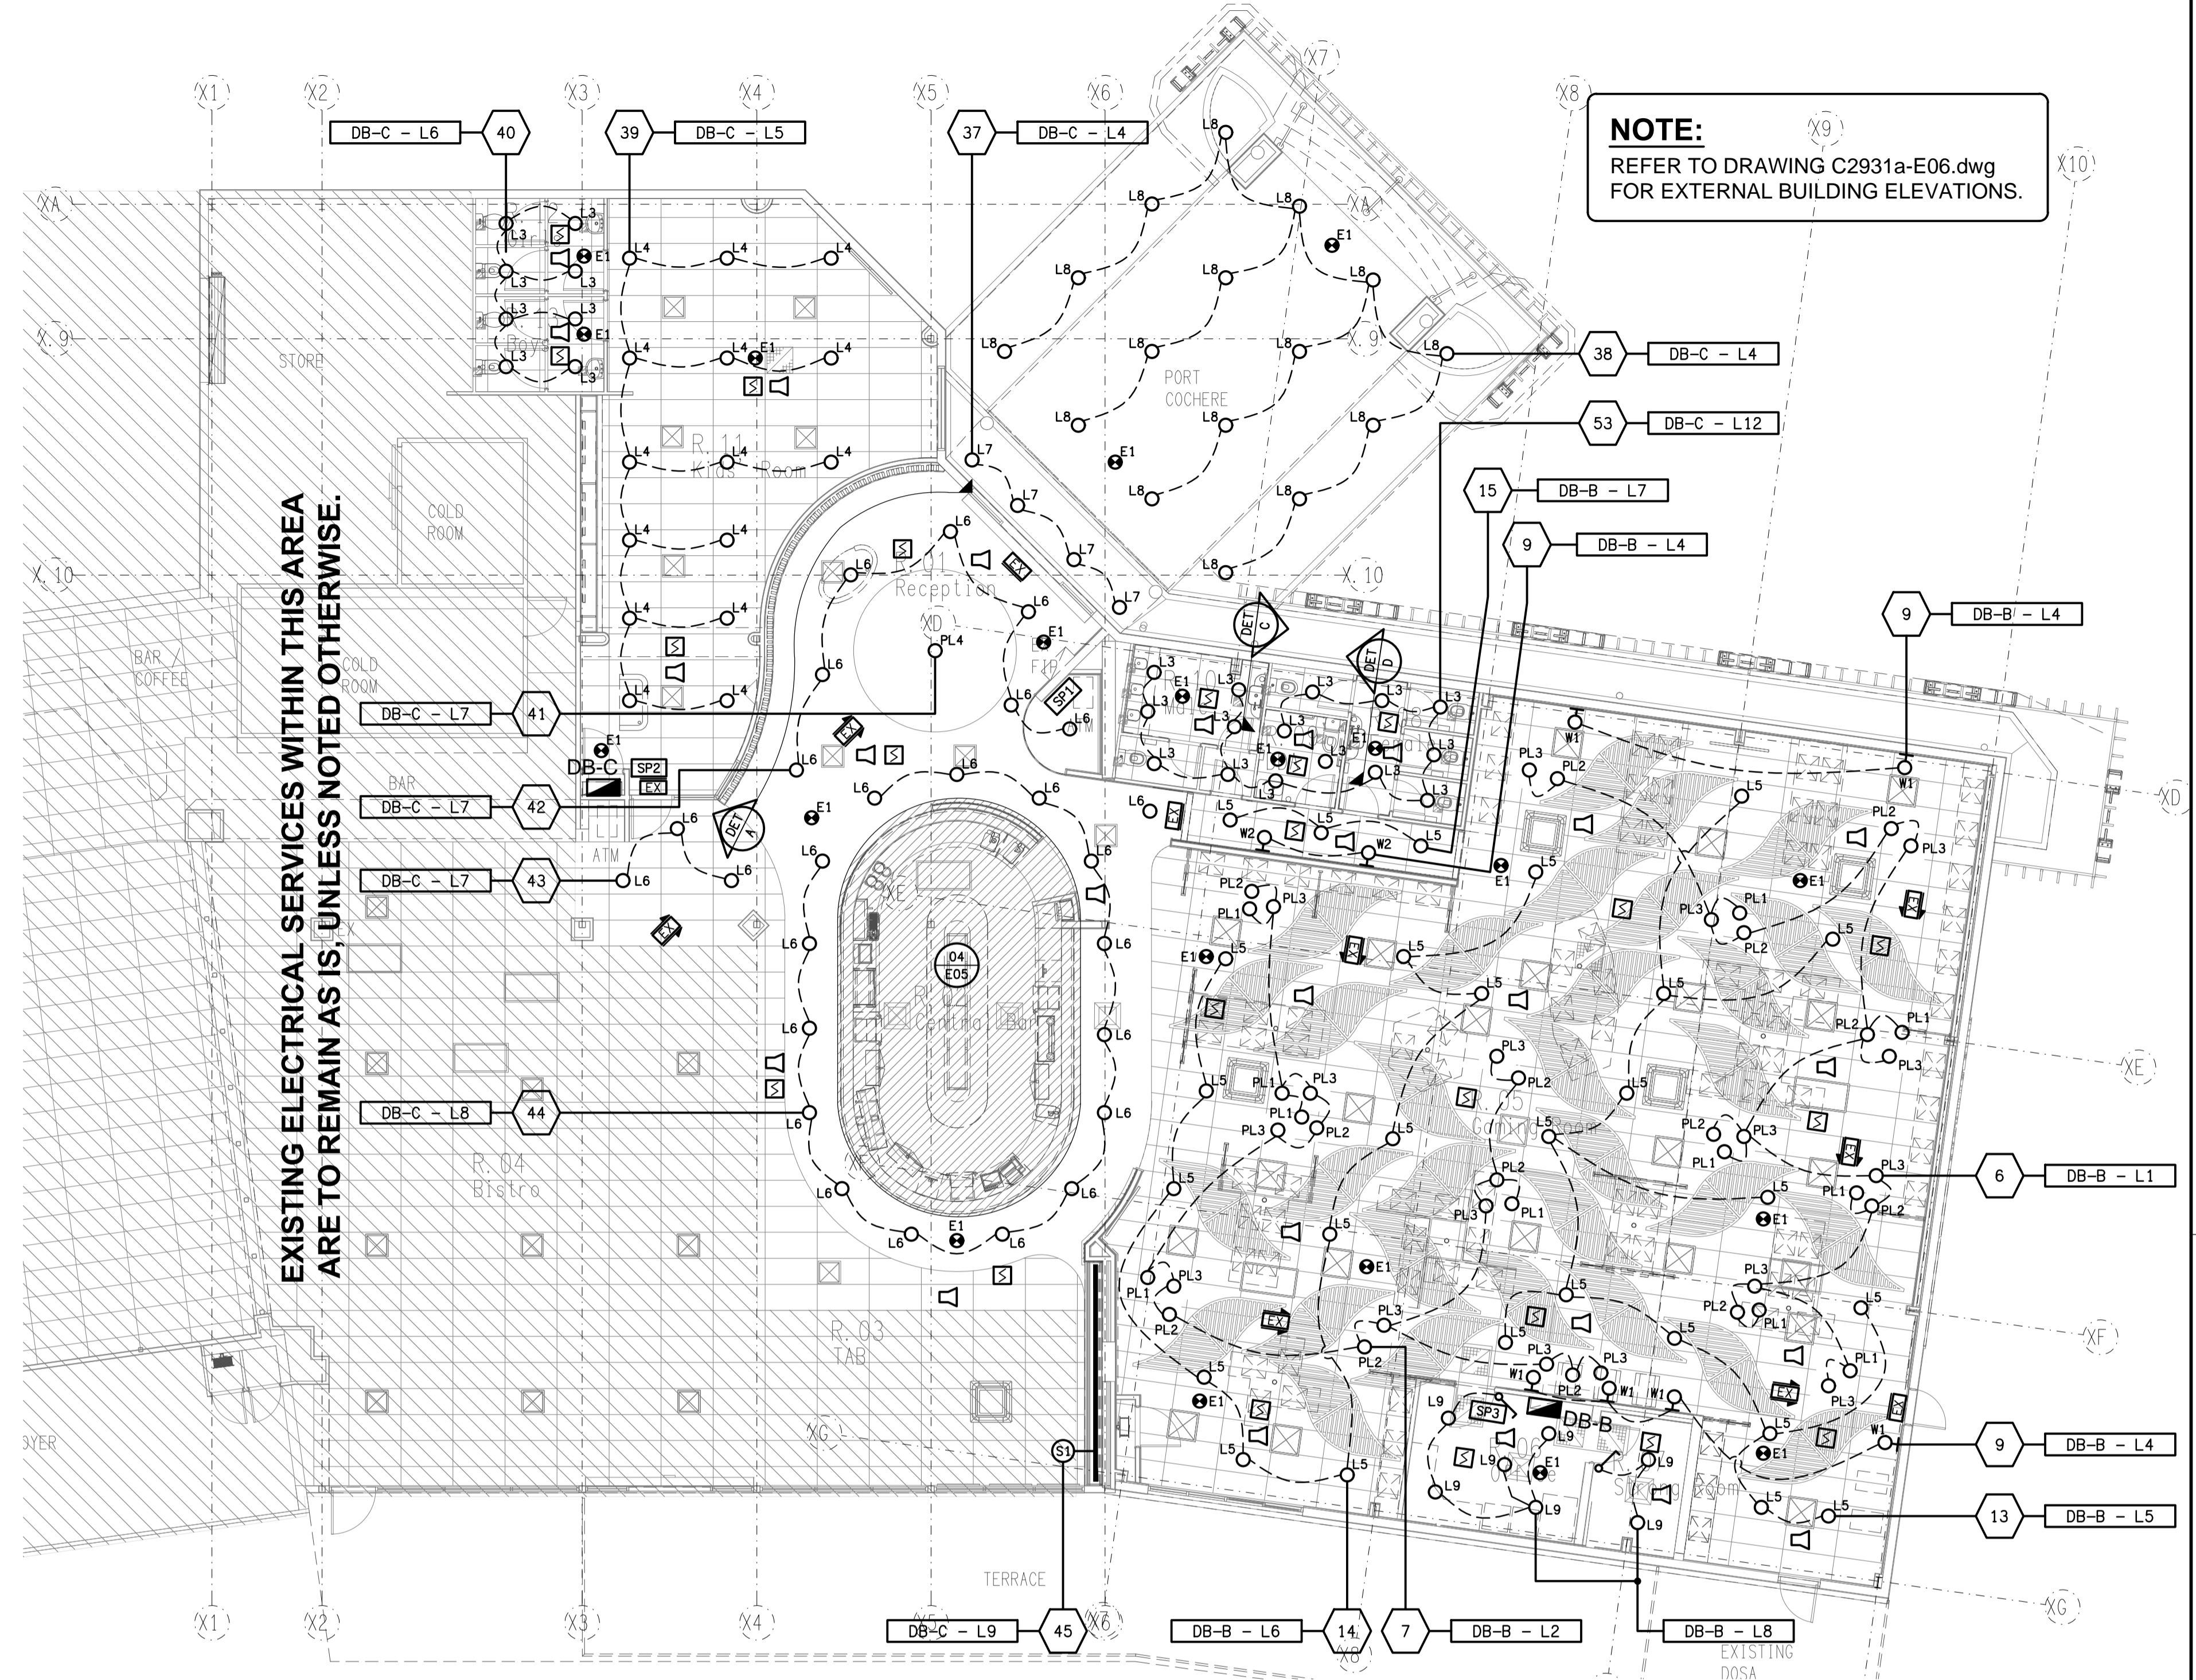

ELECTRICAL DESIGN GROUP BRISBANE
PTY LTD
ACN 092 710 793
TRADING AS:
ELECTRICAL DESIGN GROUP

THE COPYRIGHT OF THIS DRAWING
REMAINS THE PROPERTY OF THE
ELECTRICAL DESIGN GROUP.

USE FIGURED DIMENSIONS
IN PREFERENCE TO SCALE.

ALL DIMENSIONS TO BE
VERIFIED ONSITE.

ELECTRICAL DESIGN GROUP
ELECTRICAL BUILDING SERVICES CONSULTANTS
BRISBANE GOLD COAST

P.O. Box 15, Sherwood Q.4075
Phone: (07) 3278 4375
Email: brisbane@edg.net.au
Web: www.edg.net.au

PROJECT:
VICTORIA POINT SHARKS SPORTING CLUB
325 COLBURN AVENUE, VICTORIA POINT, QUEENSLAND

B	CONSTRUCTION	11/09/2023
REV.	DESCRIPTION:	DATE:

DRAWING:
**ELECTRICAL SERVICES
REFLECTED CEILING PLAN**

SCALE:
1:100

AT A1

PROJECT NO:
C2931a

DRAWING NO:
E04

REVISION:
B