




LEVEL 1
DEMOLITION FLOOR / CEILING PLAN
SCALE 1: 200

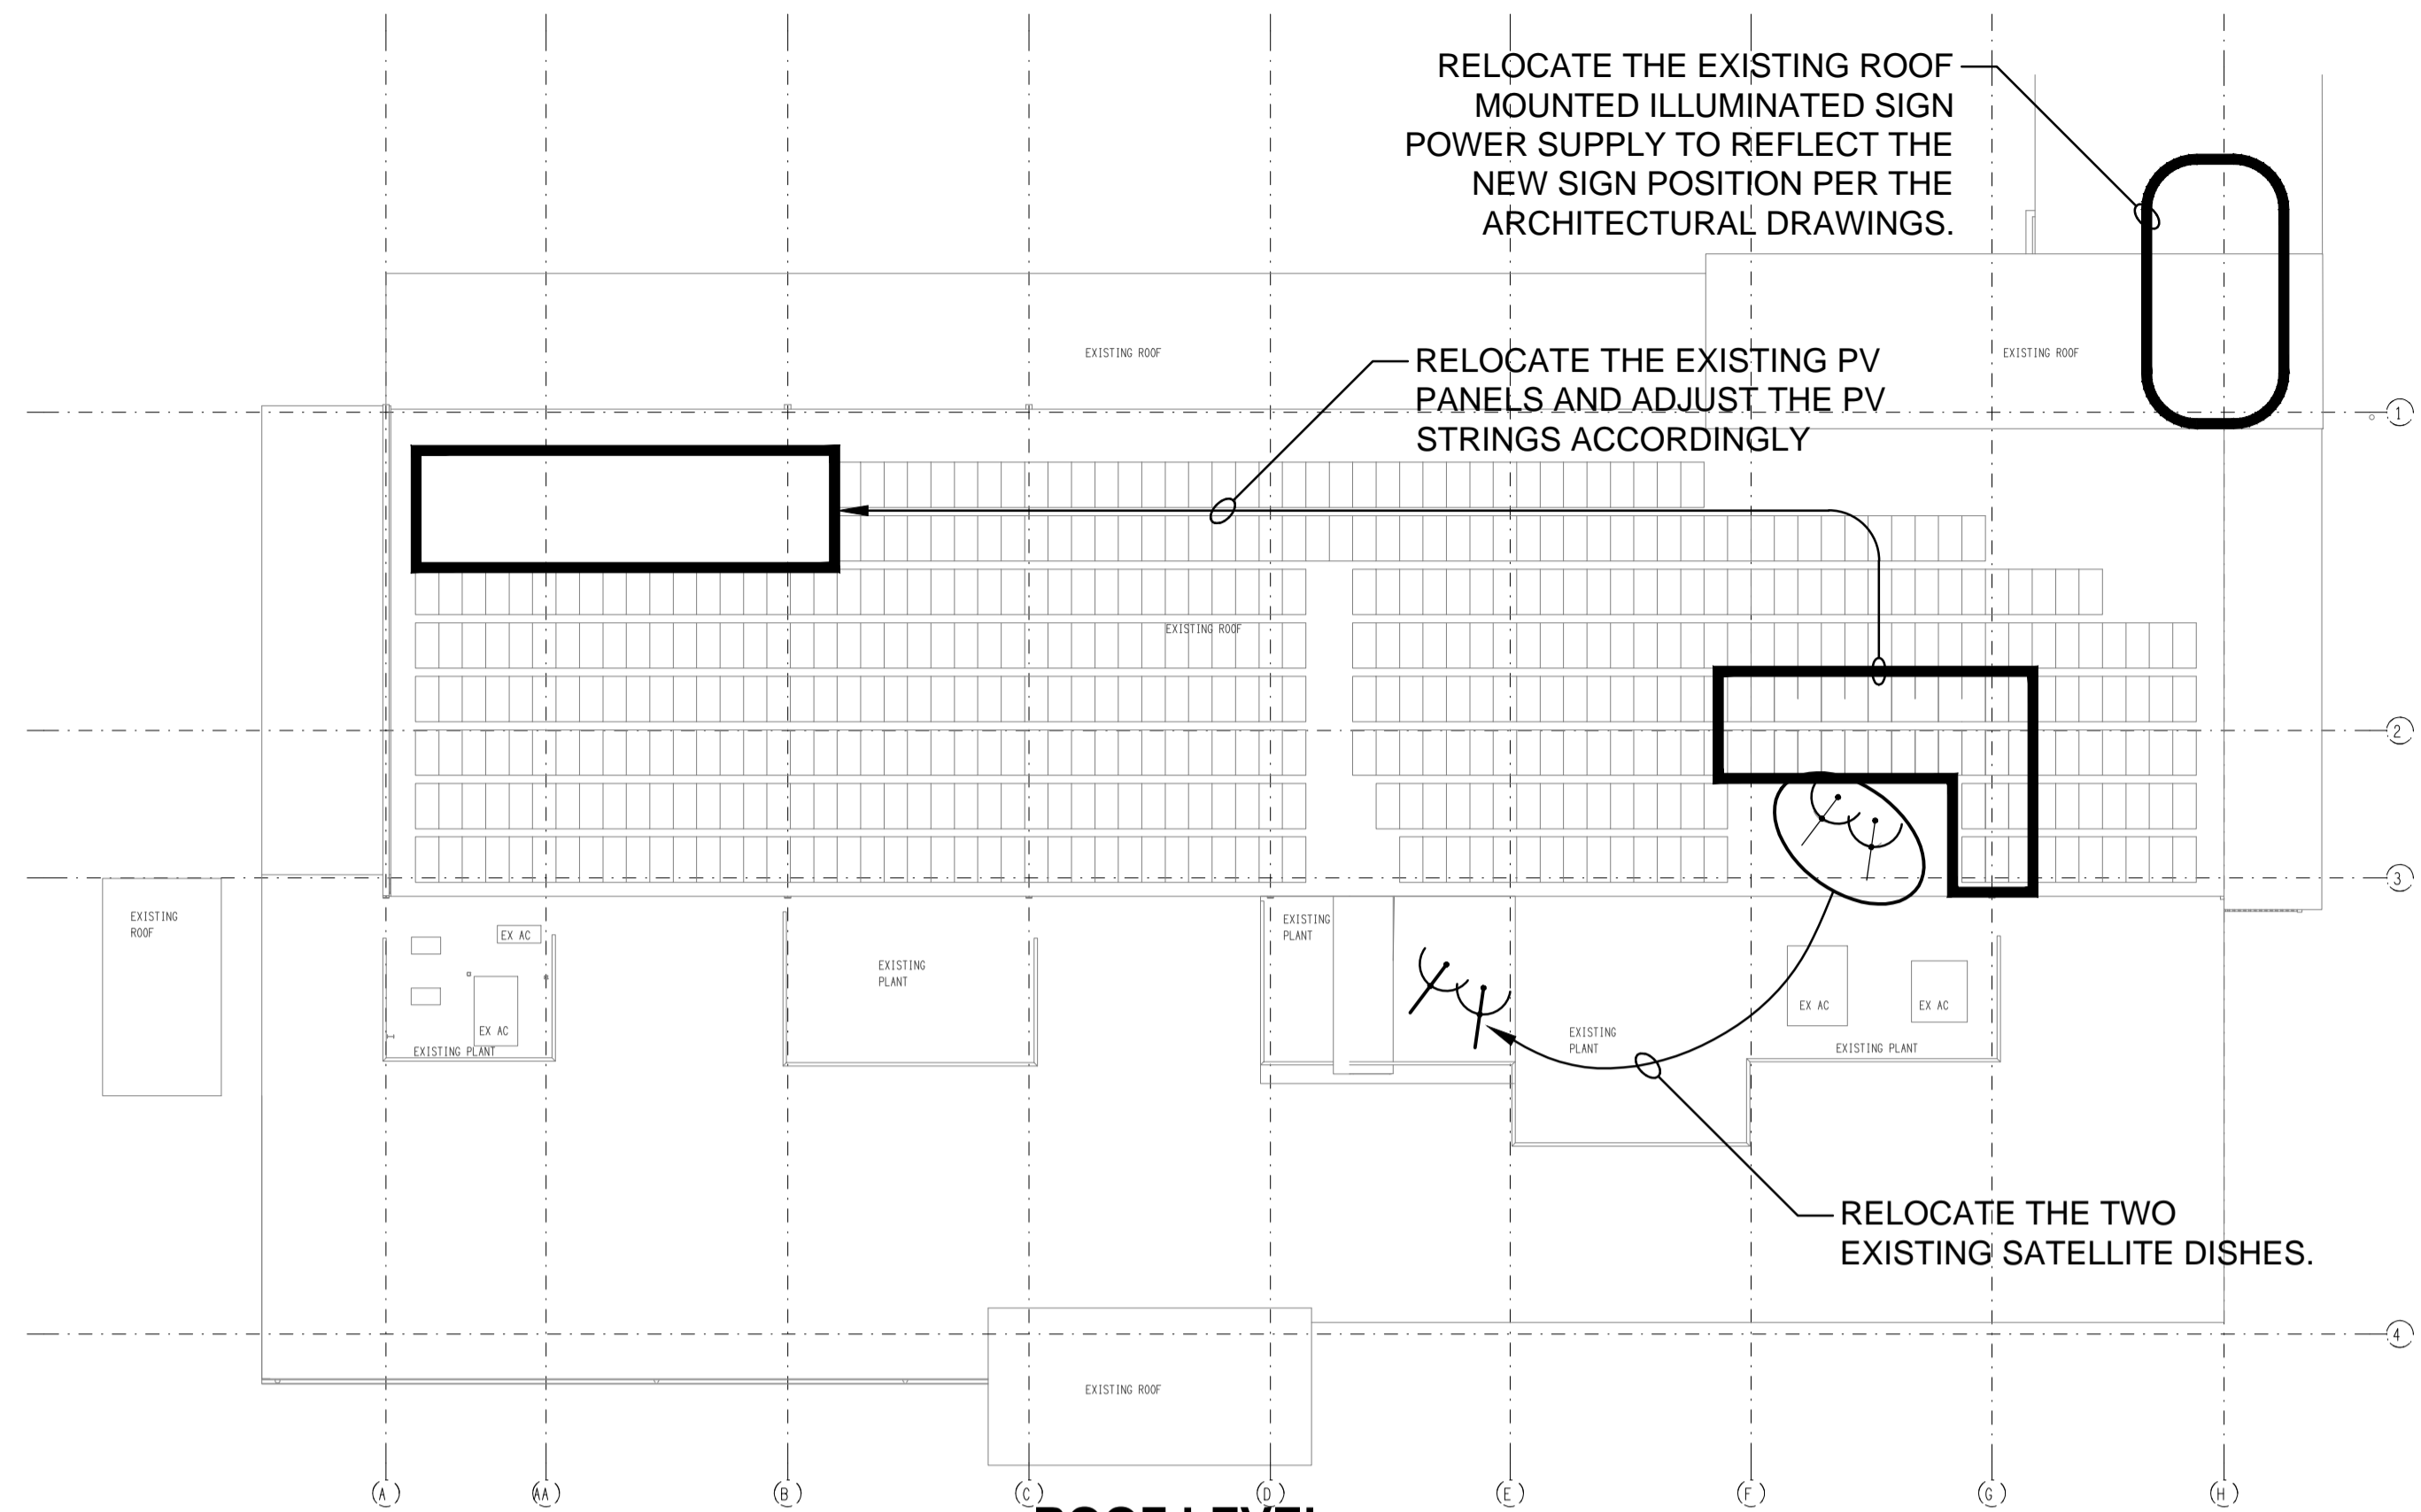

ROOF LEVEL
RELOCATION PLAN
SCALE 1: 200

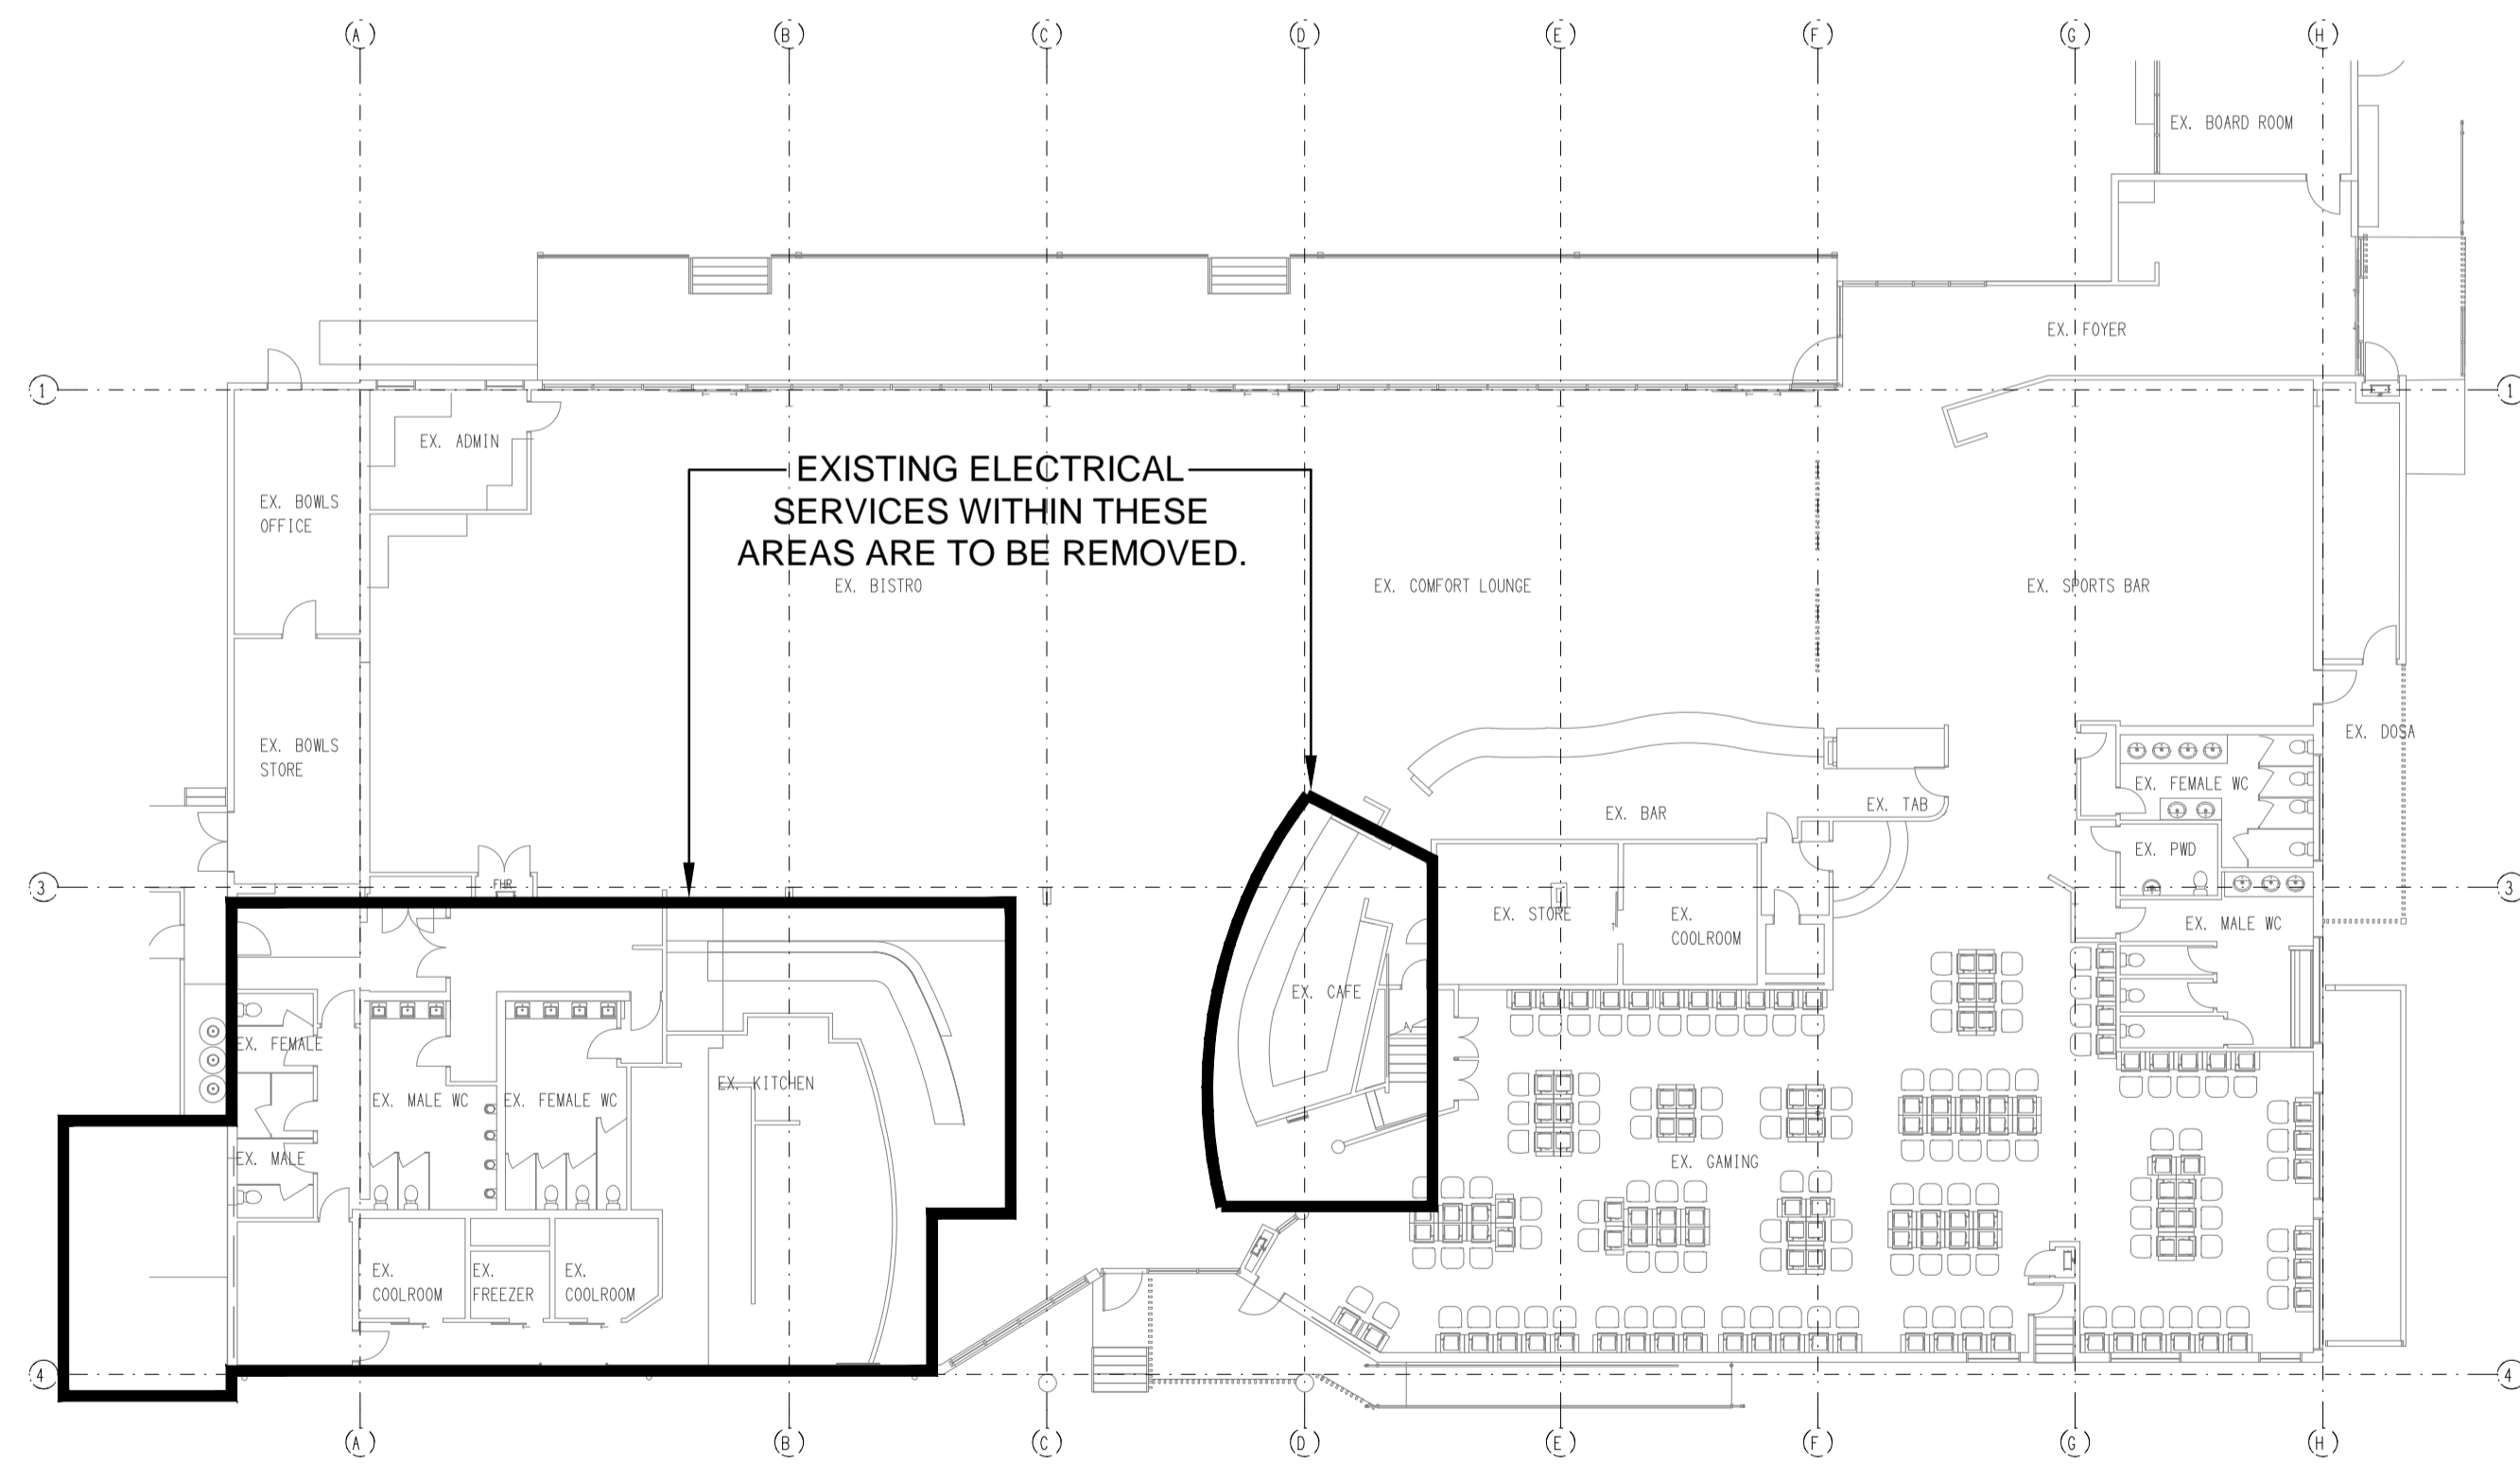

GROUND LEVEL
DEMOLITION FLOOR PLAN
SCALE 1: 200

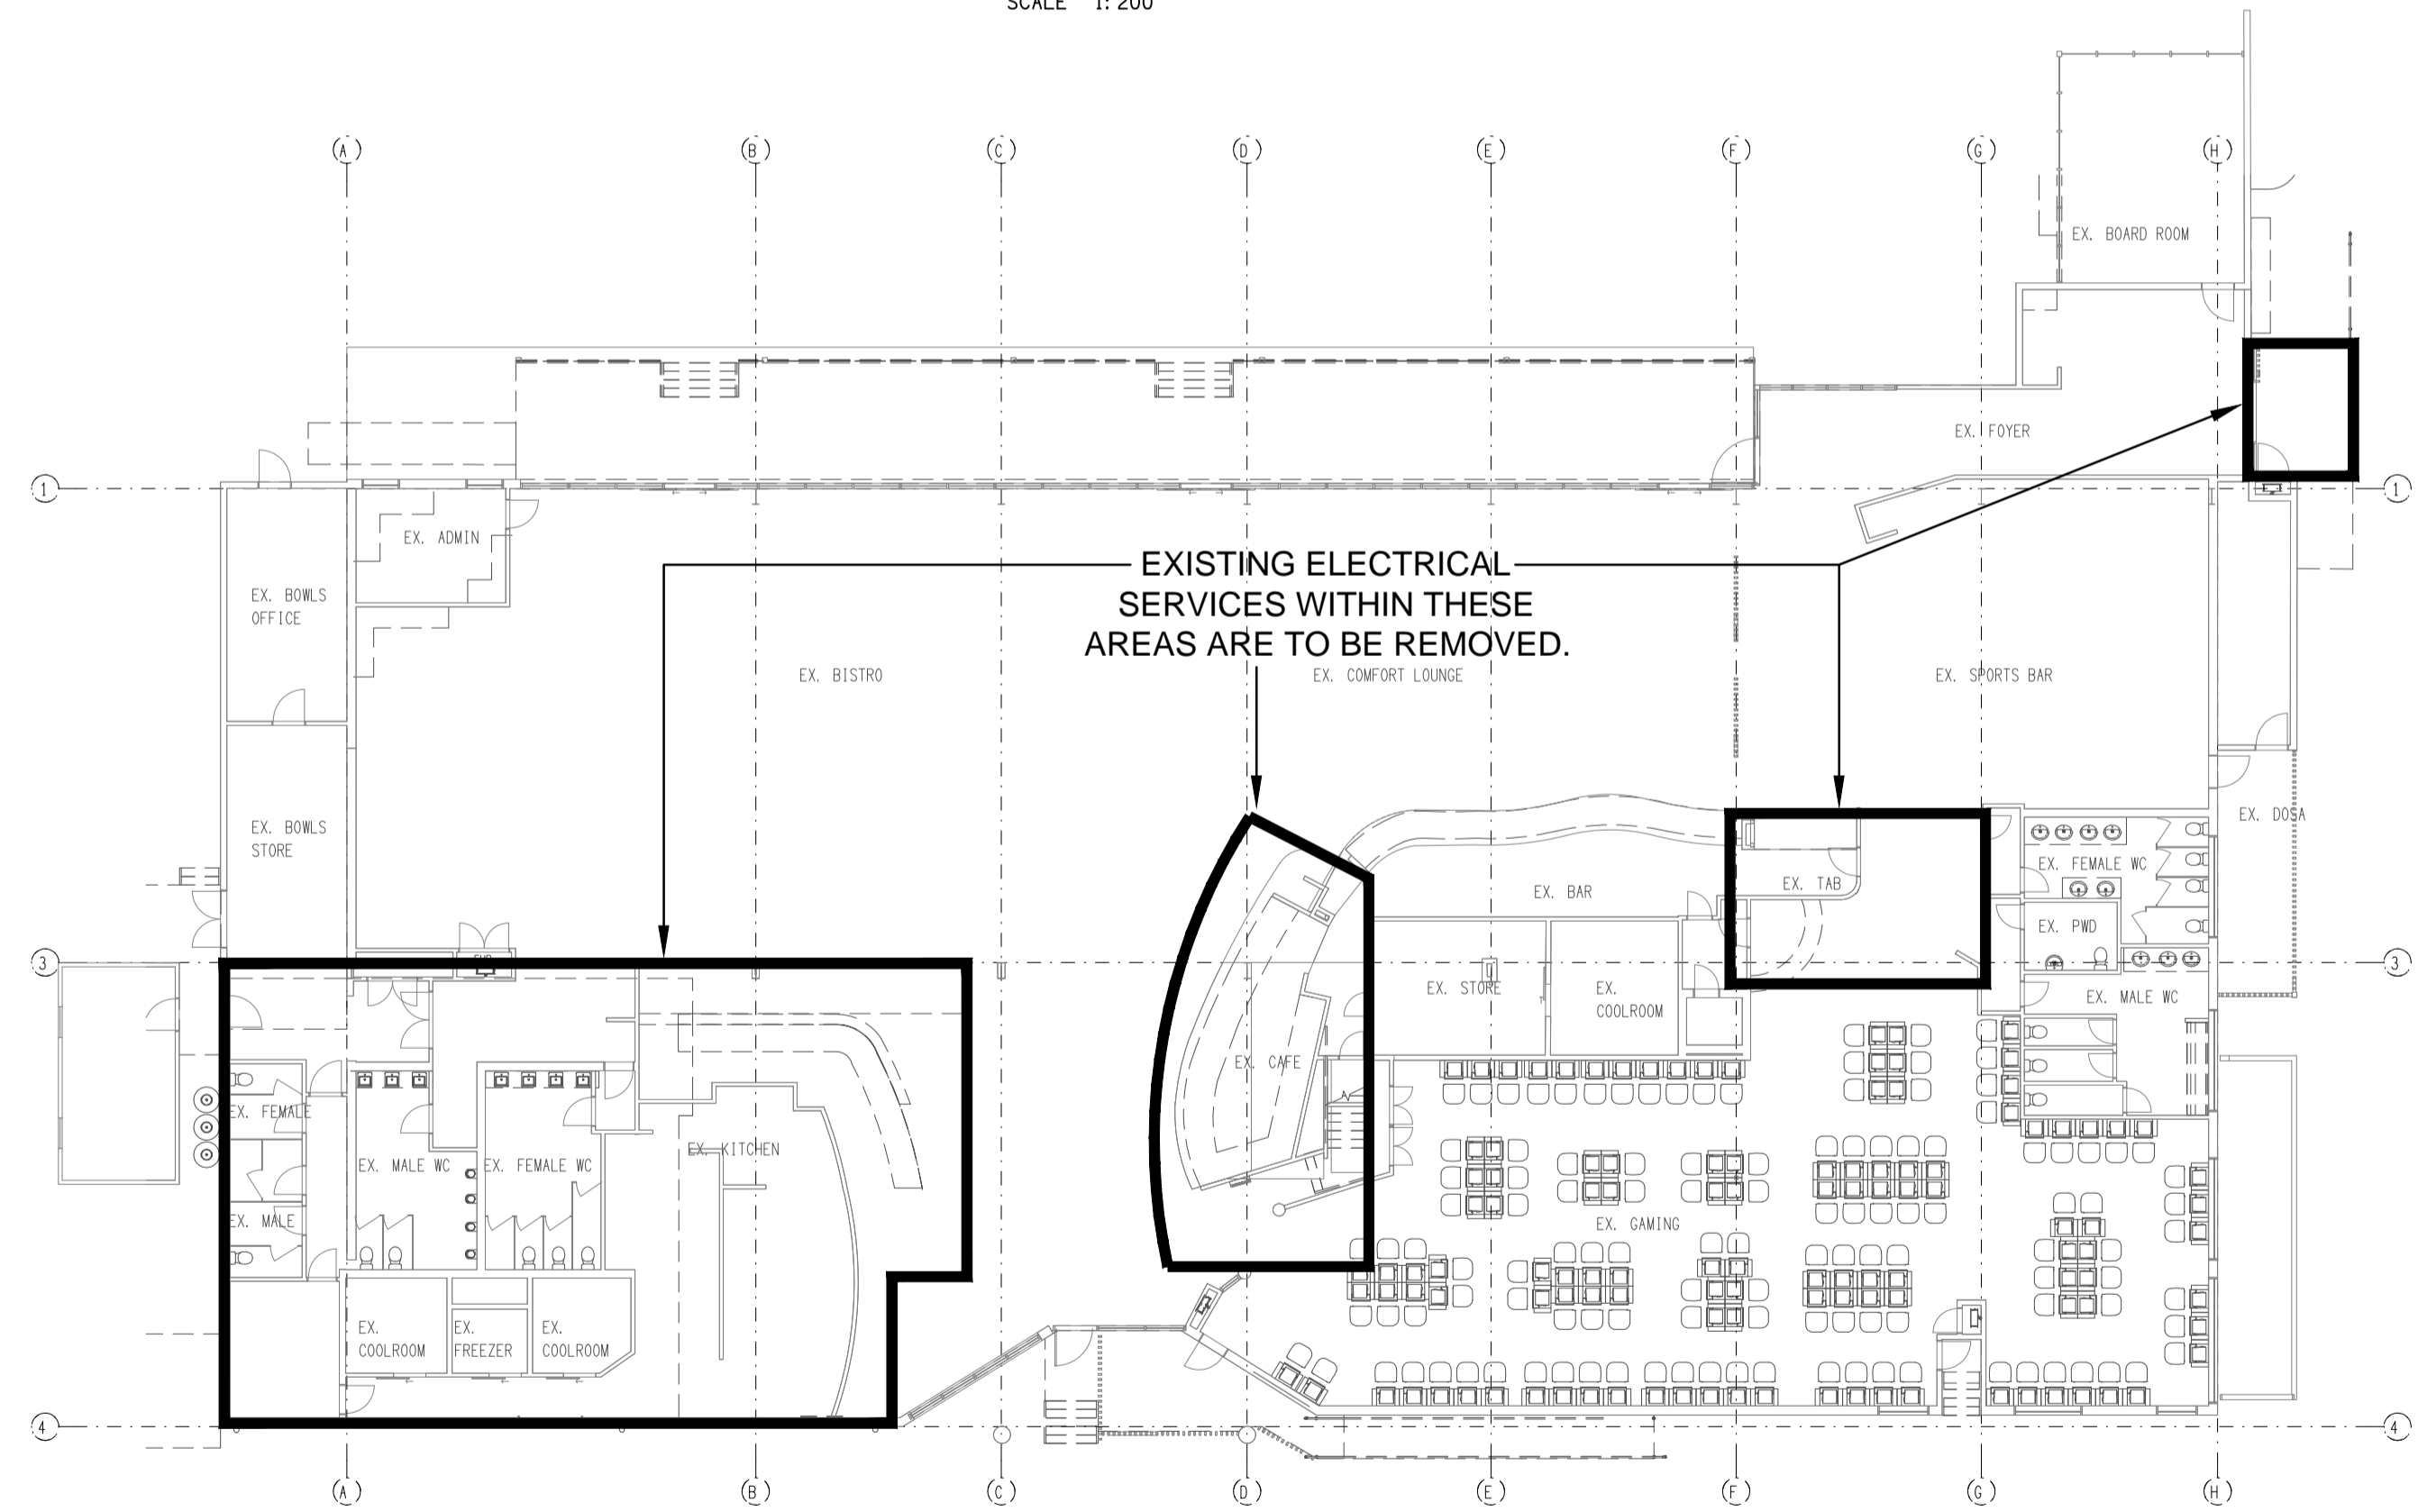

GROUND LEVEL
DEMOLITION REFLECTED CEILING PLAN
SCALE 1: 200

ELECTRICAL DESIGN GROUP BRISBANE
PTY LTD
ACN 092 710 793
TRADING AS:
ELECTRICAL DESIGN GROUP

THE COPYRIGHT OF THIS DRAWING
REMAINS THE PROPERTY OF THE
ELECTRICAL DESIGN GROUP.

USE FIGURED DIMENSIONS
IN PREFERENCE TO SCALE.

ALL DIMENSIONS TO BE
VERIFIED ONSITE.

ELECTRICAL DESIGN GROUP
ELECTRICAL BUILDING SERVICES CONSULTANTS
BRISBANE GOLD COAST

P.O. Box 15, Sherwood Q.4075
Phone: (07) 3278 4375
Email: brisbane@edg.net.au
Web: www.edg.net.au

PROJECT:
CLUB KAWANA - STAGE 1

476 NICKLIN WAY, WURTULLA

B	TENDER	30/04/2024
REV:	DESCRIPTION:	DATE:

DRAWING:
**ELECTRICAL SERVICES
DEMOLITION PLANS**

SCALE:
1:200

AT A1

PROJECT NO:
C2957a

DRAWING NO:
E03

REVISION:
B