


**GROUND LEVEL**  
REFLECTED CEILING PLAN  
SCALE 1: 200

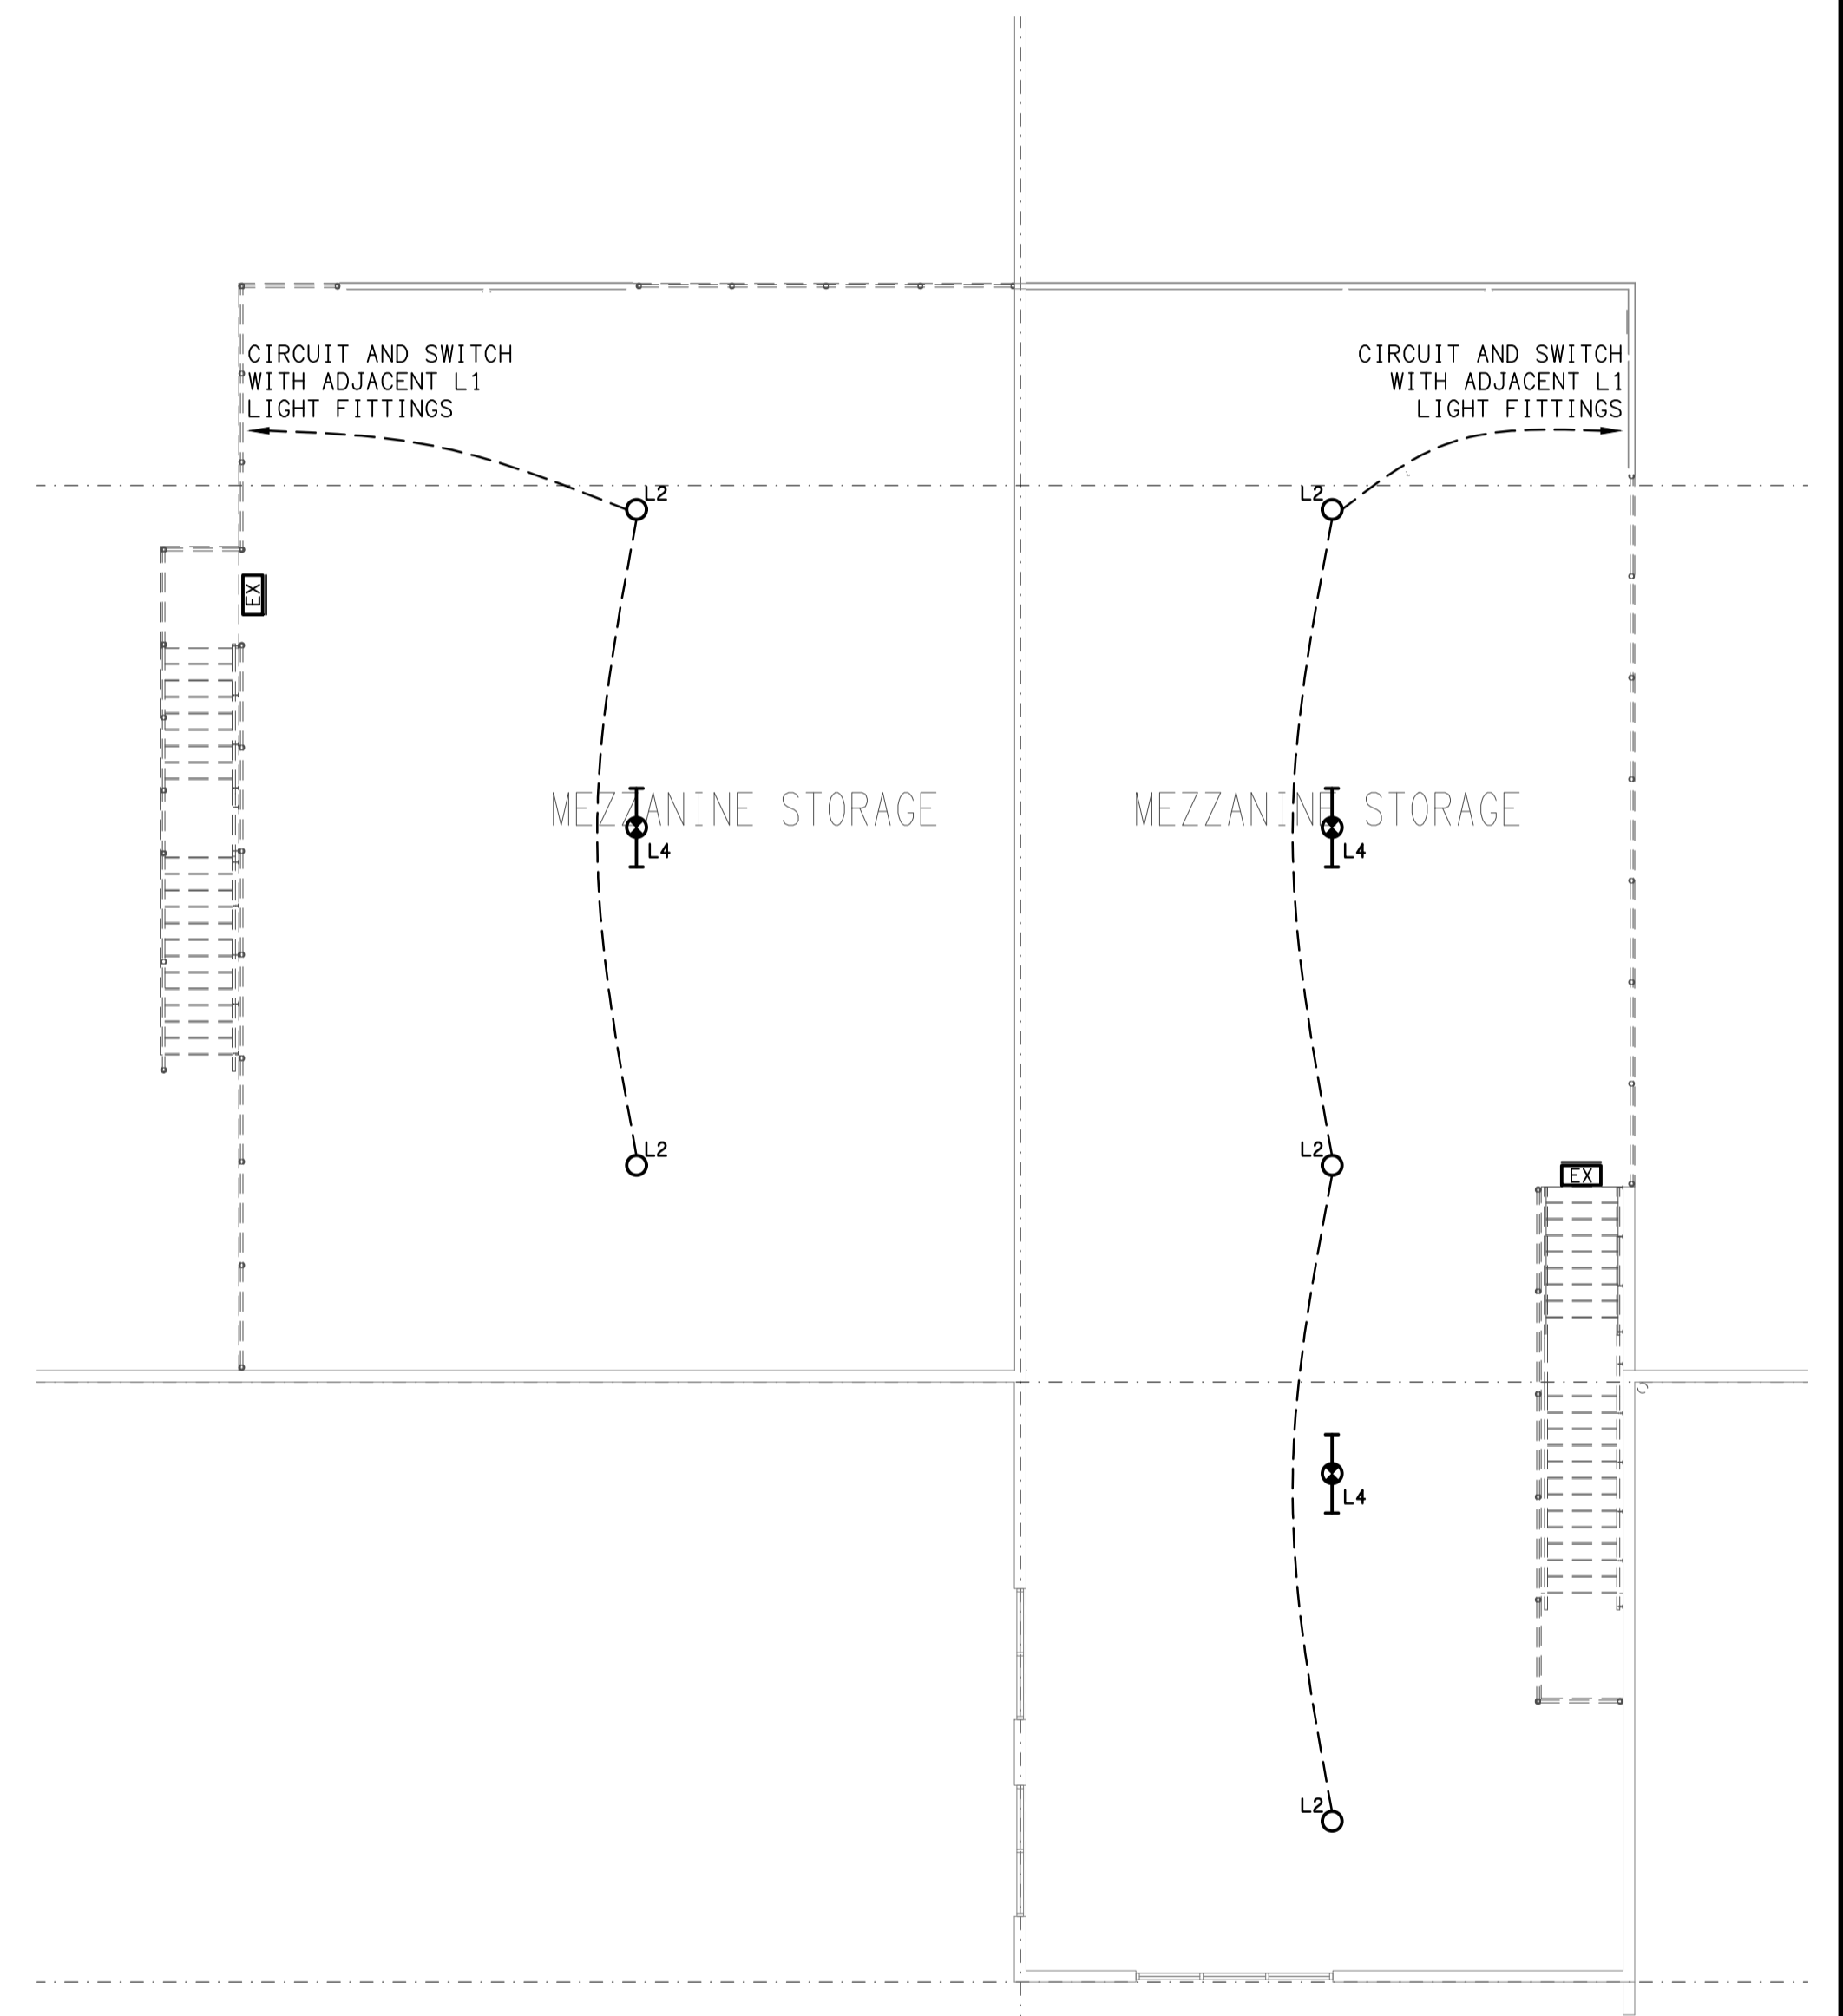

**LEVEL 1**  
REFLECTED CEILING PLAN  
SCALE 1: 100

ELECTRICAL DESIGN GROUP BRISBANE  
PTY LTD  
ACN 092 710 793  
TRADING AS:  
ELECTRICAL DESIGN GROUP

THE COPYRIGHT OF THIS DRAWING  
REMAINS THE PROPERTY OF THE  
ELECTRICAL DESIGN GROUP.

USE FIGURED DIMENSIONS  
IN PREFERENCE TO SCALE.

ALL DIMENSIONS TO BE  
VERIFIED ONSITE.

**ELECTRICAL DESIGN GROUP**  
ELECTRICAL BUILDING SERVICES CONSULTANTS  
BRISBANE GOLD COAST

P.O.Box 15, Sherwood Q.4075  
Phone: (07) 3278 4375  
Email: brisbane@edg.net.au  
Web: www.edg.net.au

PROJECT:  
BURNSIDE ROAD, GILBERTON

LOT 4 BURNSIDE ROAD, GILBERTON, QUEENSLAND

D	CONSTRUCTION	17/04/2024
REV:	DESCRIPTION:	DATE:

DRAWING:  
**ELECTRICAL SERVICES**  
**GROUND LEVEL & LEVEL 1**  
**REFLECTED CEILING PLANS**

SCALE:  
1:100 & 1:200 AT A1

PROJECT NO:  
**C2964a**

DRAWING NO:  
**E05**

REVISION:  
**D**