




PROVIDE THIS ROOF MOUNTED 32 AMP ISOLATOR WITH A NEW 32 AMP 3-PHASE 6MM CIRCUIT FROM THE ROOF MOUNTED MSBB PROTECTED BY A 32 AMP RCBO. CONFIRM THE LOCATION OF THE ISOLATOR ON SITE WITH THE MECHANICAL SUB CONTRACTOR.

KIDS ROOM TO MEETING ROOM CONVERSION. REFER DETAIL A.

EXTENT OF ALTERATION WORKS

ROOF MOUNTED MSBB

ROOF MOUNTED

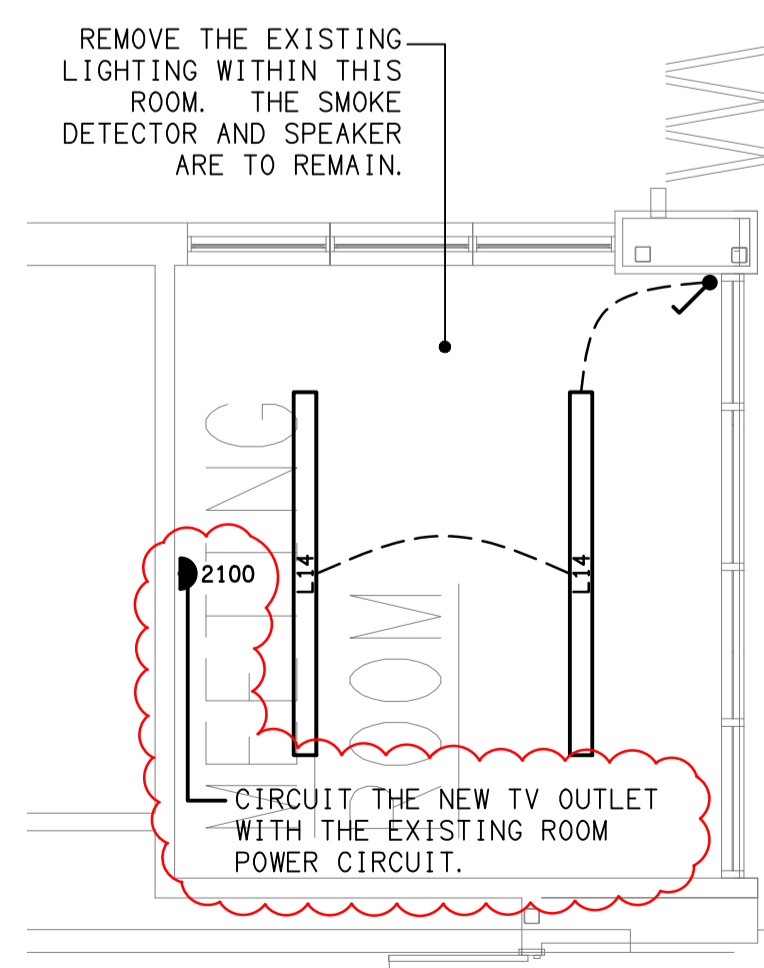

DETAILA
MEETING ROOM LIGHTING
SCALE 1:50

D	CONSTRUCTION	18/04/2024
REV:	DESCRIPTION:	DATE:

ELECTRICAL DESIGN GROUP
ELECTRICAL BUILDING SERVICES CONSULTANTS

BRISBANE: P.O. Box 15 Sherwood Qld 4075
Phone: (07) 3278 4375
Email: brisbane@edg.net.au
Web: www.edg.net.au

ELECTRICAL DESIGN GROUP BRISBANE PTY LTD ACN 092 710 793
TRADING AS: ELECTRICAL DESIGN GROUP

PROJECT:
BLUE FIN FISHING CLUB INALA - ALTERATIONS

SITE ADDRESS:
24 LILAC STREET, INALA
QUEENSLAND

SCALE: 1:200 SHEET SIZE: AT A1

DRAWING TITLE:
ELECTRICAL SERVICES SITE PLAN

PROJECT NO: DRAWING NO: REVISION:
C2969a E03 D

MAGNOLIA STREET

LILAC STREET