


THE COPYRIGHT OF THIS DRAWING REMAINS THE PROPERTY OF THE ELECTRICAL DESIGN GROUP.

USE FIGURED DIMENSIONS IN PREFERENCE TO SCALE.

ALL DIMENSIONS TO BE VERIFIED ONSITE.

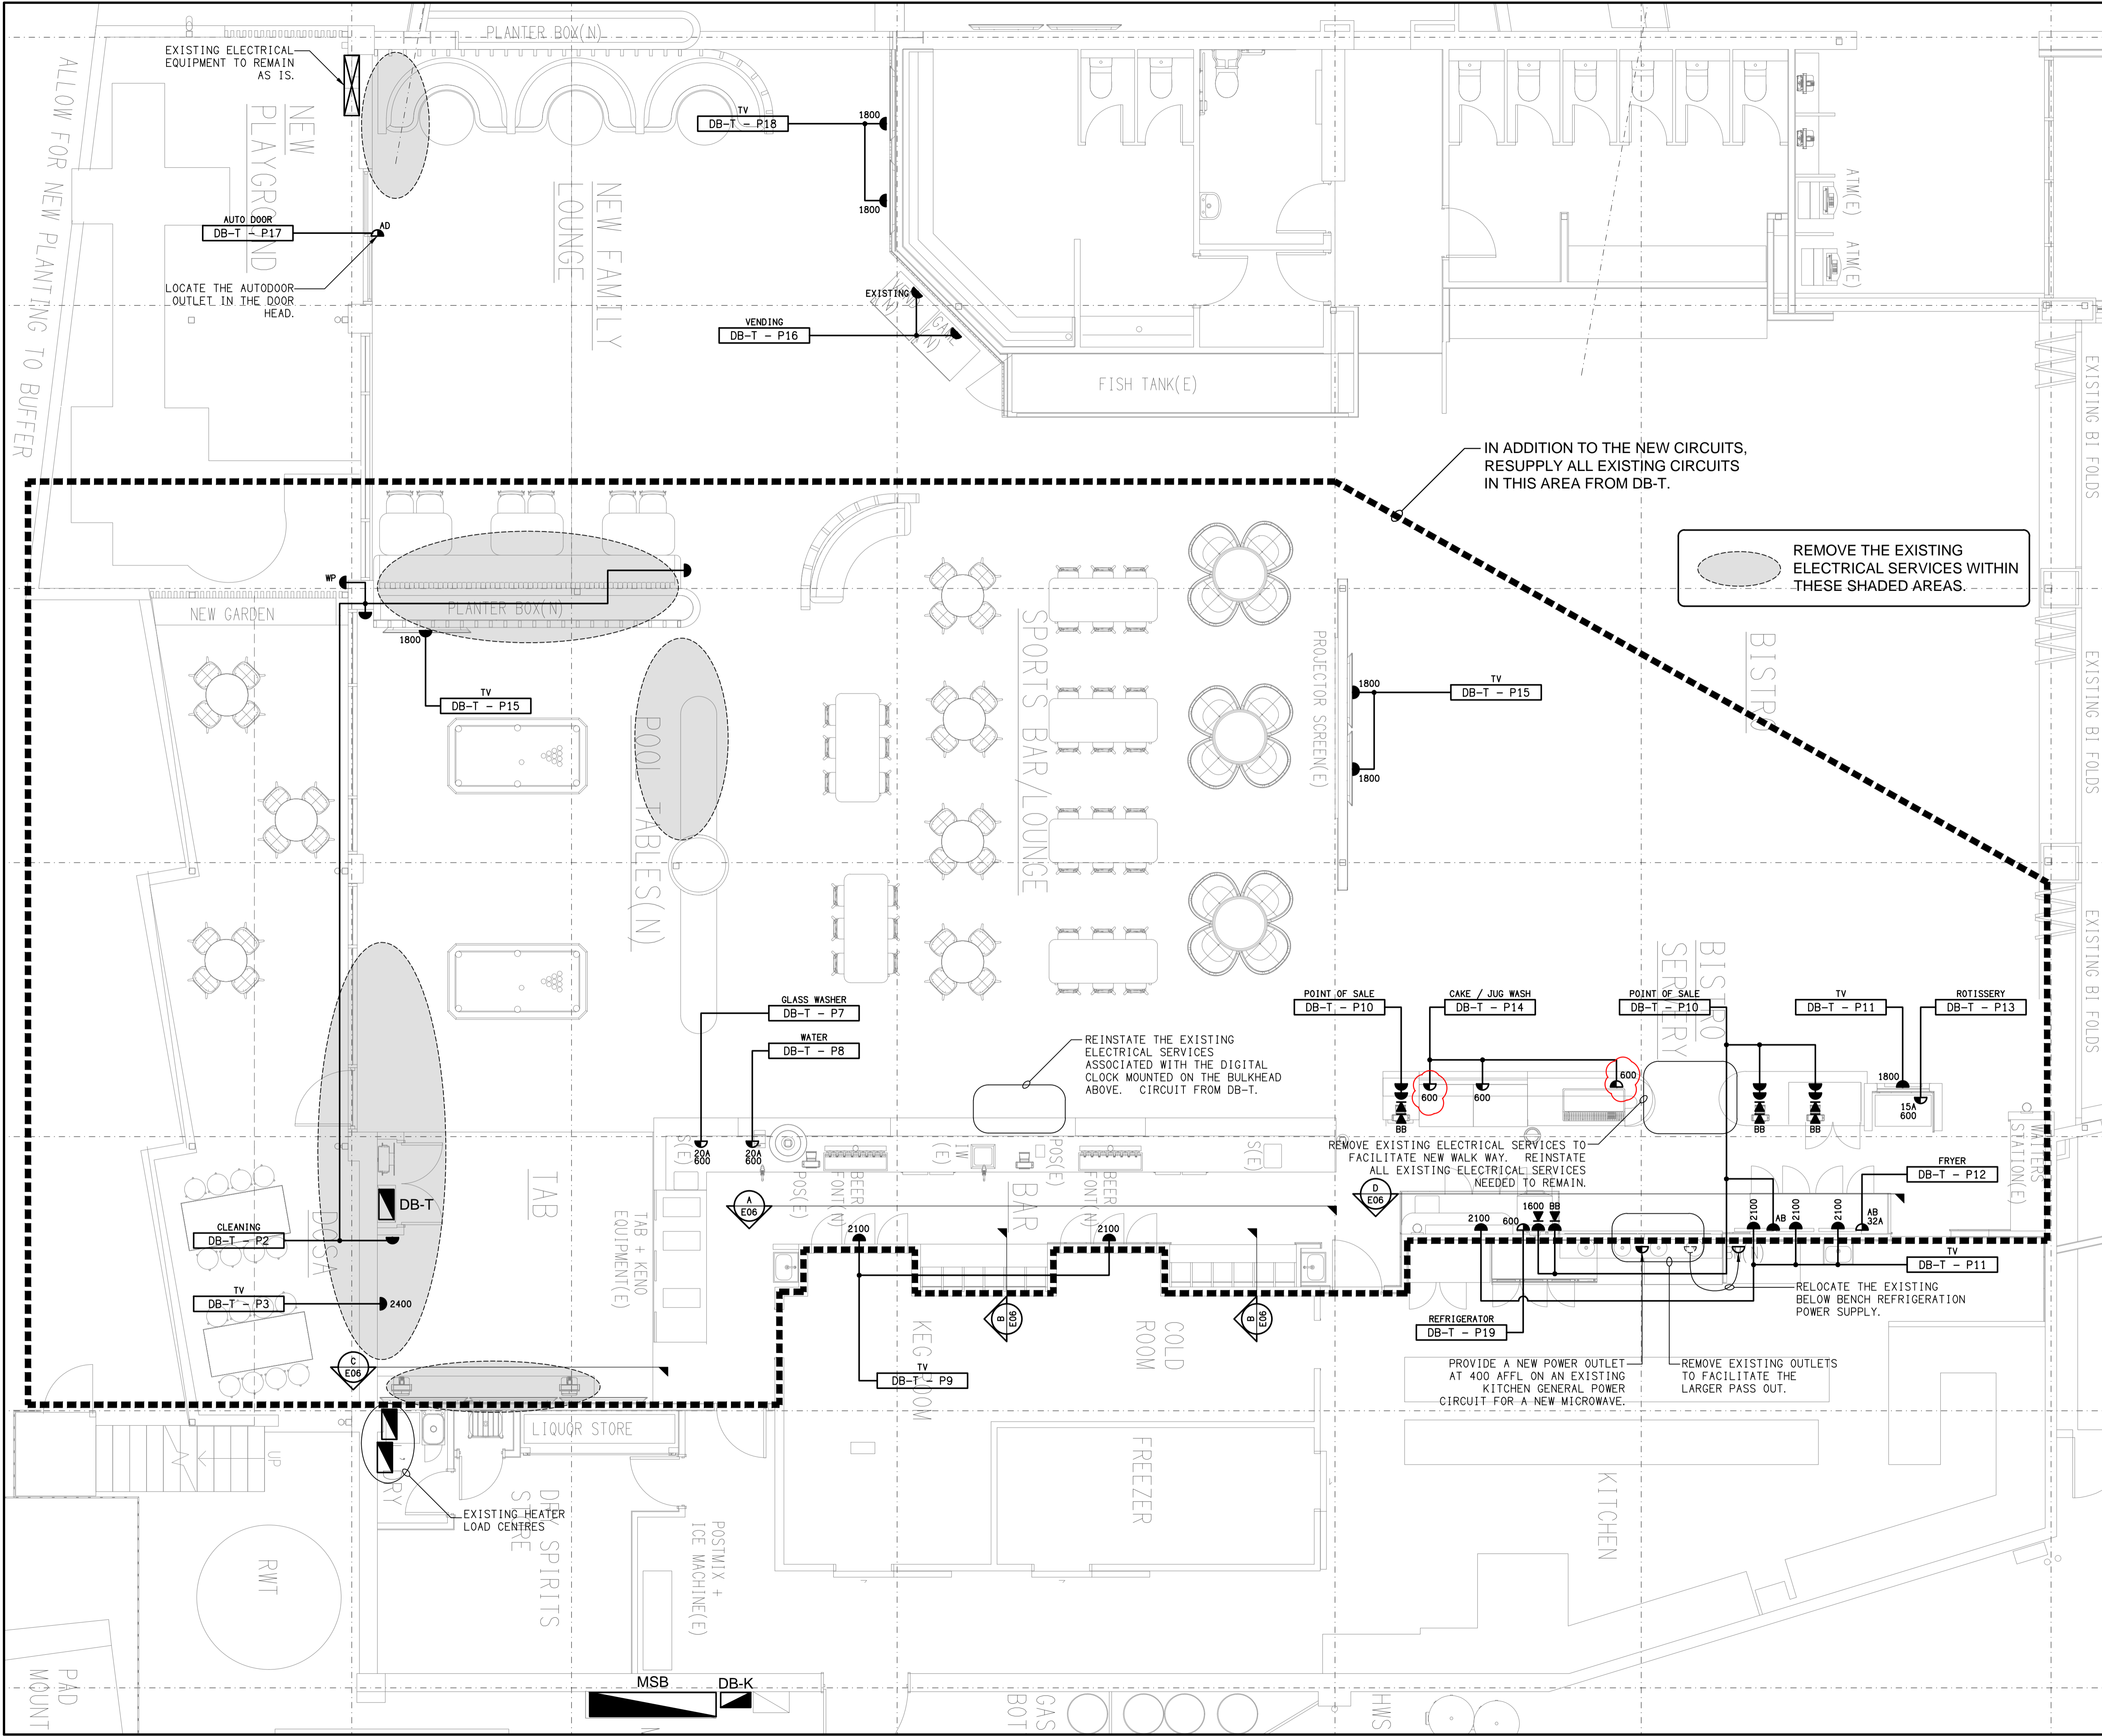

REMOVE THE EXISTING ELECTRICAL SERVICES WITHIN THESE SHADED AREAS.

IN ADDITION TO THE NEW CIRCUITS, RESUPPLY ALL EXISTING CIRCUITS IN THIS AREA FROM DB-T.

|      |              |            |
|------|--------------|------------|
| F    | CONSTRUCTION | 30/04/2024 |
| REV: | DESCRIPTION: | DATE:      |

**ELECTRICAL DESIGN GROUP**  
ELECTRICAL BUILDING SERVICES CONSULTANTS

BRISBANE: P.O. Box 15 Sherwood Qld 4075  
Phone: (07) 3278 4375  
Email: brisbane@edg.net.au  
Web: www.edg.net.au

ELECTRICAL DESIGN GROUP BRISBANE PTY LTD  
ACN 092 710 793

TRADING AS:  
ELECTRICAL DESIGN GROUP

PROJECT:  
**BLUE FIN FISHING CLUB  
INALA - ALTERATIONS**

SITE ADDRESS:  
24 LILAC STREET, INALA  
QUEENSLAND

SCALE: 1:50 SHEET SIZE: AT A1

DRAWING TITLE:  
**ELECTRICAL SERVICES  
FLOOR PLAN**

PROJECT NO. DRAWING NO. REVISION:  
**C2969a E04 F**