


**FLOOR PLAN**  
GROUND LEVEL  
SCALE 1:100

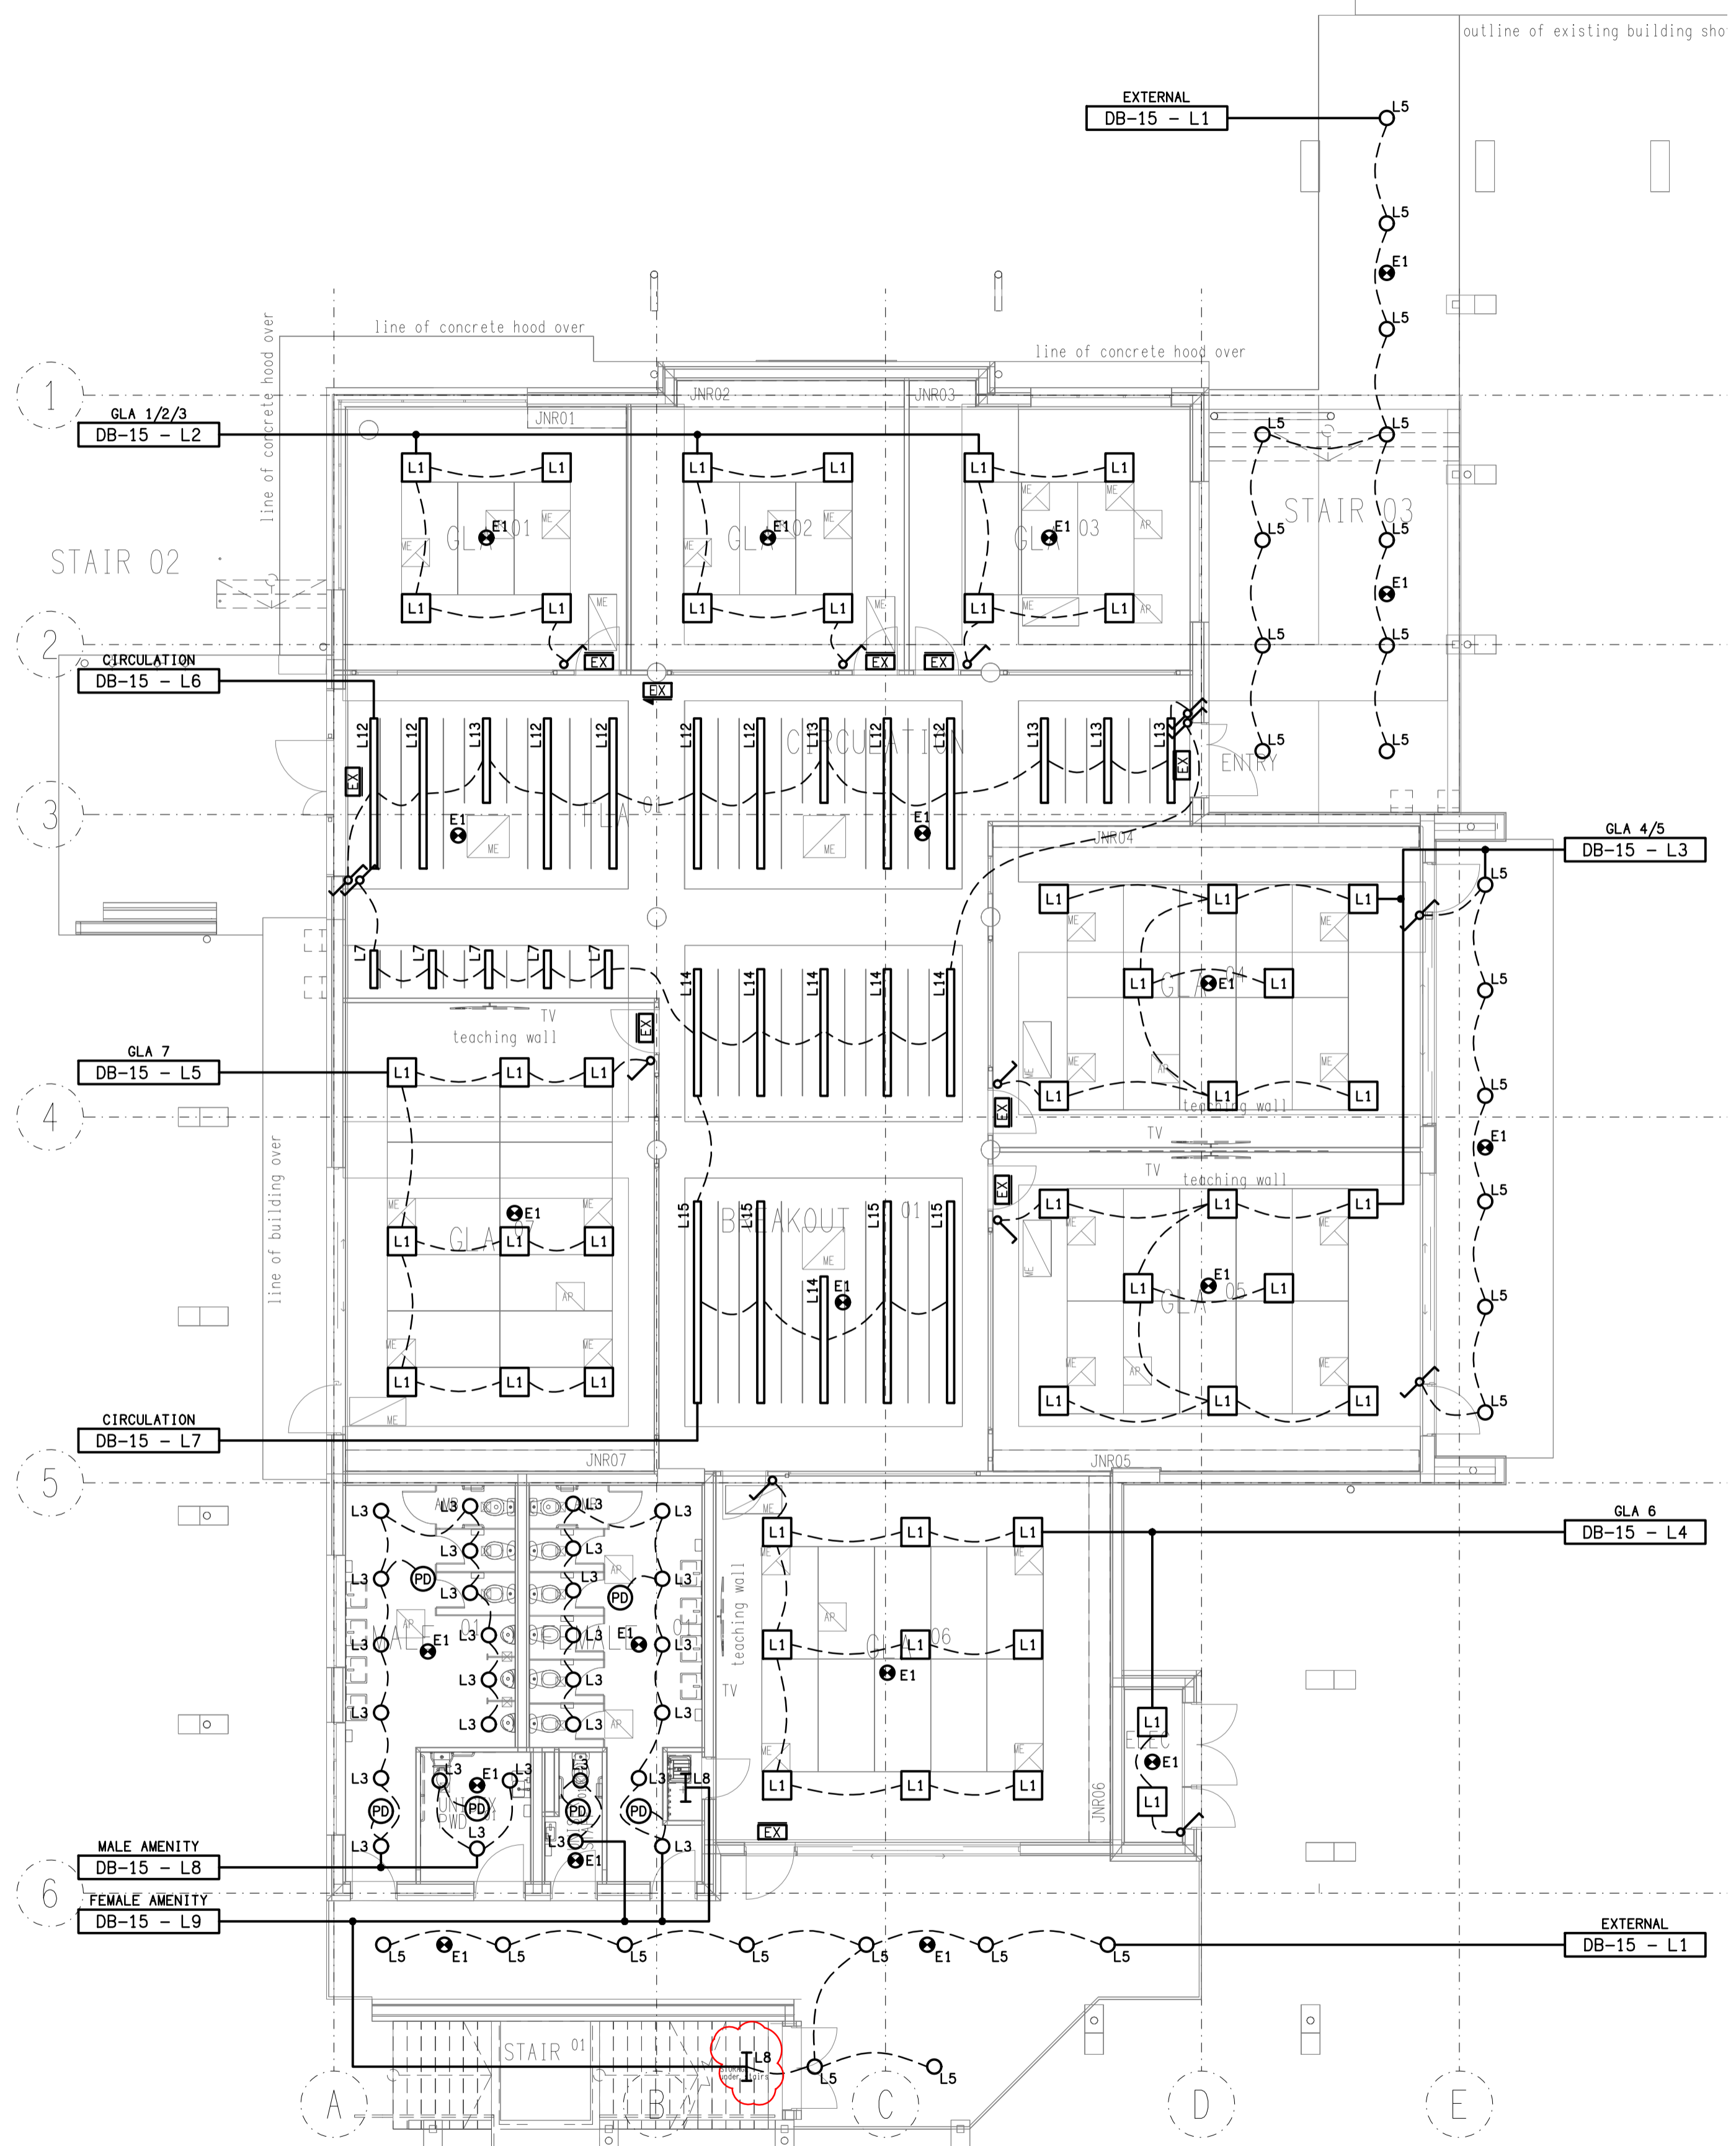

**REFLECTED CEILING PLAN**  
GROUND LEVEL  
SCALE 1:100

ELECTRICAL DESIGN GROUP BRISBANE  
PTY LTD  
ACN 092 710 793  
TRADING AS:  
ELECTRICAL DESIGN GROUP

THE COPYRIGHT OF THIS DRAWING  
REMAINS THE PROPERTY OF THE  
ELECTRICAL DESIGN GROUP.  
USE FIGURED DIMENSIONS  
IN PREFERENCE TO SCALE.  
ALL DIMENSIONS TO BE  
VERIFIED ONSITE.

**ELECTRICAL DESIGN GROUP**  
ELECTRICAL BUILDING SERVICES CONSULTANTS  
BRISBANE GOLD COAST

P.O. Box 15, Sherwood Q.4075  
Phone: (07) 3278 4375  
Email: brisbane@edg.net.au  
Web: www.edg.net.au

PROJECT:  
**KINGS CHRISTIAN COLLEGE - PIMPAMA  
JUNIOR RESOURCE BUILDING - PIM 15**

198 PIMPAMA JACOBS WELL ROAD, PIMPAMA, QUEENSLAND

C	CONSTRUCTION	08/12/2023
REV:	DESCRIPTION:	DATE:

DRAWING:  
**ELECTRICAL SERVICES  
GROUND LEVEL PLANS**

SCALE: 1:100	AT A1	PROJECT NO: <b>C2975a</b>	DRAWING NO: <b>E03</b>	REVISION: <b>C</b>
-----------------	-------	------------------------------	---------------------------	-----------------------