


FLOOR PLAN
LEVEL 1
SCALE 1:100

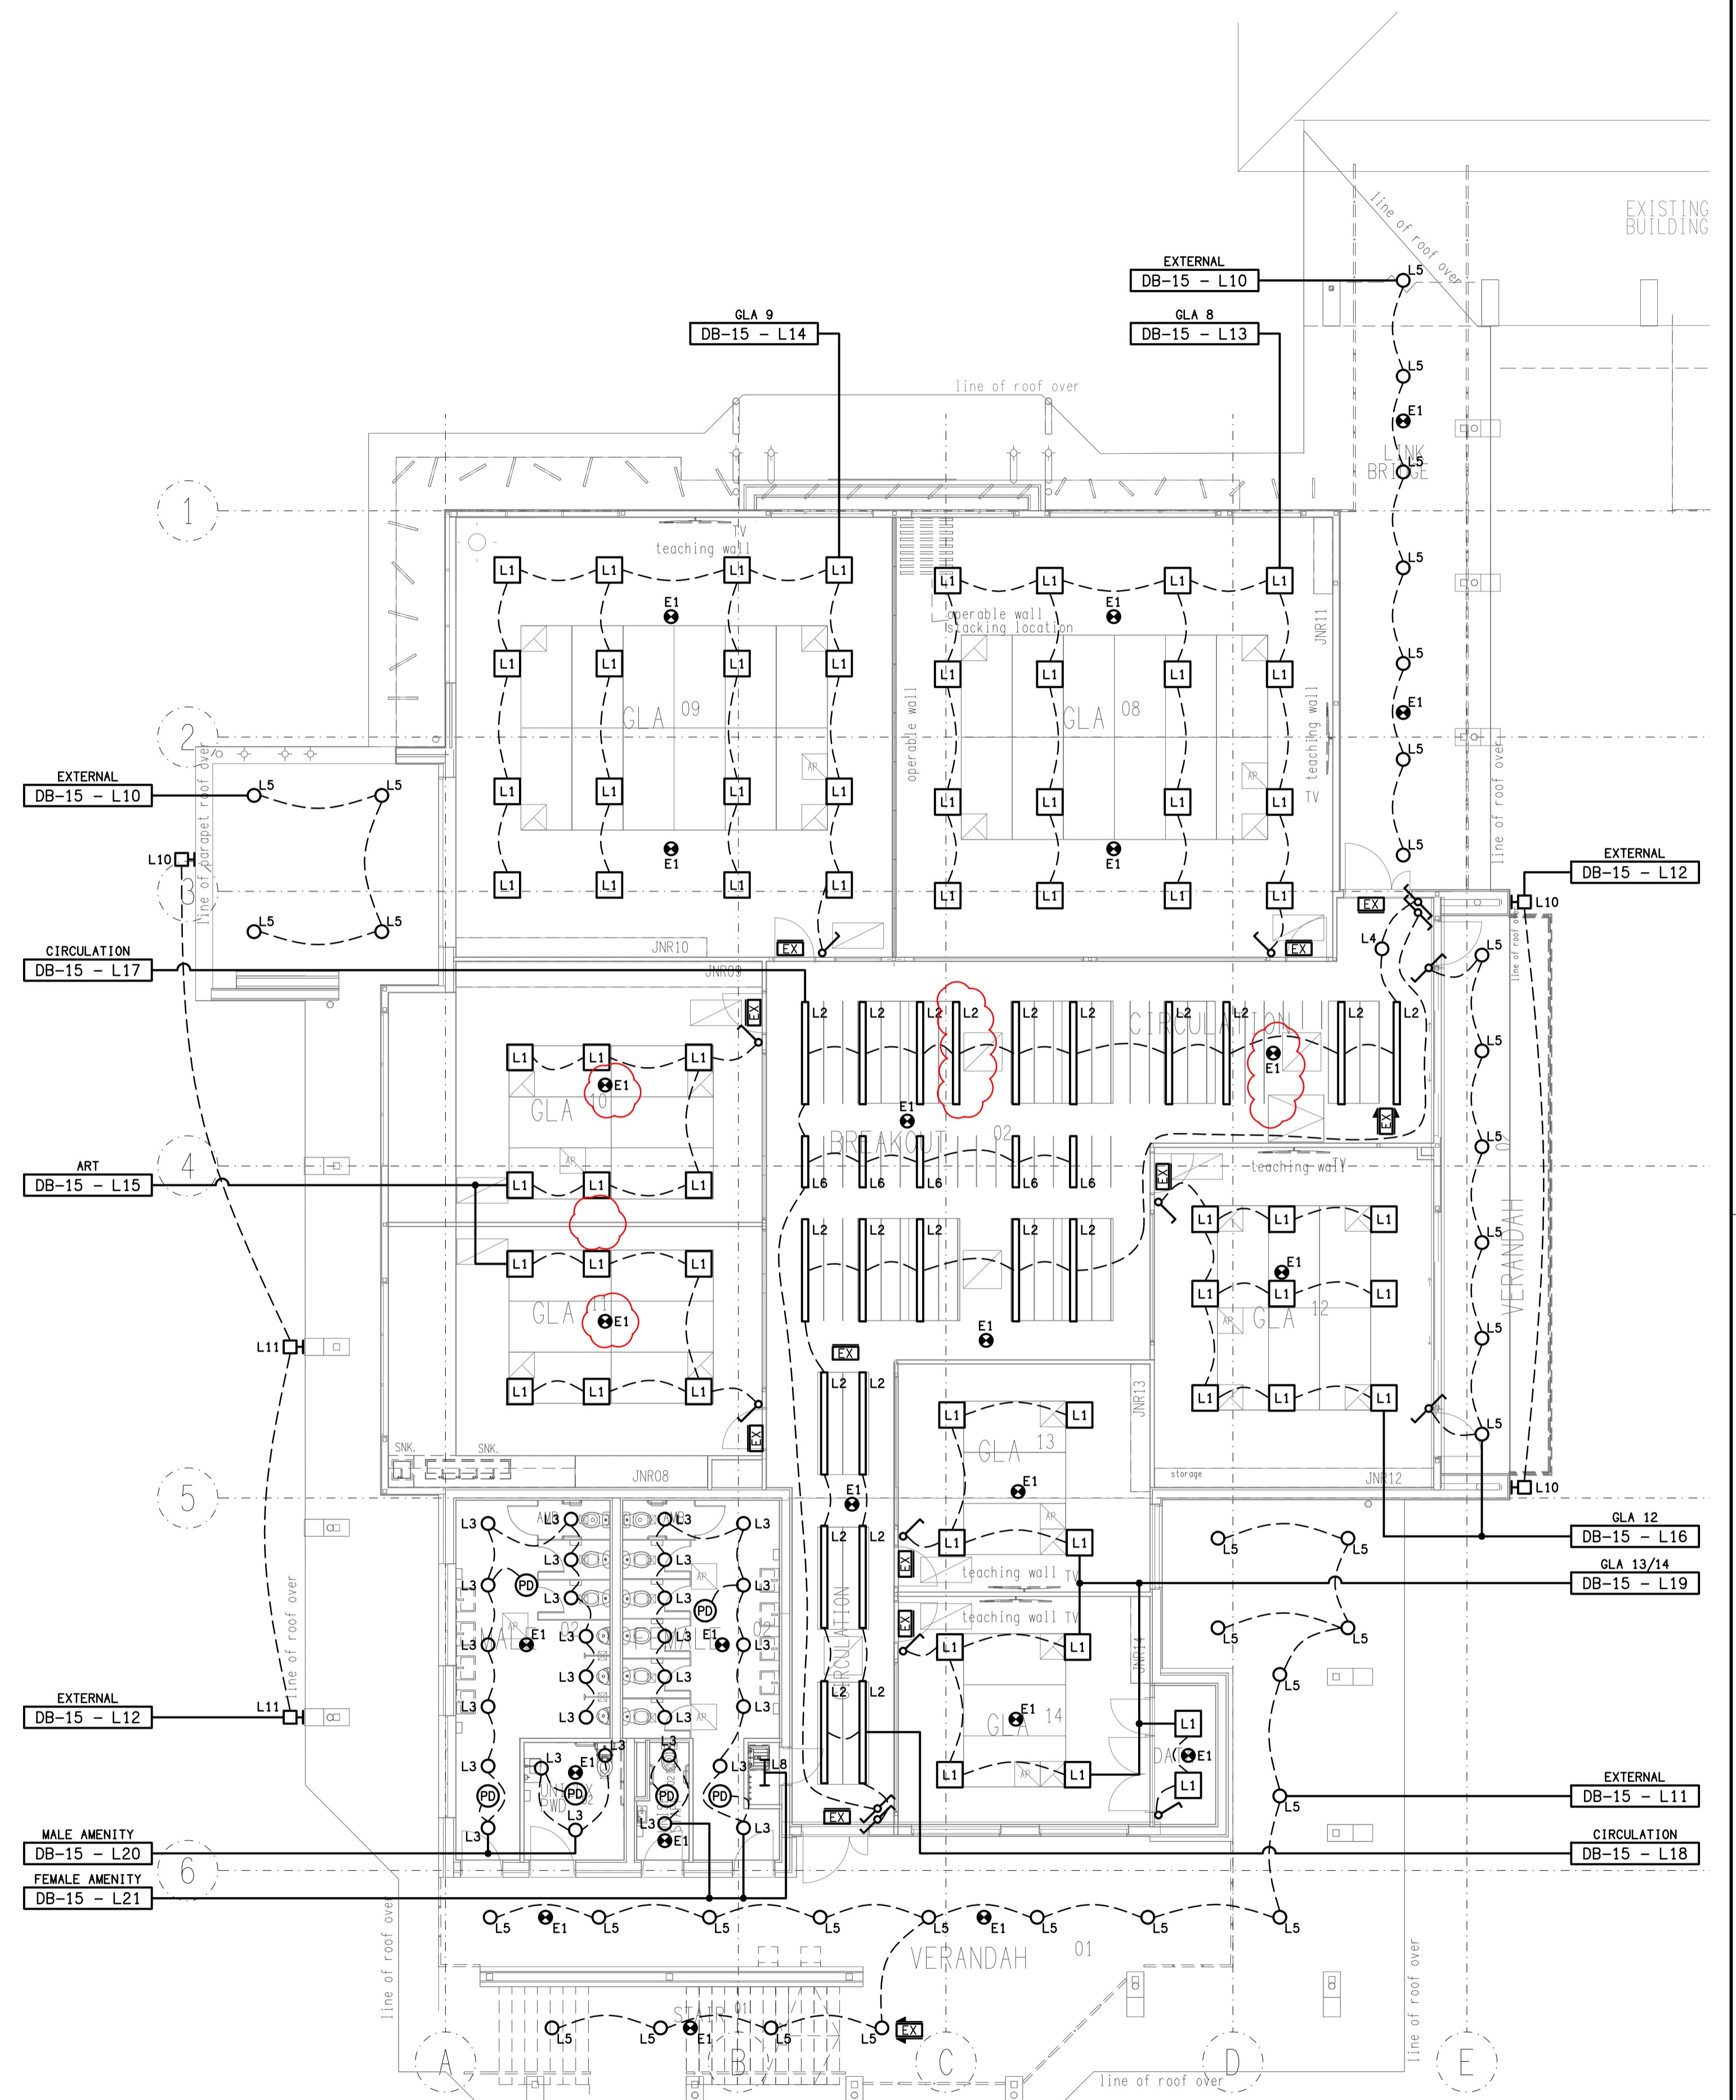

REFLECTED CEILING PLAN
LEVEL 1
SCALE 1:100

ELECTRICAL DESIGN GROUP BRISBANE
PTY LTD
ACN 092 710 793
TRADING AS:
ELECTRICAL DESIGN GROUP

THE COPYRIGHT OF THIS DRAWING
REMAINS THE PROPERTY OF THE
ELECTRICAL DESIGN GROUP.

USE FIGURED DIMENSIONS
IN PREFERENCE TO SCALE.

ALL DIMENSIONS TO BE
VERIFIED ONSITE.

ELECTRICAL DESIGN GROUP
ELECTRICAL BUILDING SERVICES CONSULTANTS
BRISBANE GOLD COAST

P.O. Box 15, Sherwood Q.4075
Phone: (07) 3278 4375
Email: brisbane@edg.net.au
Web: www.edg.net.au

PROJECT:
**KINGS CHRISTIAN COLLEGE - PIMPAMA
JUNIOR RESOURCE BUILDING - PIM 15**

198 PIMPAMA JACOBS WELL ROAD, PIMPAMA, QUEENSLAND

C	CONSTRUCTION	08/12/2023
REV.	DESCRIPTION:	DATE:

DRAWING:
**ELECTRICAL SERVICES
LEVEL 1 PLANS**

SCALE:
1:100

AT A1

PROJECT NO:
C2975a

DRAWING NO:
E04

REVISION:
C