




DETAIL A
DB-A ACCESS TRENCH SECTION
SCALE 1:50

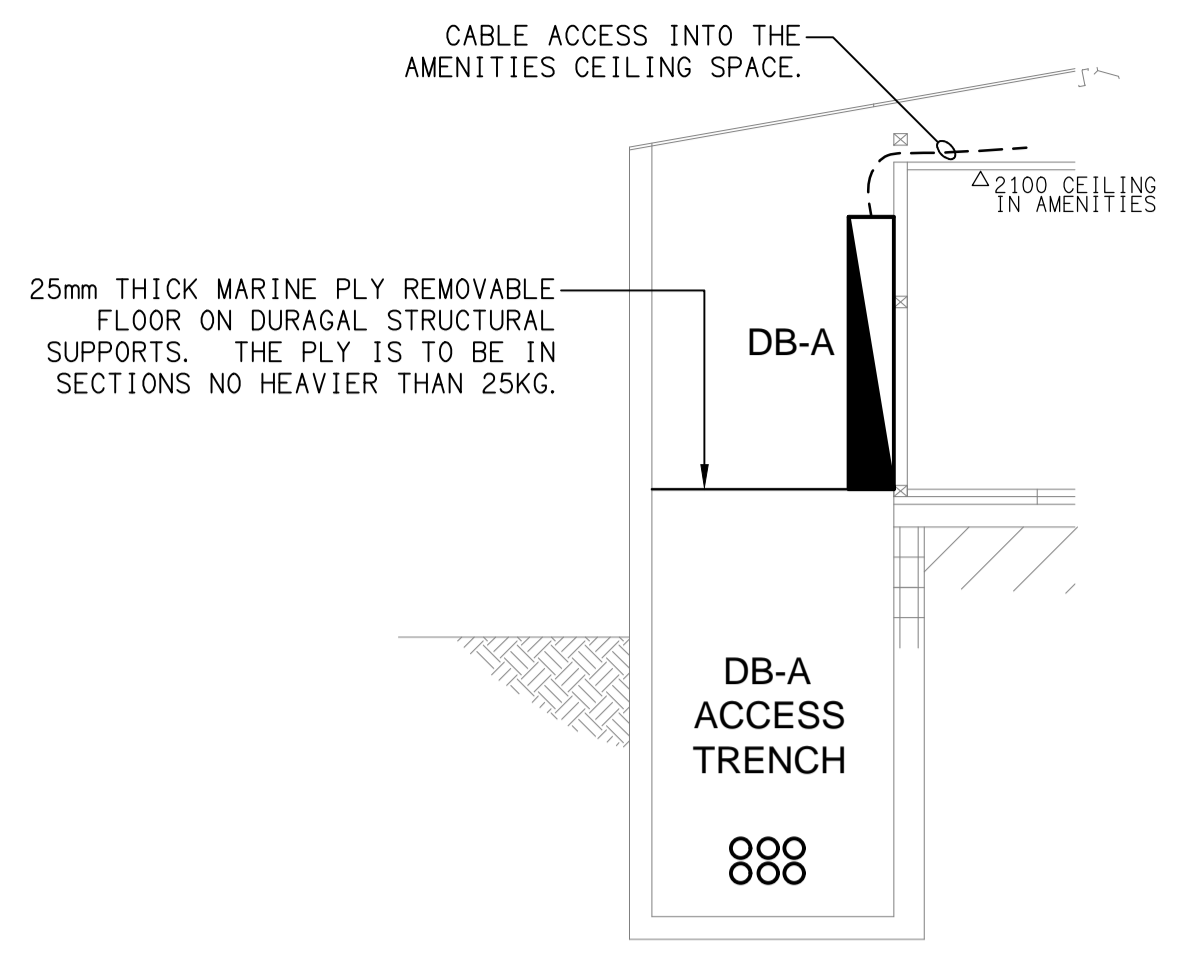

DETAIL B
DB-A ACCESS TRENCH SECTION
SCALE 1:50

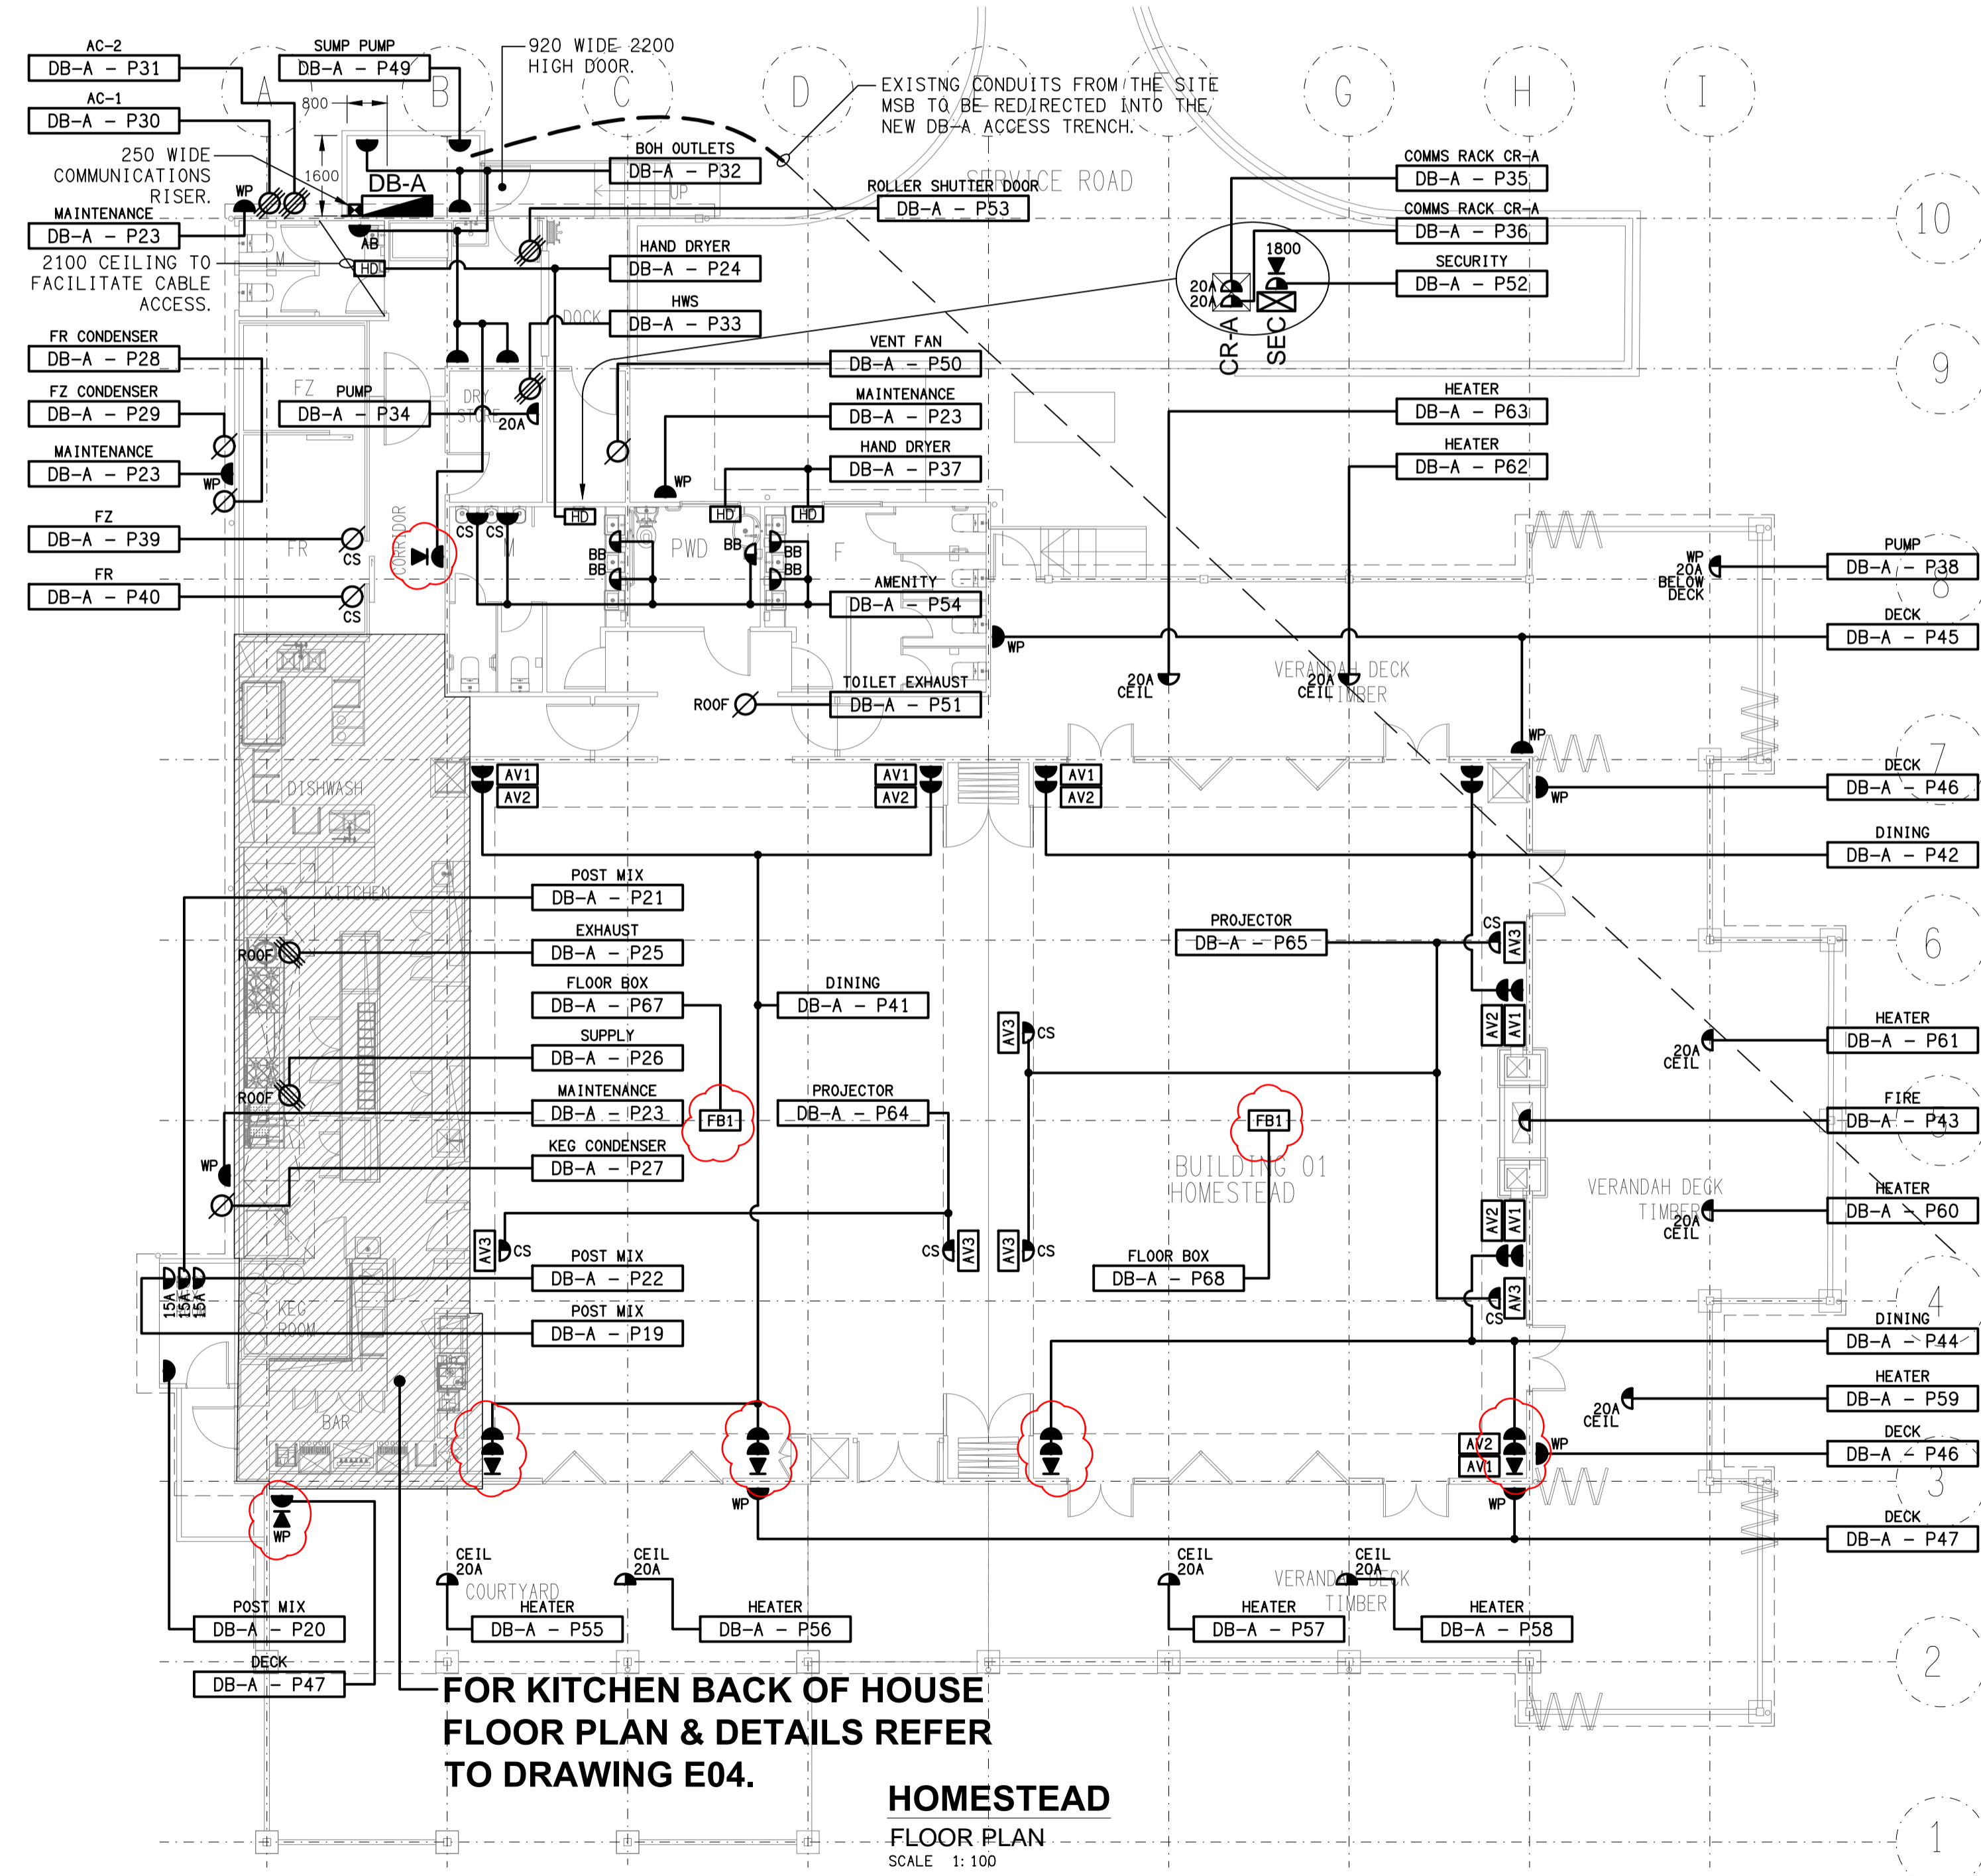

HOMESTEAD
FLOOR PLAN
SCALE 1:100

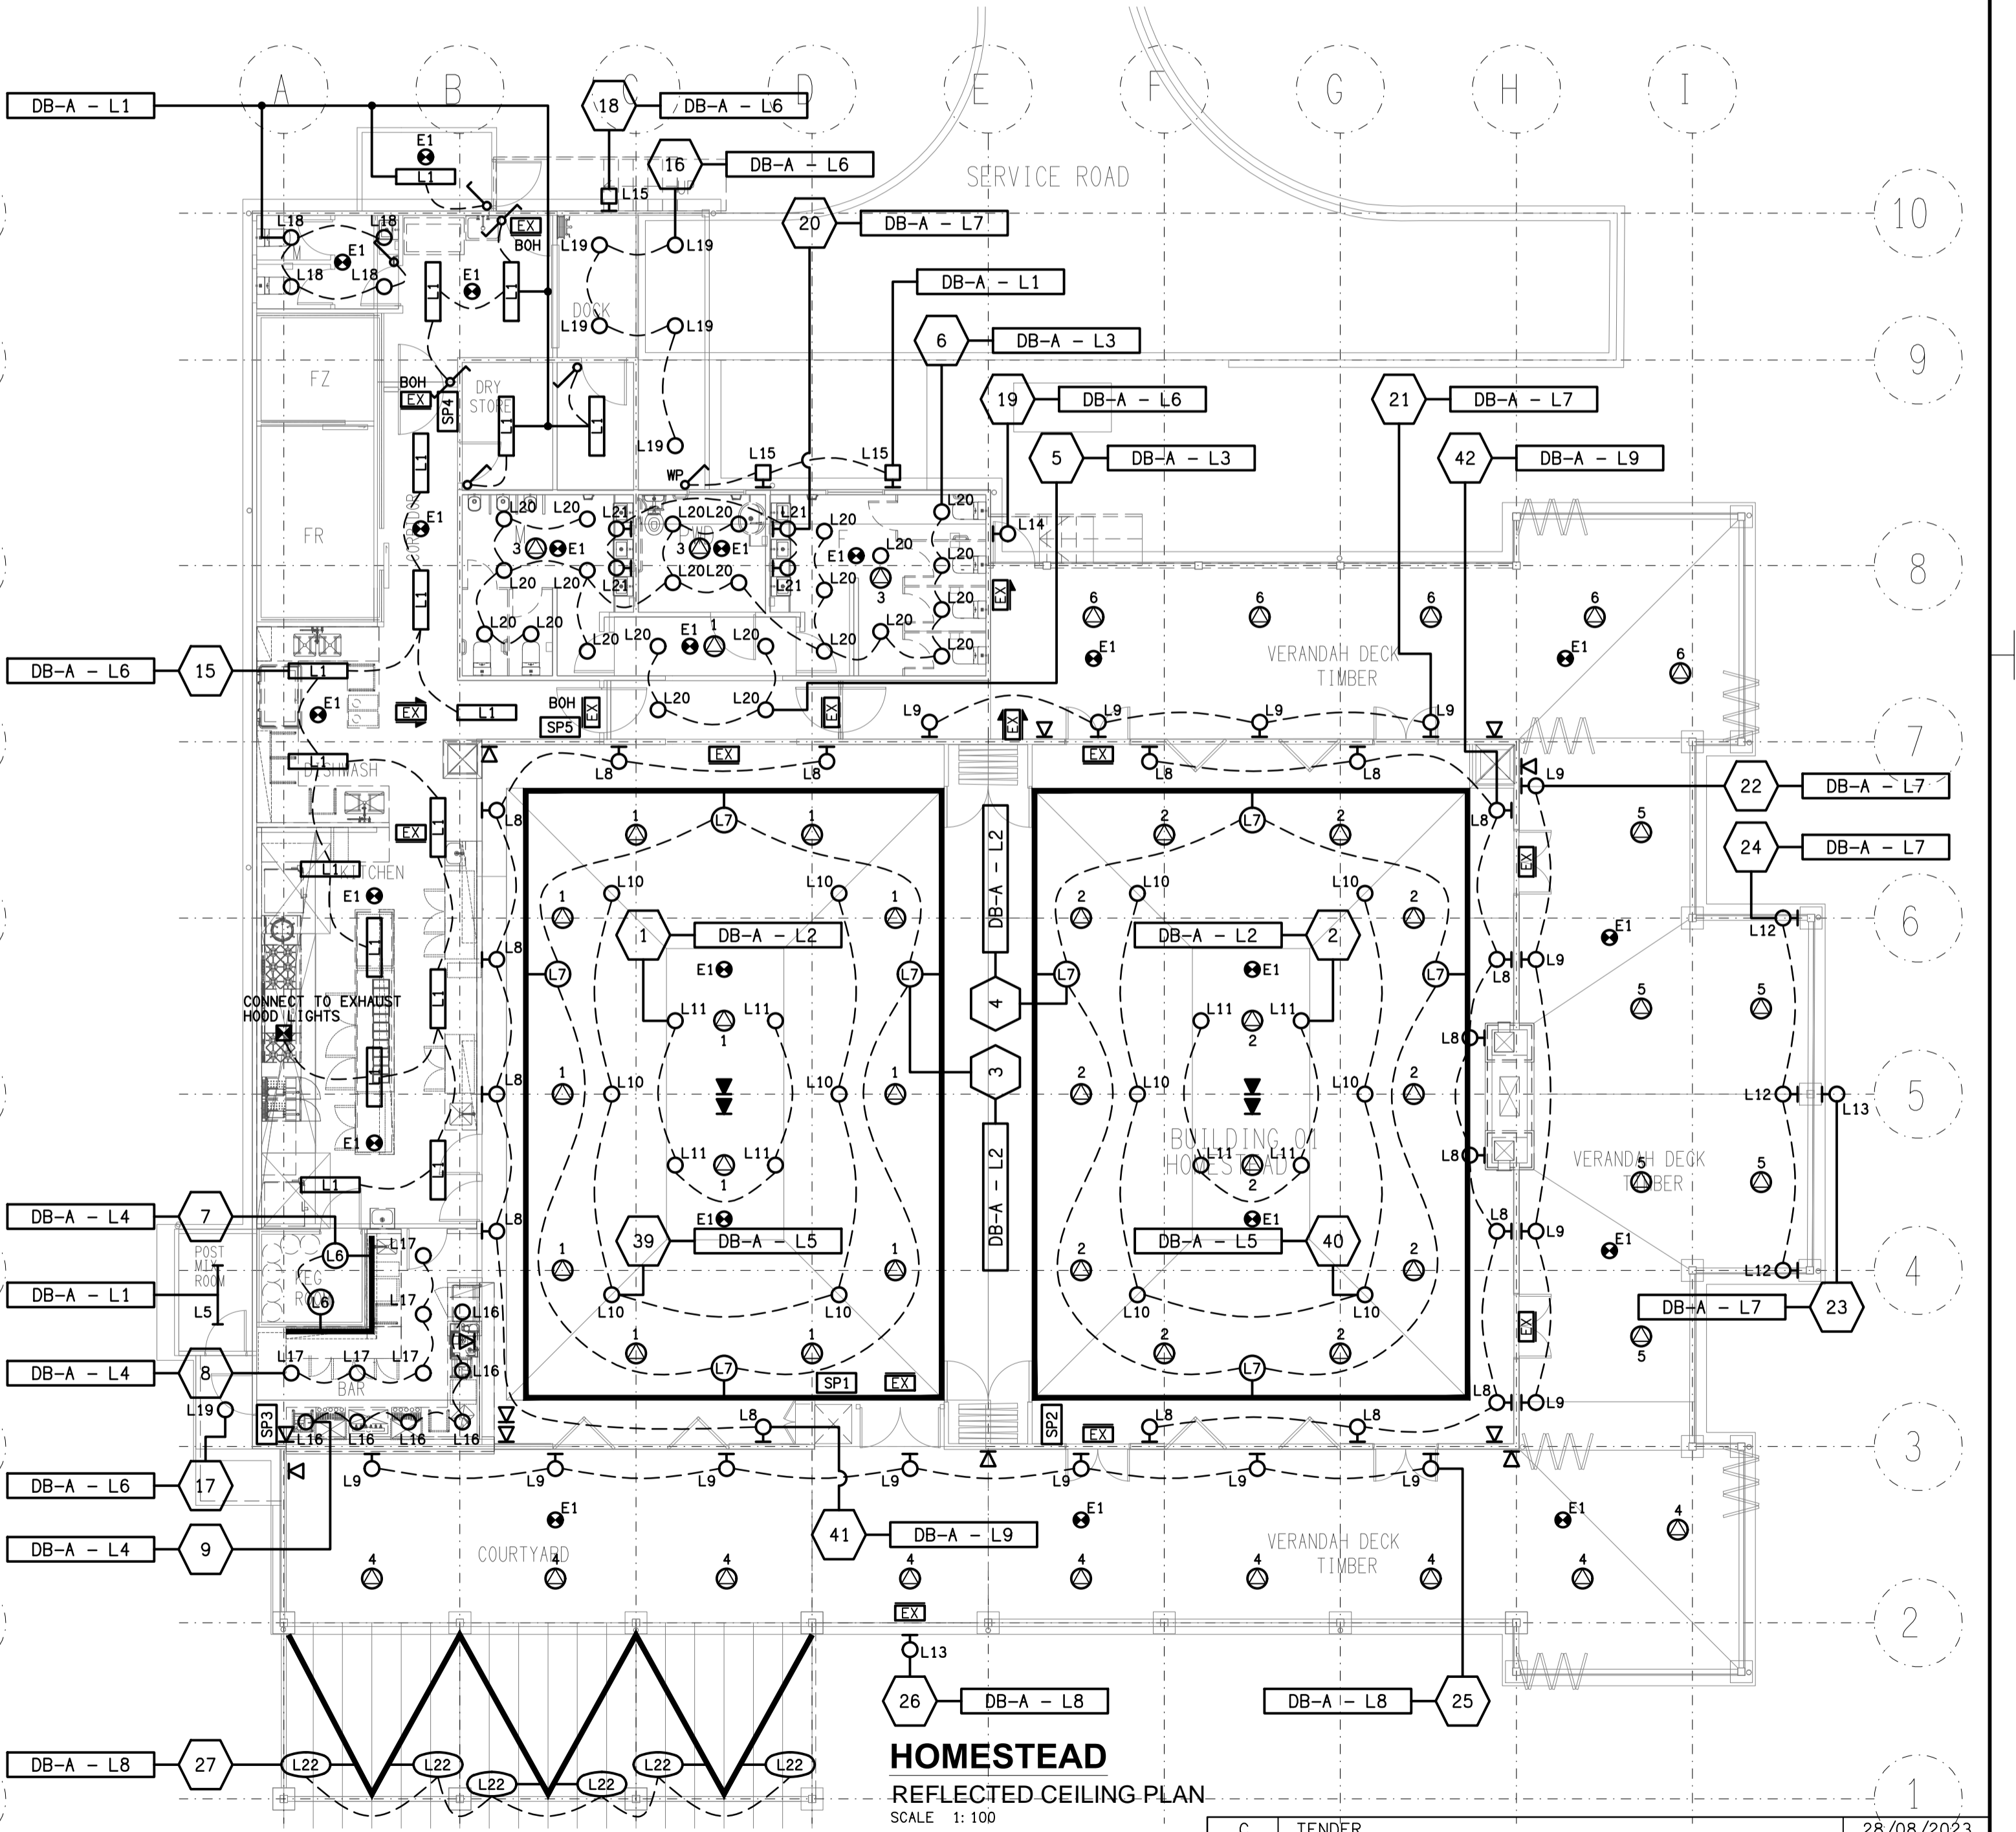

HOMESTEAD
REFLECTED CEILING PLAN
SCALE 1:100

ELECTRICAL DESIGN GROUP BRISBANE
PTY LTD
ACN 092 710 793
TRADING AS:
ELECTRICAL DESIGN GROUP

THE COPYRIGHT OF THIS DRAWING
REMAINS THE PROPERTY OF THE
ELECTRICAL DESIGN GROUP.
USE FIGURED DIMENSIONS
IN PREFERENCE TO SCALE.
ALL DIMENSIONS TO BE
VERIFIED ONSITE.

ELECTRICAL DESIGN GROUP
ELECTRICAL BUILDING SERVICES CONSULTANTS
BRISBANE GOLD COAST
P.O. Box 15, Sherwood Q. 4075
Phone: (07) 3278 4375
Email: brisbane@edg.net.au
Web: www.edg.net.au

PROJECT:
**CURRUMBIN WILDLIFE SANCTUARY
AUSTRALIANA PRECINCT**
28 TOMWIN STREET, CURRUMBIN, QUEENSLAND

C	TENDER	28/08/2023
REV.	DESCRIPTION:	DATE:
DRAWING: ELECTRICAL SERVICES HOMESTEAD PLANS		
SCALE: 1:100	AT A1	PROJECT NO: C3031a
		DRAWING NO: E03
		REVISION: C