



FLOOR PLAN
TICKET OFFICE
SCALE 1:100

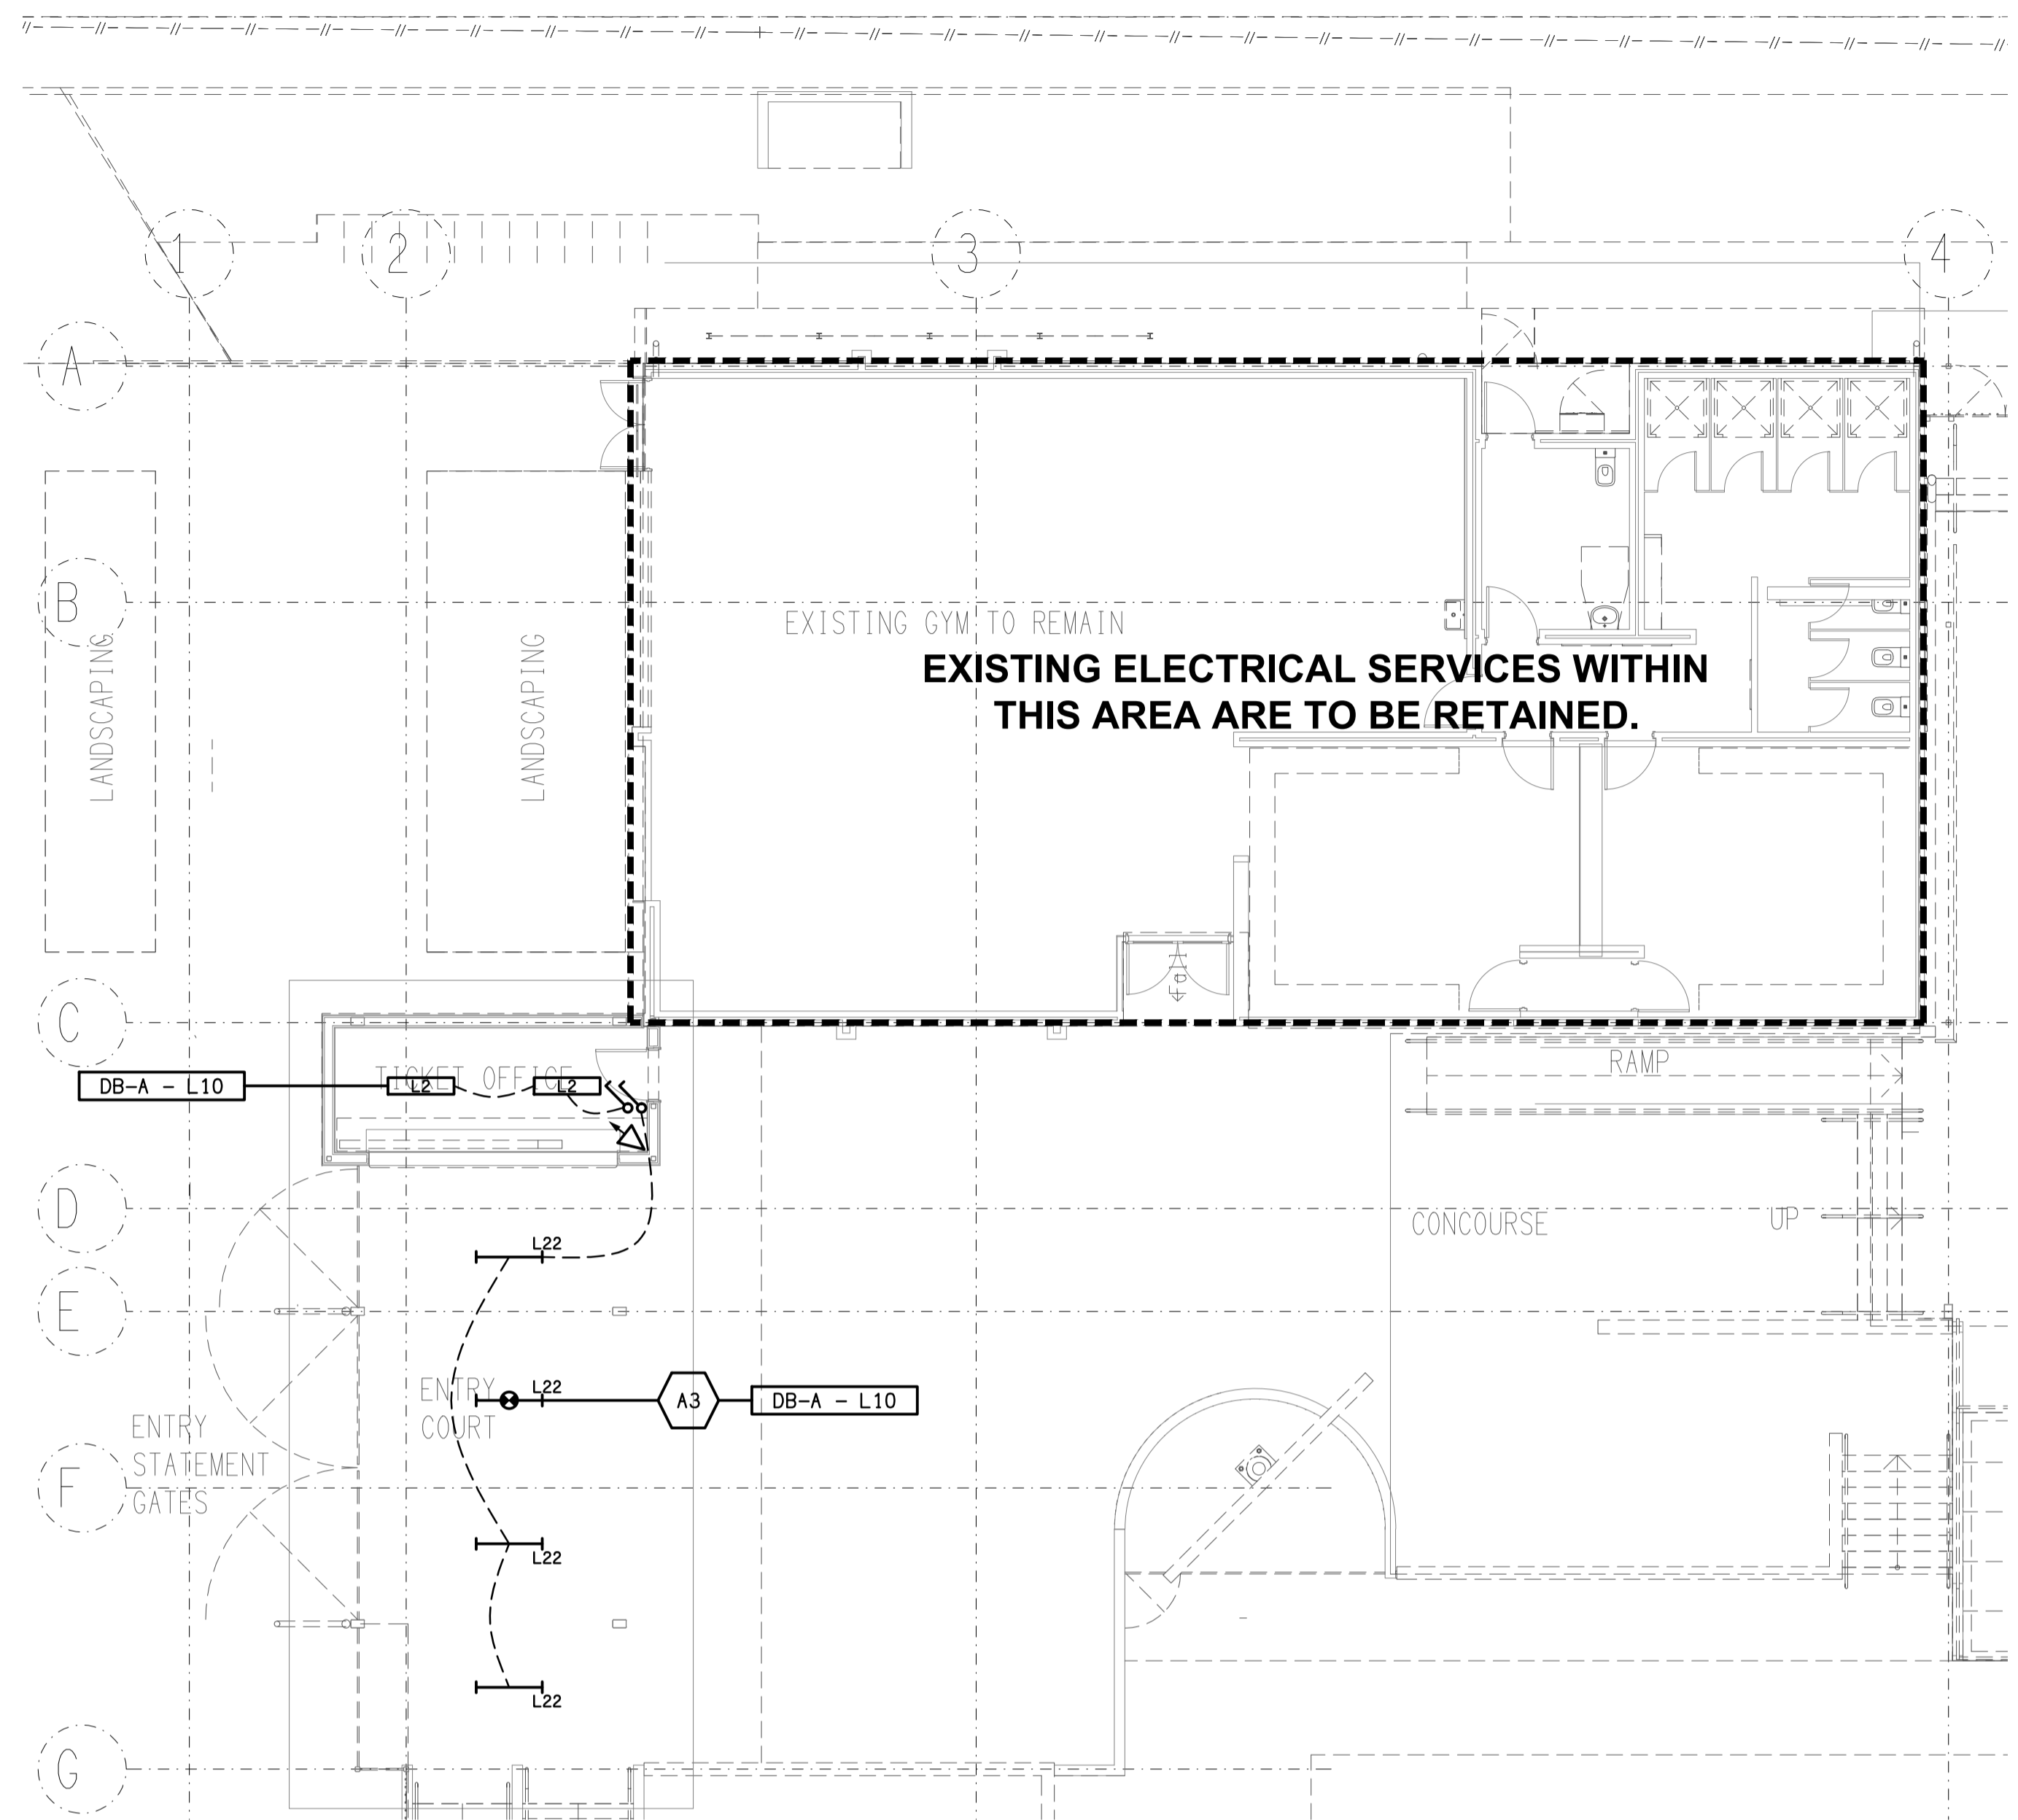

REFLECTED CEILING PLAN
TICKET OFFICE
SCALE 1:100

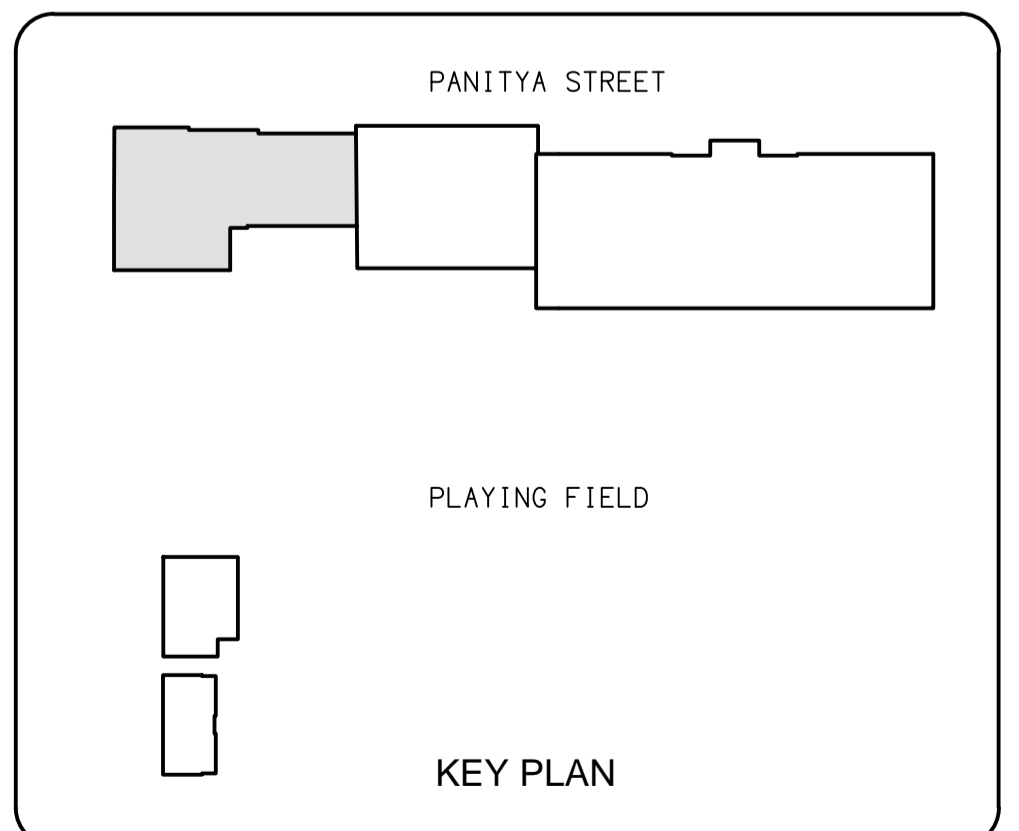

ELECTRICAL DESIGN GROUP BRISBANE
PTY LTD
ACN 092 710 793
TRADING AS:
ELECTRICAL DESIGN GROUP

THE COPYRIGHT OF THIS DRAWING
REMAINS THE PROPERTY OF THE
ELECTRICAL DESIGN GROUP.
USE FIGURED DIMENSIONS
IN PREFERENCE TO SCALE.
ALL DIMENSIONS TO BE
VERIFIED ONSITE.

ELECTRICAL DESIGN GROUP
ELECTRICAL BUILDING SERVICES CONSULTANTS
BRISBANE GOLD COAST

P.O. Box 15, Sherwood Q.4075
Phone: (07) 3278 4375
Email: brisbane@edg.net.au
Web: www.edg.net.au

PROJECT:
BRISBANE TIGERS - STAGE 2
LANGLANDS PARK, MAIN AVENUE, COORPAROO

B	CONSTRUCTION	06/11/2023
REV:	DESCRIPTION:	DATE:
DRAWING: ELECTRICAL SERVICES TICKET OFFICE FLOOR PLAN & REFLECTED CEILING PLAN		
SCALE: 1:100	PROJECT NO: C3040a	DRAWING NO: E05
AT A1	REVISION: B	