



**ROOF PLATFORM**  
RUGBY AMENITIES  
SCALE 1: 100

**NOTE:**  
ALL L7, L10 & L11 FITTINGS ARE TO BE SUPPLIED FROM CIRCUIT DB-A - L1.

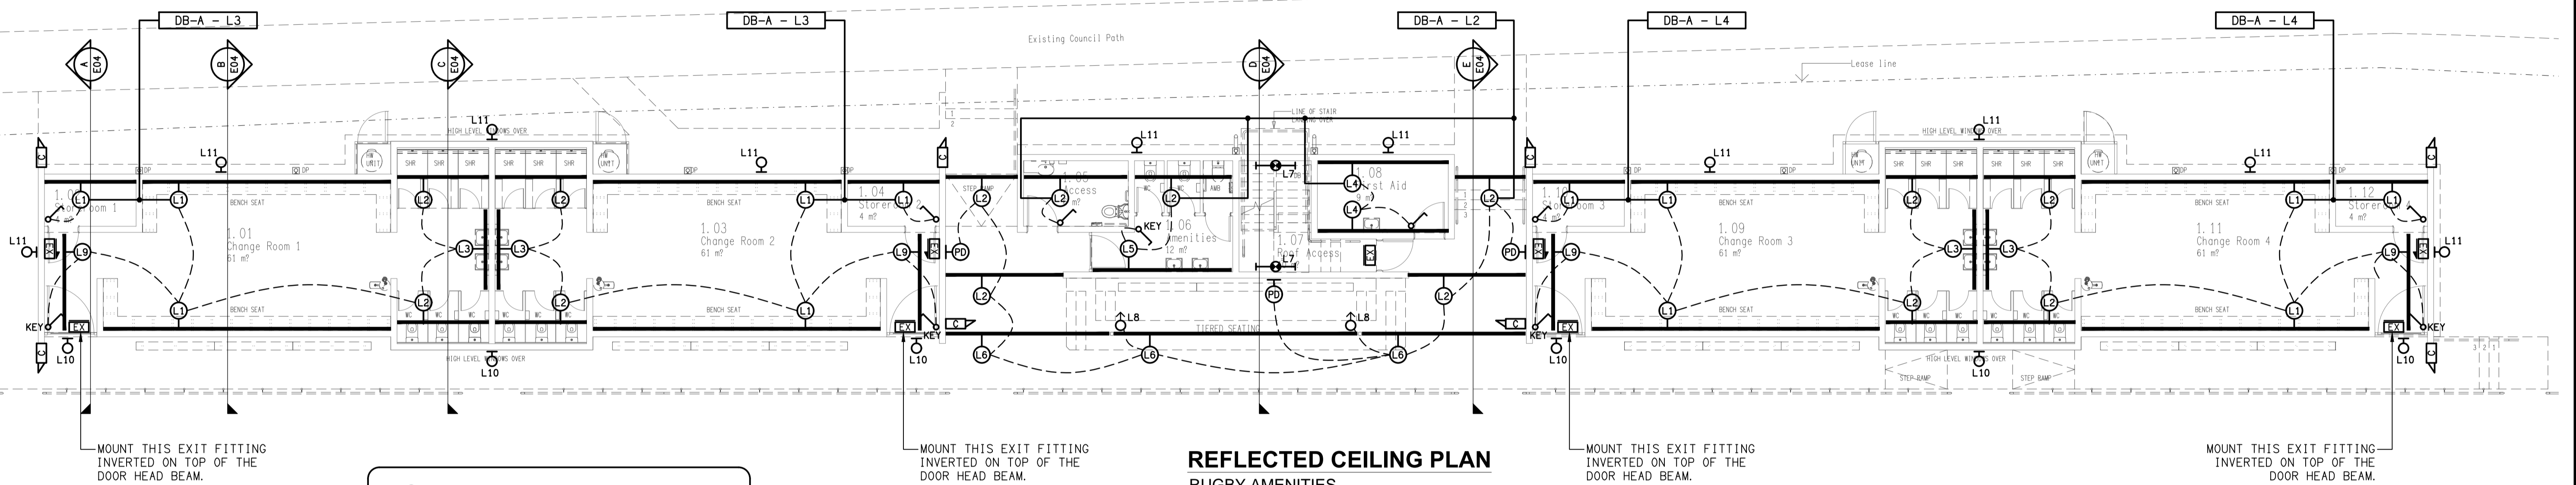

**REFLECTED CEILING PLAN**  
RUGBY AMENITIES  
SCALE 1: 100

**NOTE**  
ALL ELECTRICAL PENETRATIONS THROUGH THE ROOF SHEETING ARE TO BE IN LINE WITH THE STRUCTURAL OR MECHANICAL SERVICES PENETRATIONS TO AVOID DEDICATED FLASHINGS FOR THE ELECTRICAL SERVICES.

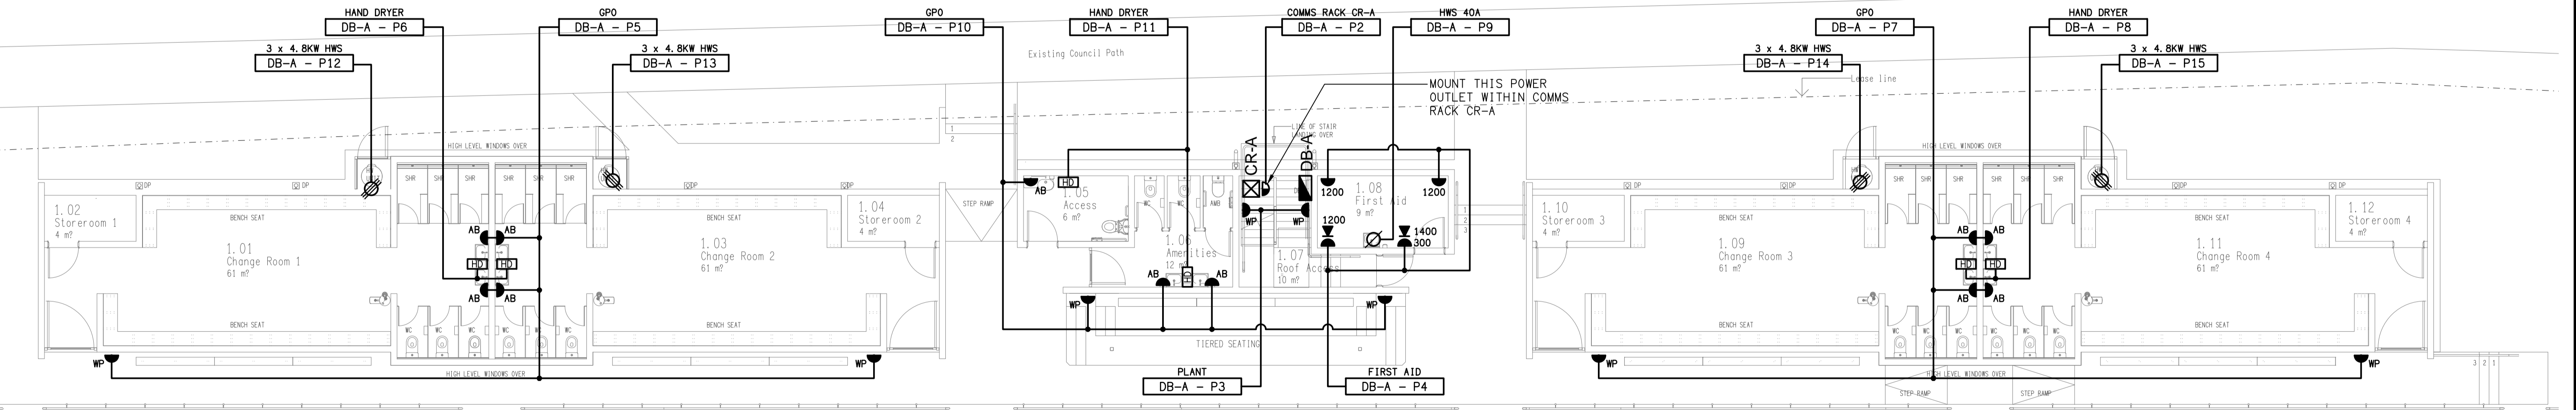

**FLOOR PLAN**  
RUGBY AMENITIES  
SCALE 1: 100

ELECTRICAL DESIGN GROUP BRISBANE PTY LTD ACN 092 710 793  TRADING AS: ELECTRICAL DESIGN GROUP	THE COPYRIGHT OF THIS DRAWING REMAINS THE PROPERTY OF THE ELECTRICAL DESIGN GROUP.  USE FIGURED DIMENSIONS IN PREFERENCE TO SCALE.  ALL DIMENSIONS TO BE VERIFIED ONSITE.	<b>ELECTRICAL DESIGN GROUP</b> ELECTRICAL BUILDING SERVICES CONSULTANTS BRISBANE GOLD COAST  P.O. Box 15, Sherwood Q.4075 Phone: (07) 3278 4375 Email: brisbane@edg.net.au Web: www.edg.net.au	PROJECT: <b>ASPLEY LEAGUES CLUB - RUGBY AMENITIES</b>	C CONSTRUCTION 12/09/2023 REV: DESCRIPTION: DATE:
			29 KIRBY ROAD, ASPLEY, QUEENSLAND	DRAWING: <b>ELECTRICAL SERVICES AMENITIES PLANS</b>  SCALE: 1:100 AT A1 PROJECT NO: <b>C3051a</b> DRAWING NO: <b>E03</b> REVISION: <b>C</b>