




**ZONE 3**  
RESTAURANT AMENITIES WALL MOUNTED LIGHTING  
SCALE 1: 50

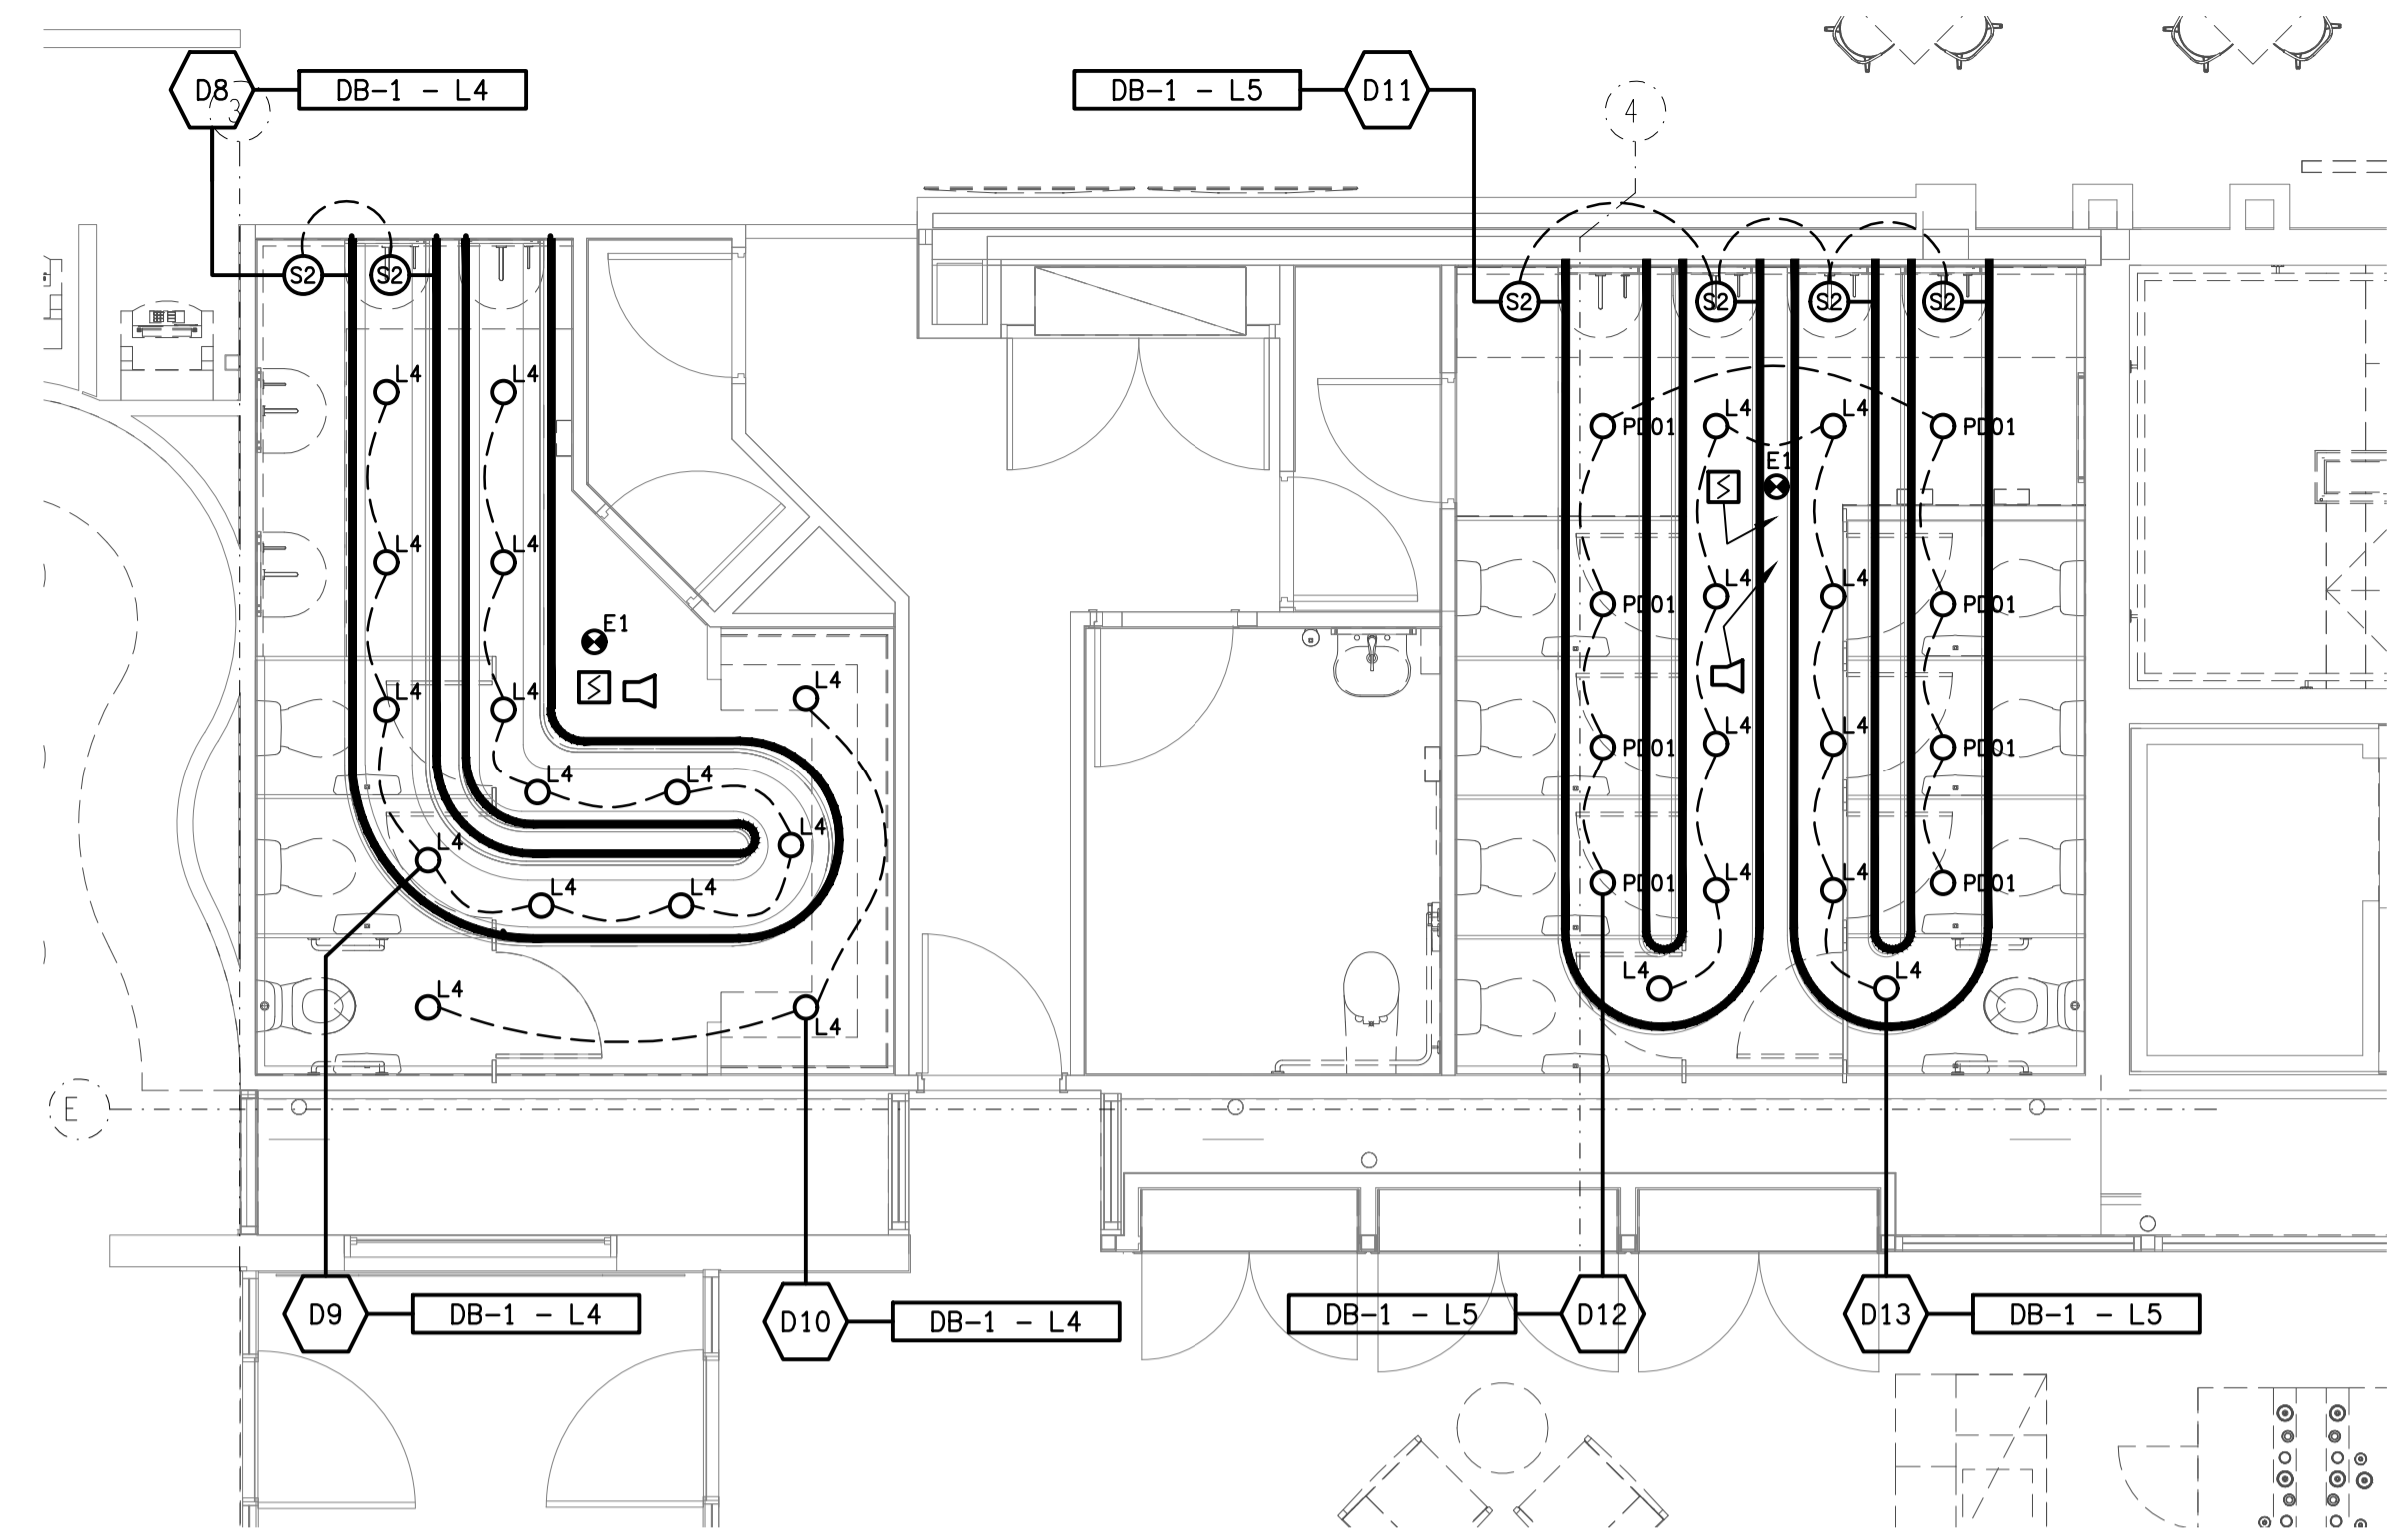


**ZONE 3**  
RESTAURANT AMENITIES REFLECTED CEILING PLAN  
SCALE 1: 50

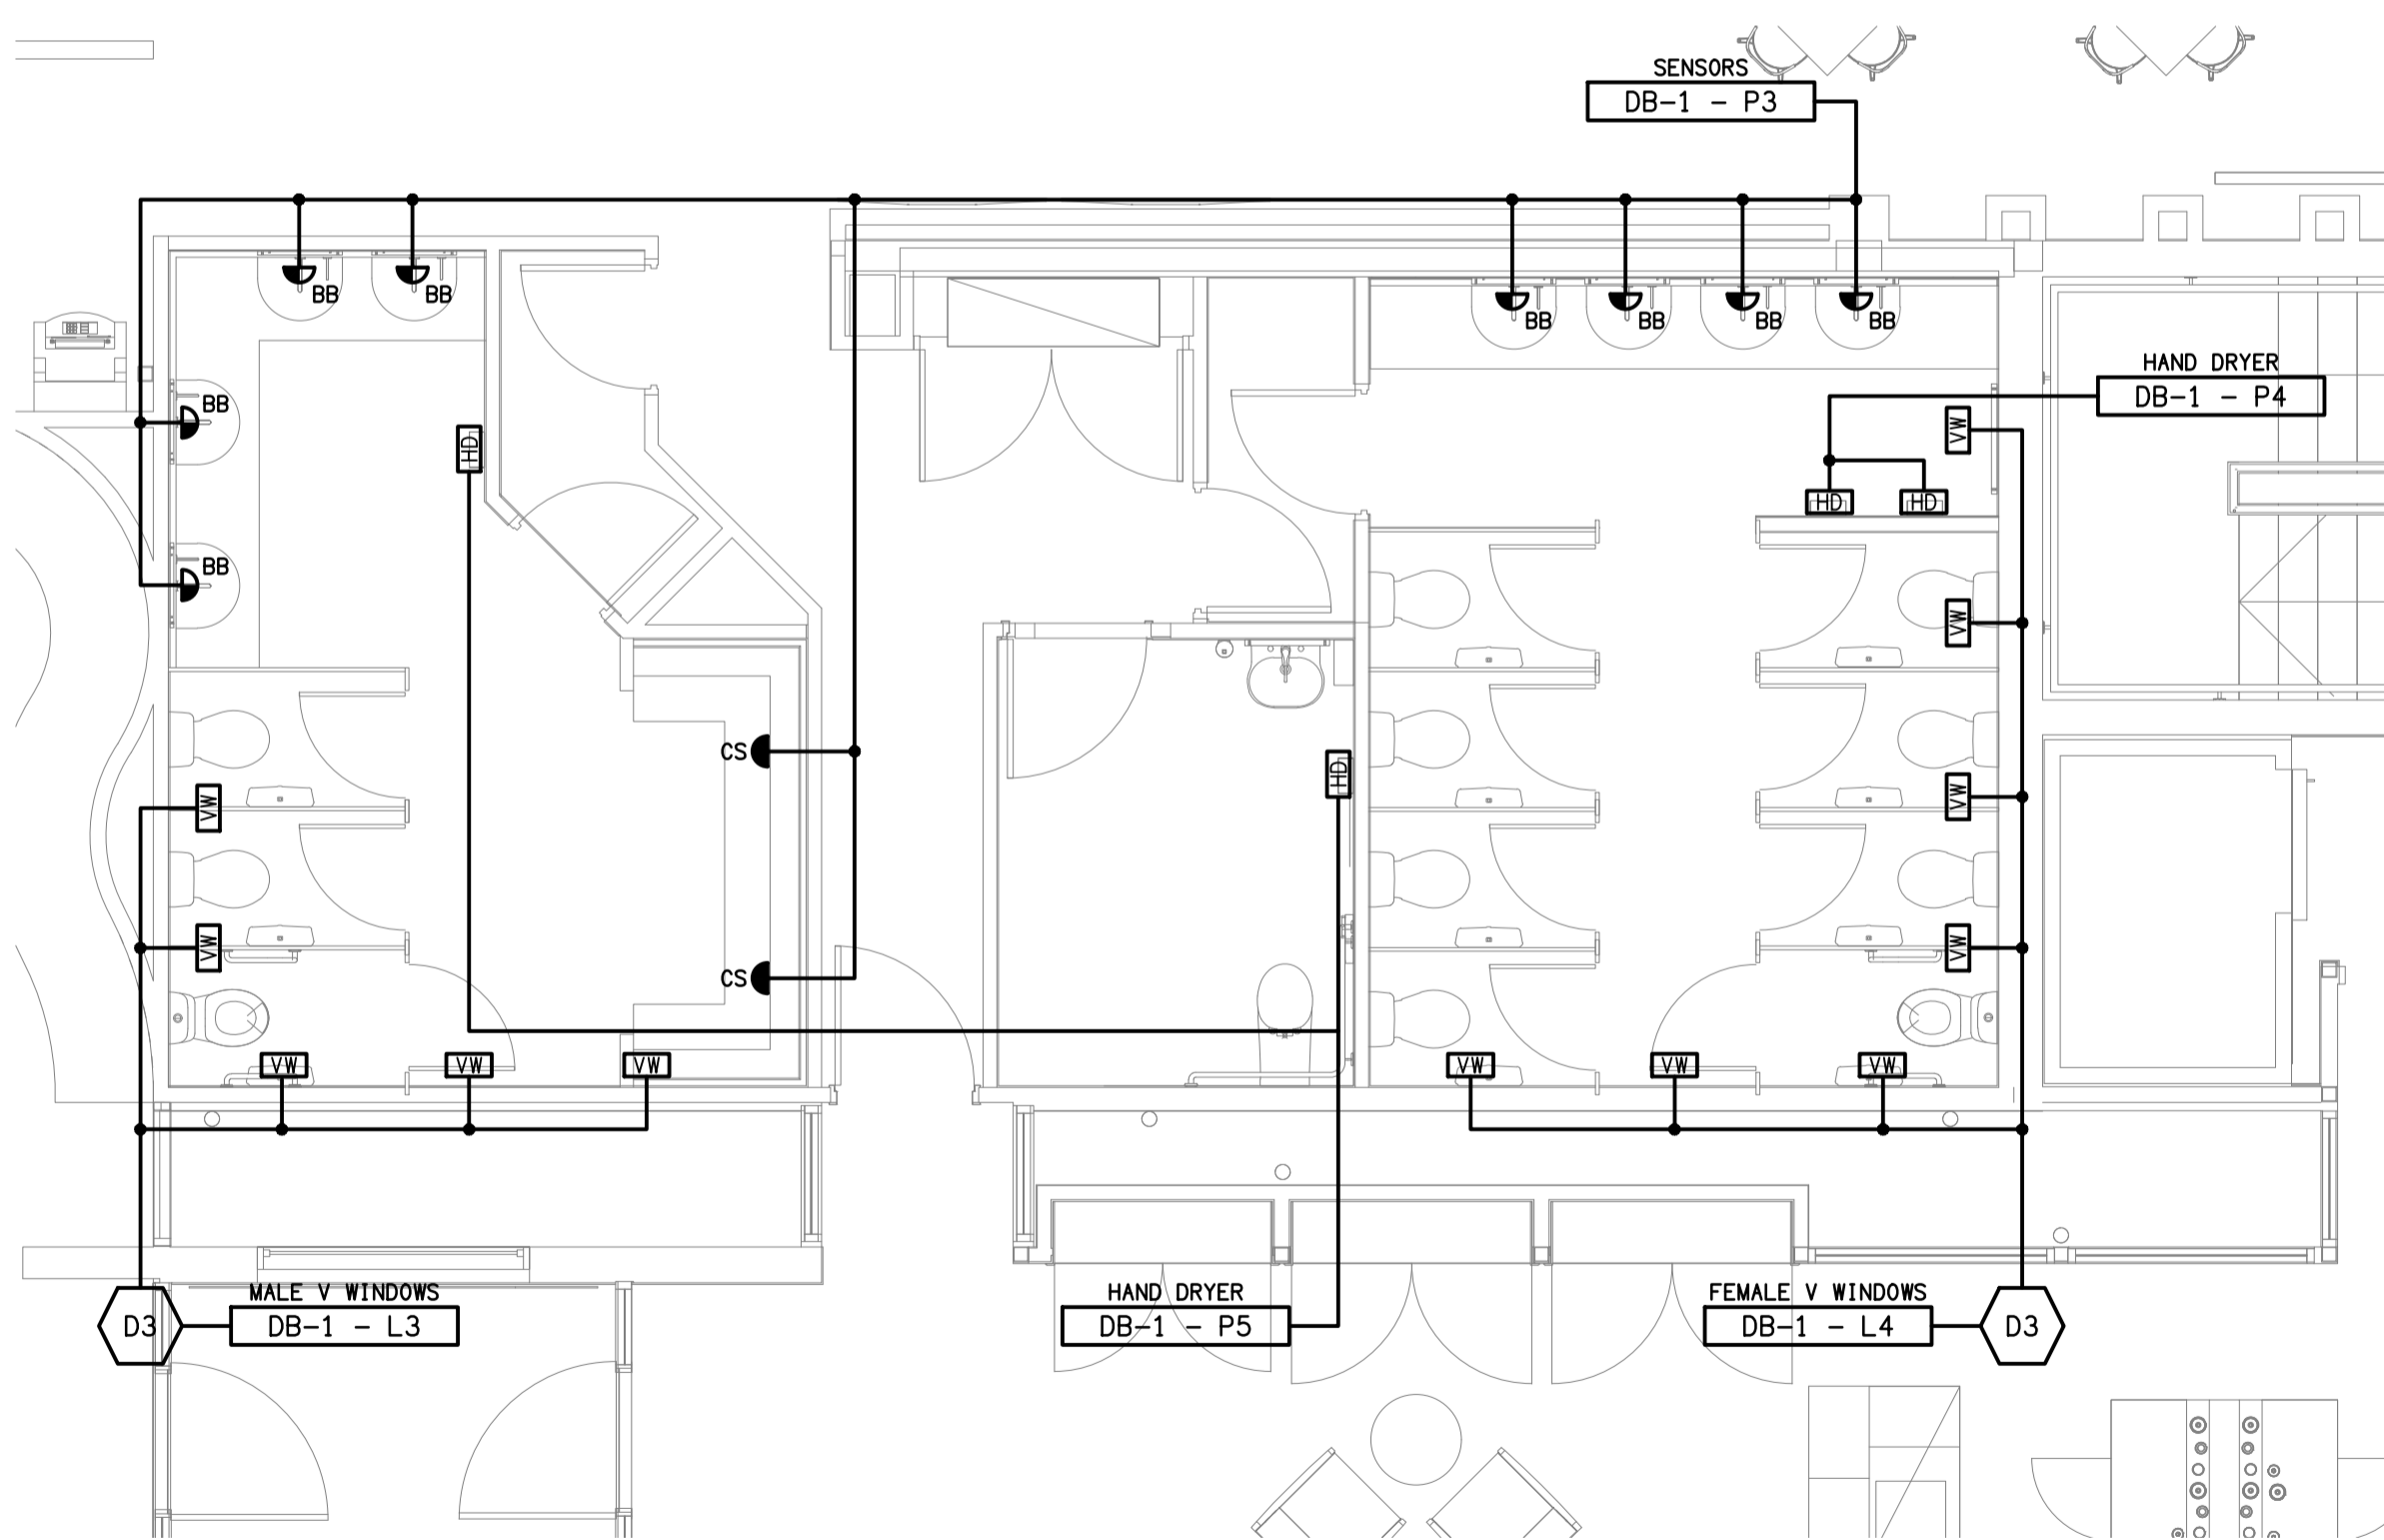

**ZONE 3**  
RESTAURANT AMENITIES FLOOR PLAN  
SCALE 1: 50

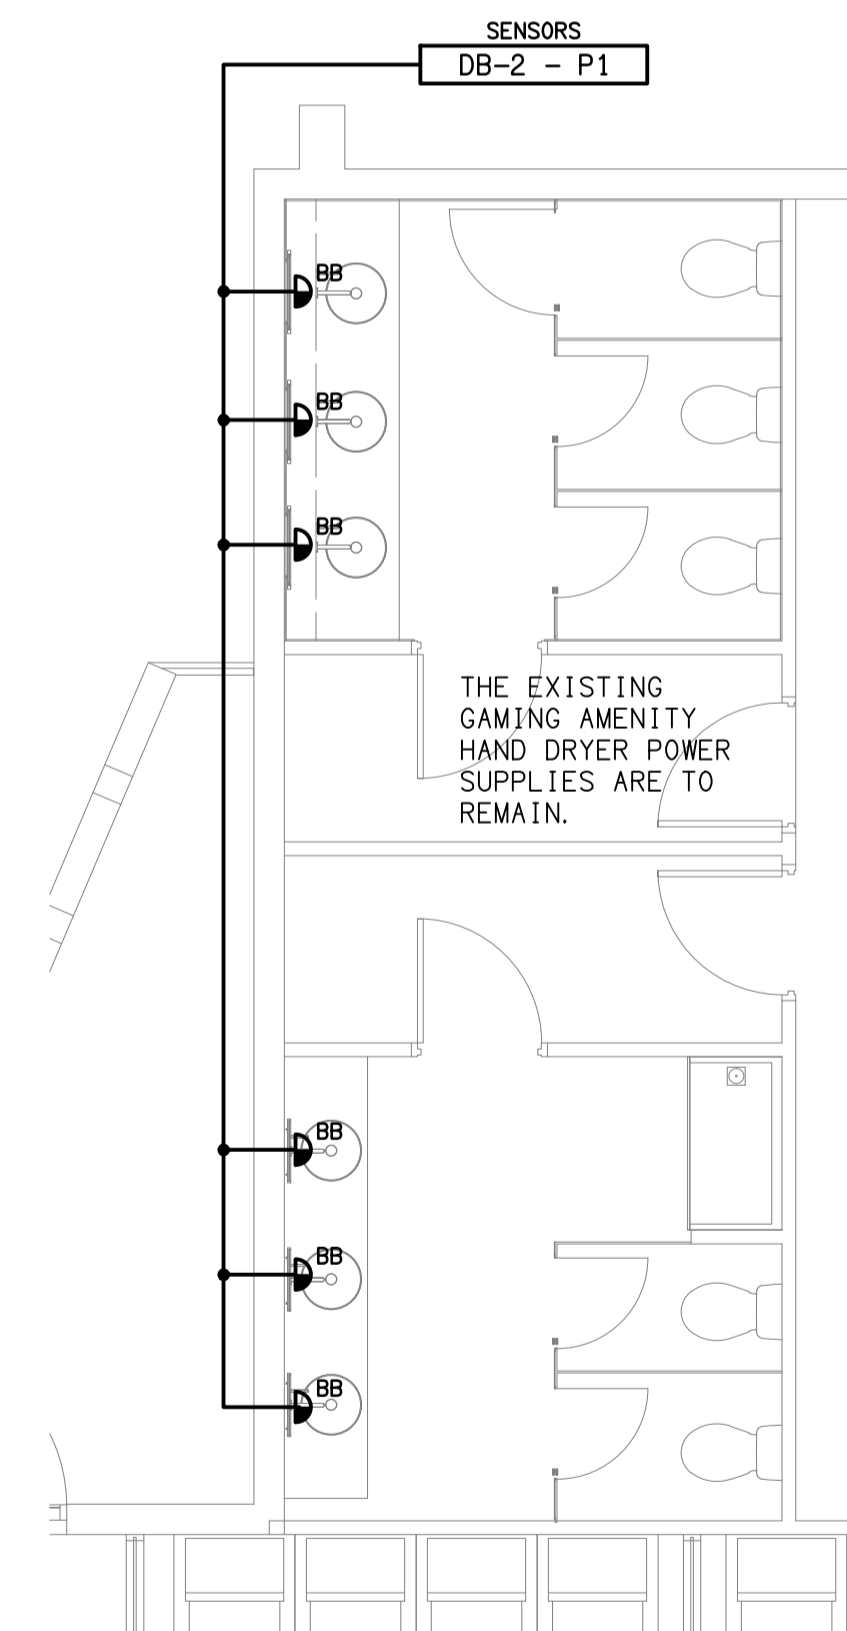

**ZONE 4**  
GAMING AMENITIES FLOOR PLAN  
SCALE 1: 50

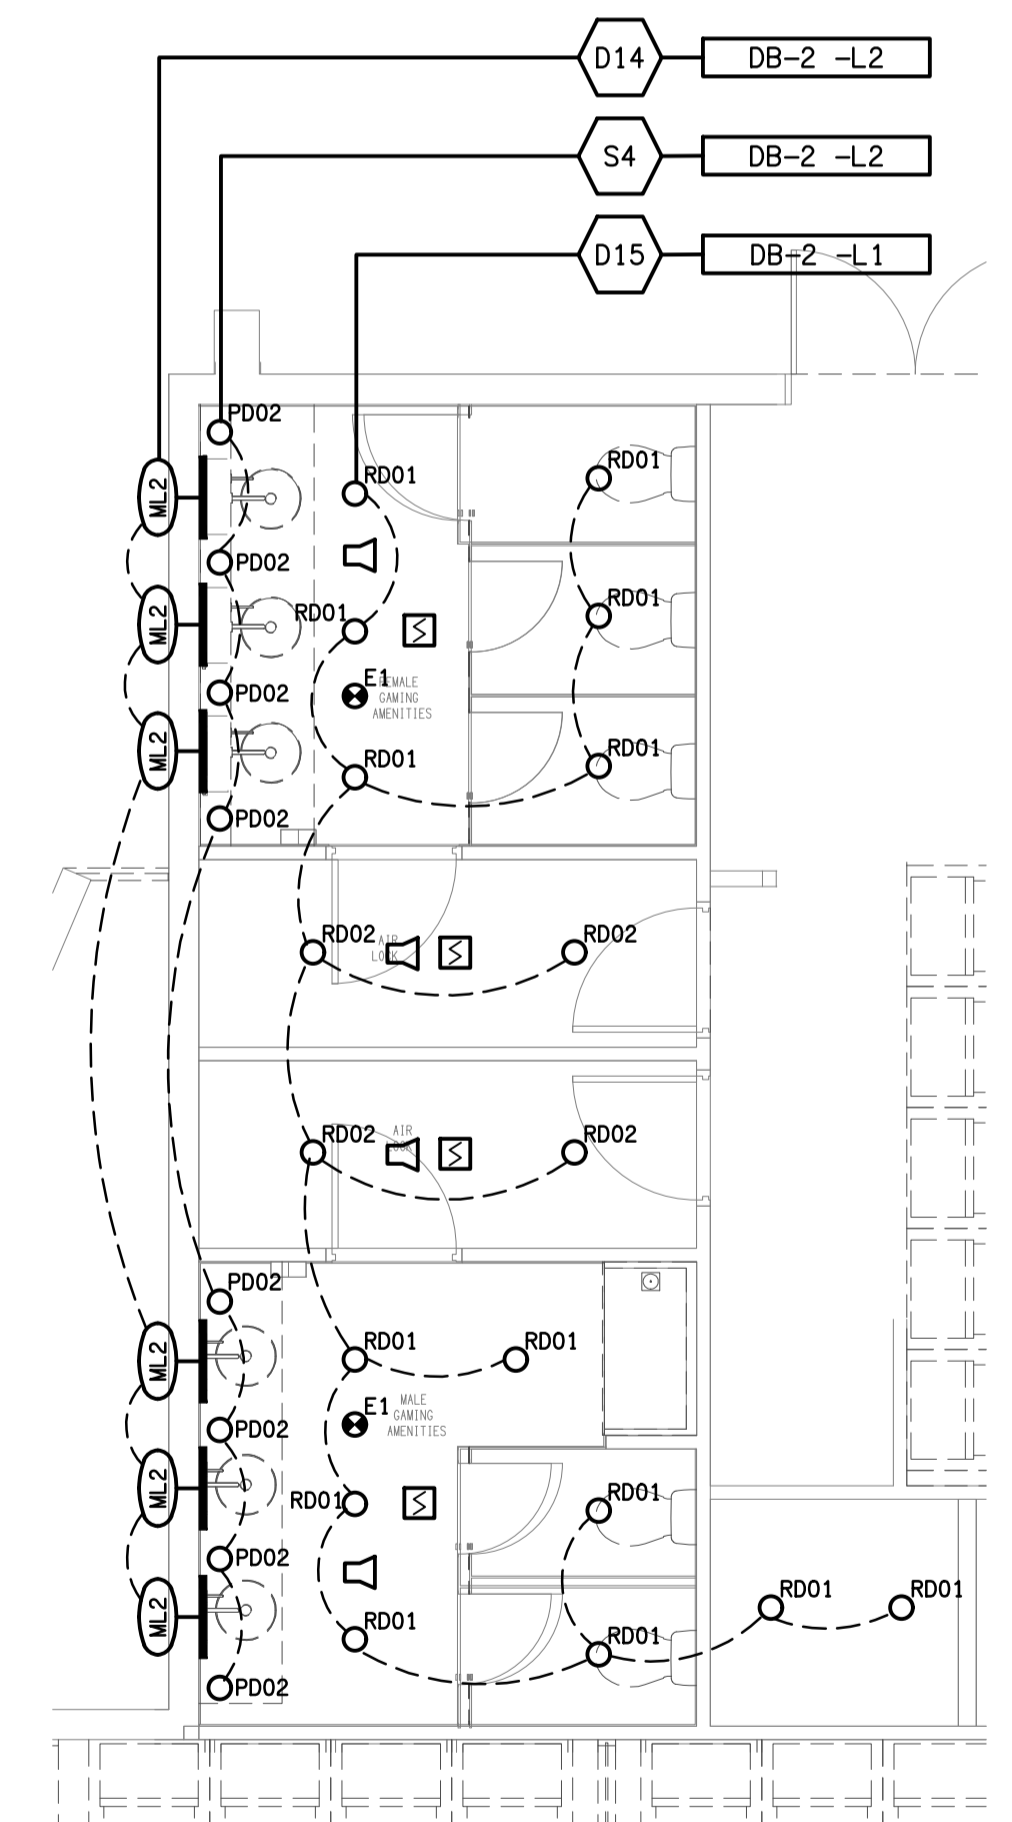

**ZONE 4**  
GAMING AMENITIES REFLECTED CEILING PLAN  
SCALE 1: 50

ELECTRICAL DESIGN GROUP BRISBANE  
PTY LTD  
ACN 092 710 793  
TRADING AS:  
ELECTRICAL DESIGN GROUP

THE COPYRIGHT OF THIS DRAWING  
REMAINS THE PROPERTY OF THE  
ELECTRICAL DESIGN GROUP.

USE FIGURED DIMENSIONS  
IN PREFERENCE TO SCALE.

ALL DIMENSIONS TO BE  
VERIFIED ONSITE.

**ELECTRICAL DESIGN GROUP**  
ELECTRICAL BUILDING SERVICES CONSULTANTS  
BRISBANE GOLD COAST

P.O. Box 15, Sherwood Q.4075  
Phone: (07) 3278 4375  
Email: brisbane@edg.net.au  
Web: www.edg.net.au

PROJECT:  
**THE LION RICHLANDS - MINOR PROJECTS**

133 PINE ROAD, RICHLANDS

A	PRELIMINARY	10/11/2023
REV.	DESCRIPTION:	DATE:

DRAWING:  
**ELECTRICAL SERVICES  
ZONE 3 & 4 PLANS**

SCALE:  
1:50

AT A1

PROJECT NO:  
**C3067a**

DRAWING NO:  
**E05**

REVISION:  
**A**