




**DETAIL F**  
BEER GARDEN SECTION  
NOT TO SCALE

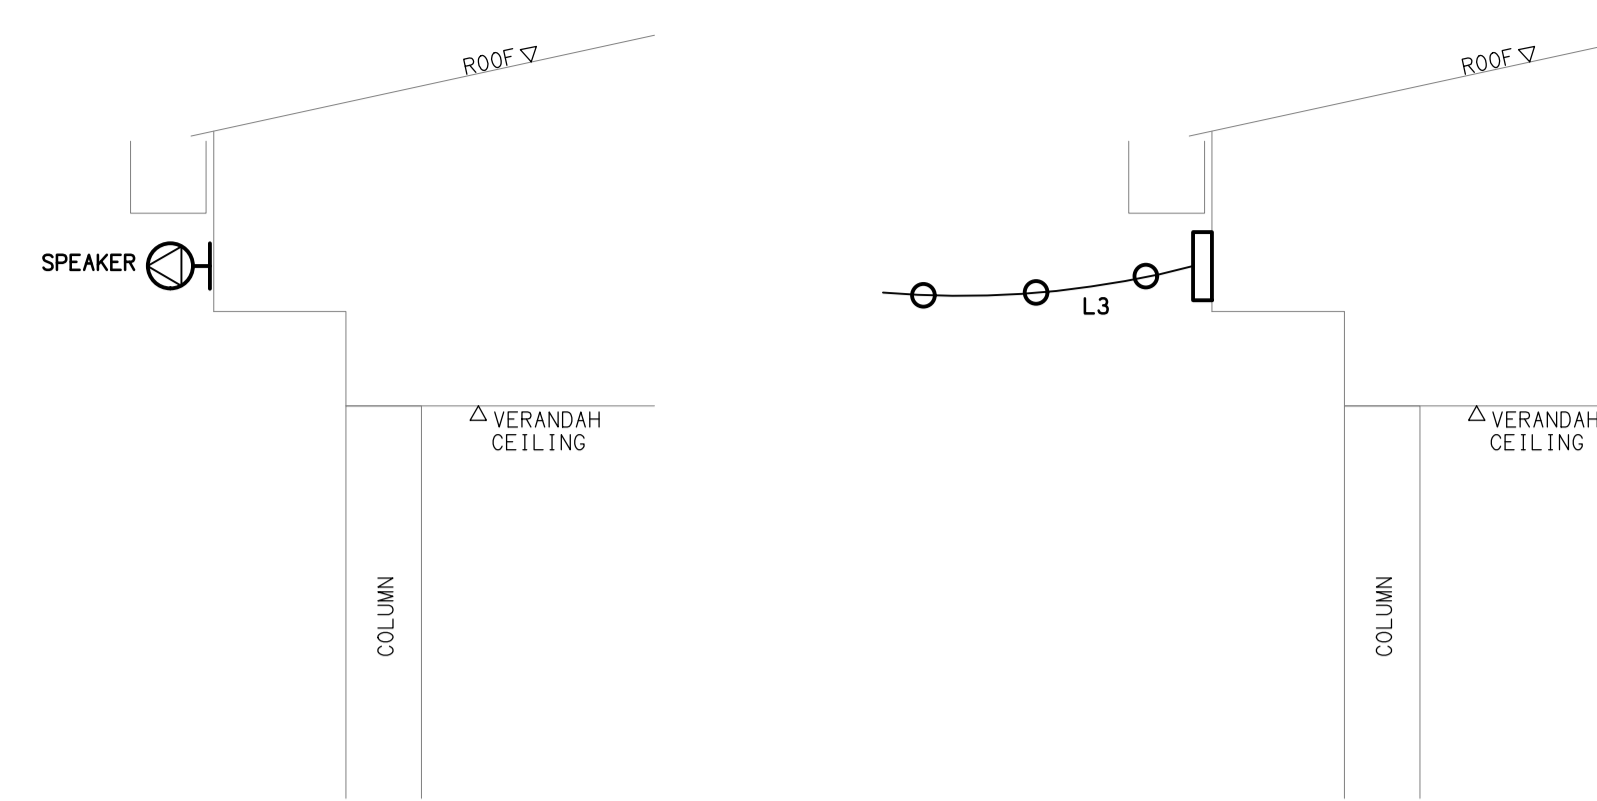



**DETAIL B**  
EXTERNAL SPEAKER MOUNTING  
NOT TO SCALE

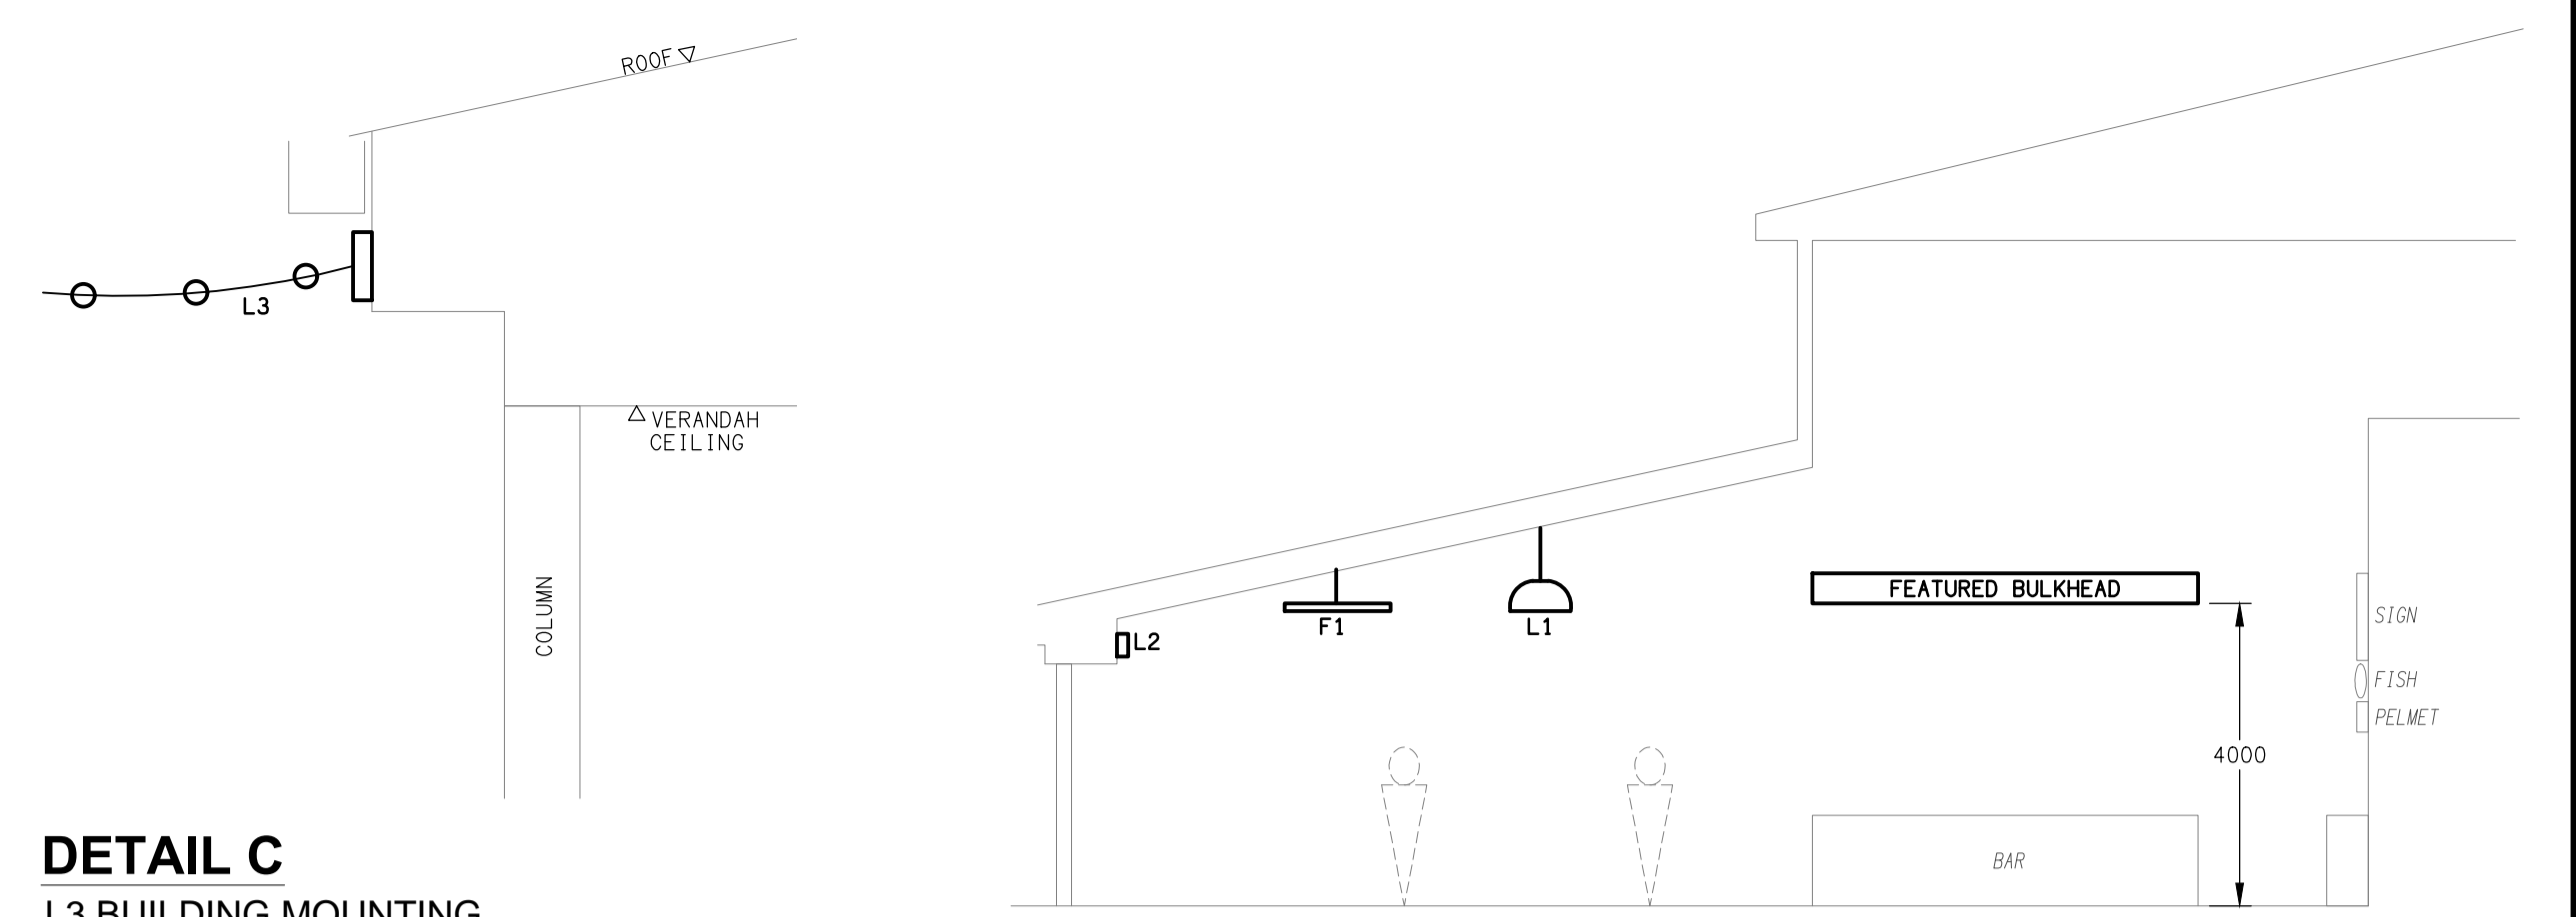


**DETAIL C**  
L3 BUILDING MOUNTING  
NOT TO SCALE

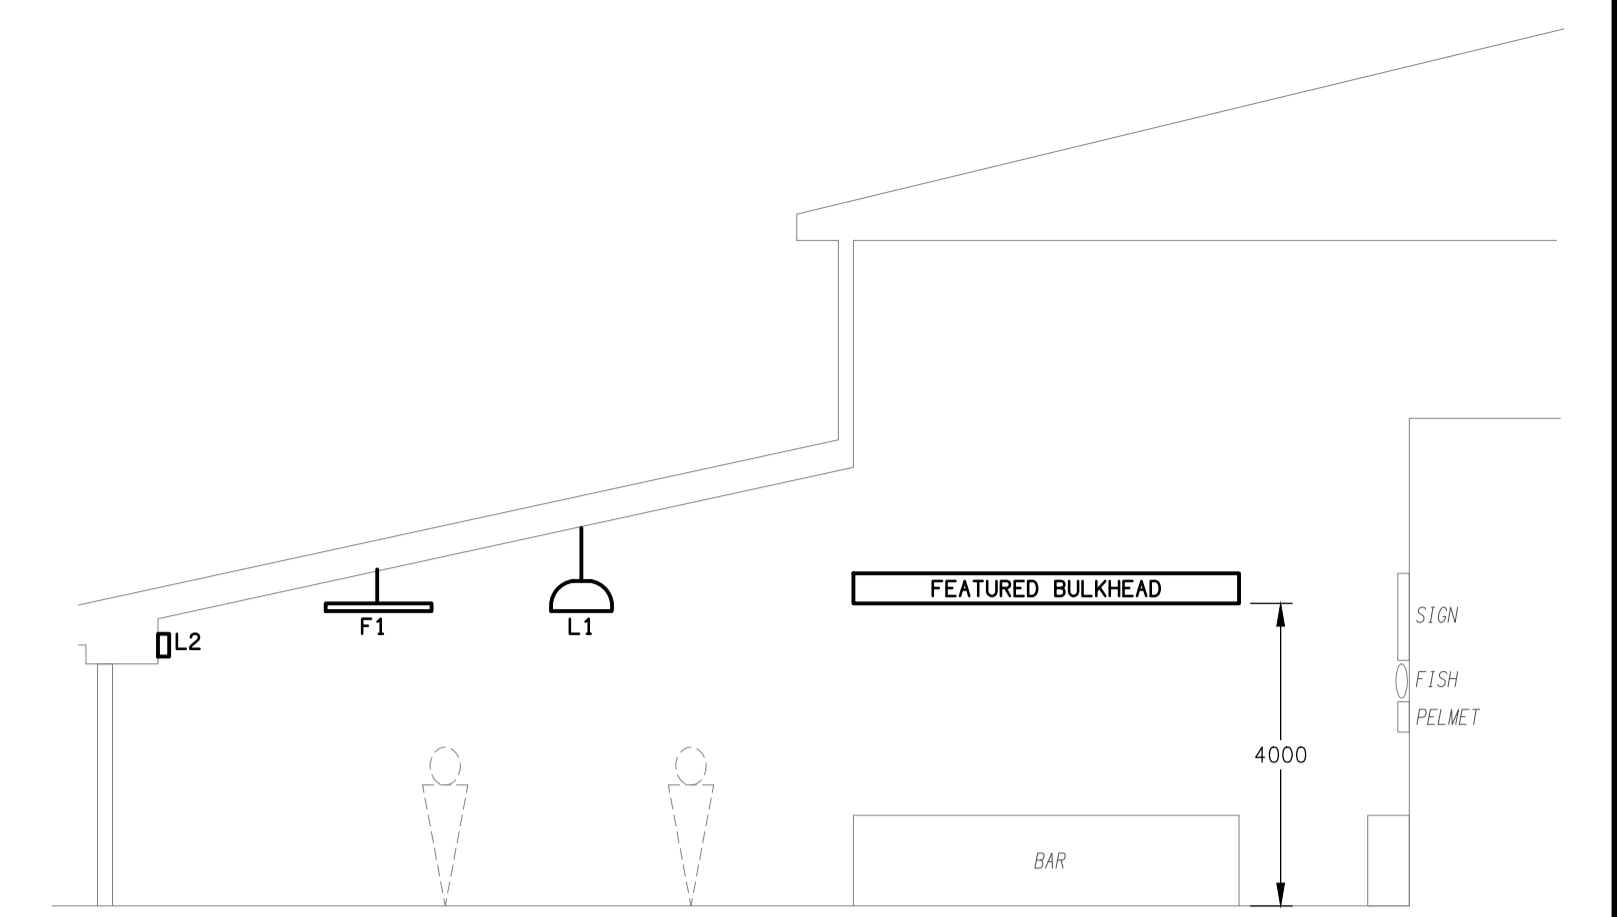

**DETAIL A**  
TAVERN LOUNGE SECTION  
NOT TO SCALE

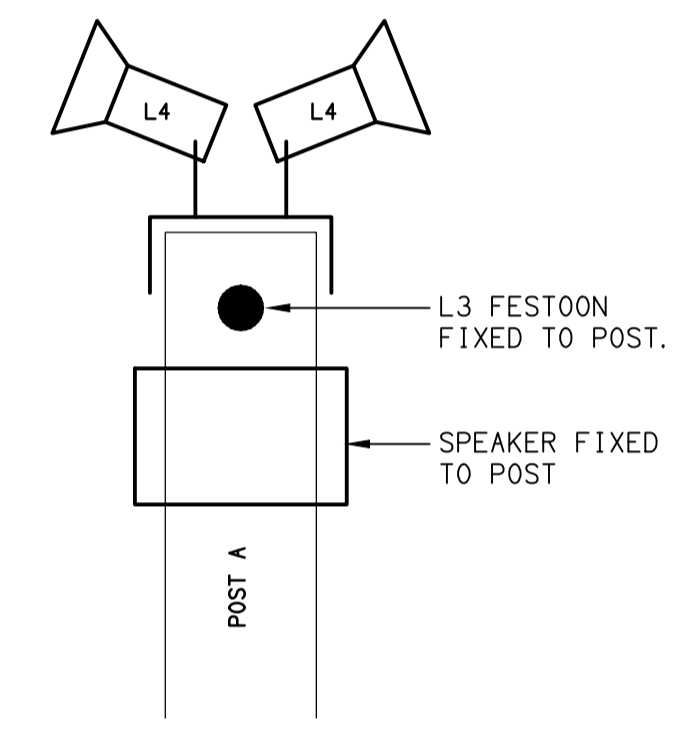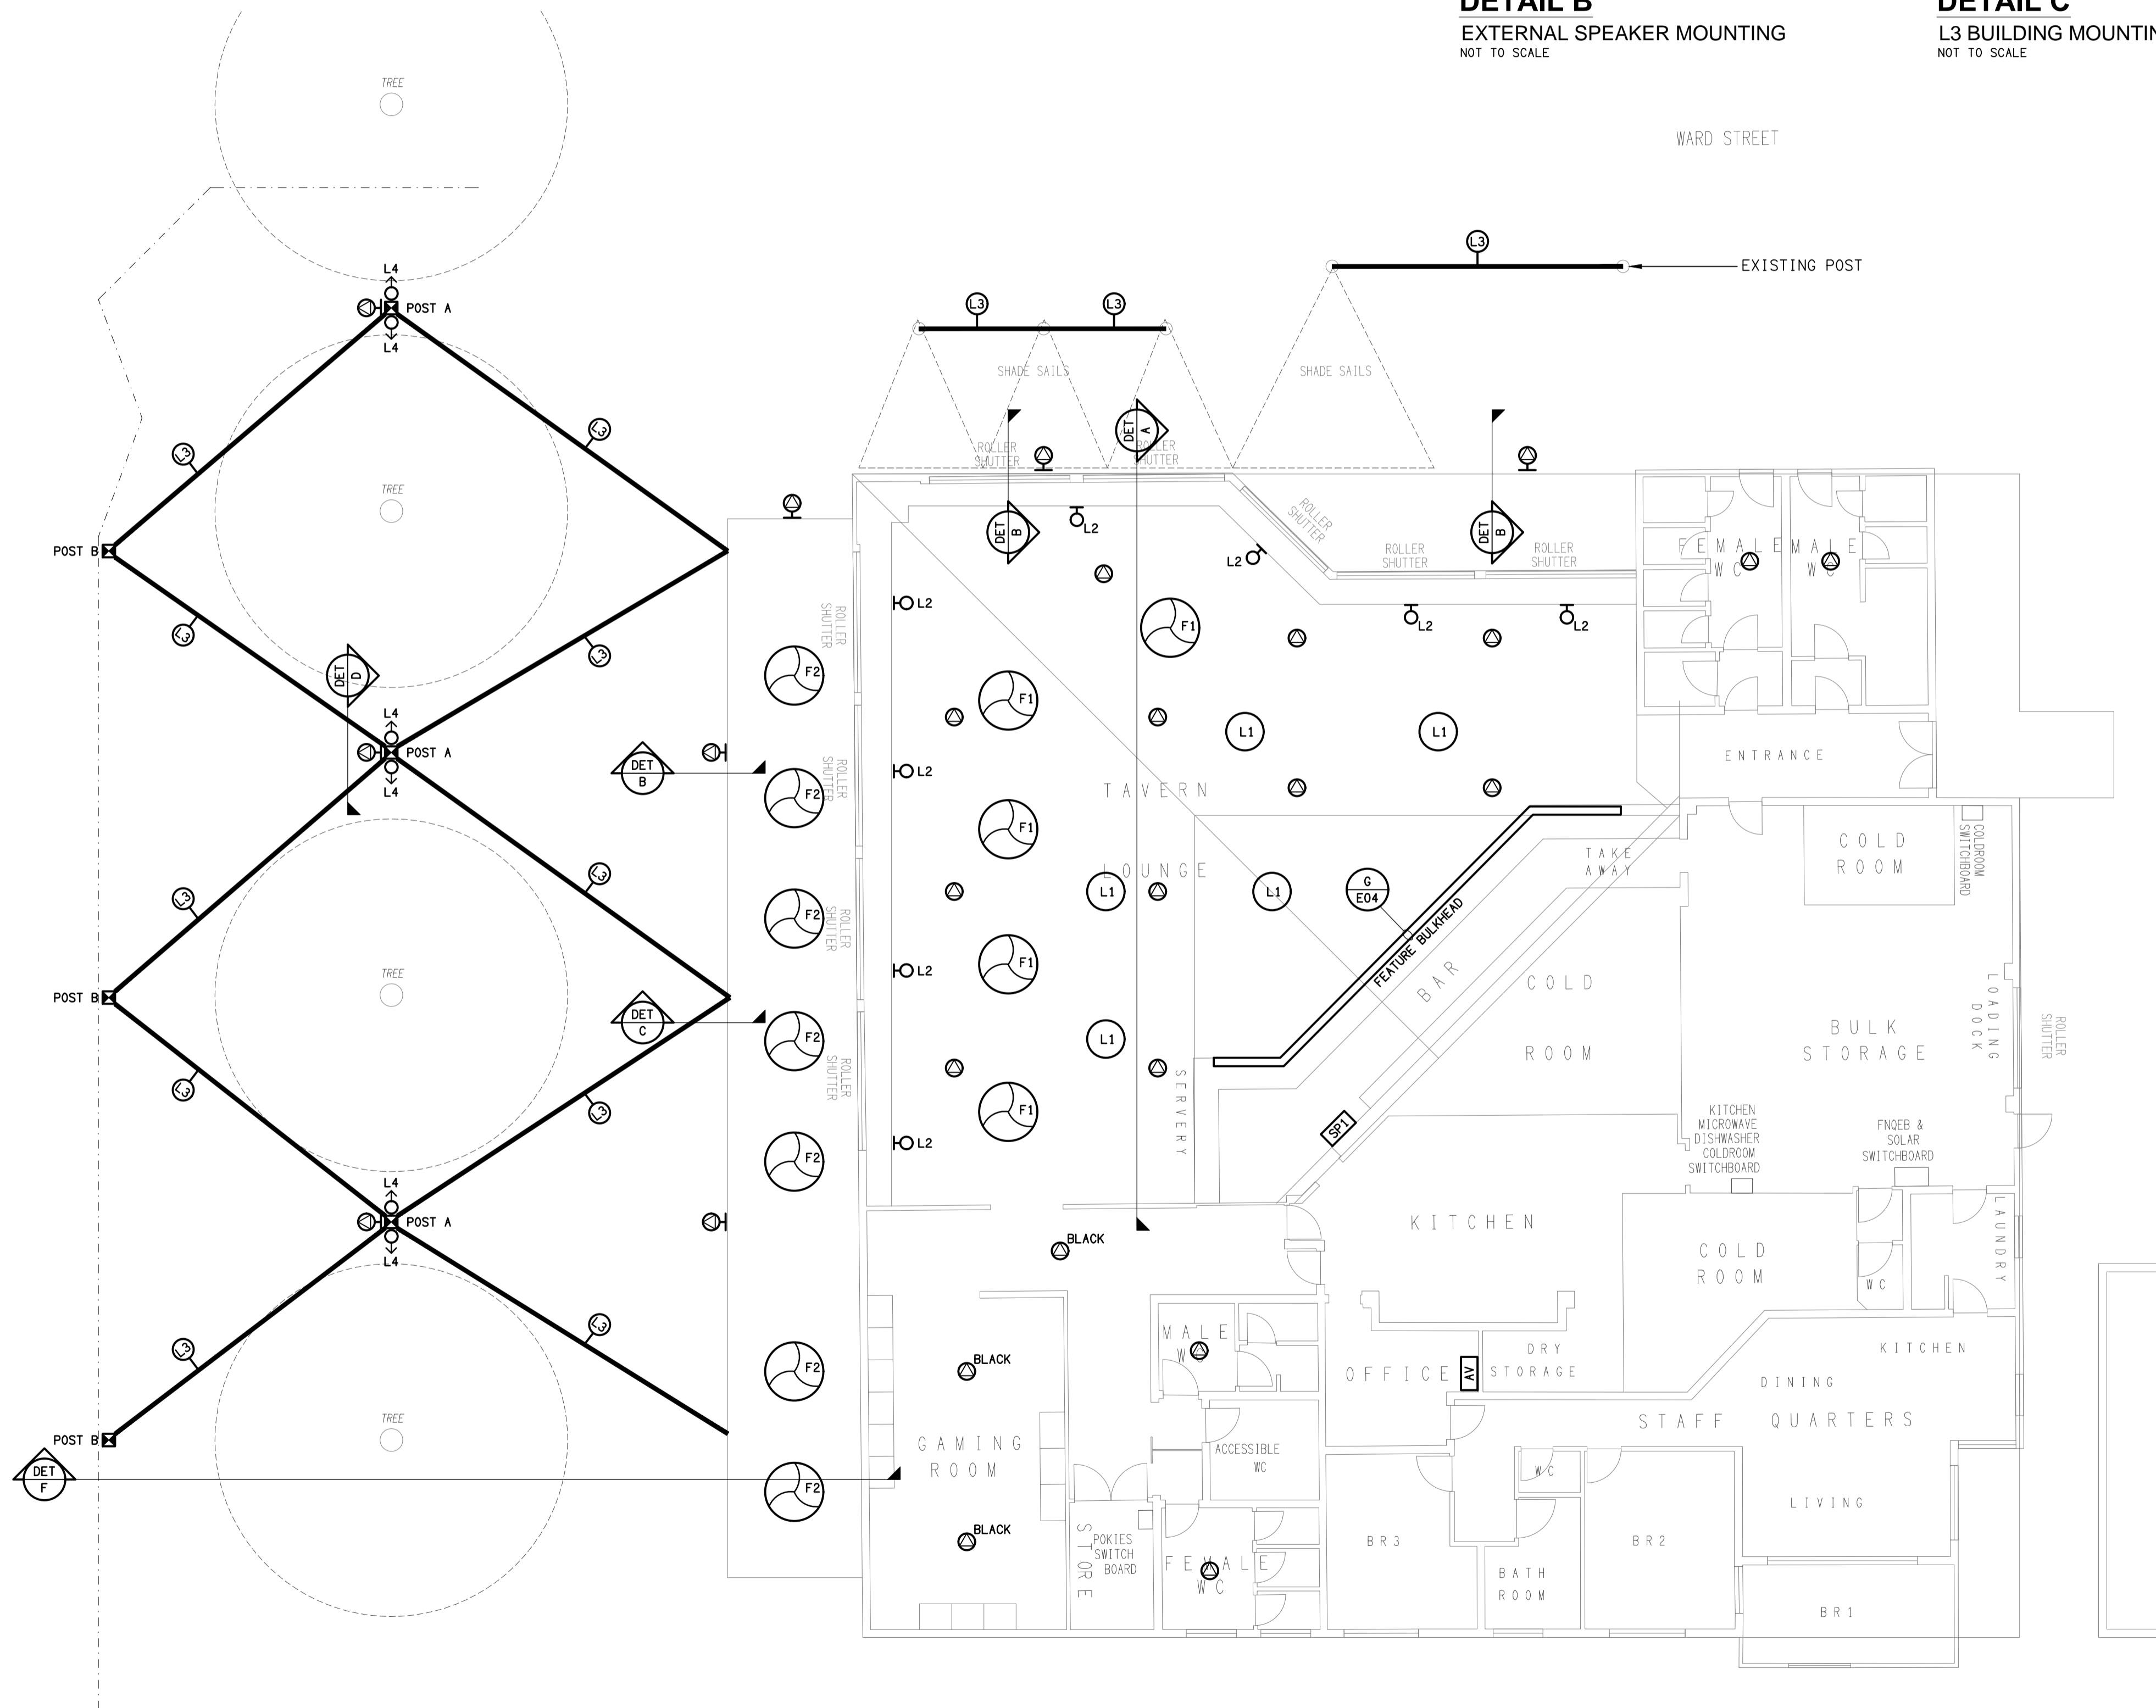

**DETAIL E**  
L3 & L4 MOUNTINGS  
NOT TO SCALE

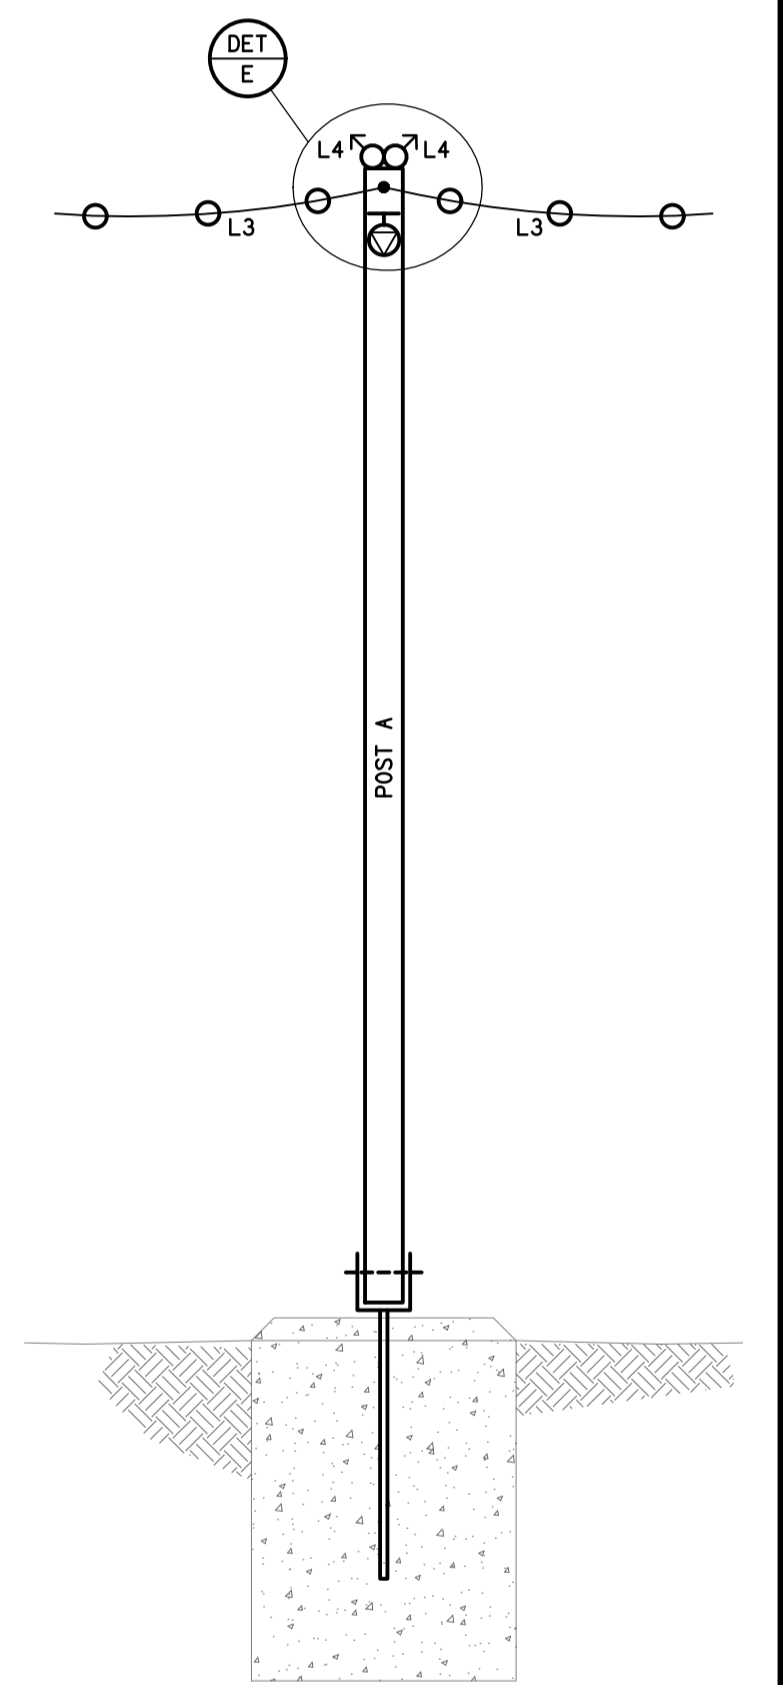

**DETAIL D**  
POST A ELEVATION  
NOT TO SCALE

ELECTRICAL DESIGN GROUP BRISBANE  
PTY LTD  
ACN 092 710 793  
TRADING AS:  
ELECTRICAL DESIGN GROUP

THE COPYRIGHT OF THIS DRAWING  
REMAINS THE PROPERTY OF THE  
ELECTRICAL DESIGN GROUP.  
USE FIGURED DIMENSIONS  
IN PREFERENCE TO SCALE.  
ALL DIMENSIONS TO BE  
VERIFIED ONSITE.

**ELECTRICAL DESIGN GROUP**  
ELECTRICAL BUILDING SERVICES CONSULTANTS  
BRISBANE GOLD COAST

P.O. Box 15, Sherwood Q.4075  
Phone: (07) 3278 4375  
Email: brisbane@edg.net.au  
Web: www.edg.net.au

PROJECT:  
**SUNSET TAVERN, KARUMBA - LIGHTING & AV**

2 WARD STREET, KARUMBA, QUEENSLAND

A	INFORMATION	04/08/2023
REV.	DESCRIPTION:	DATE:

DRAWING:  
**ELECTRICAL SERVICES  
PROPOSED LIGHTING PLAN**

SCALE:  
1:100

AT A1

PROJECT NO:  
**C3086a**

DRAWING NO:  
**E03**

REVISION:  
**A**