



**SITE PLAN**  
ELECTRICAL PLANT  
SCALE 1:2000

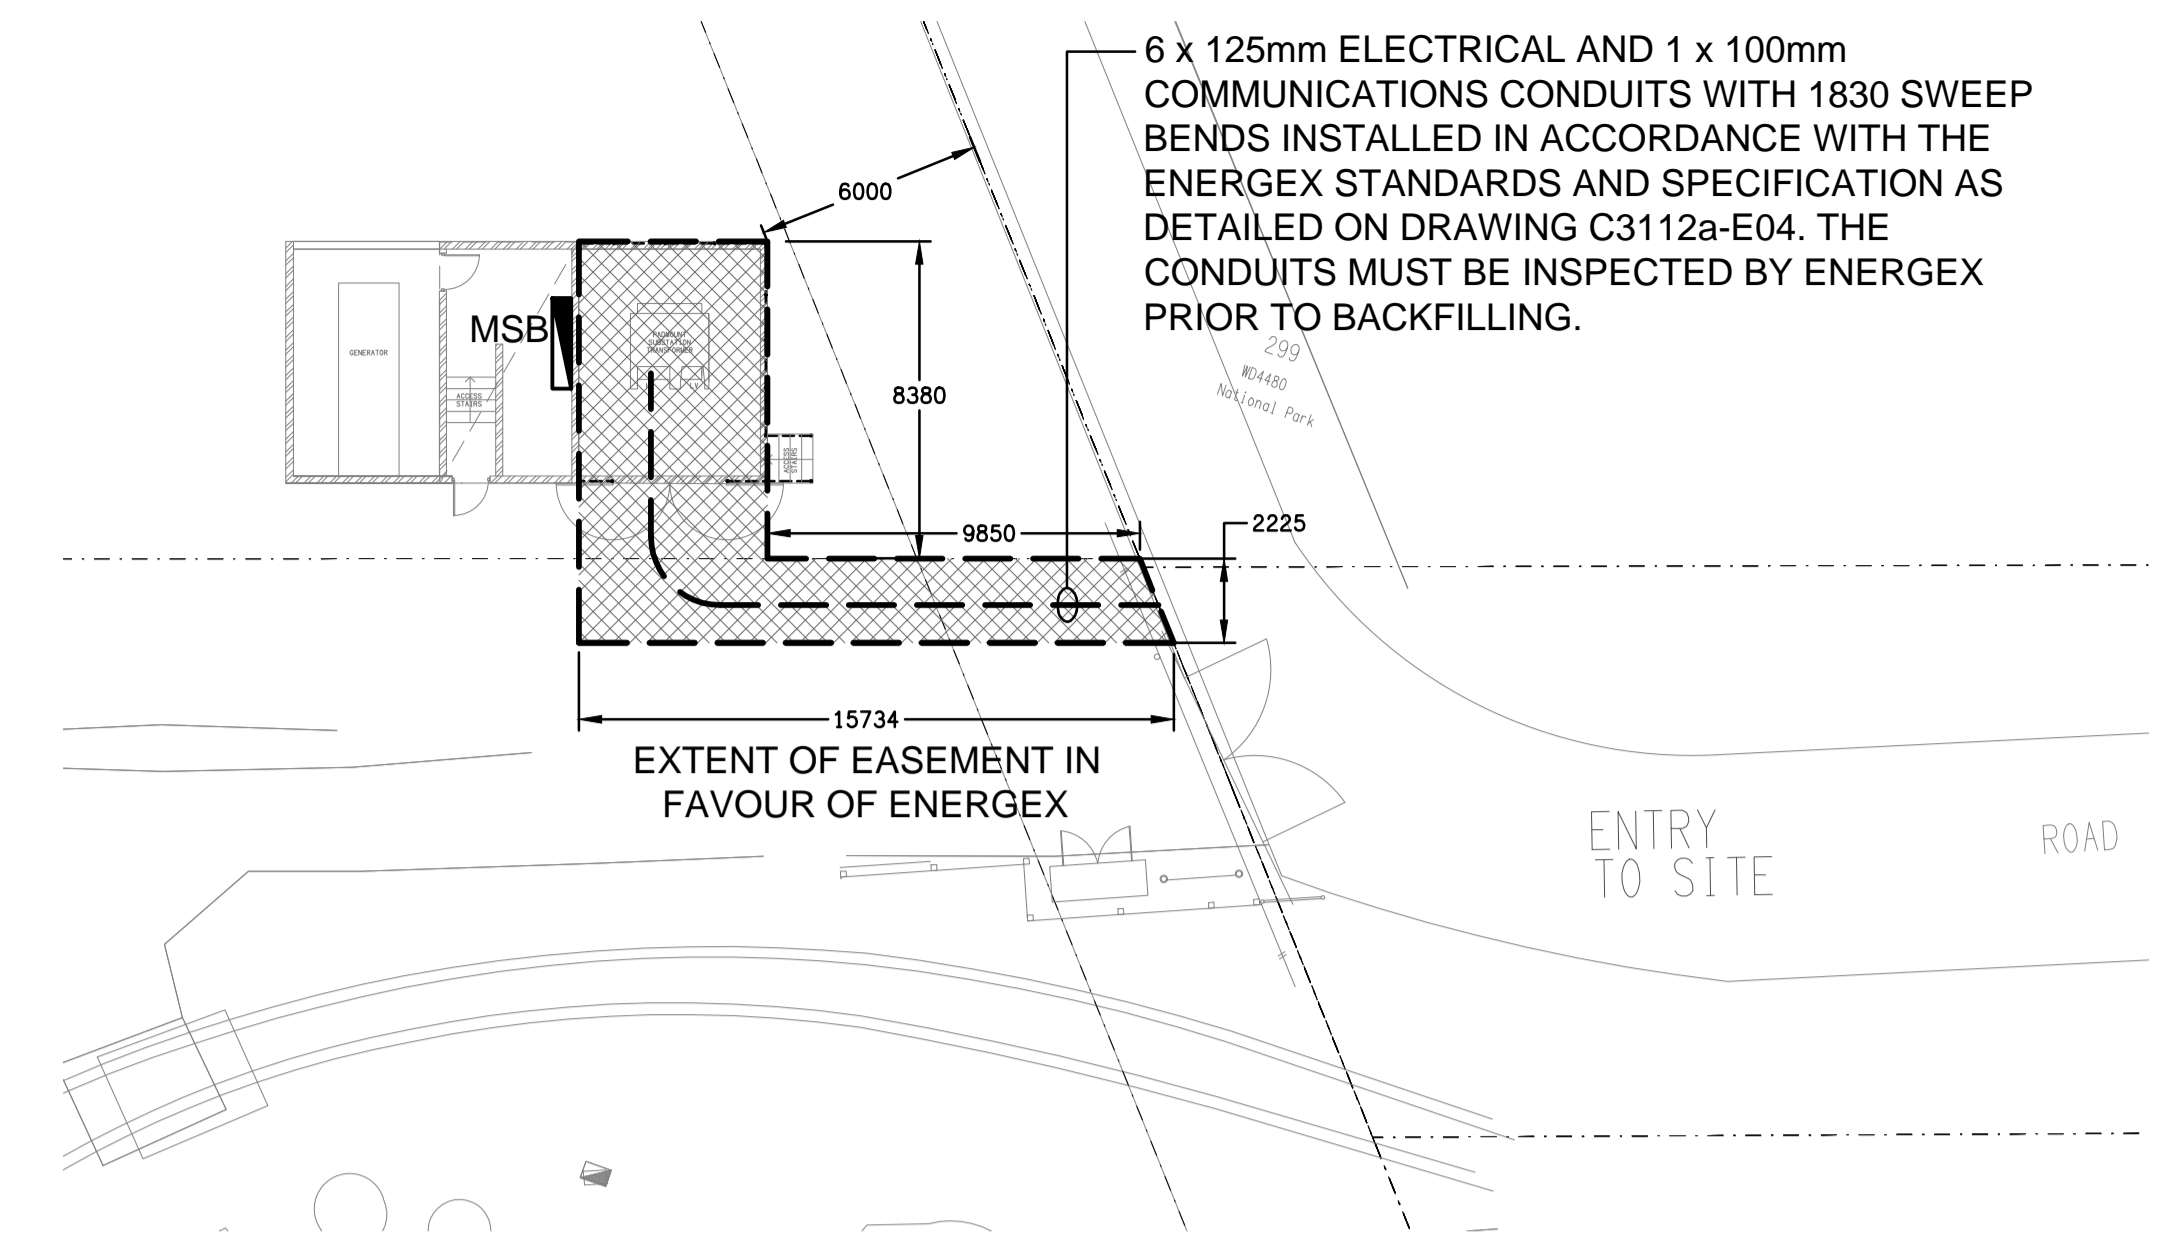

**DETAILED PLAN**  
ENERGEX EASEMENT  
SCALE 1:200

ENERGEX ACCEPTANCE 

NAME .....

OFFICE .....

SIGNED .....

DATE / /

ENERGEX takes no responsibility for the accuracy of the information provided on this drawing



D	CONSTRUCTION	18/01/2024
REV:	DESCRIPTION:	DATE:

ELECTRICAL DESIGN GROUP BRISBANE PTY LTD  
ACN 092 710 793  
TRADING AS:  
ELECTRICAL DESIGN GROUP

THE COPYRIGHT OF THIS DRAWING REMAINS THE PROPERTY OF THE ELECTRICAL DESIGN GROUP.  
USE FIGURED DIMENSIONS IN PREFERENCE TO SCALE.  
ALL DIMENSIONS TO BE VERIFIED ONSITE.

CULVERT INSPECTION REQUIRED BEFORE TRANSFORMER IS DELIVERED - 5 BUSINESS DAYS PRIOR NOTICE NEEDED.  
CONTACT \_\_\_\_\_ PH: \_\_\_\_\_ EMAIL: \_\_\_\_\_  
TRANSFORMER WILL NOT BE ENERGISED UNTIL ALL REQUIREMENTS ARE MET.

**ELECTRICAL DESIGN GROUP**  
ELECTRICAL BUILDING SERVICES CONSULTANTS  
BRISBANE GOLD COAST  
P.O. Box 15, Sherwood Q.4075  
Phone: (07) 3278 4375  
Email: brisbane@edg.net.au  
Web: www.edg.net.au

PROJECT:  
**CURRUMBIN WILDLIFE SANCTUARY SITE MSB**  
28 TOMEWIN STREET, CURRUMBIN, QUEENSLAND

DRAWING:  
**ELECTRICAL SERVICES SITE PLAN ENERGEX EASEMENT**  
SCALE: AS SHOWN AT A1  
PROJECT NO: **C3112a**  
DRAWING NO: **E02**  
REVISION: **D**