


EXISTING ELECTRICAL SERVICES OUTSIDE OF THIS DASH LINED AREA ARE TO REMAIN AS IS, UNLESS NOTED OTHERWISE.

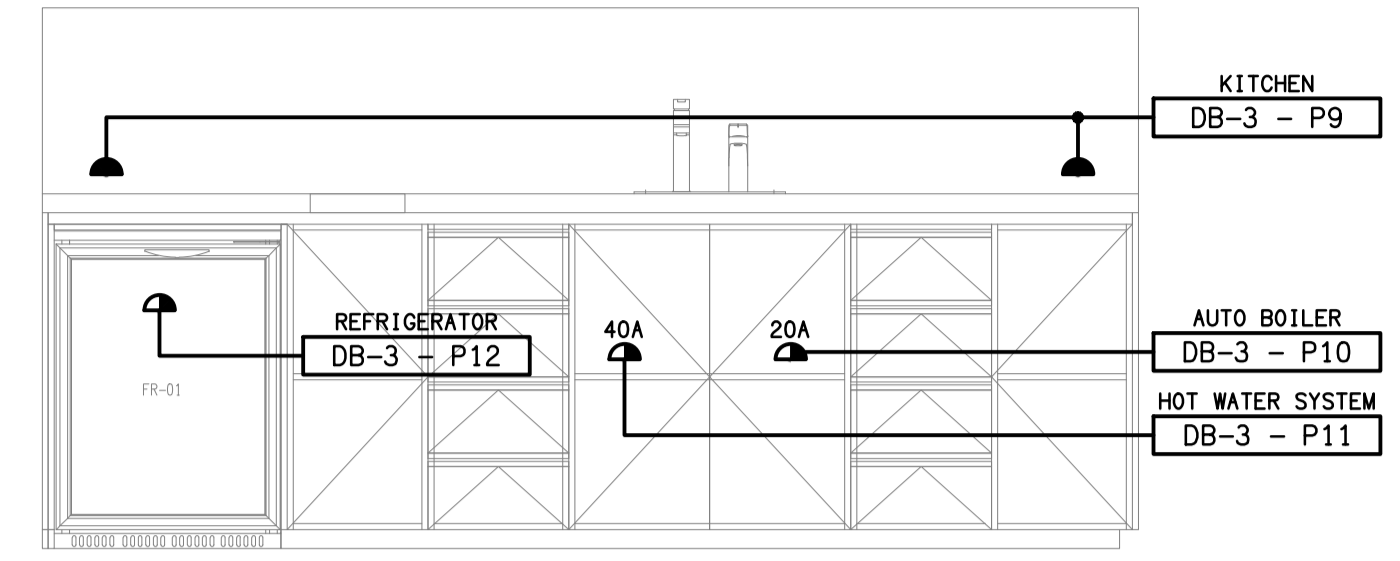

DETAIL A
CUSTOMER KITCHENETTE ELEVATION
SCALE 1: 20

ELECTRICAL DESIGN GROUP BRISBANE PTY LTD
ACN 092 710 793
TRADING AS:
ELECTRICAL DESIGN GROUP

THE COPYRIGHT OF THIS DRAWING REMAINS THE PROPERTY OF THE ELECTRICAL DESIGN GROUP.
USE FIGURED DIMENSIONS IN PREFERENCE TO SCALE.
ALL DIMENSIONS TO BE VERIFIED ONSITE.

ELECTRICAL DESIGN GROUP
ELECTRICAL BUILDING SERVICES CONSULTANTS
BRISBANE GOLD COAST
P.O. Box 15, Sherwood Q.4075
Phone: (07) 3278 4375
Email: brisbane@edg.net.au
Web: www.edg.net.au

PROJECT:
NISSAN - IPSWICH
5 BRISBANE ROAD, BUNDAMBA, QUEENSLAND

C	TENDER	20/10/2023
REV.	DESCRIPTION:	DATE:
DRAWING: ELECTRICAL SERVICES FLOOR PLAN		
SCALE: 1:100 UNO	AT A1	PROJECT NO: C3117a
		DRAWING NO: E03
		REVISION: C