

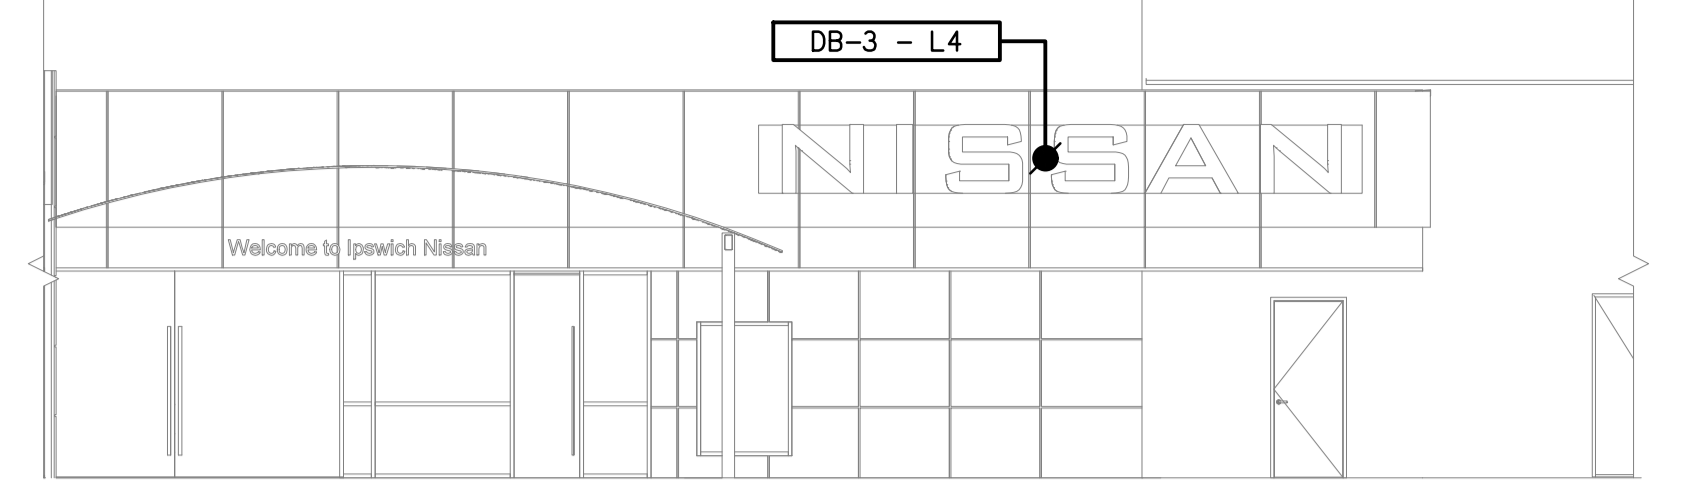


CUSTOMER ENTRY WEST
EXTERNAL BUILDING ELEVATION
SCALE 1:100

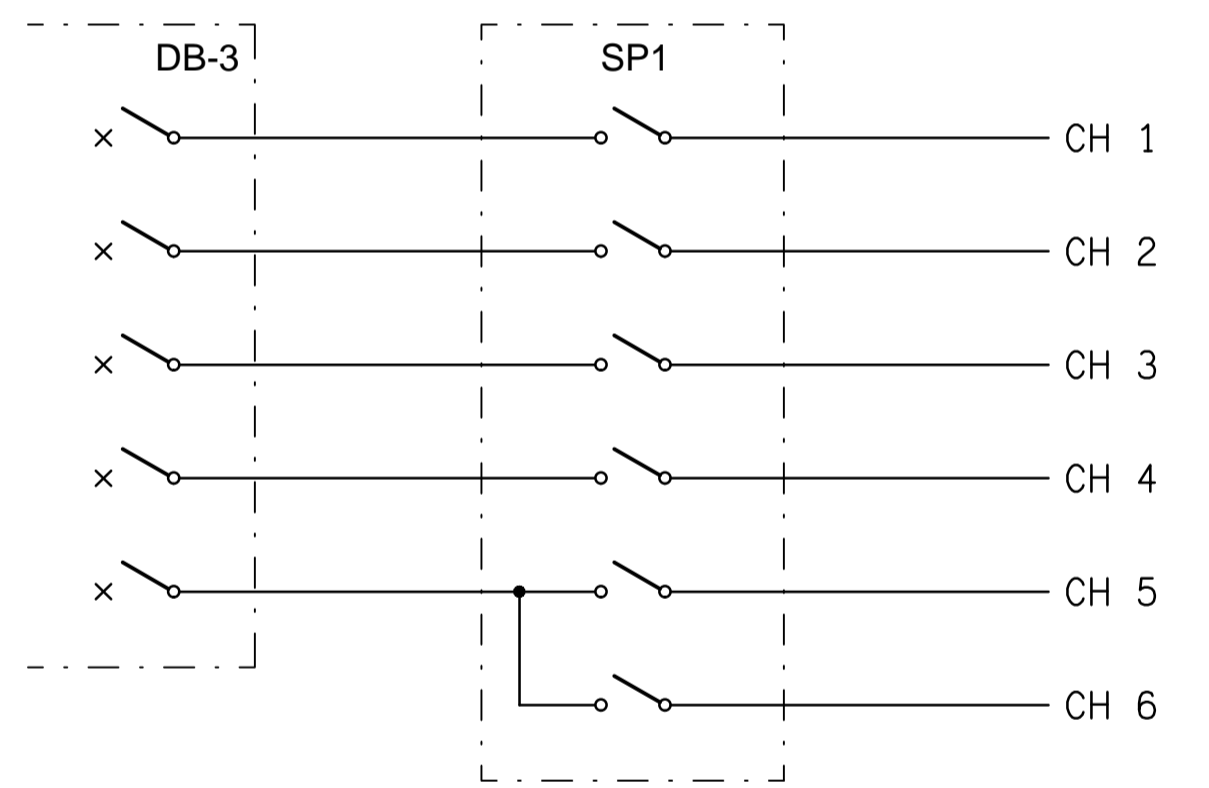

NISSAN SOUTH
EXTERNAL BUILDING ELEVATION
SCALE 1:100

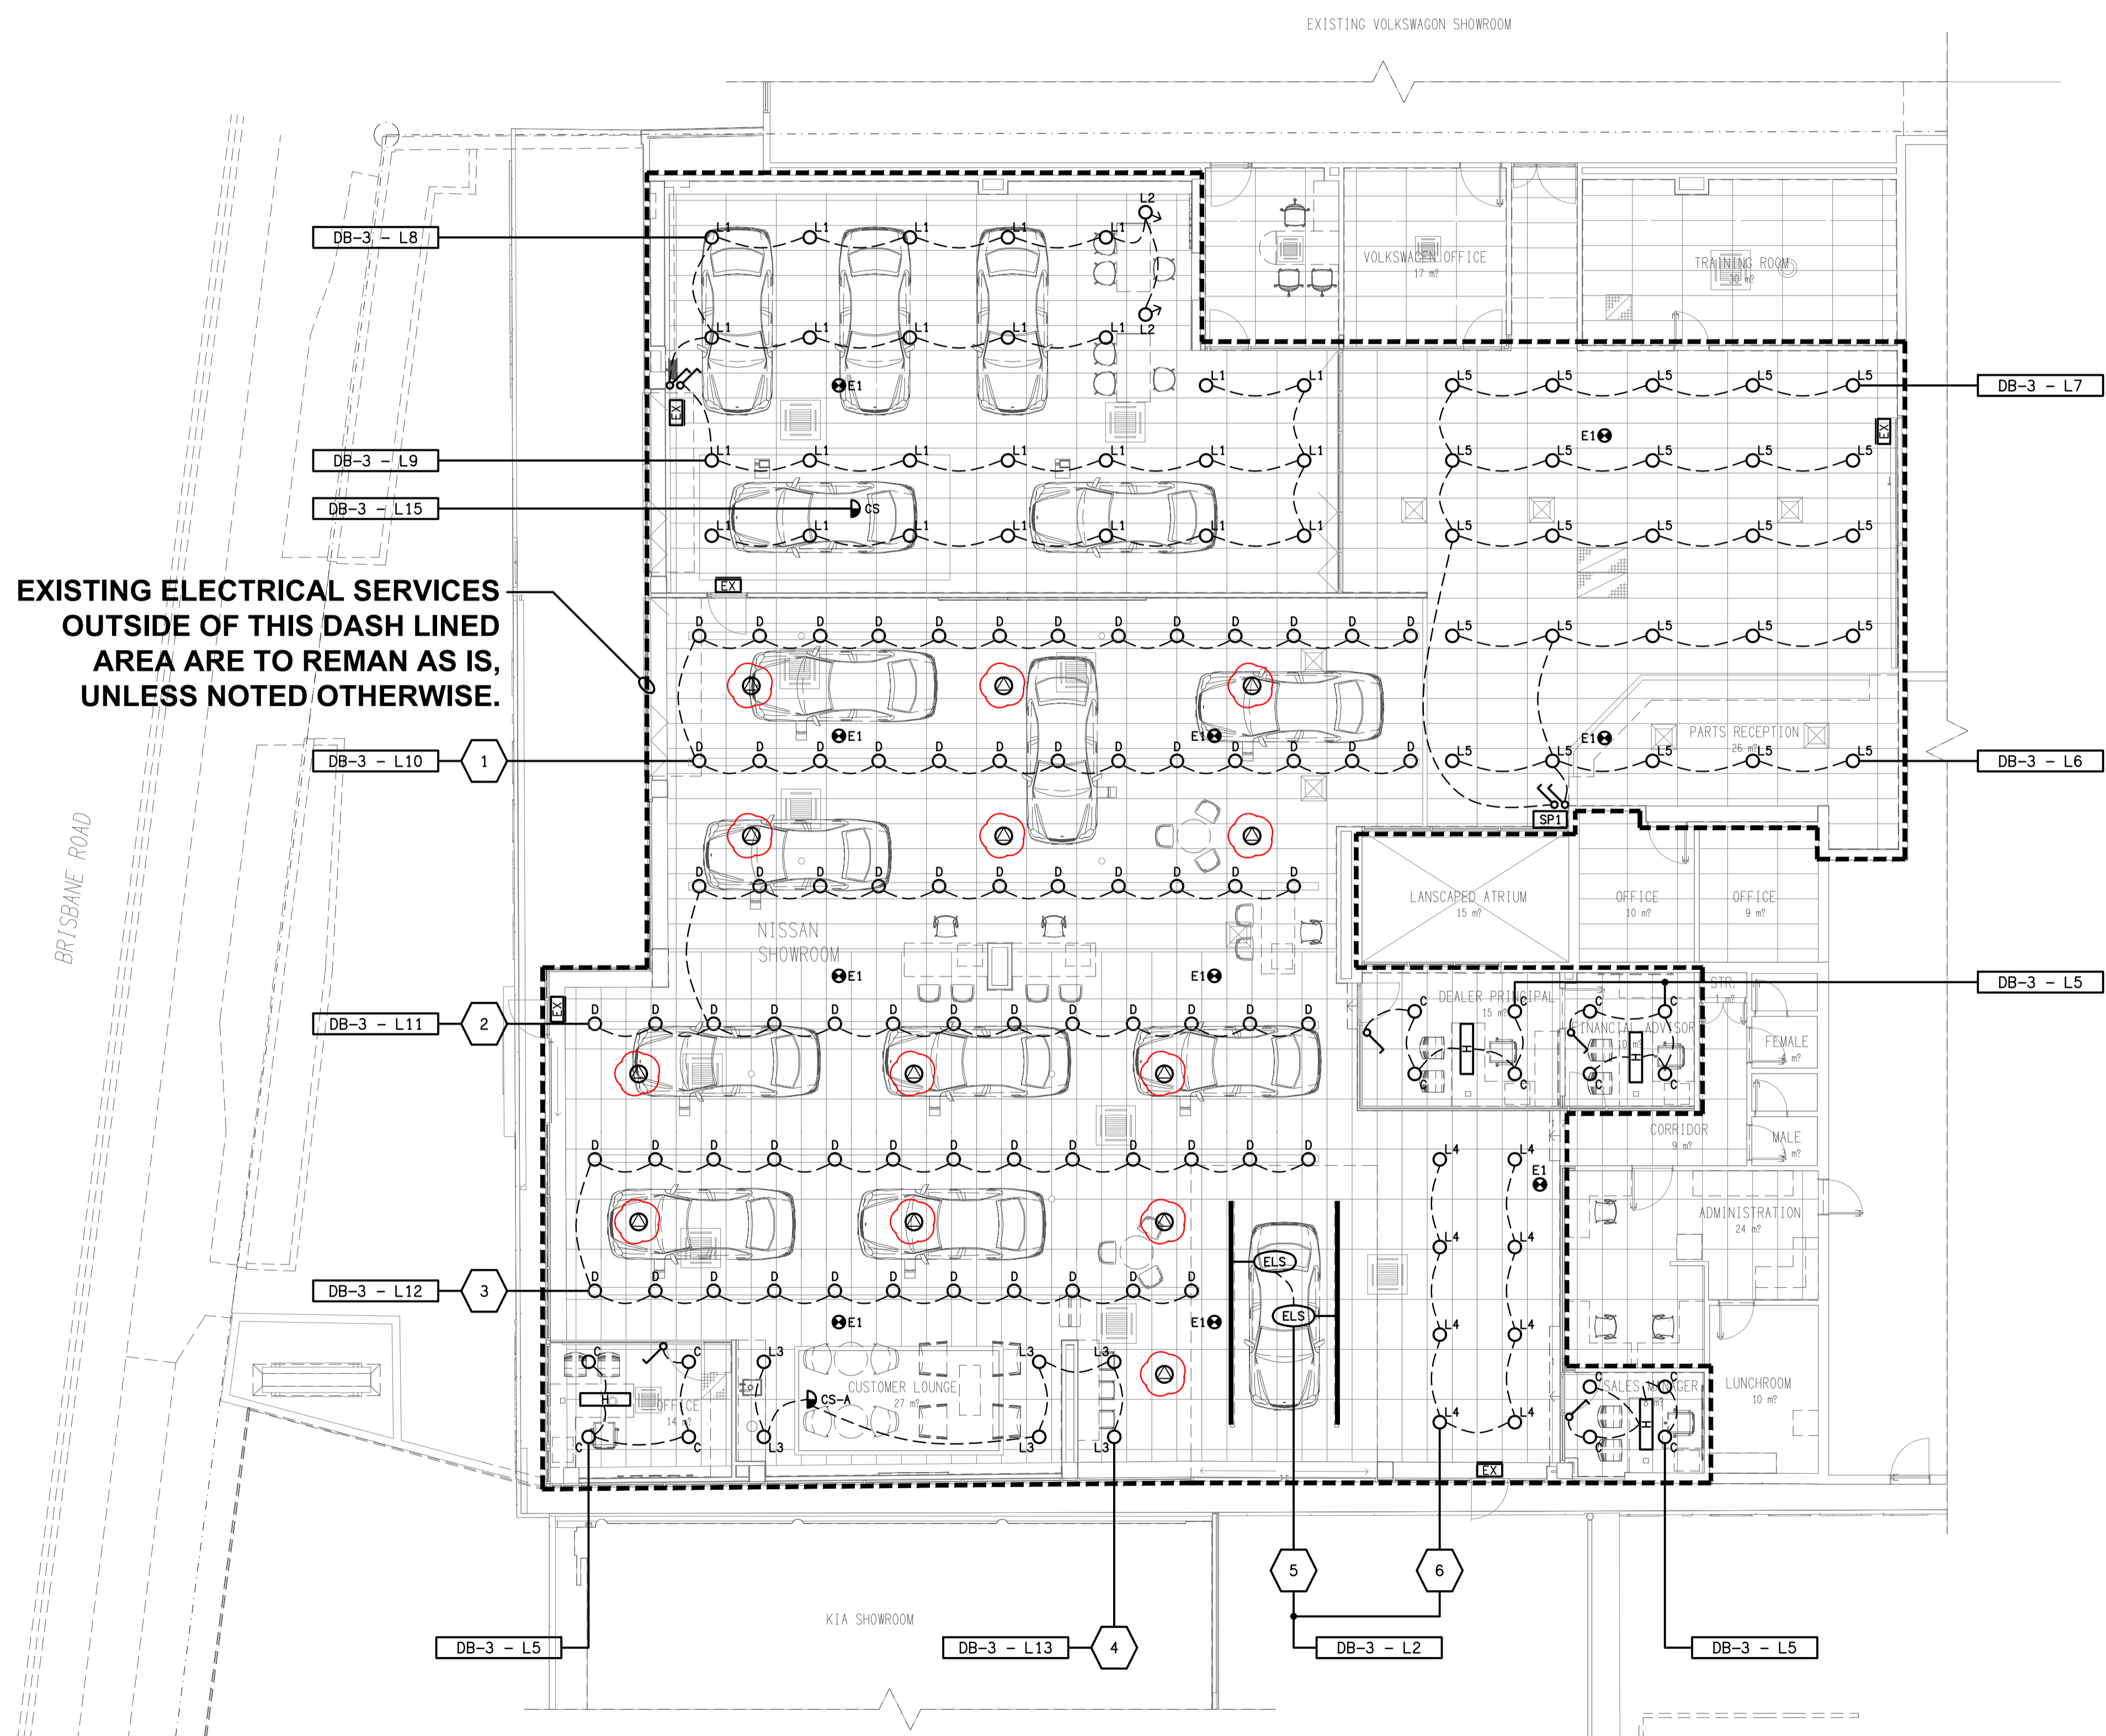

SCHEMATIC
SP1 LIGHTING CONTROL
NOT TO SCALE

ELECTRICAL DESIGN GROUP BRISBANE
PTY LTD
ACN 092 710 793
TRADING AS:
ELECTRICAL DESIGN GROUP

THE COPYRIGHT OF THIS DRAWING
REMAINS THE PROPERTY OF THE
ELECTRICAL DESIGN GROUP.
USE FIGURED DIMENSIONS
IN PREFERENCE TO SCALE.
ALL DIMENSIONS TO BE
VERIFIED ONSITE.

ELECTRICAL DESIGN GROUP
ELECTRICAL BUILDING SERVICES CONSULTANTS
BRISBANE GOLD COAST
P.O. Box 15, Sherwood Q.4075
Phone: (07) 3278 4375
Email: brisbane@edg.net.au
Web: www.edg.net.au

PROJECT:
NISSAN - IPSWICH
5 BRISBANE ROAD, BUNDAMBA, QUEENSLAND

C	TENDER	20/10/2023
REV:	DESCRIPTION:	DATE:
DRAWING: ELECTRICAL SERVICES REFLECTED CEILING PLAN		
SCALE: 1:100 UNO	AT A1	PROJECT NO: C3117a
		DRAWING NO: E04
		REVISION: C