


DETAIL A
STAFF ROOM KITCHENETTE ELEVATION
SCALE 1: 25

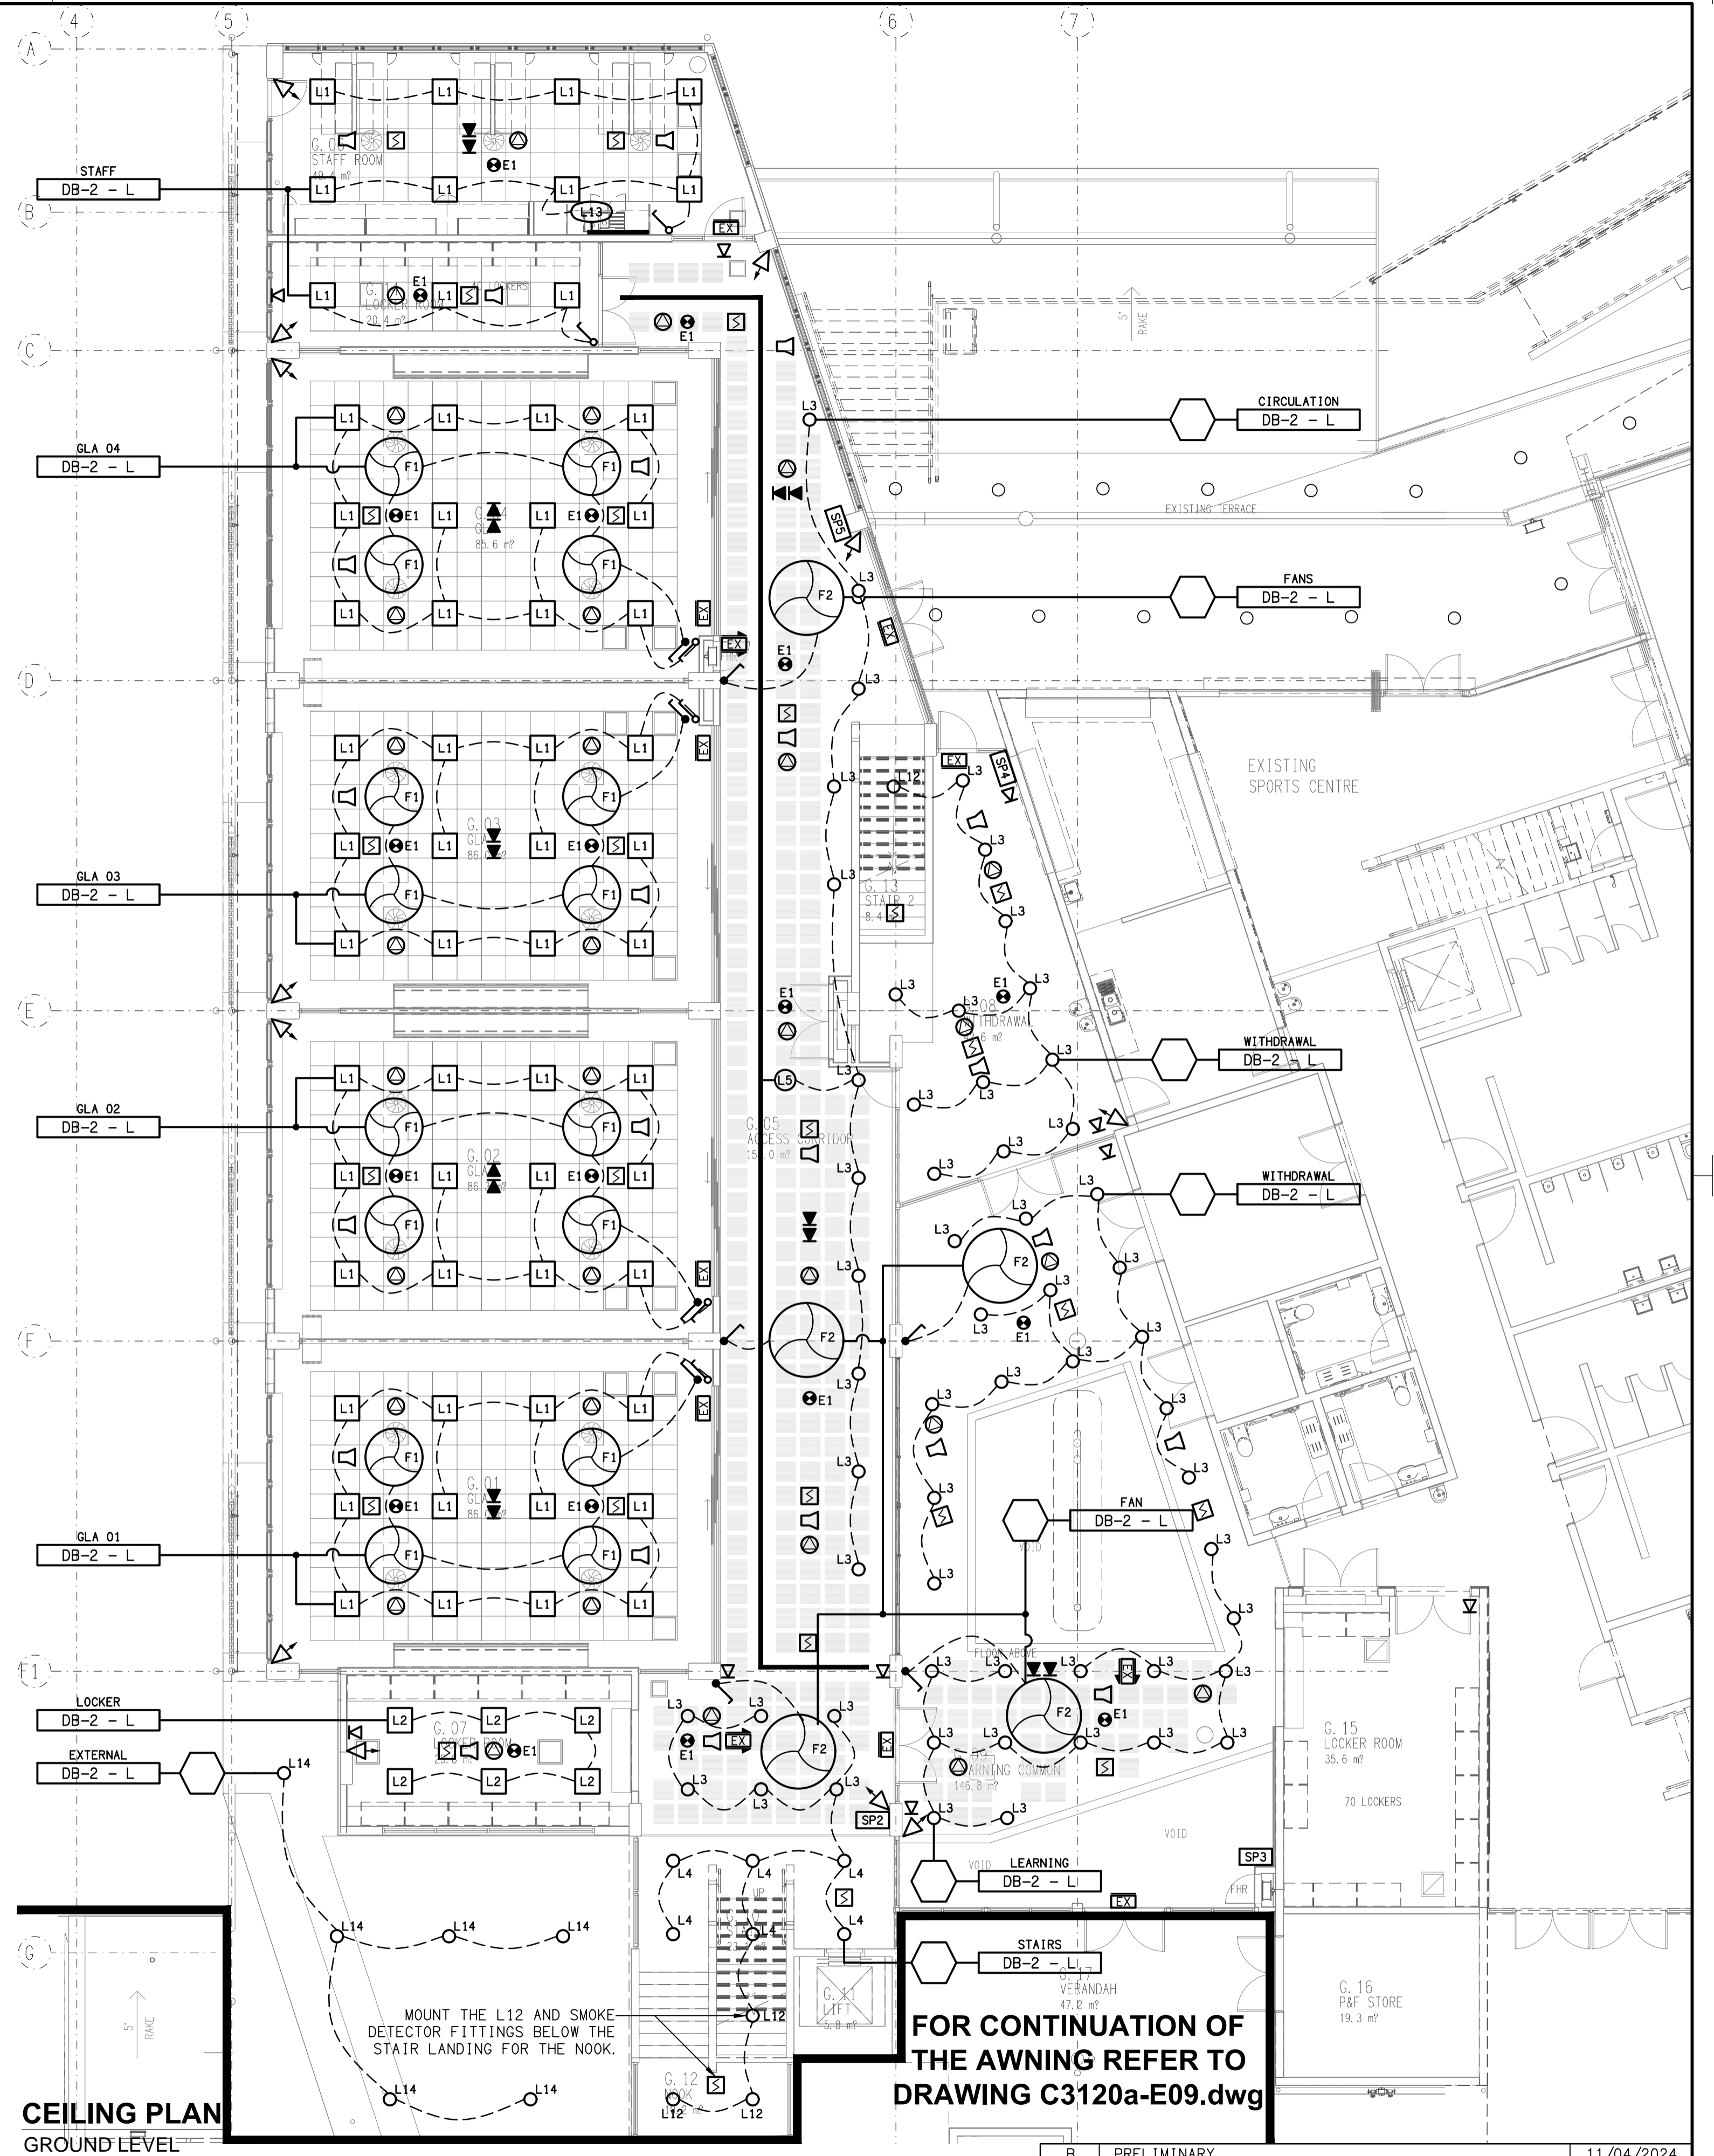

**FOR CONTINUATION OF
THE AWNING REFER TO
DRAWING C3120a-E09.dwg**

FLOOR PLAN
GROUND LEVEL
SCALE 1: 100

CEILING PLAN
GROUND LEVEL
SCALE 1: 100

ELECTRICAL DESIGN GROUP BRISBANE
PTY LTD
ACN 092 710 793
TRADING AS:
ELECTRICAL DESIGN GROUP

THE COPYRIGHT OF THIS DRAWING
REMAINS THE PROPERTY OF THE
ELECTRICAL DESIGN GROUP.
USE FIGURED DIMENSIONS
IN REFERENCE TO SCALE.
ALL DIMENSIONS TO BE
VERIFIED ONSITE.

ELECTRICAL DESIGN GROUP
ELECTRICAL BUILDING SERVICES CONSULTANTS
BRISBANE GOLD COAST
P.O. Box 15, Sherwood Q.4075
Phone: (07) 3278 4375
Email: brisbane@edg.net.au
Web: www.edg.net.au

PROJECT:
**ST JOHN'S ANGLICAN COLLEGE
FOREST LAKE
AQUATIC CENTRE STAGE 1
COLLEGE AVENUE, FOREST LAKE**

B	PRELIMINARY	11/04/2024
REV:	DESCRIPTION:	DATE:
DRAWING: ELECTRICAL SERVICES AQUATIC CENTRE GROUND LEVEL PLANS		
SCALE: 1:100	AT A1	PROJECT NO: C3120a
		DRAWING NO: E04
		REVISION: B