

NOTES:

- REFER TO DRAWING E01 FOR LEGEND AND GENERAL NOTES

NOTE

THIS DRAWING HAS BEEN COMPILED WITH INFORMATION FROM VARIOUS CONTRACT SOURCES AND SITE INSPECTIONS. NO GUARANTEE IS GIVEN FOR THE ACCURACY OF THIS INFORMATION. DETAILS MUST BE CONFIRMED ON SITE PRIOR TO WORK COMMENCING.

EXISTING UNDER GROUND ELECTRICAL POWER, COMMUNICATIONS, HYDRAULIC AND OTHER SERVICES ARE LOCATED THROUGH OUT THE SITE. SURVEY AND CHECK THE EXTENT OF SERVICES WITHIN WORK ZONES PRIOR TO EXCAVATION CORING OR PENETRATIONS OF ANY KIND.

NETWORK EXISTS IN THE AREA, IF YOUR ACTIVITIES ARE WITH IN SERVICE PROVIDER ENCROACHMENT DISTANCES (SEE DUTY OF CARE) THE CONTRACTOR IS TO CONTACT THE SERVICE PROVIDER AT LEAST 2 DAYS BEFORE STARTING ANY ACTIVITY.


FOR ALL WORK WITHIN 2.5m OF ANY FIBRE OPTIC CABLES, THE CONTRACTOR IS REQUIRED TO HAND DIG (POTHOLE) AND EXPOSE ALL CABLES/CORDS. BEFORE WORK CAN COMMENCE THE CONTRACTOR IS TO OBTAIN THE ONSITE LOCATION FROM AN ACCREDITED PLANT LOCATOR.



THE COPYRIGHT OF THIS DRAWING REMAINS THE PROPERTY OF THE ELECTRICAL DESIGN GROUP.

USE FIGURED DIMENSIONS IN PREFERENCE TO SCALE.

ALL DIMENSIONS TO BE VERIFIED ONSITE.

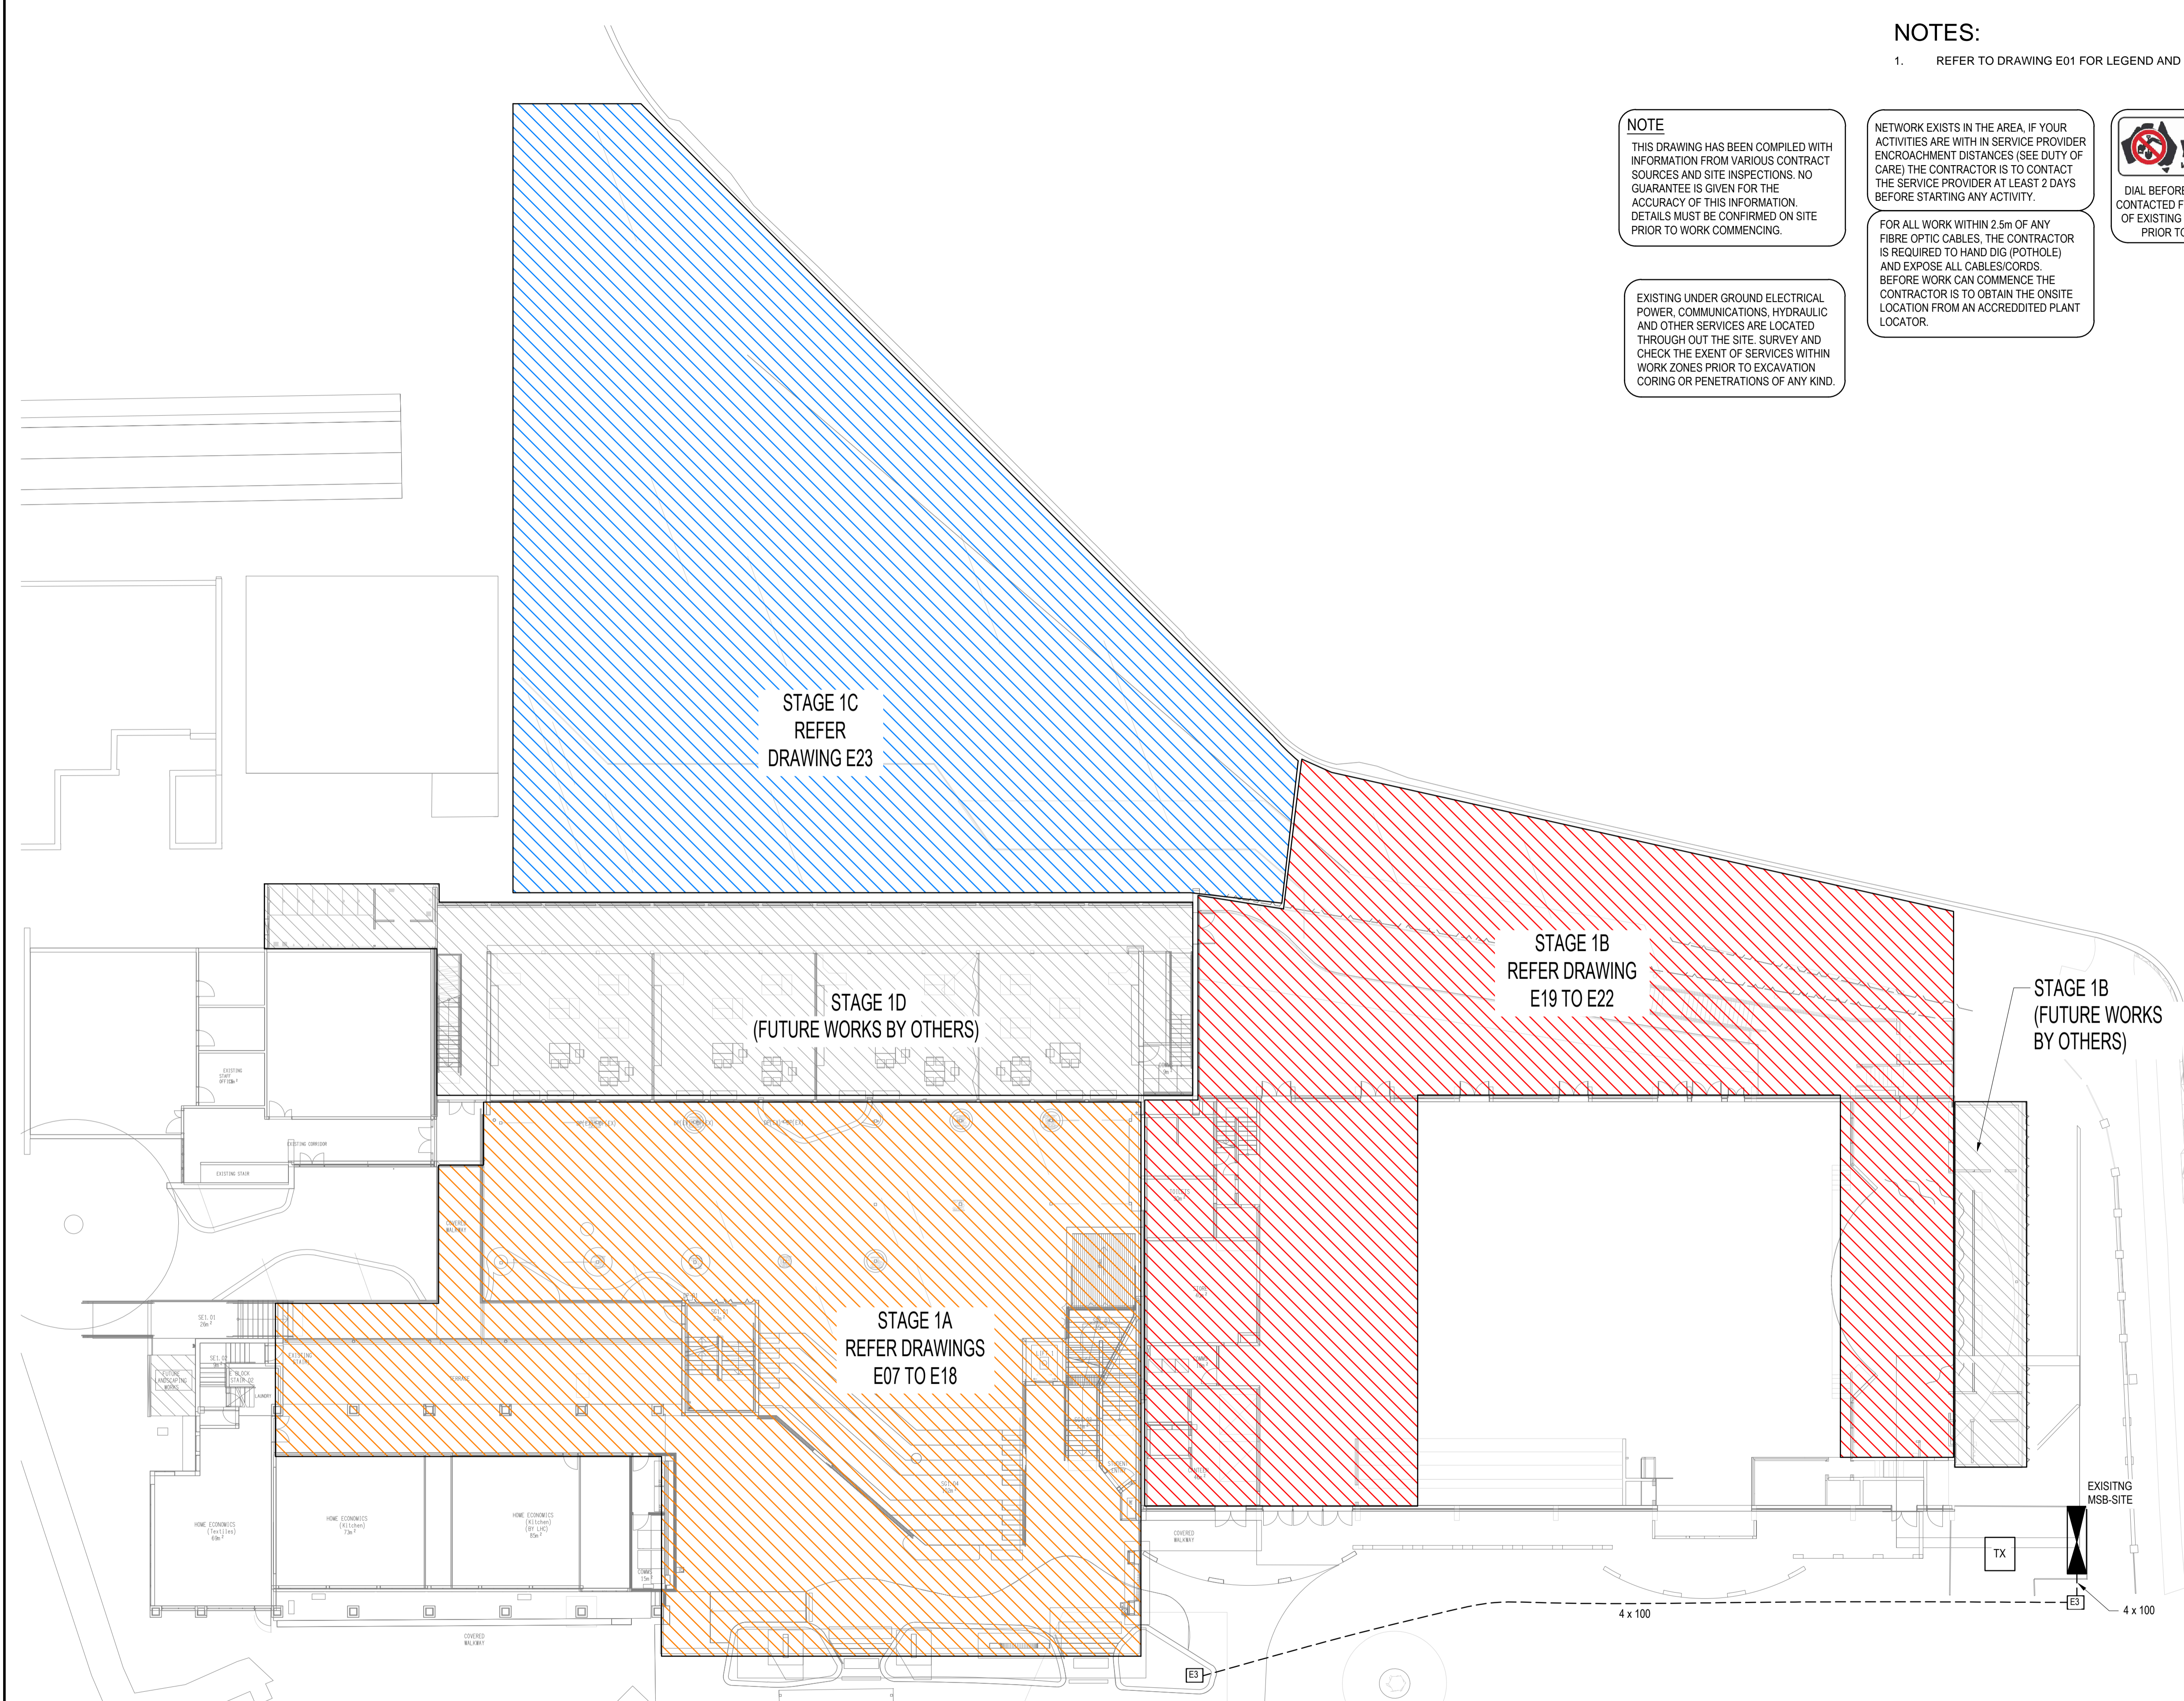

B	INFORMATION	30/11/2023
REV:	DESCRIPTION:	DATE:

ELECTRICAL DESIGN GROUP
ELECTRICAL BUILDING SERVICES CONSULTANTS

BRISBANE: P.O. Box 15 Sherwood Qld 4075
Phone: (07) 3278 4375
Email: brisbane@edg.net.au
Web: www.edg.net.au

ELECTRICAL DESIGN GROUP BRISBANE / TRADING AS:
PTY LTD ACN 092 710 793 / ELECTRICAL DESIGN GROUP

PROJECT:
**LOURDES HILL COLLEGE
STAGE 1**

SITE ADDRESS:
**86 HAWTHORNE ROAD,
HAWTHORNE, QUEENSLAND**

SCALE: 1:200 SHEET SIZE: AT A1

DRAWING TITLE:
**ELECTRICAL SERVICES
SITE PLAN**

PROJECT NO. DRAWING NO. REVISION:
C3134a E06 B