


DETAIL
TYPICAL L2 SECTION VIEW
NOT TO SCALE

NOTES:

- REFER TO DRAWING E01 FOR LEGEND AND GENERAL NOTES.

THE COPYRIGHT OF THIS DRAWING REMAINS THE PROPERTY OF THE ELECTRICAL DESIGN GROUP.
USE FIGURED DIMENSIONS IN PREFERENCE TO SCALE.
ALL DIMENSIONS TO BE VERIFIED ONSITE.

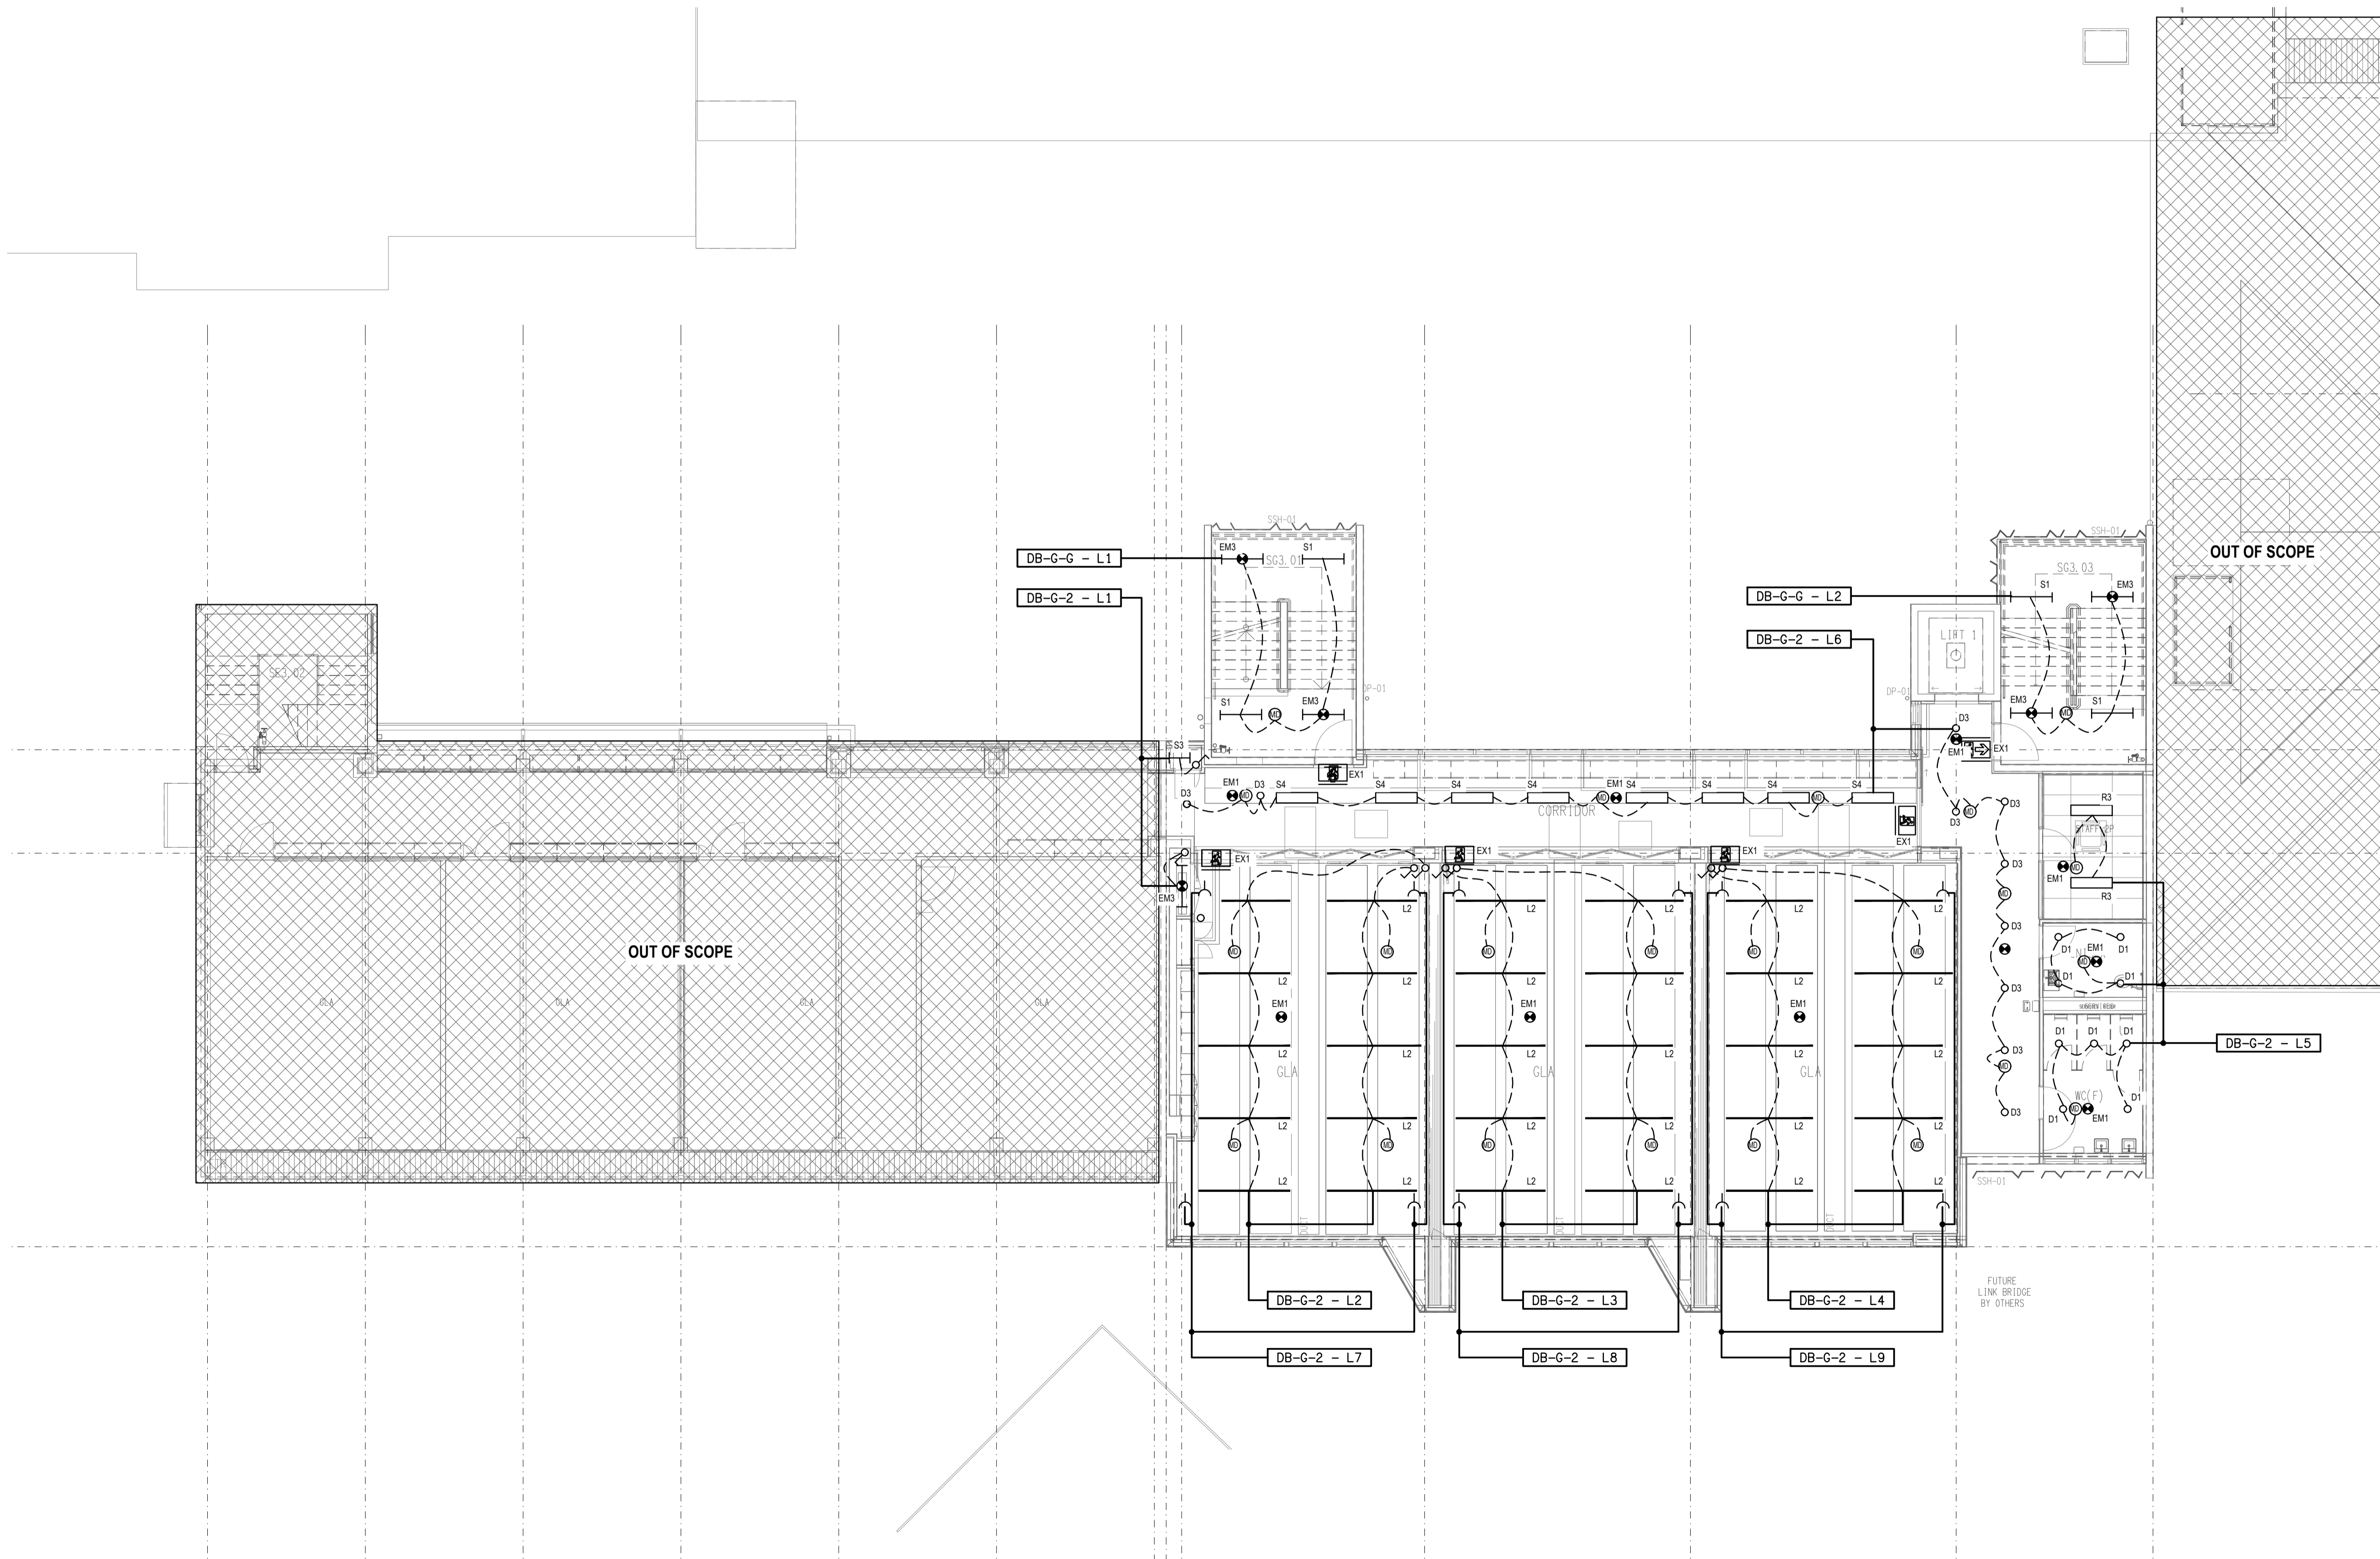

C	INFORMATION	11/12/2023
REV:	DESCRIPTION:	DATE:

ELECTRICAL DESIGN GROUP
ELECTRICAL BUILDING SERVICES CONSULTANTS

BRISBANE: P.O. Box 15 Sherwood Qld 4075
Phone: (07) 3278 4375
Email: brisbane@edg.net.au
Web: www.edg.net.au

ELECTRICAL DESIGN GROUP BRISBANE PTY LTD
ACN 092 710 793

TRADING AS:
ELECTRICAL DESIGN GROUP

PROJECT:
**LOURDES HILL COLLEGE
STAGE 1**

SITE ADDRESS:
86 HAWTHORNE ROAD,
HAWTHORNE, QUEENSLAND

SCALE: 1:100 AT A1 SHEET SIZE:

DRAWING TITLE:
**ELECTRICAL SERVICES
STAGE 1A LEVEL 2
REFLECTED CEILING PLAN**

PROJECT NO. DRAWING NO. REVISION:

C3134a E10 C